
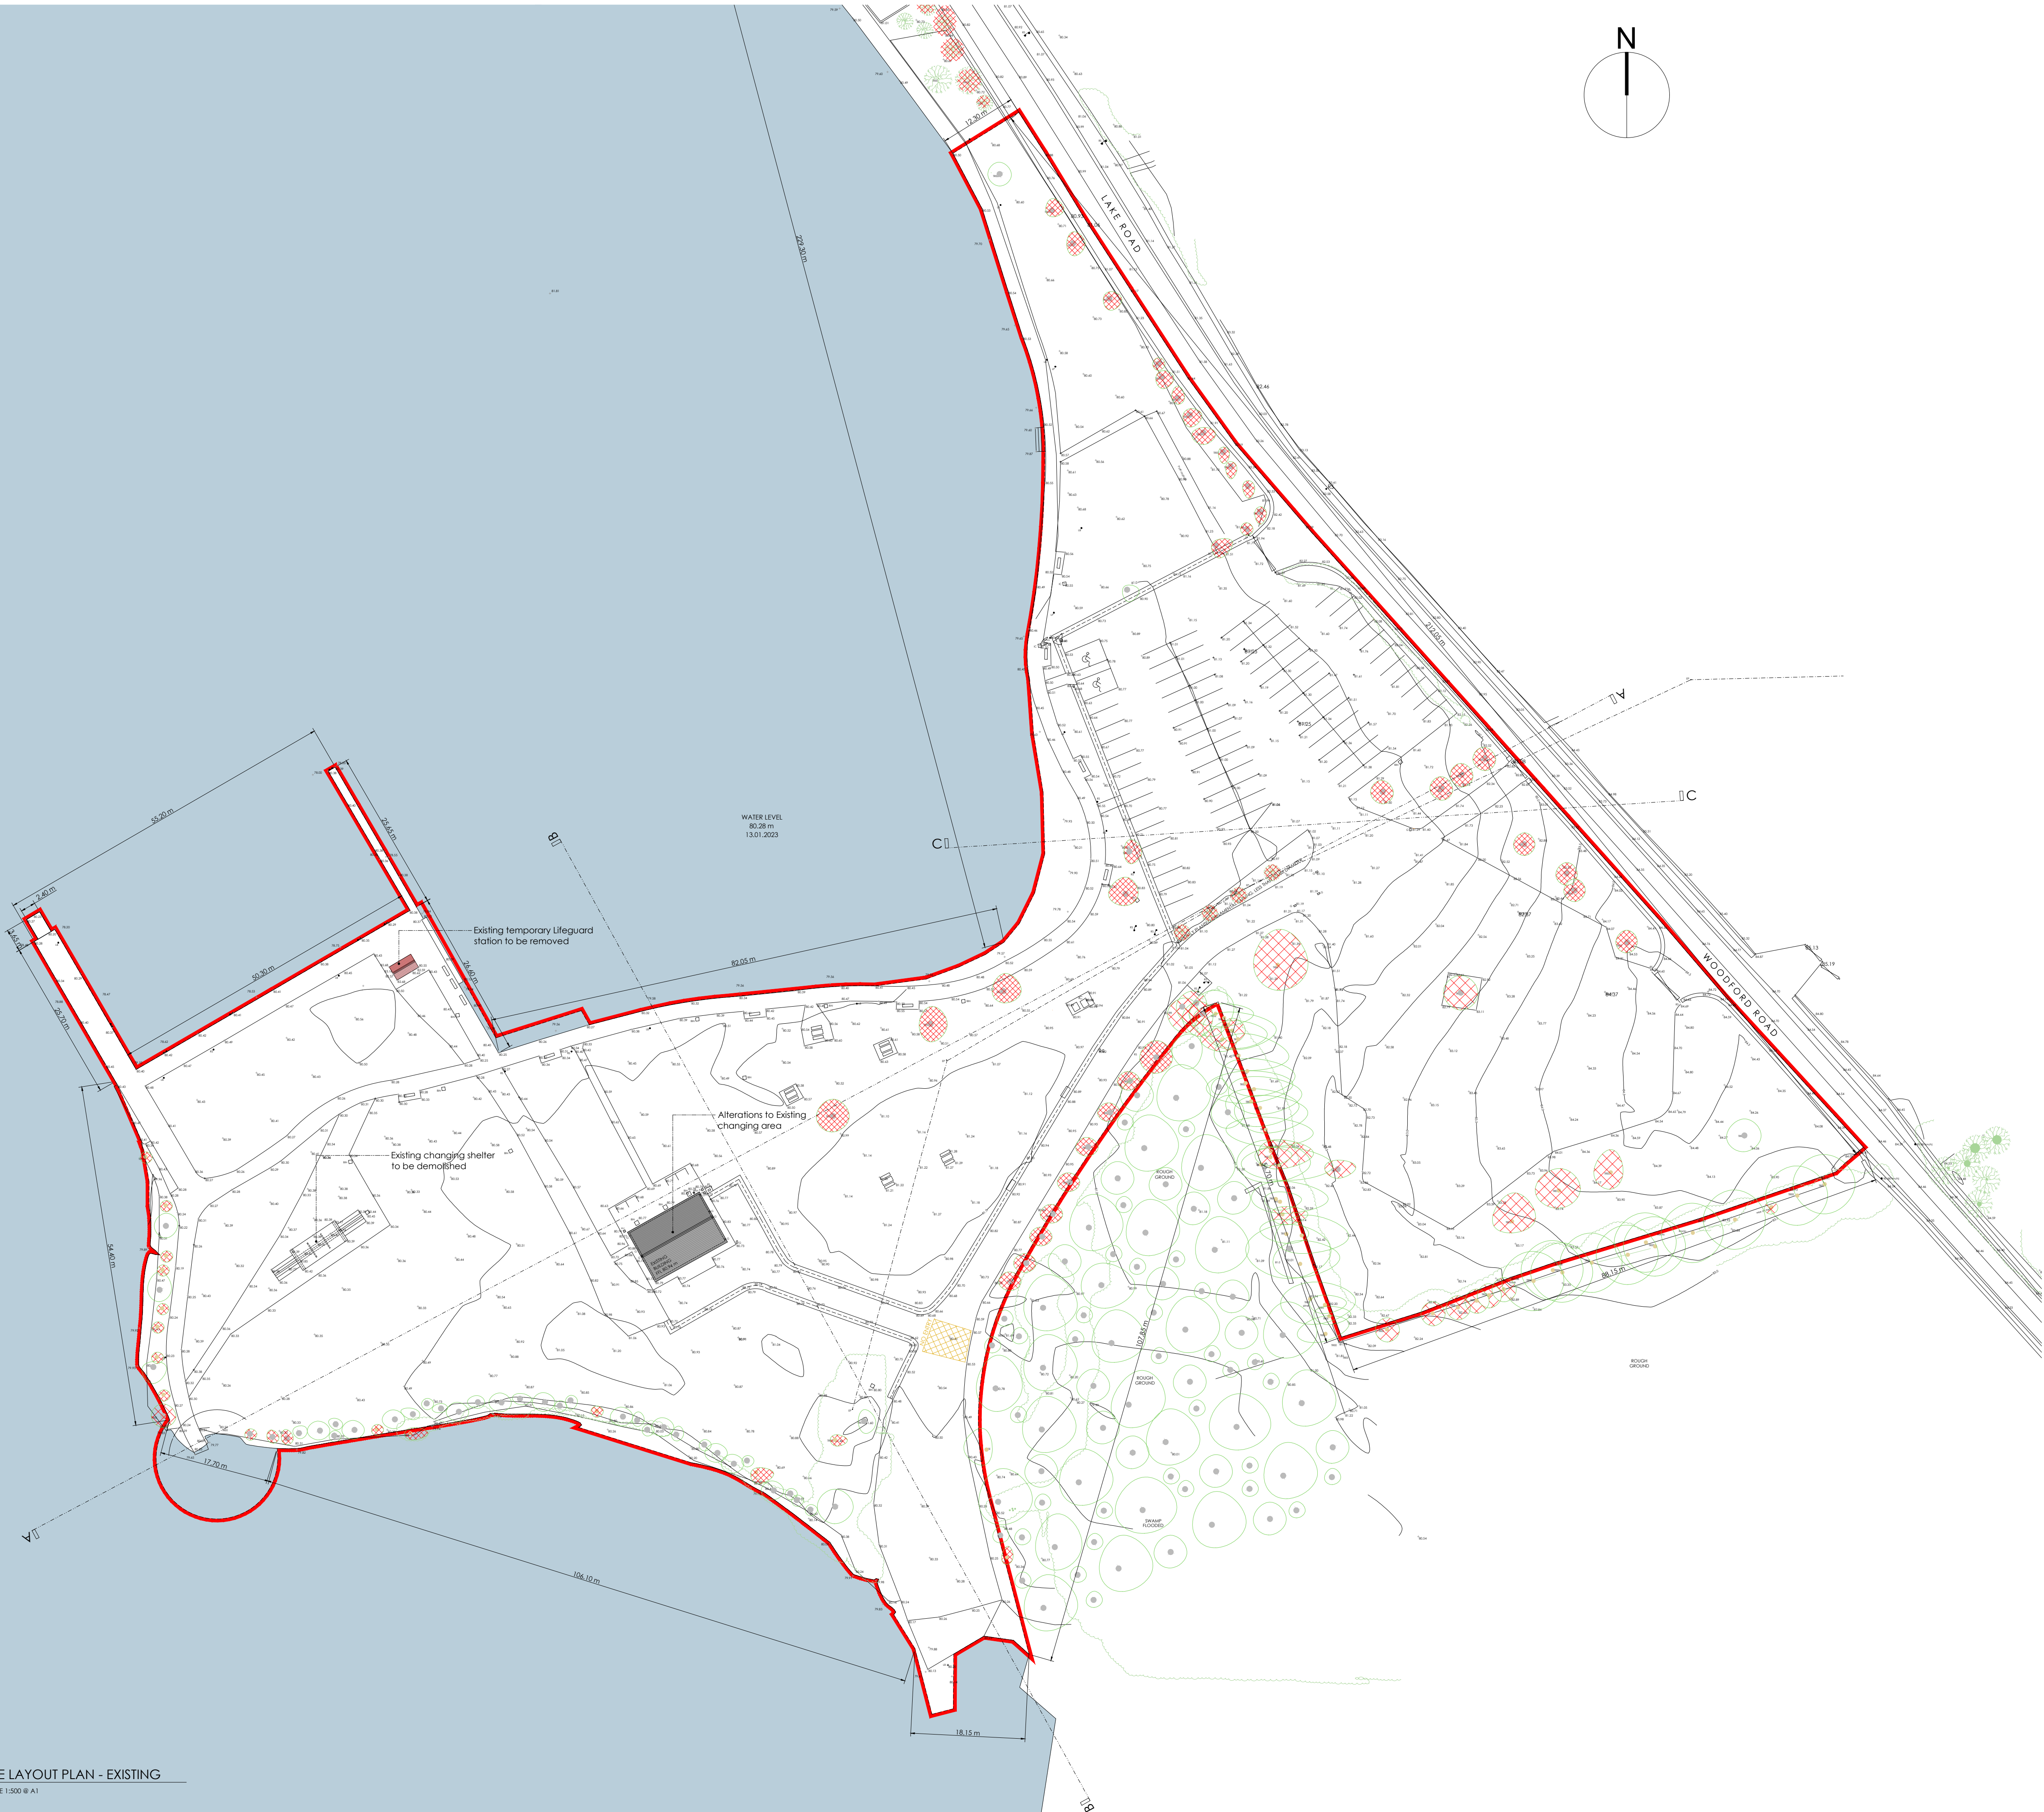


DRAWING REGISTER AND ISSUE SHEET

[illegible]

DRAWING REGISTER AND ISSUE SHEET

--	--	--	--	--	--	--	--	--	--	--	--	--	--	--	--	--	--	--	--	--

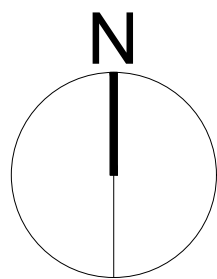


- EXISTING TREES
- PROPOSED TREE REMOVALS - REFER TO ARBORICULTURIST'S REPORT

DRAWING NOTES				
EXTENT OF SITE OUTLINED IN RED				
SITE AREA: 2.26 HA				
THIS DRAWING IS COPYRIGHT AND IS FOR PLANNING PURPOSES ONLY AND IS NOT TO BE USED FOR CONSTRUCTION PURPOSES.				
USE FIGURED DIMENSIONS ONLY. DO NOT SCALE FROM DRAWINGS.				
THIS DRAWING SHOULD BE ONLY RELIED UPON FOR THE SPECIFIC PURPOSE THAT IT WAS PREPARED AND SHOULD NOT BE RELIED UP ON FOR CONSTRUCTION PURPOSES. NO IMPLIED OR EXPRESSED WARRANTY IS GIVEN AS TO THE SUITABILITY FOR CONSTRUCTION PURPOSES. HELENA MCELMEEL ARCHITECTS SHALL NOT BE LIABLE FOR ANY LOSS OR DAMAGE OR INJURY CONSEQUENTIAL OR OTHERWISE HOWSOEVER ARISING FOR FAILURE TO COMPLY WITH THE ABOVE.				
Rev	Date	Description	Drawn By	Checked By
1	15.07.2025	FURTHER INFORMATION REPONSE	HME	HME
0	26.09.2024	ISSUED FOR PLANNING		


PROJECT	LONG POINT OUTDOOR AMENITY ENHANCEMENT PROJECT			DWG. NO.	
CLIENT	GALWAY COUNTY COUNCIL				P(01)02
DRAWING TITLE	EXISTING SITE LAYOUT PLAN			REV.	1
99014	JULY 2024	1:500 @ A1	BS		R
PROJECT NO.	DATE	SCALE	DRAWN BY	CHECKED BY	RELEASED

HELENA MCELMEEL
ARCHITECTS


T. +353 91 539023 | E. INFO@MCELMEEL.IE | DOCKGATE HOUSE, MERCHANT'S ROAD, GALWAY

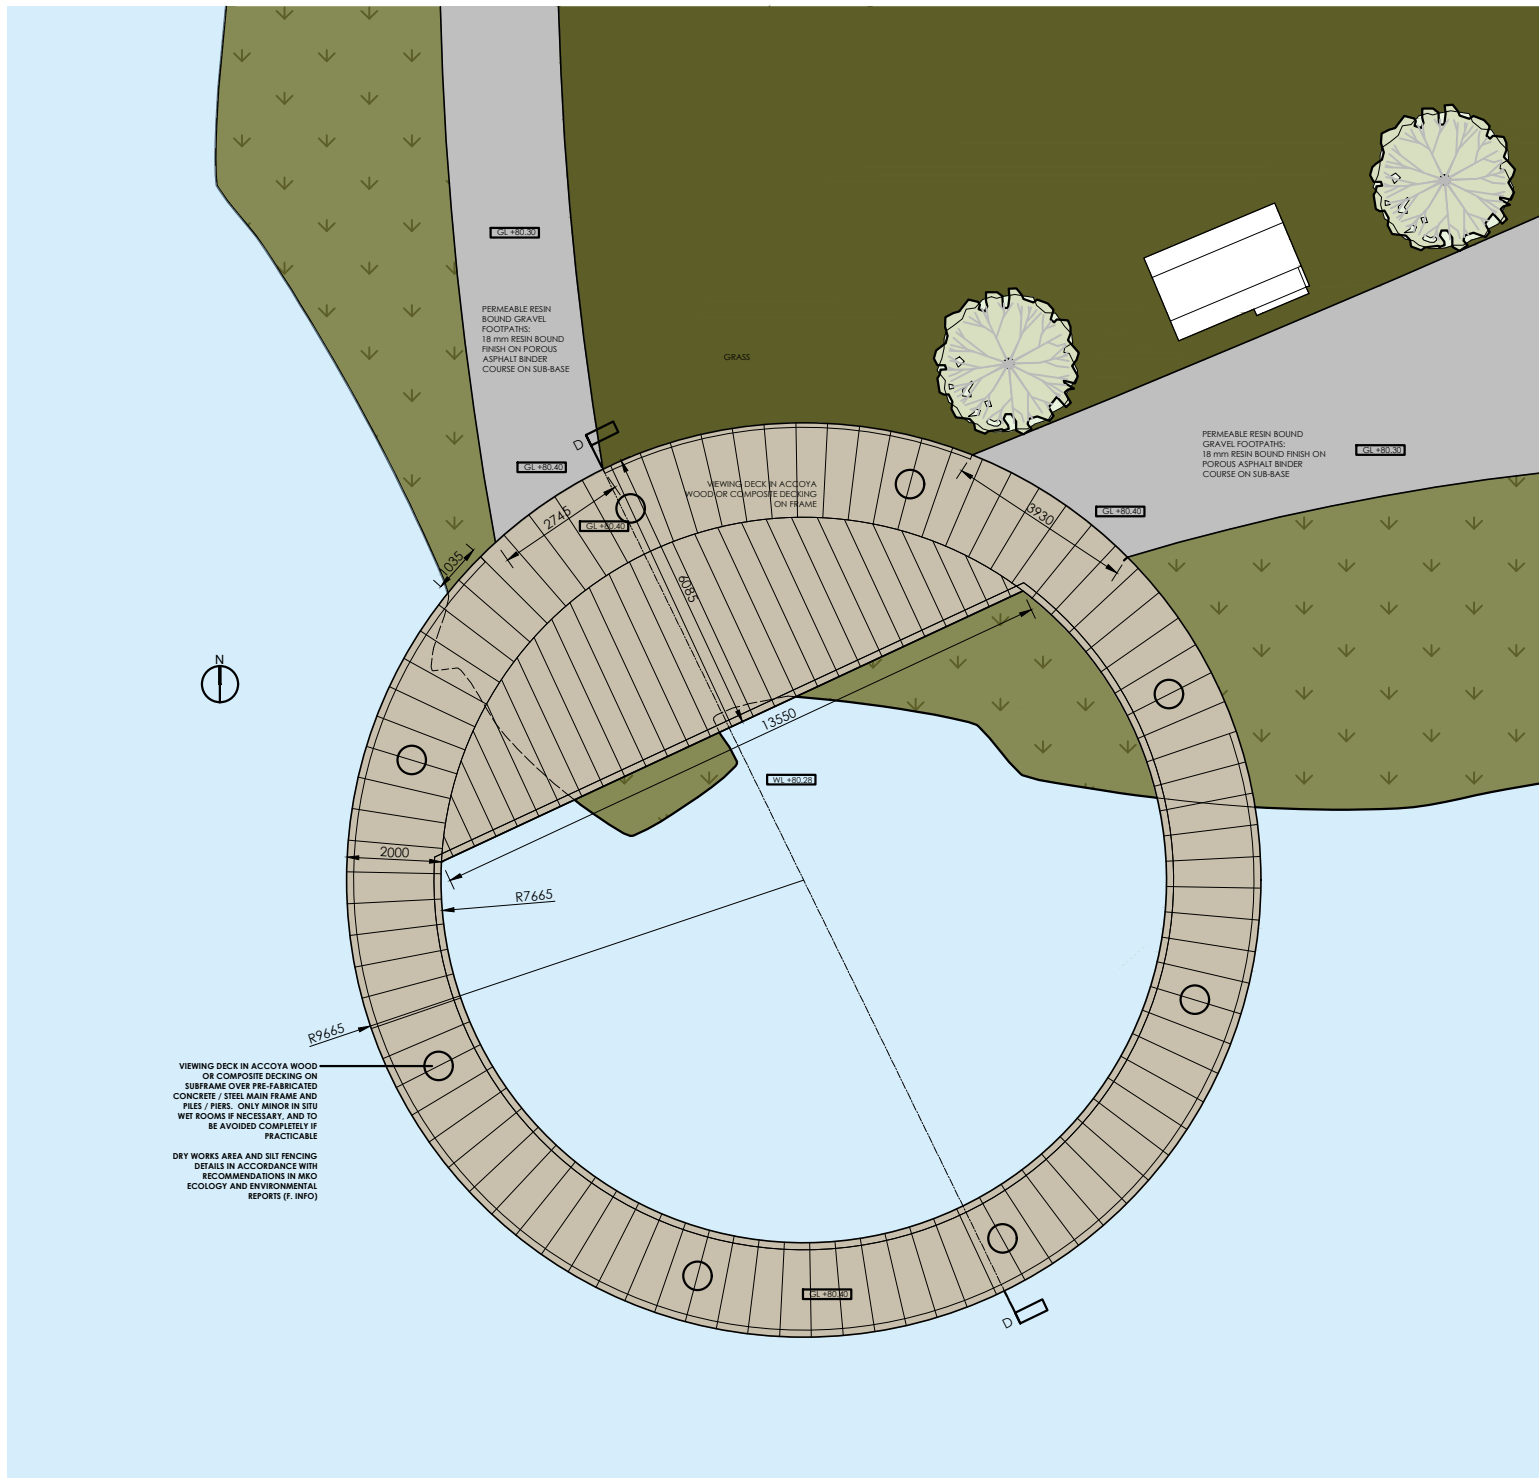


CRANNÓG VIEWPOINT - PROPOSED PLAN
SCALE 1:100 @ A1

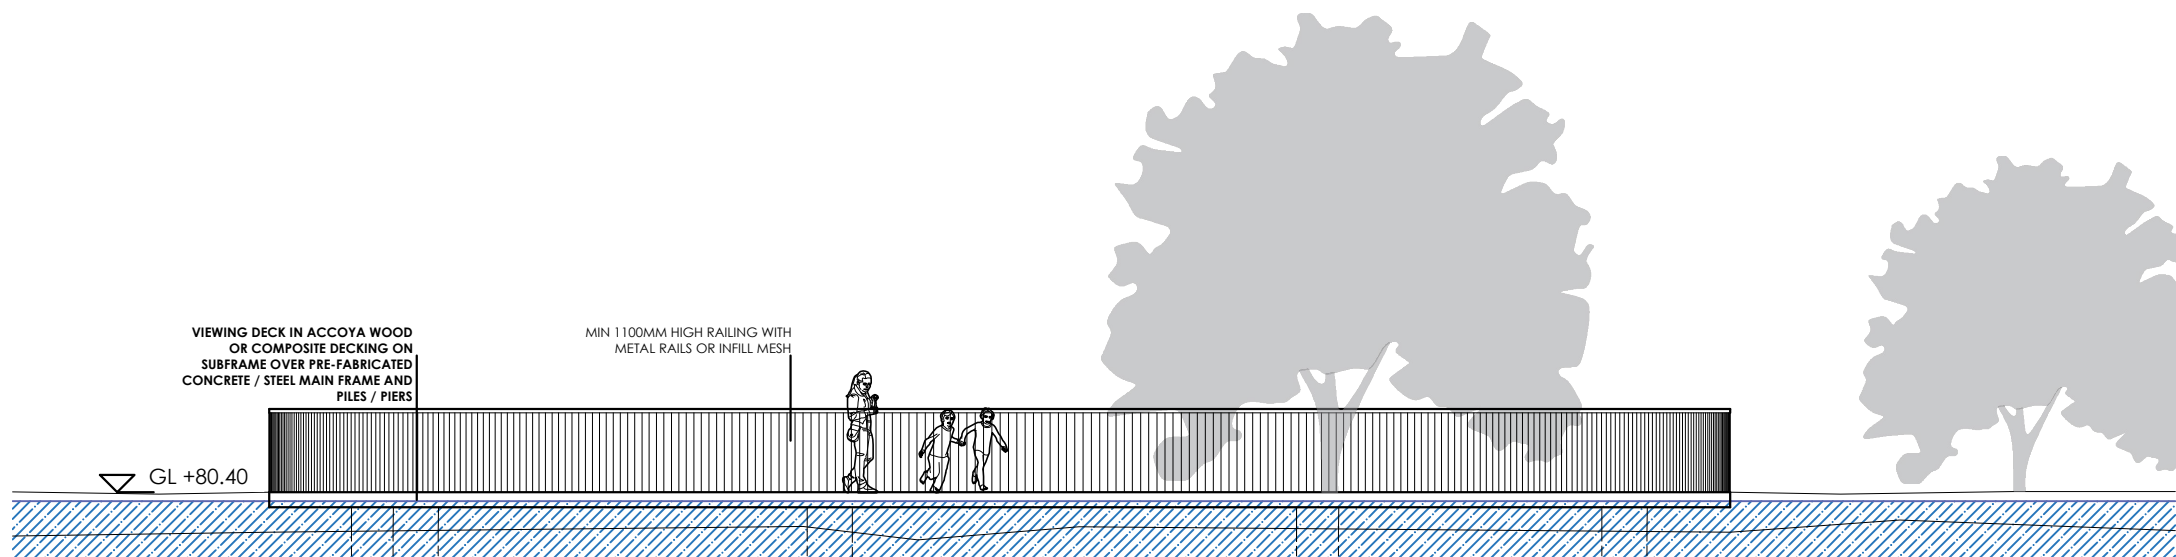


CRANNÓG VIEWPOINT - PROPOSED SOUTH ELEVATION
SCALE 1:100 @ A1

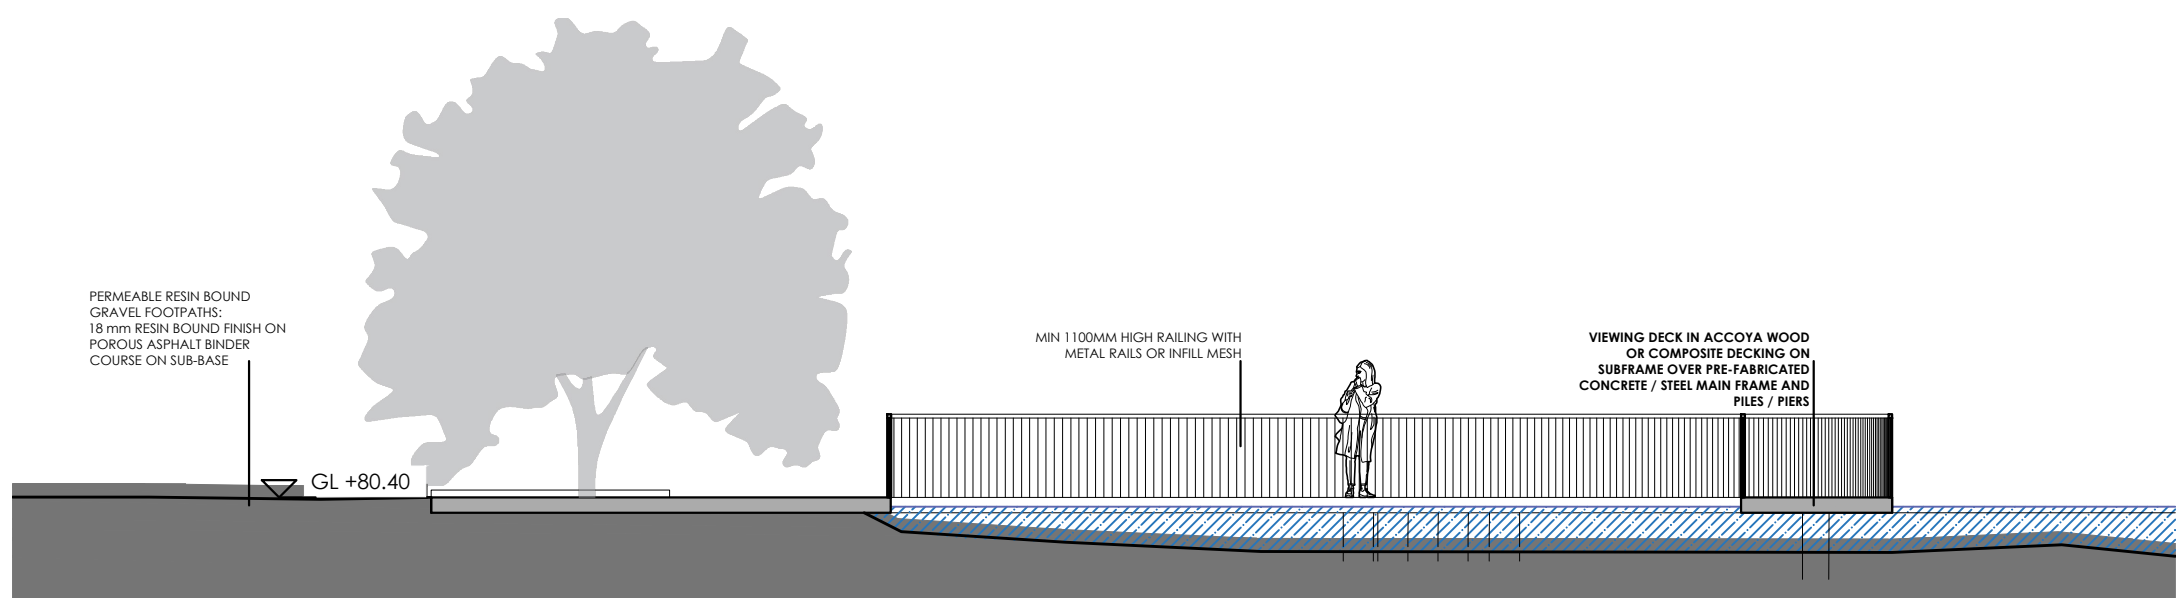


CRANNÓG VIEWPOINT - PROPOSED SECTION D-D
SCALE 1:100 @ A1

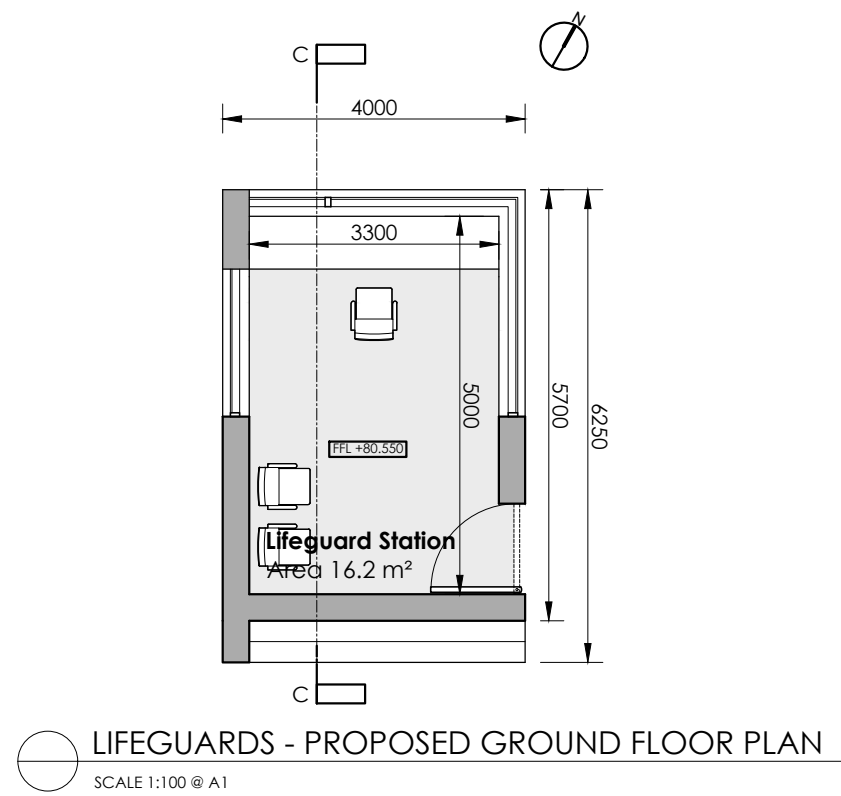


LIFEGUARDS - PROPOSED GROUND FLOOR PLAN
SCALE 1:100 @ A1

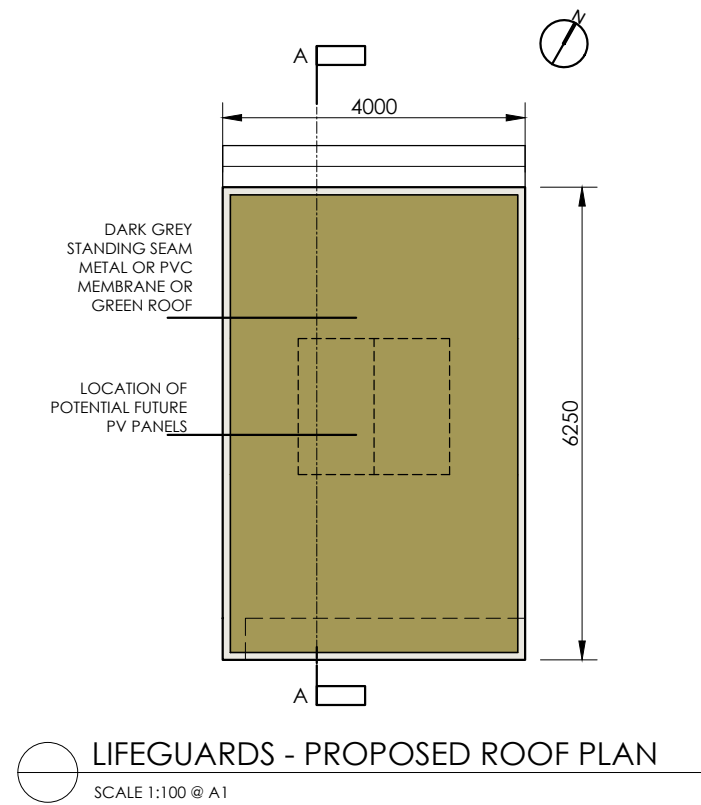


LIFEGUARDS - PROPOSED ROOF PLAN
SCALE 1:100 @ A1

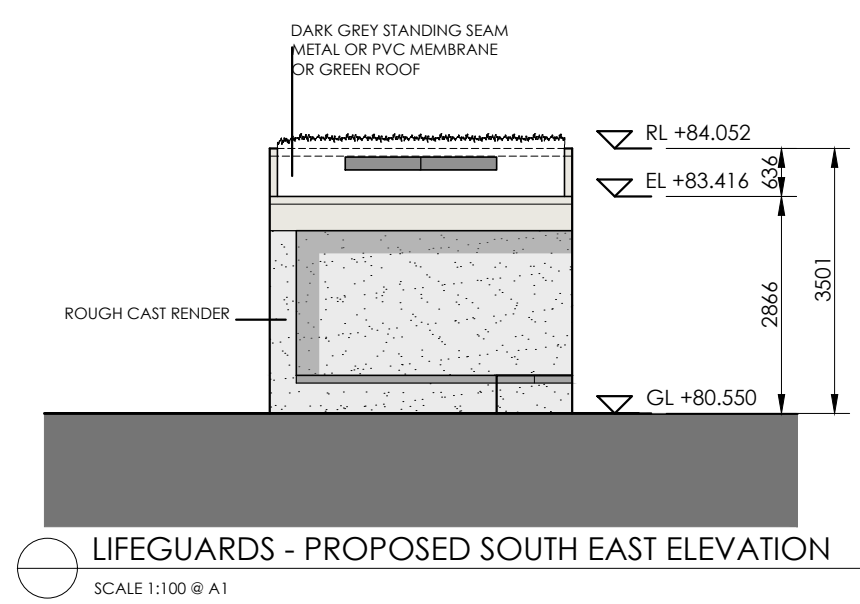


LIFEGUARDS - PROPOSED SOUTH EAST ELEVATION
SCALE 1:100 @ A1

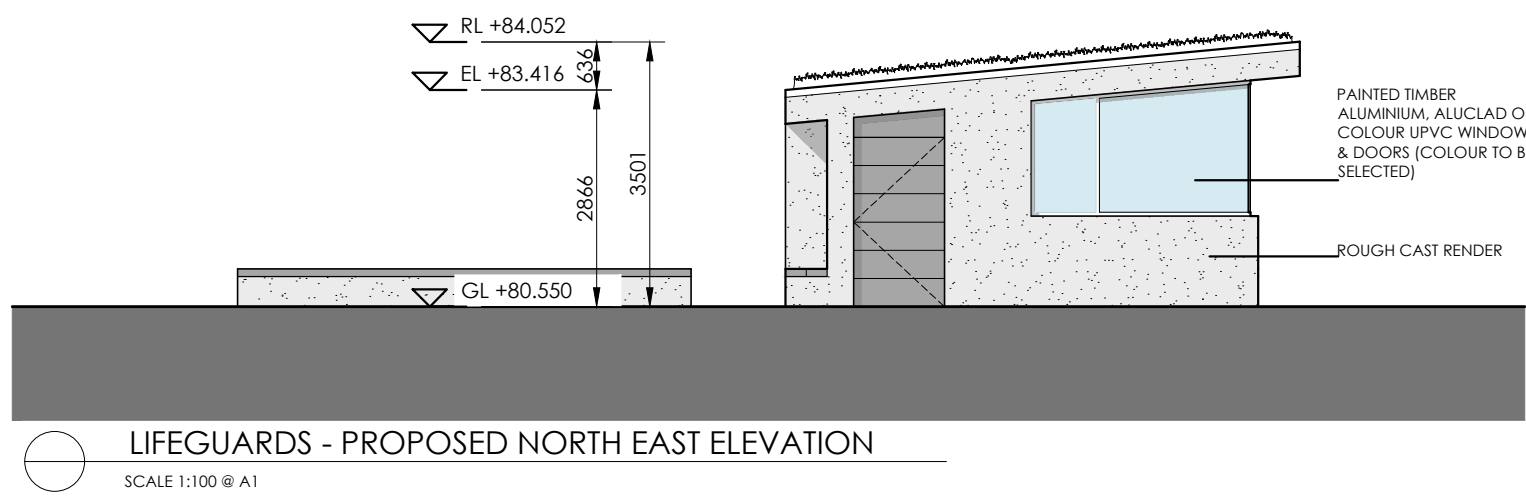


LIFEGUARDS - PROPOSED NORTH EAST ELEVATION
SCALE 1:100 @ A1

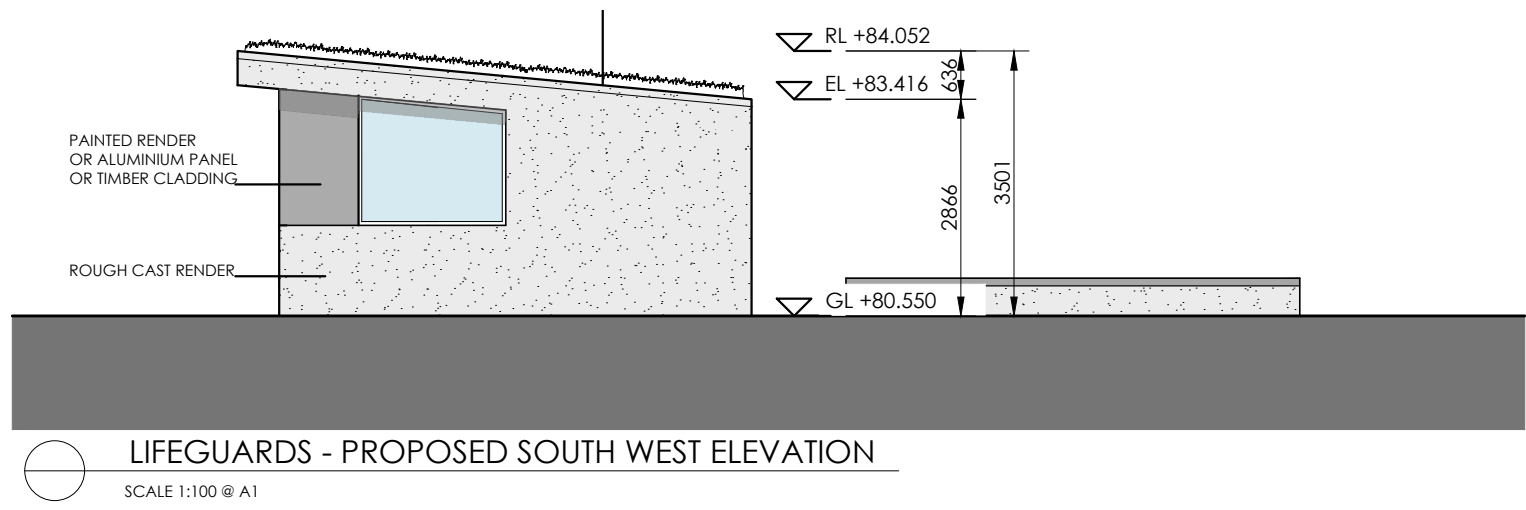


LIFEGUARDS - PROPOSED SOUTH WEST ELEVATION
SCALE 1:100 @ A1

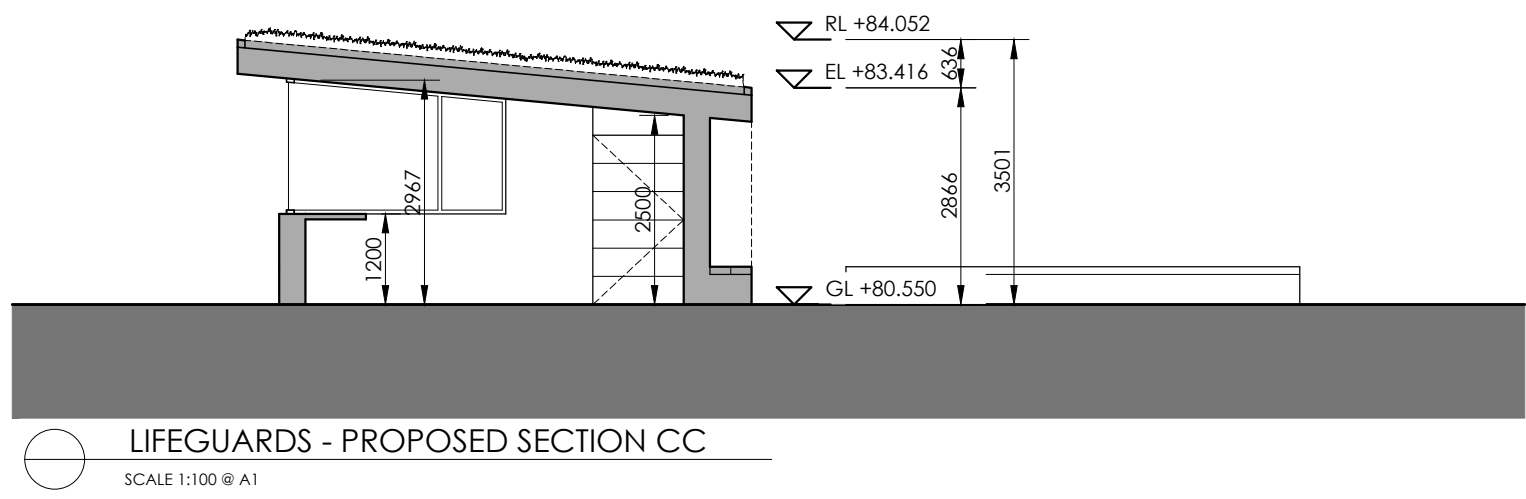


LIFEGUARDS - PROPOSED SECTION CC
SCALE 1:100 @ A1

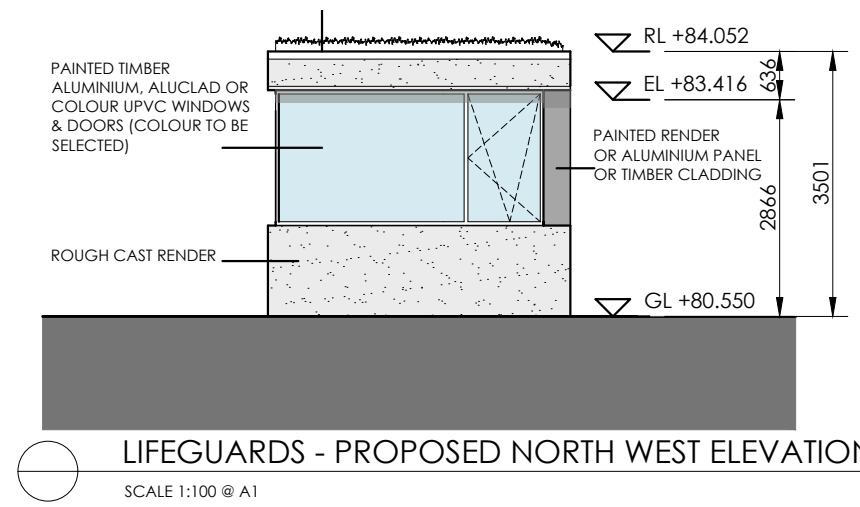

LIFEGUARDS - PROPOSED NORTH WEST ELEVATION
SCALE 1:100 @ A1

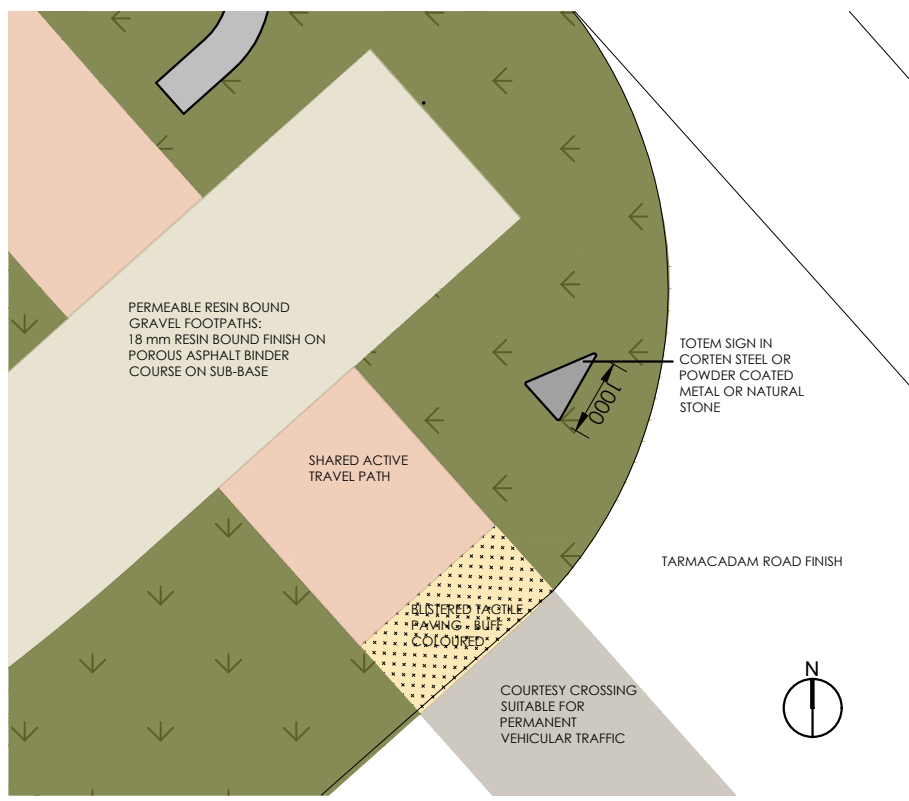

TOTEM SIGN - PROPOSED PLAN
SCALE 1:100 @ A1

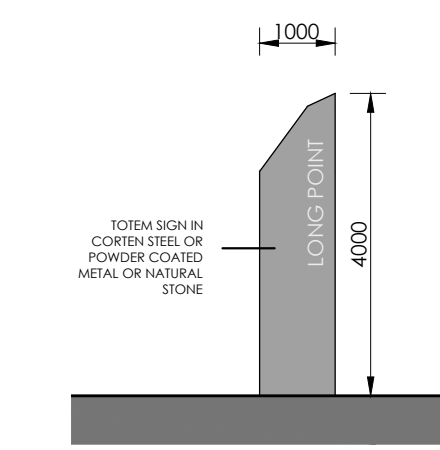

TOTEM SIGN - PROPOSED ELEVATION
SCALE 1:100 @ A1

DRAWING NOTES

AREA OF PROPOSED LIFEGUARD STATION: 16.2 SQ.M

THIS DRAWING IS COPYRIGHT AND IS FOR PLANNING PURPOSES ONLY AND IS NOT TO BE USED FOR CONSTRUCTION PURPOSES. USE FIGURED DIMENSIONS ONLY. DO NOT SCALE FROM DRAWINGS.

THIS DRAWING SHOULD BE ONLY RELIED UPON FOR THE SPECIFIC PURPOSE THAT IT WAS PREPARED AND SHOULD NOT BE RELIED UP ON FOR CONSTRUCTION PURPOSES. NO IMPLIED OR EXPRESSED WARRANTY IS GIVEN AS TO THE SUITABILITY FOR CONSTRUCTION PURPOSES. HELENA MCELMEEL ARCHITECTS SHALL NOT BE LIABLE FOR ANY LOSS OR DAMAGE OR INJURY CONSEQUENTIAL OR OTHERWISE HOWSOEVER ARISING FOR FAILURE TO COMPLY WITH THE ABOVE.

REFER TO CIVIL ENGINEERS DRAWINGS AND SW REPORT FOR DETAILS OF PROPOSED DRAINAGE AND SEWAGE DETAILS.

REFER TO SOFT LANDSCAPING DESIGN REPORT FOR DETAILS OF SOFT LANDSCAPING PROPOSALS.

REFER TO SITE LIGHTING LAYOUT AND LIGHTING OVERVIEW FOR DETAILS OF PROPOSED EXTERNAL LIGHTING.

Rev	Date	Description	Drawn By	Checked By
1	15.07.2023	FURTHER INFORMATION RESPONSE	HME	HME
0	26.09.2024	ISSUED FOR PLANNING		

PROJECT	LONG POINT OUTDOOR AMENITY ENHANCEMENT PROJECT	DWG. NO.	P(01)07
CLIENT	GALWAY COUNTY COUNCIL	REV.	1
DRAWING TITLE	PROPOSED BUILDINGS - LIFEGUARDS, VIEWING POINT AND TOTEM SIGN		
99014	JULY 2024	1:100 @ A1	BS
PROJECT NO.	DATE	SCALE	DRAWN BY
			CHECKED BY
			RELEASED