
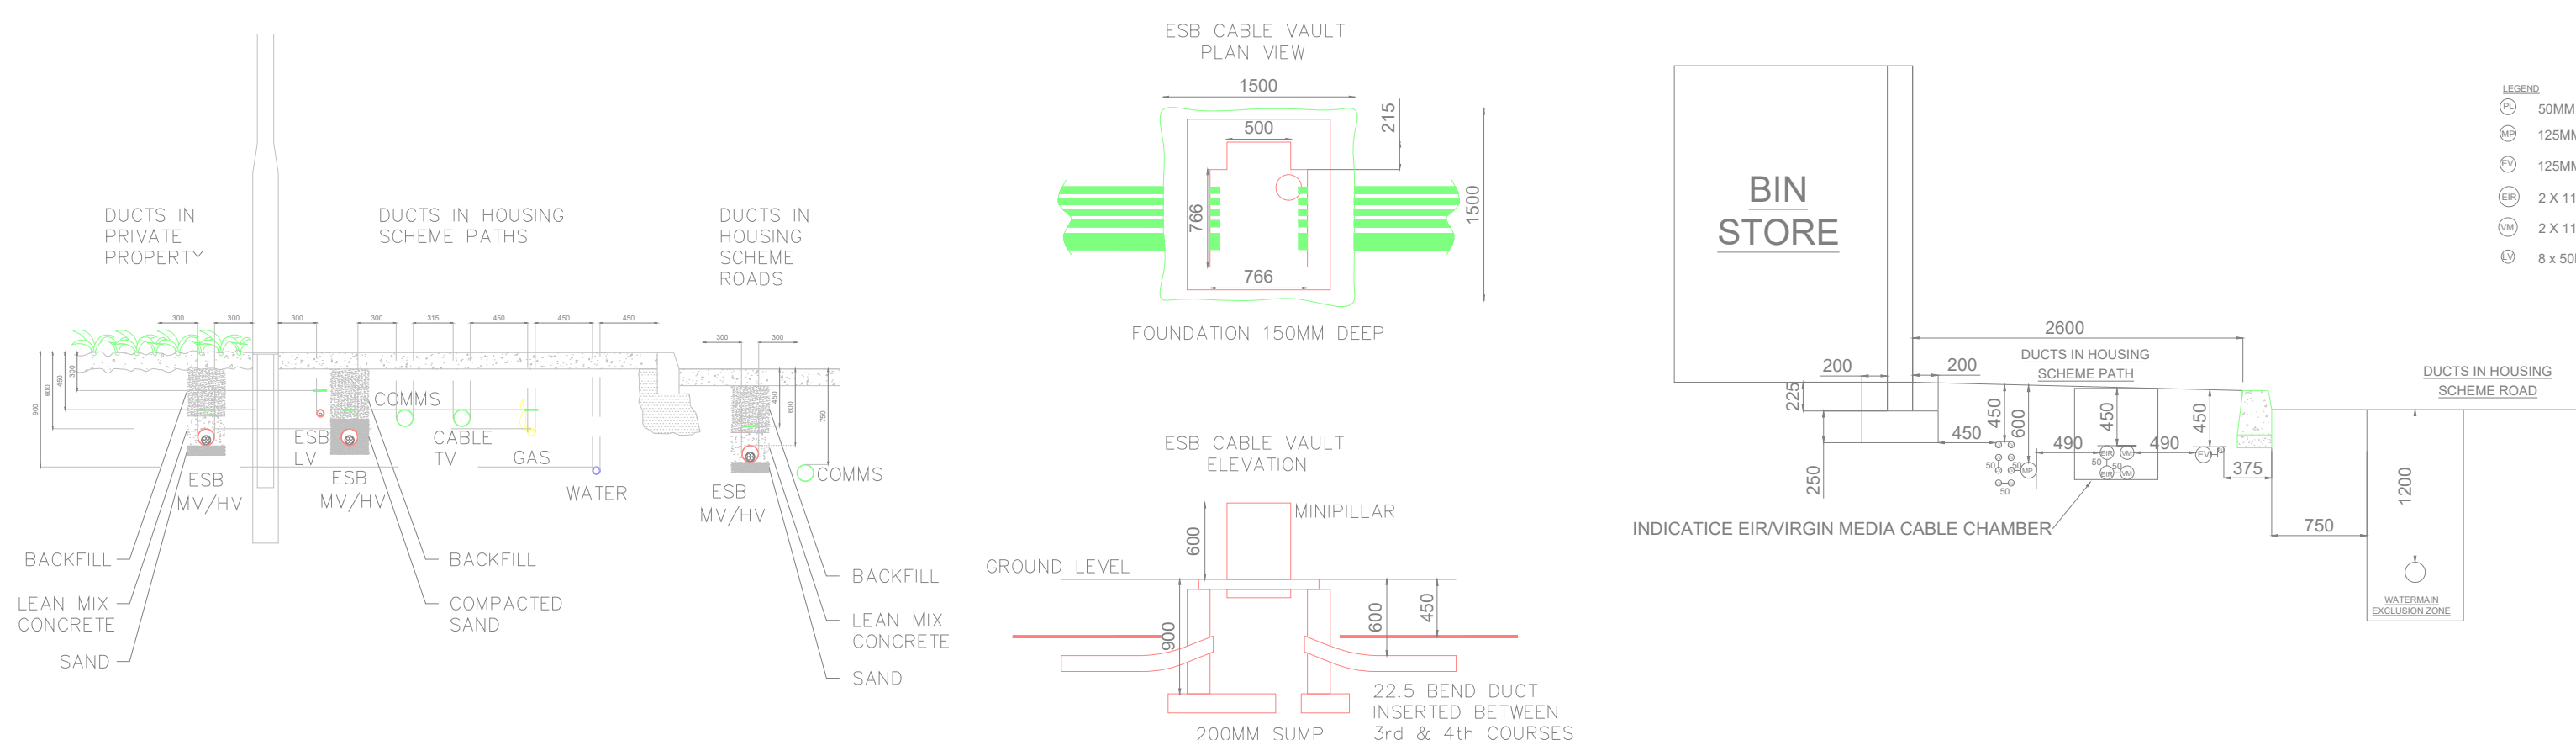


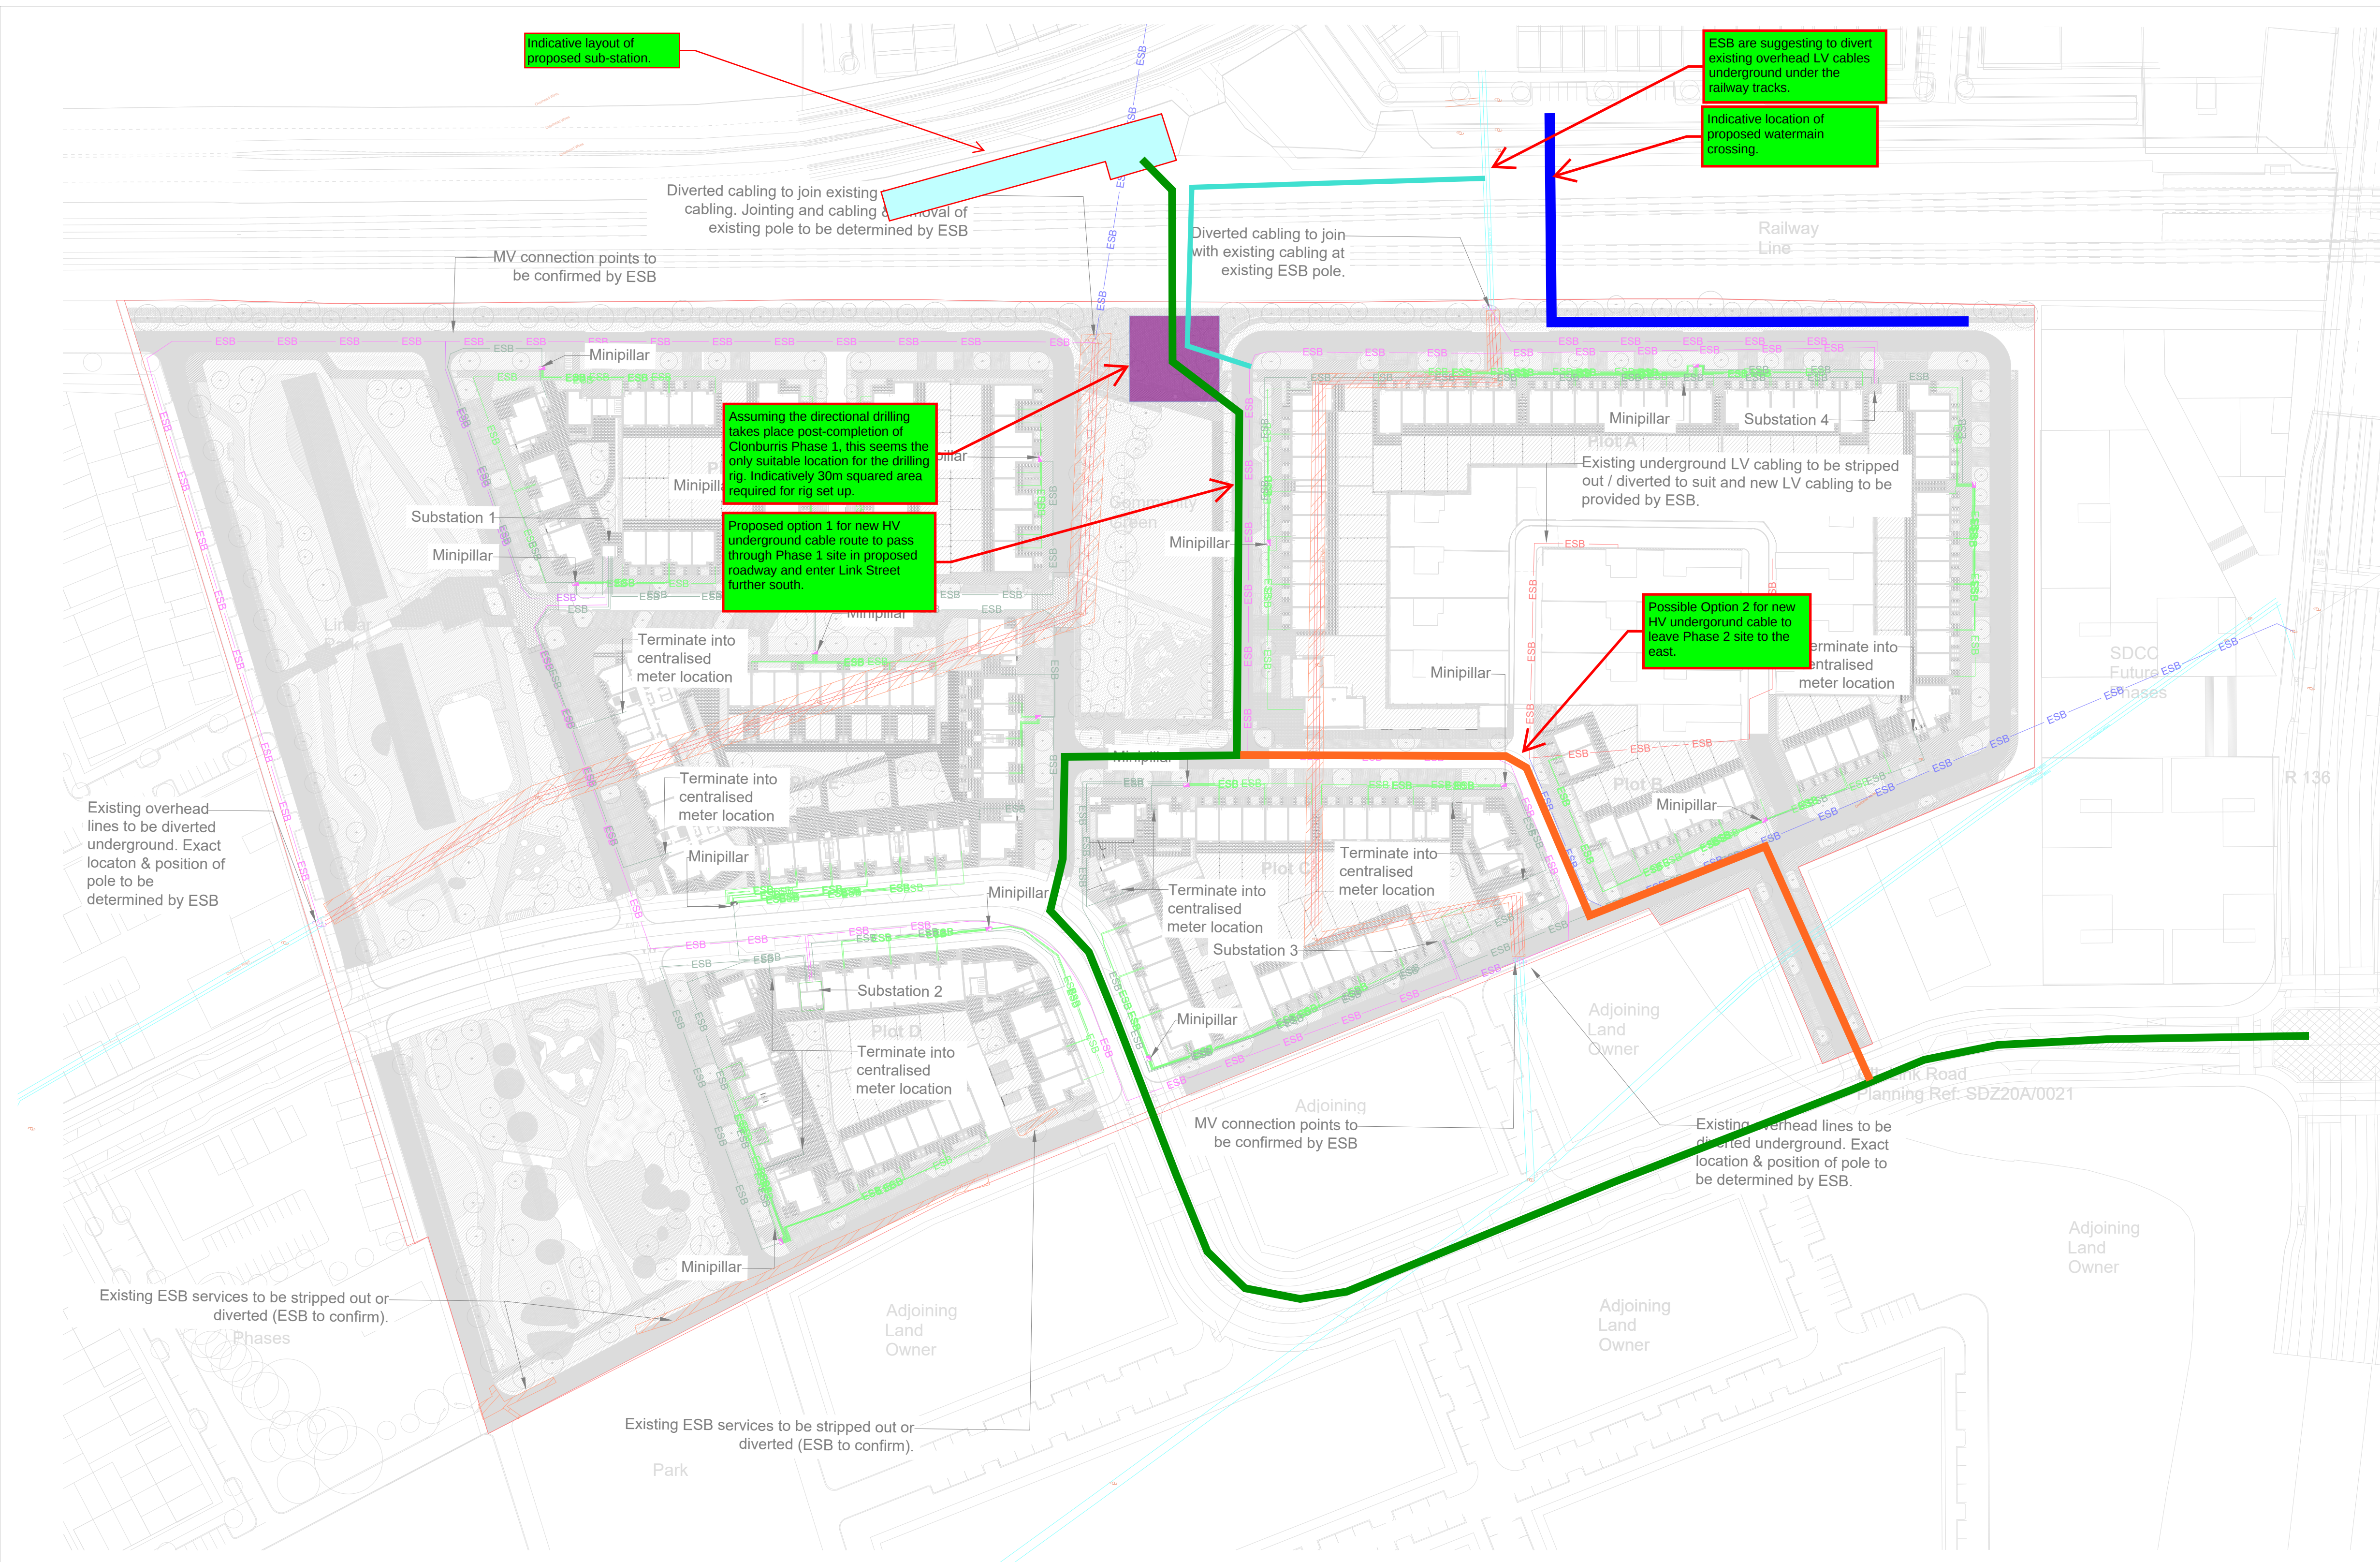

Issue/Revision		
T01	20230310	Suitable For Tender
Rev	Date	Description



Key Plan


 

Purpose Of Issue
D2 - Suitable For Tender
Project Number
606503944
Sheet Title

Site Plan

Existing and Proposed Layout

ESB

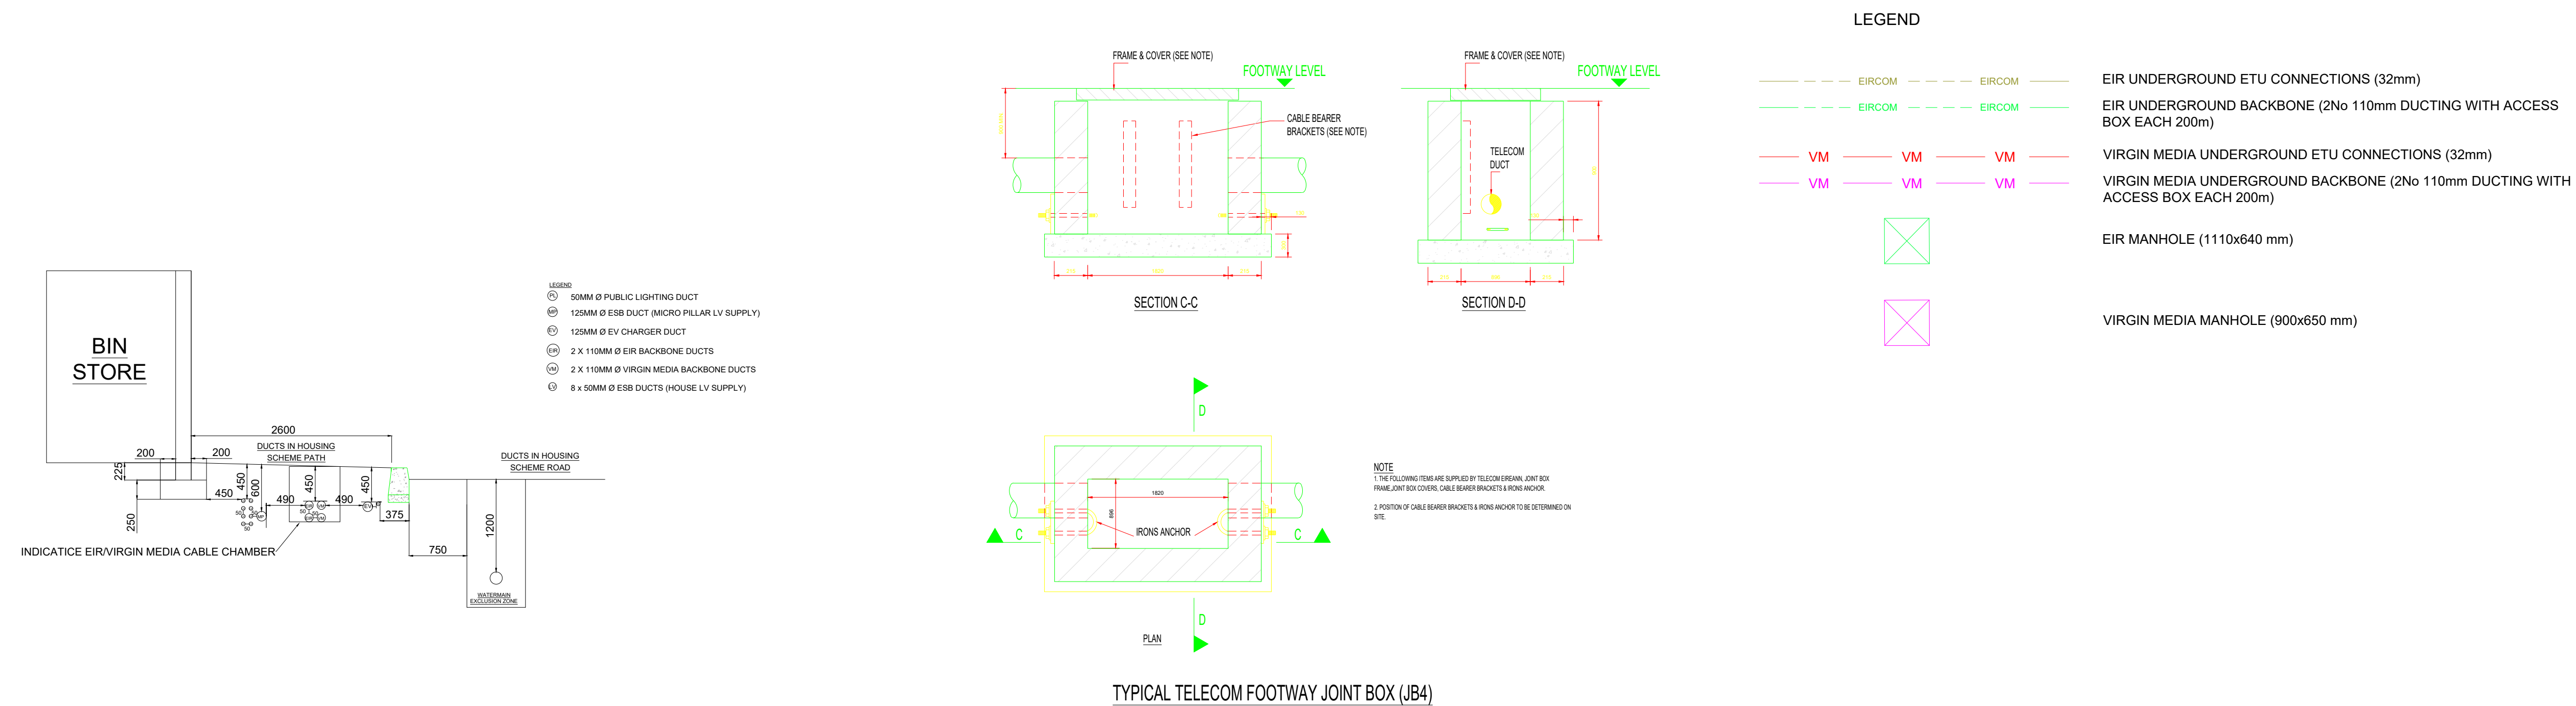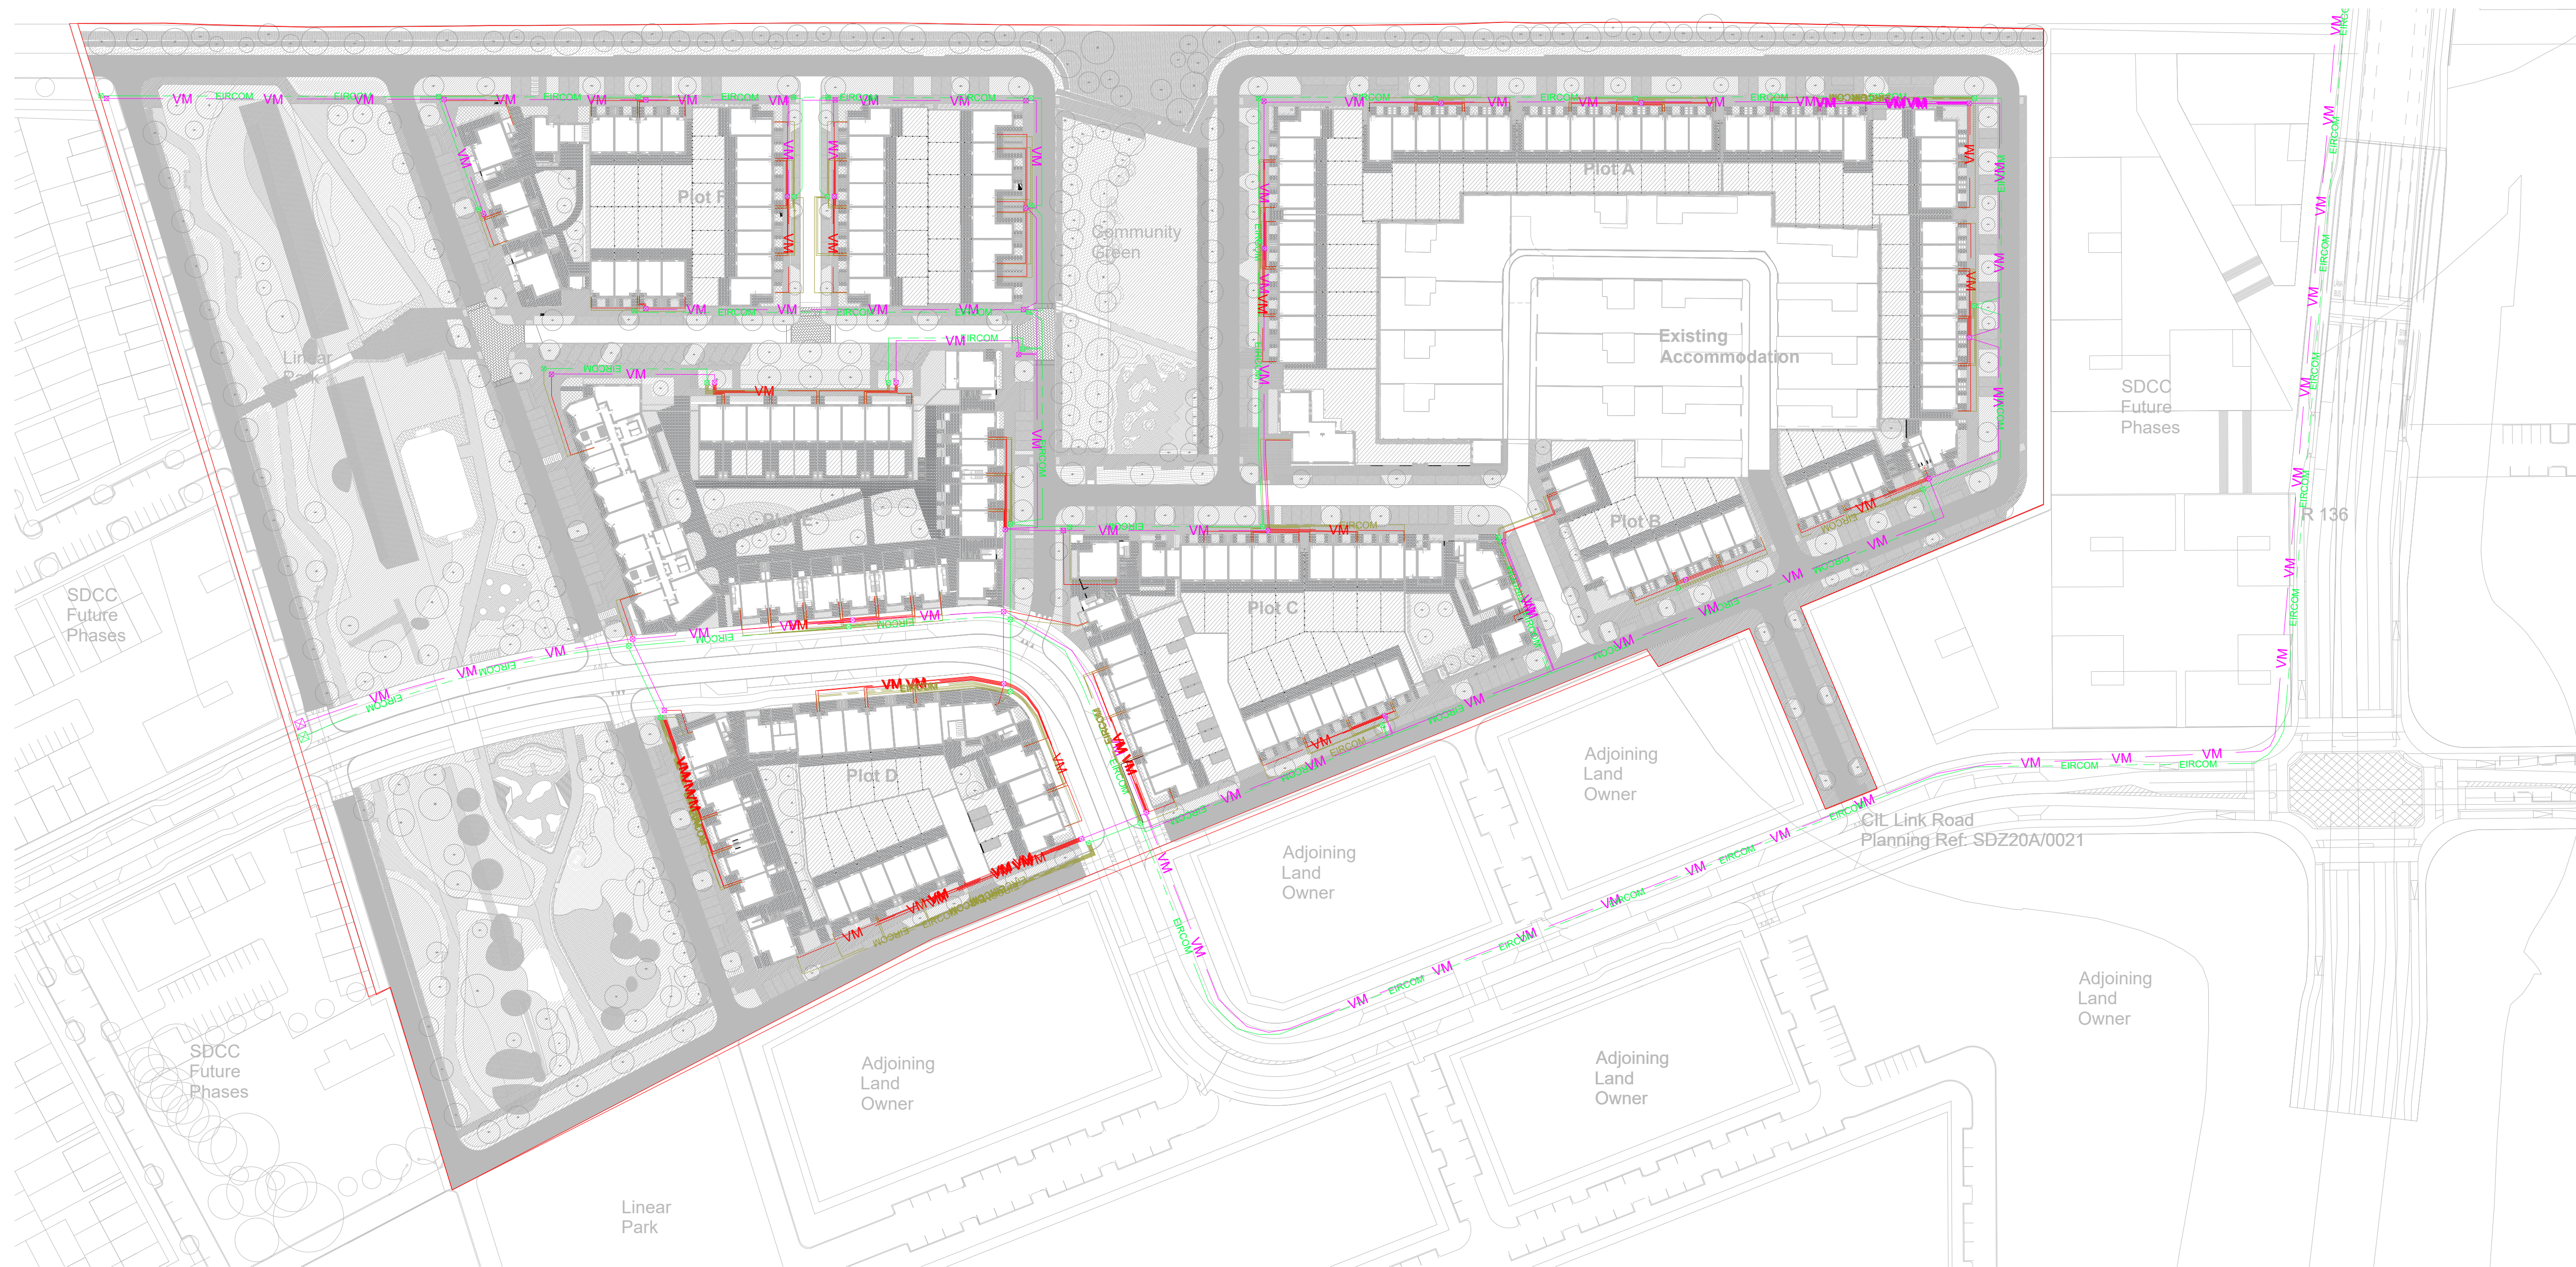

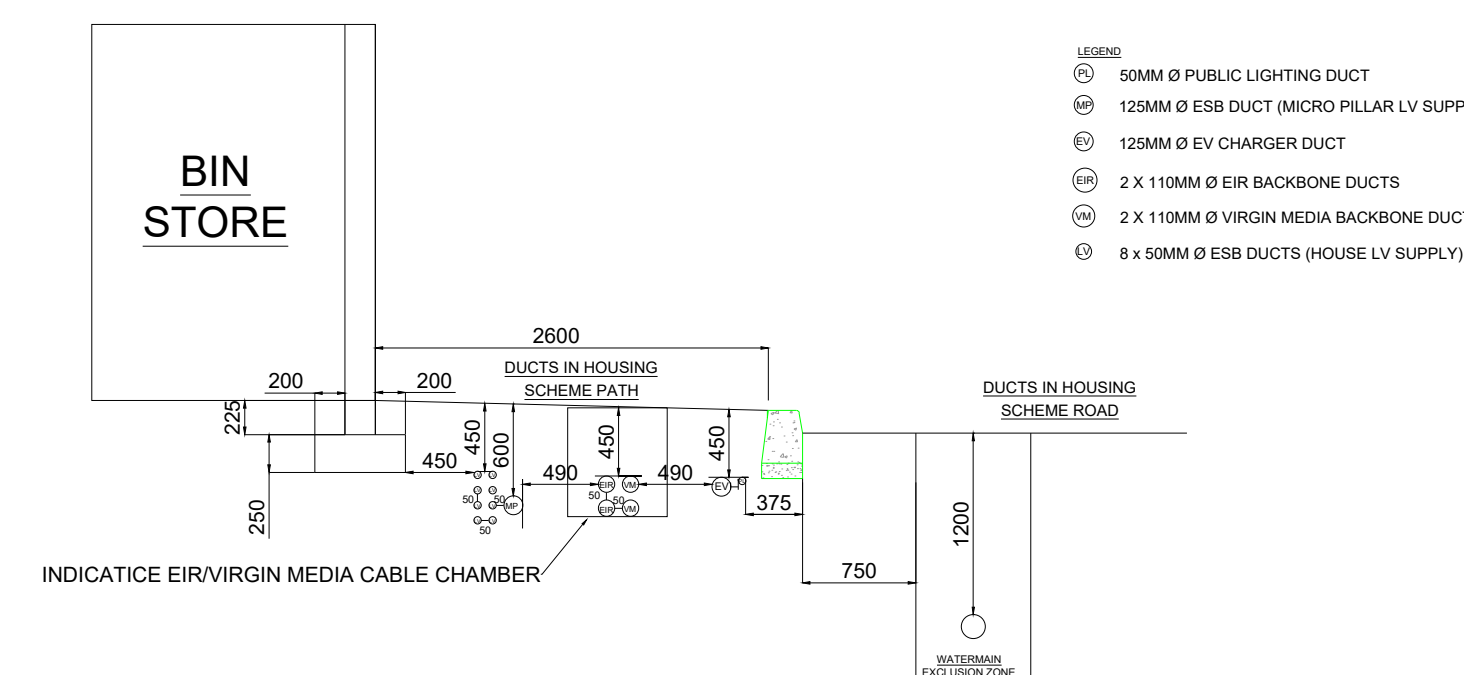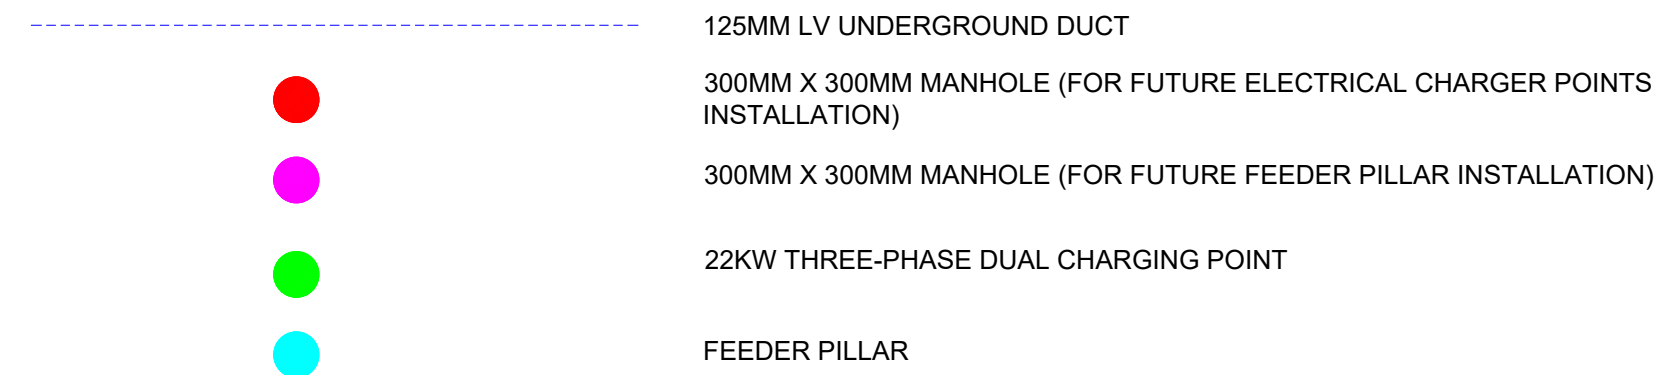

Issue/Revision		
T01	20230310	Suitable For Tender
Rev	Date	Description

Key Plan

Purpose Of Issue

D2 - Suitable For Tender

Project Number

606503944

Sheet Title

Site Plan Electrical Vehicle Charging Point EVC Layout


Sheet Number

CLON-ACM-ZZ-00-DR-EL-021003

Scale: 1 : 1000 @ A1


Rev: T01

ISO A1 594mm x 841mm
Approved: RR
Checked: KF
Designer: SS
Project Management Initials: DR-EL-02-1004 DWG
Last saved by: GROSSA/2023.03.08
Filename: \\NA-AECOM\NET\COM\FS\EMEA\DU\BIN\EDBL2\LEGACY\IEDBL2\FP001\DATA\DCS\PROJECTS\BP\60650394_SDCC_CLONBURRIS\900_CAD_GIS\903_BS01_WIP02_SHEETS\ELECTRICAL\CLON-ACM-ZZ-00-DR-EL-02-1004.DWG

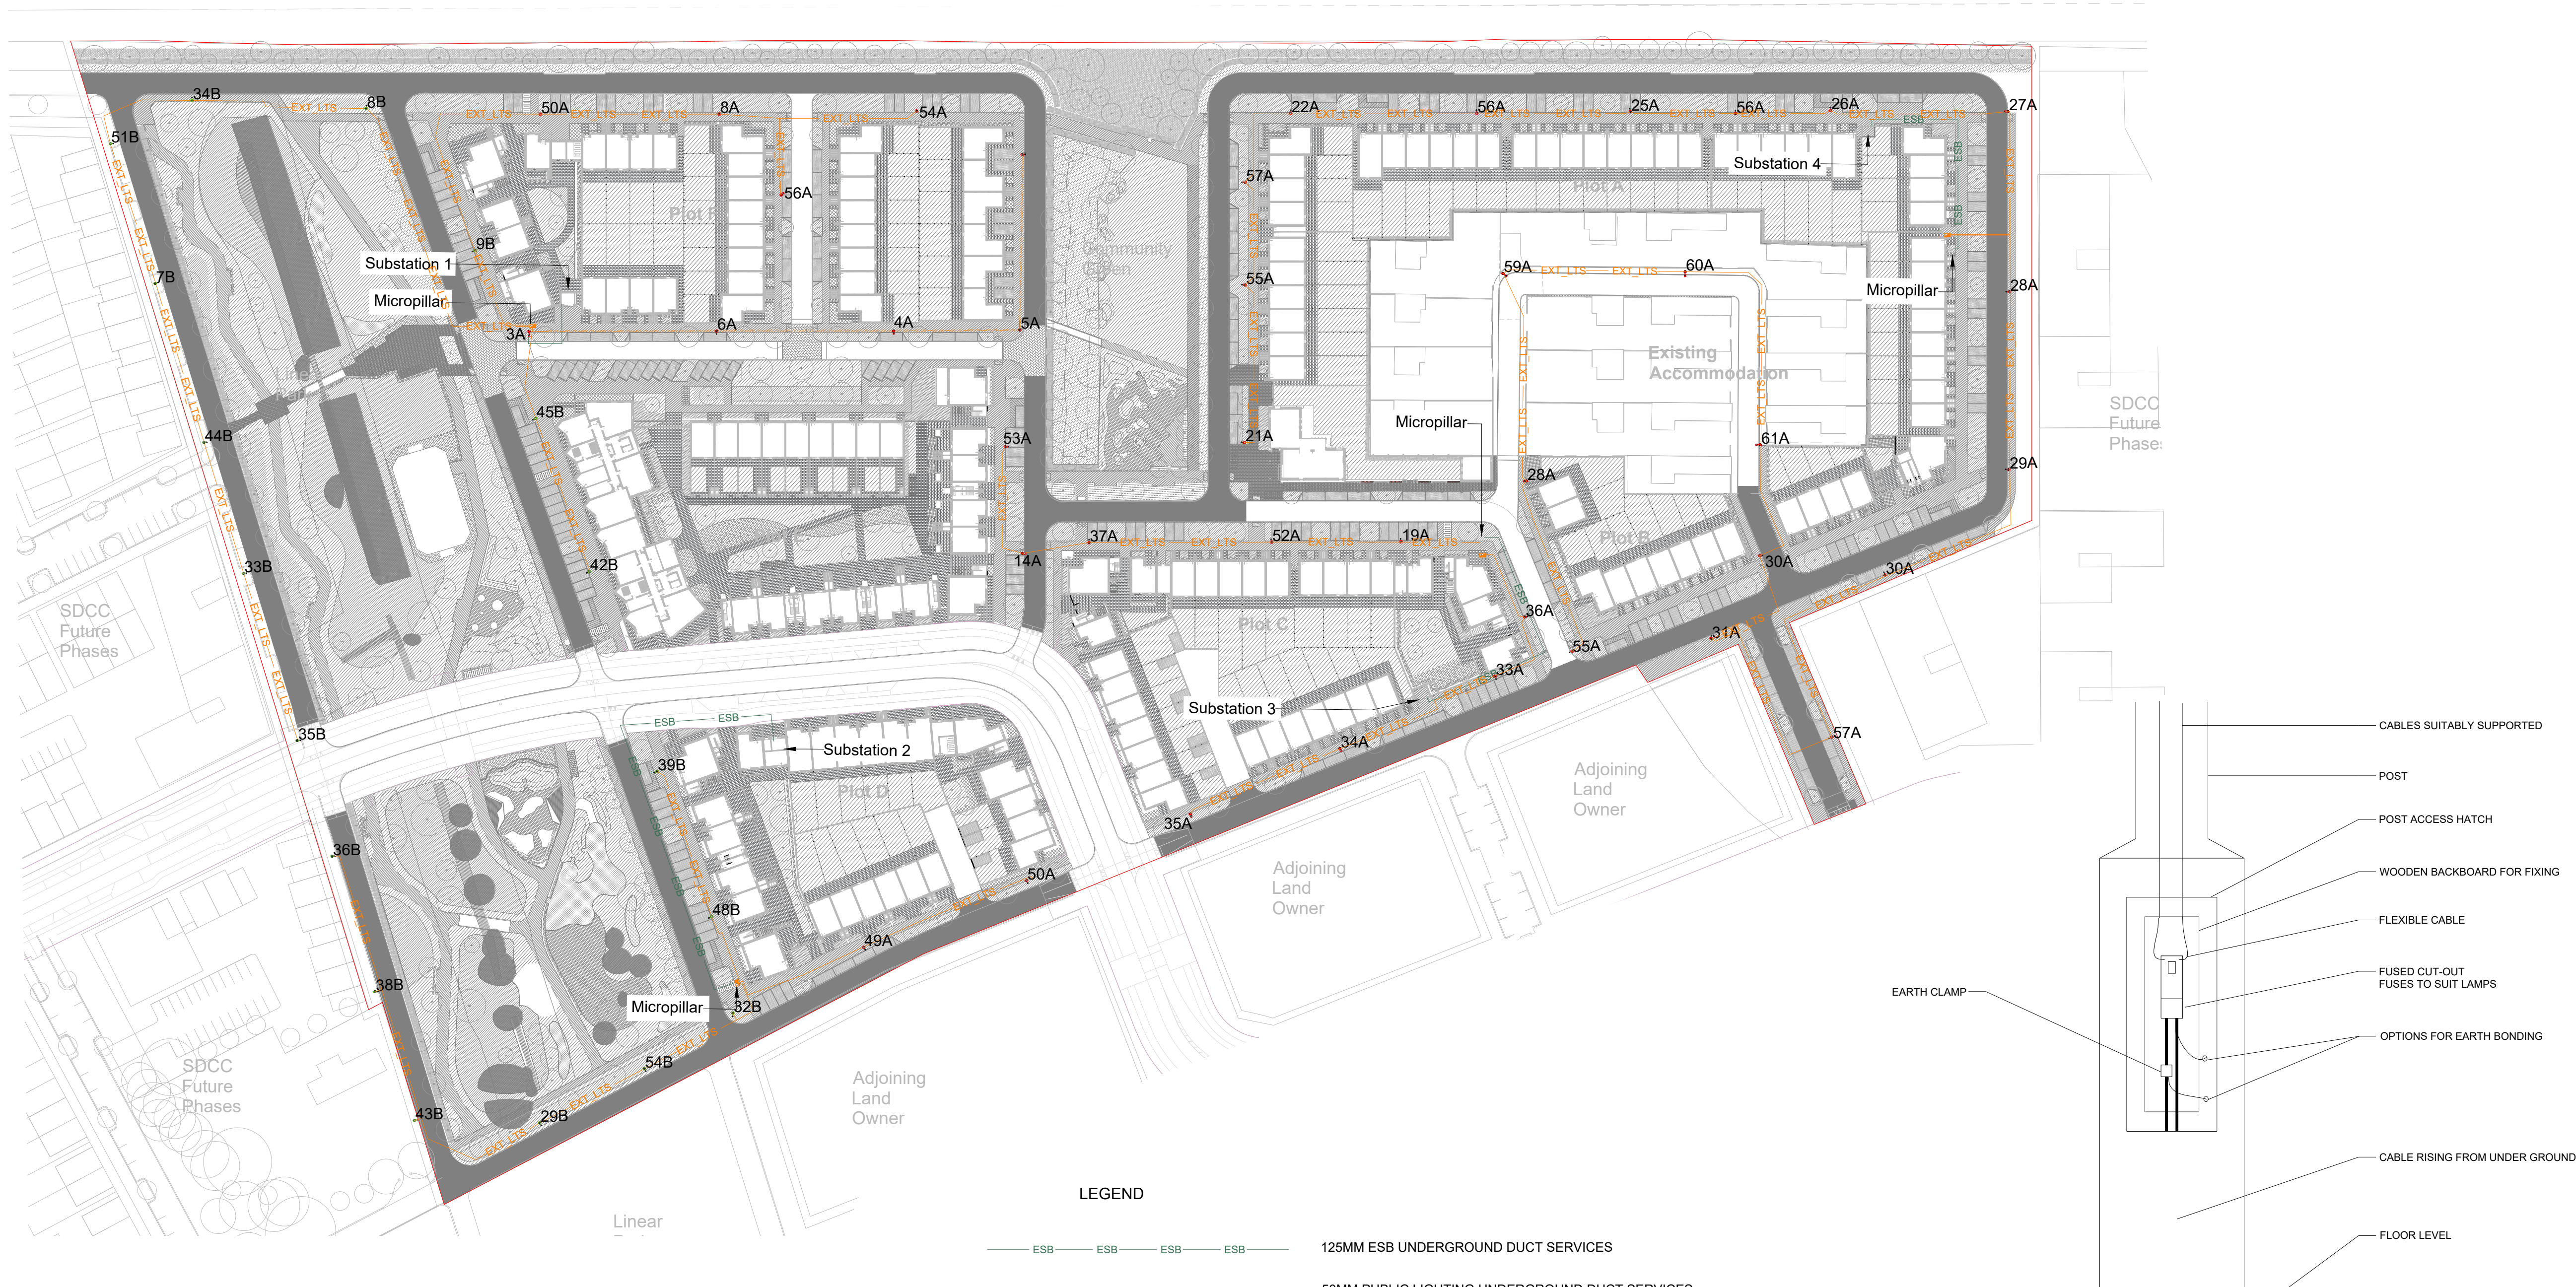


LEGEND

- ESB ESB ESB ESB 125MM ESB UNDERGROUND DUCT SERVICES
- EXT_LTS EXT_LTS EXT_LTS EXT_LTS 50MM PUBLIC LIGHTING UNDERGROUND DUCT SERVICES
- LUMINAIRE S1 - LED 9000LM 4000K C/W 6M COLUMN
- LUMINAIRE S2 - LED 8000LM 2700K C/W 6M COLUMN
- BEAMING AIMING TARGET
- PHOTOCENTRIC CENTRE

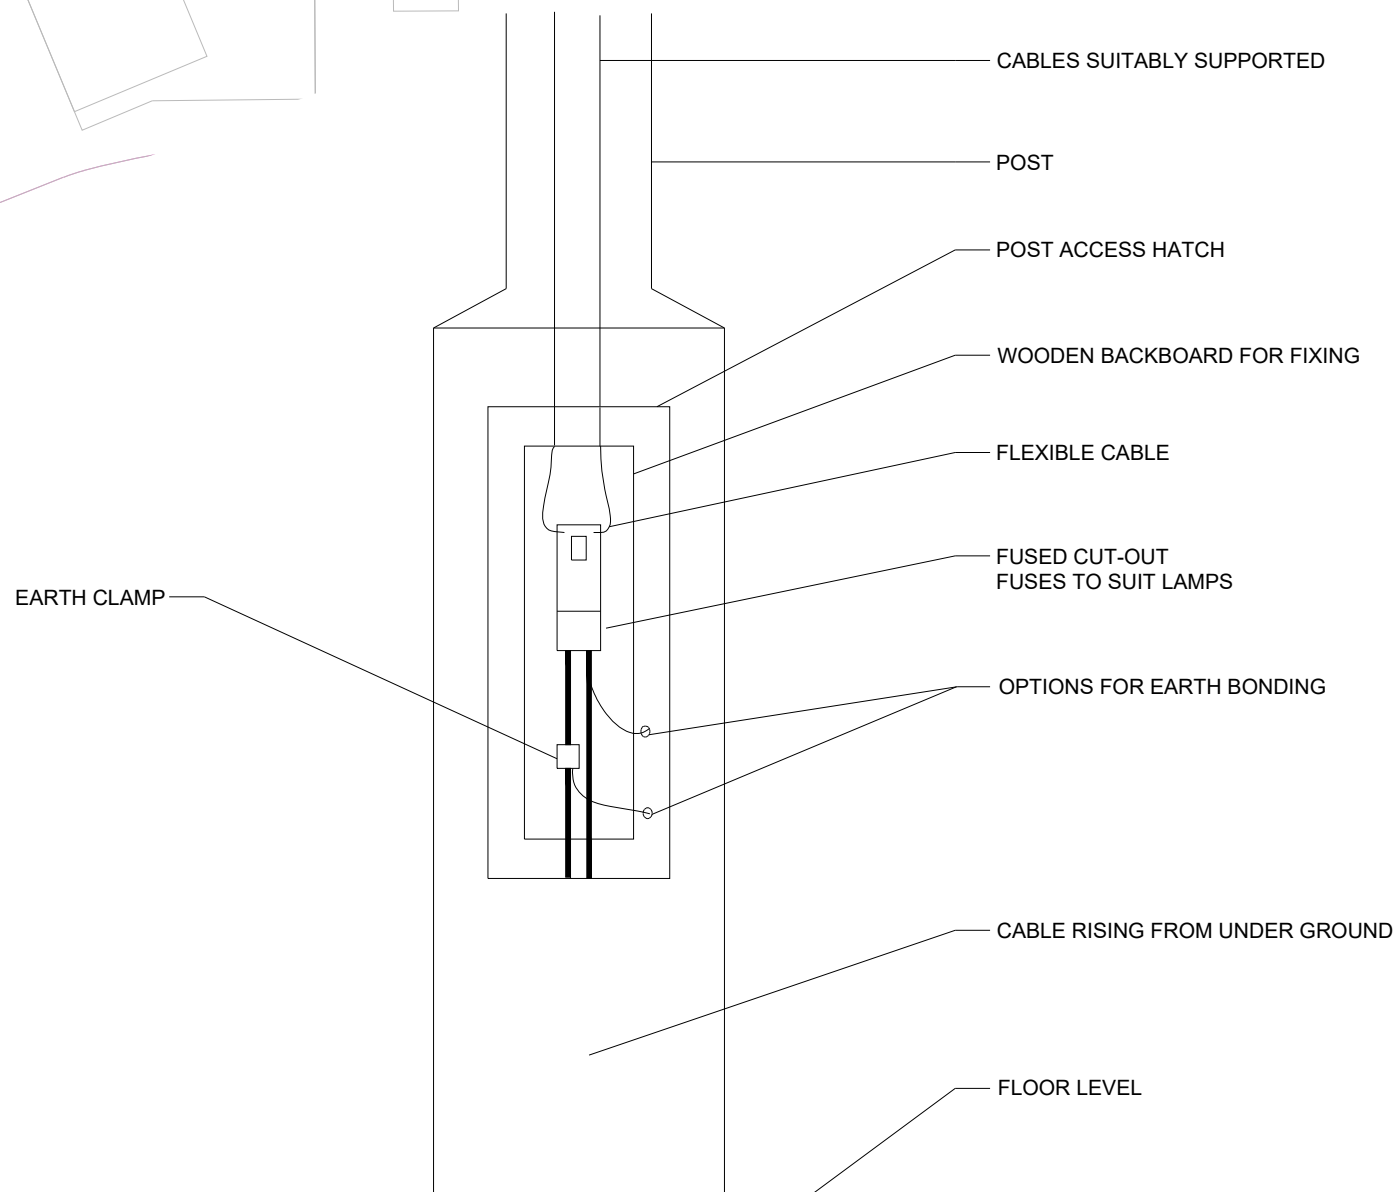


EXTERNAL LUMINAIRE COLUMN CABLING

ID	Type	Height	Tilt	Outreach	ID	Type	Height	Tilt	Outreach
3	A	6	0	0	50	A	6	0	0
4	A	6	0	0	32	B	6	0	0
5	A	6	0	0	33	B	6	0	0
6	A	6	0	0	34	B	6	0	0
8	A	6	0	0	35	B	6	0	0
7	B	6	0	0	36	B	6	0	0
8	B	6	0	0	50	A	6	0	0
9	B	6	0	0	38	B	6	0	0
14	A	6	0	0	39	B	6	0	0
17	A	6	0	0	55	A	6	0	0
19	A	6	0	0	56	A	6	0	0
21	A	6	0	0	42	B	6	0	0
22	A	6	0	0	43	B	6	0	0
25	A	6	0	0	44	B	6	0	0
26	A	6	0	0	45	B	6	0	0
27	A	6	0	0	56	A	6	0	0
28	A	6	0	0	57	A	6	0	0
29	A	6	0	0	48	B	6	0	0
30	A	6	0	0	59	A	6	0	0
31	A	6	0	0	60	A	6	0	0
33	A	6	0	0	61	A	6	0	0
34	A	6	0	0	51	B	6	0	0
35	A	6	0	0	52	A	6	0	0
36	A	6	0	0	53	A	6	0	0
37	A	6	0	0	54	A	6	0	0
28	A	6	0	0	54	B	6	0	0
29	B	6	0	0	55	A	6	0	0
49	A	6	0	0	56	A	6	0	0
					57	A	6	0	0

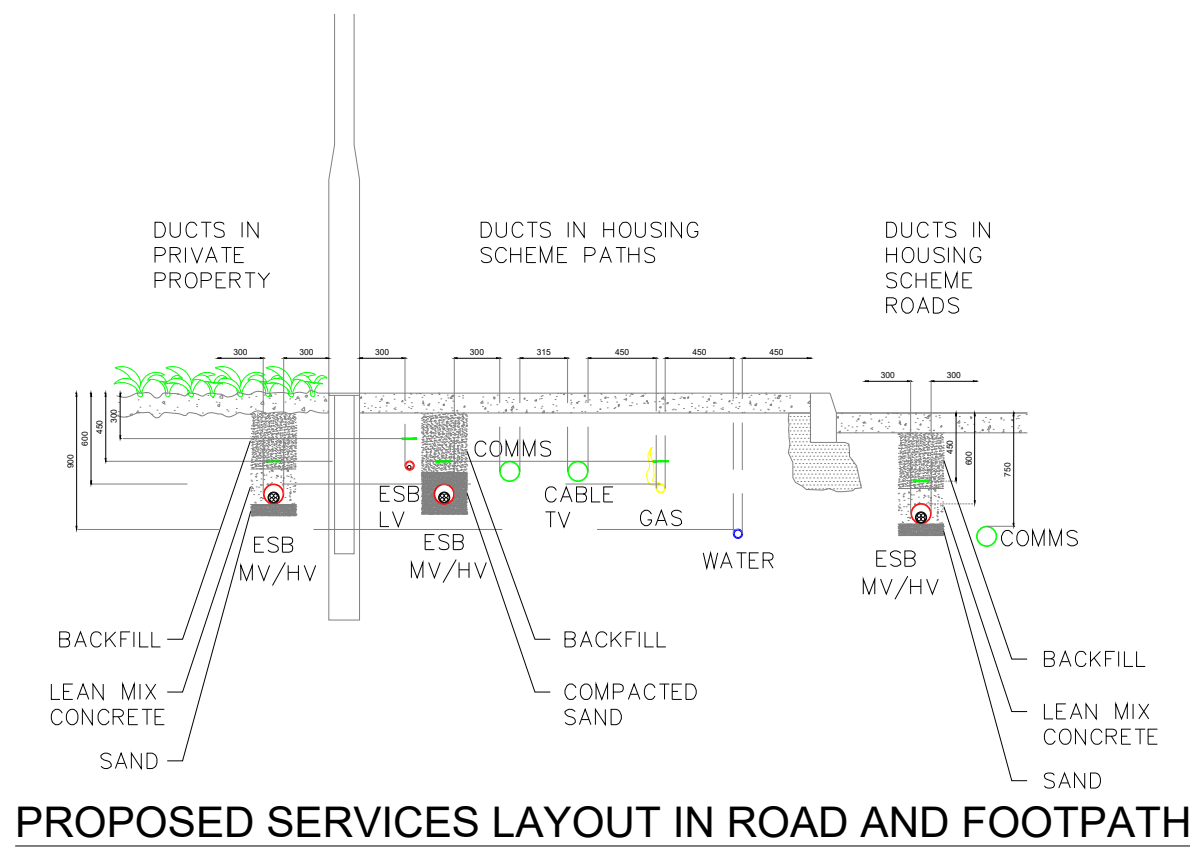

PROPOSED SERVICES LAYOUT IN ROAD AND FOOTPATH

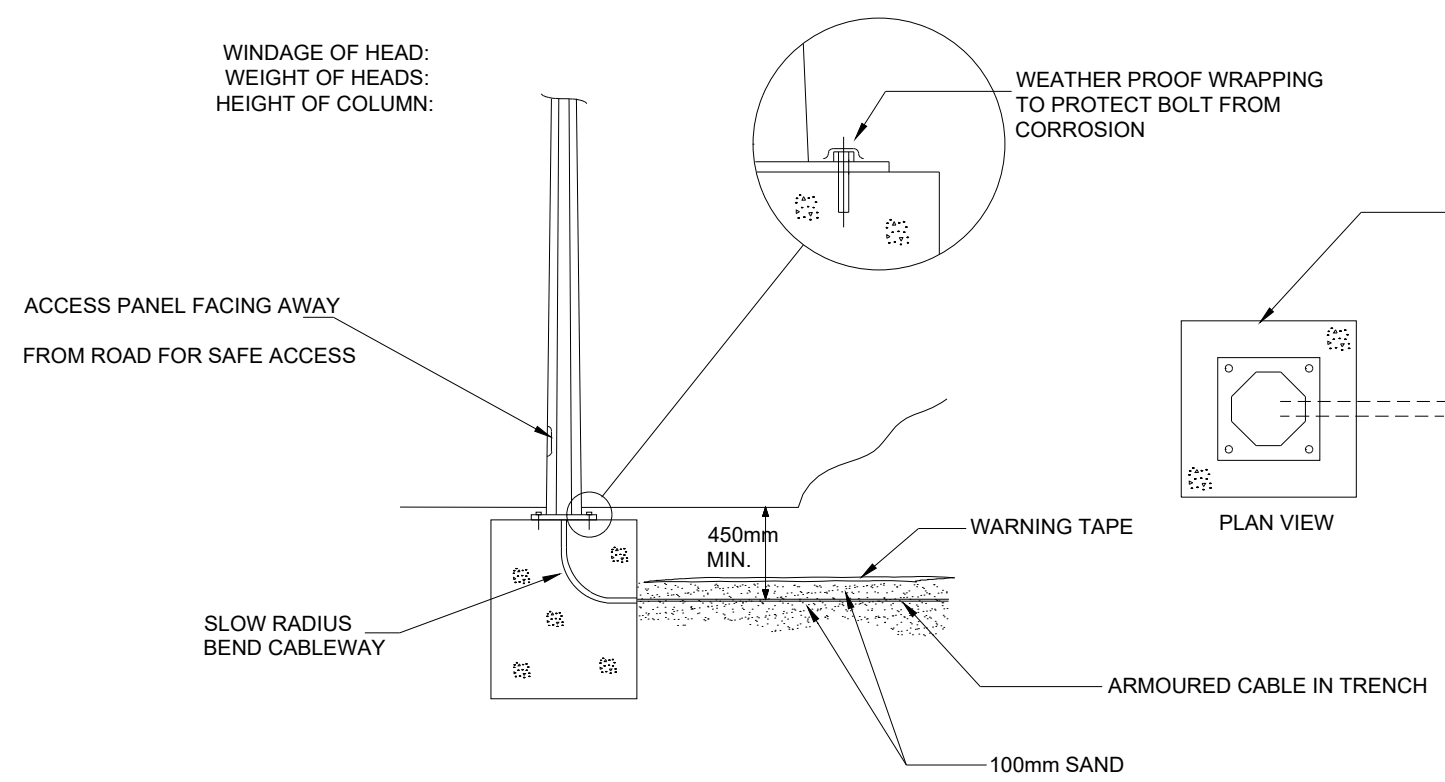

EXTERNAL LUMINAIRE COLUMN CABLE ENTRY - FLANGED BASE

Issue/Revision

Rev	Date	Description
T01	20230310	Suitable For Tender

Key Plan

Purpose Of Issue

D2 - Suitable For Tender

Project Number

606503944

Sheet Title

Site Plan
Public & External Lighting

Sheet Number

CLON-ACM-ZZ-00-DR-EL-021004

Scale: 1 : 1000 @ A1

Rev: T01