


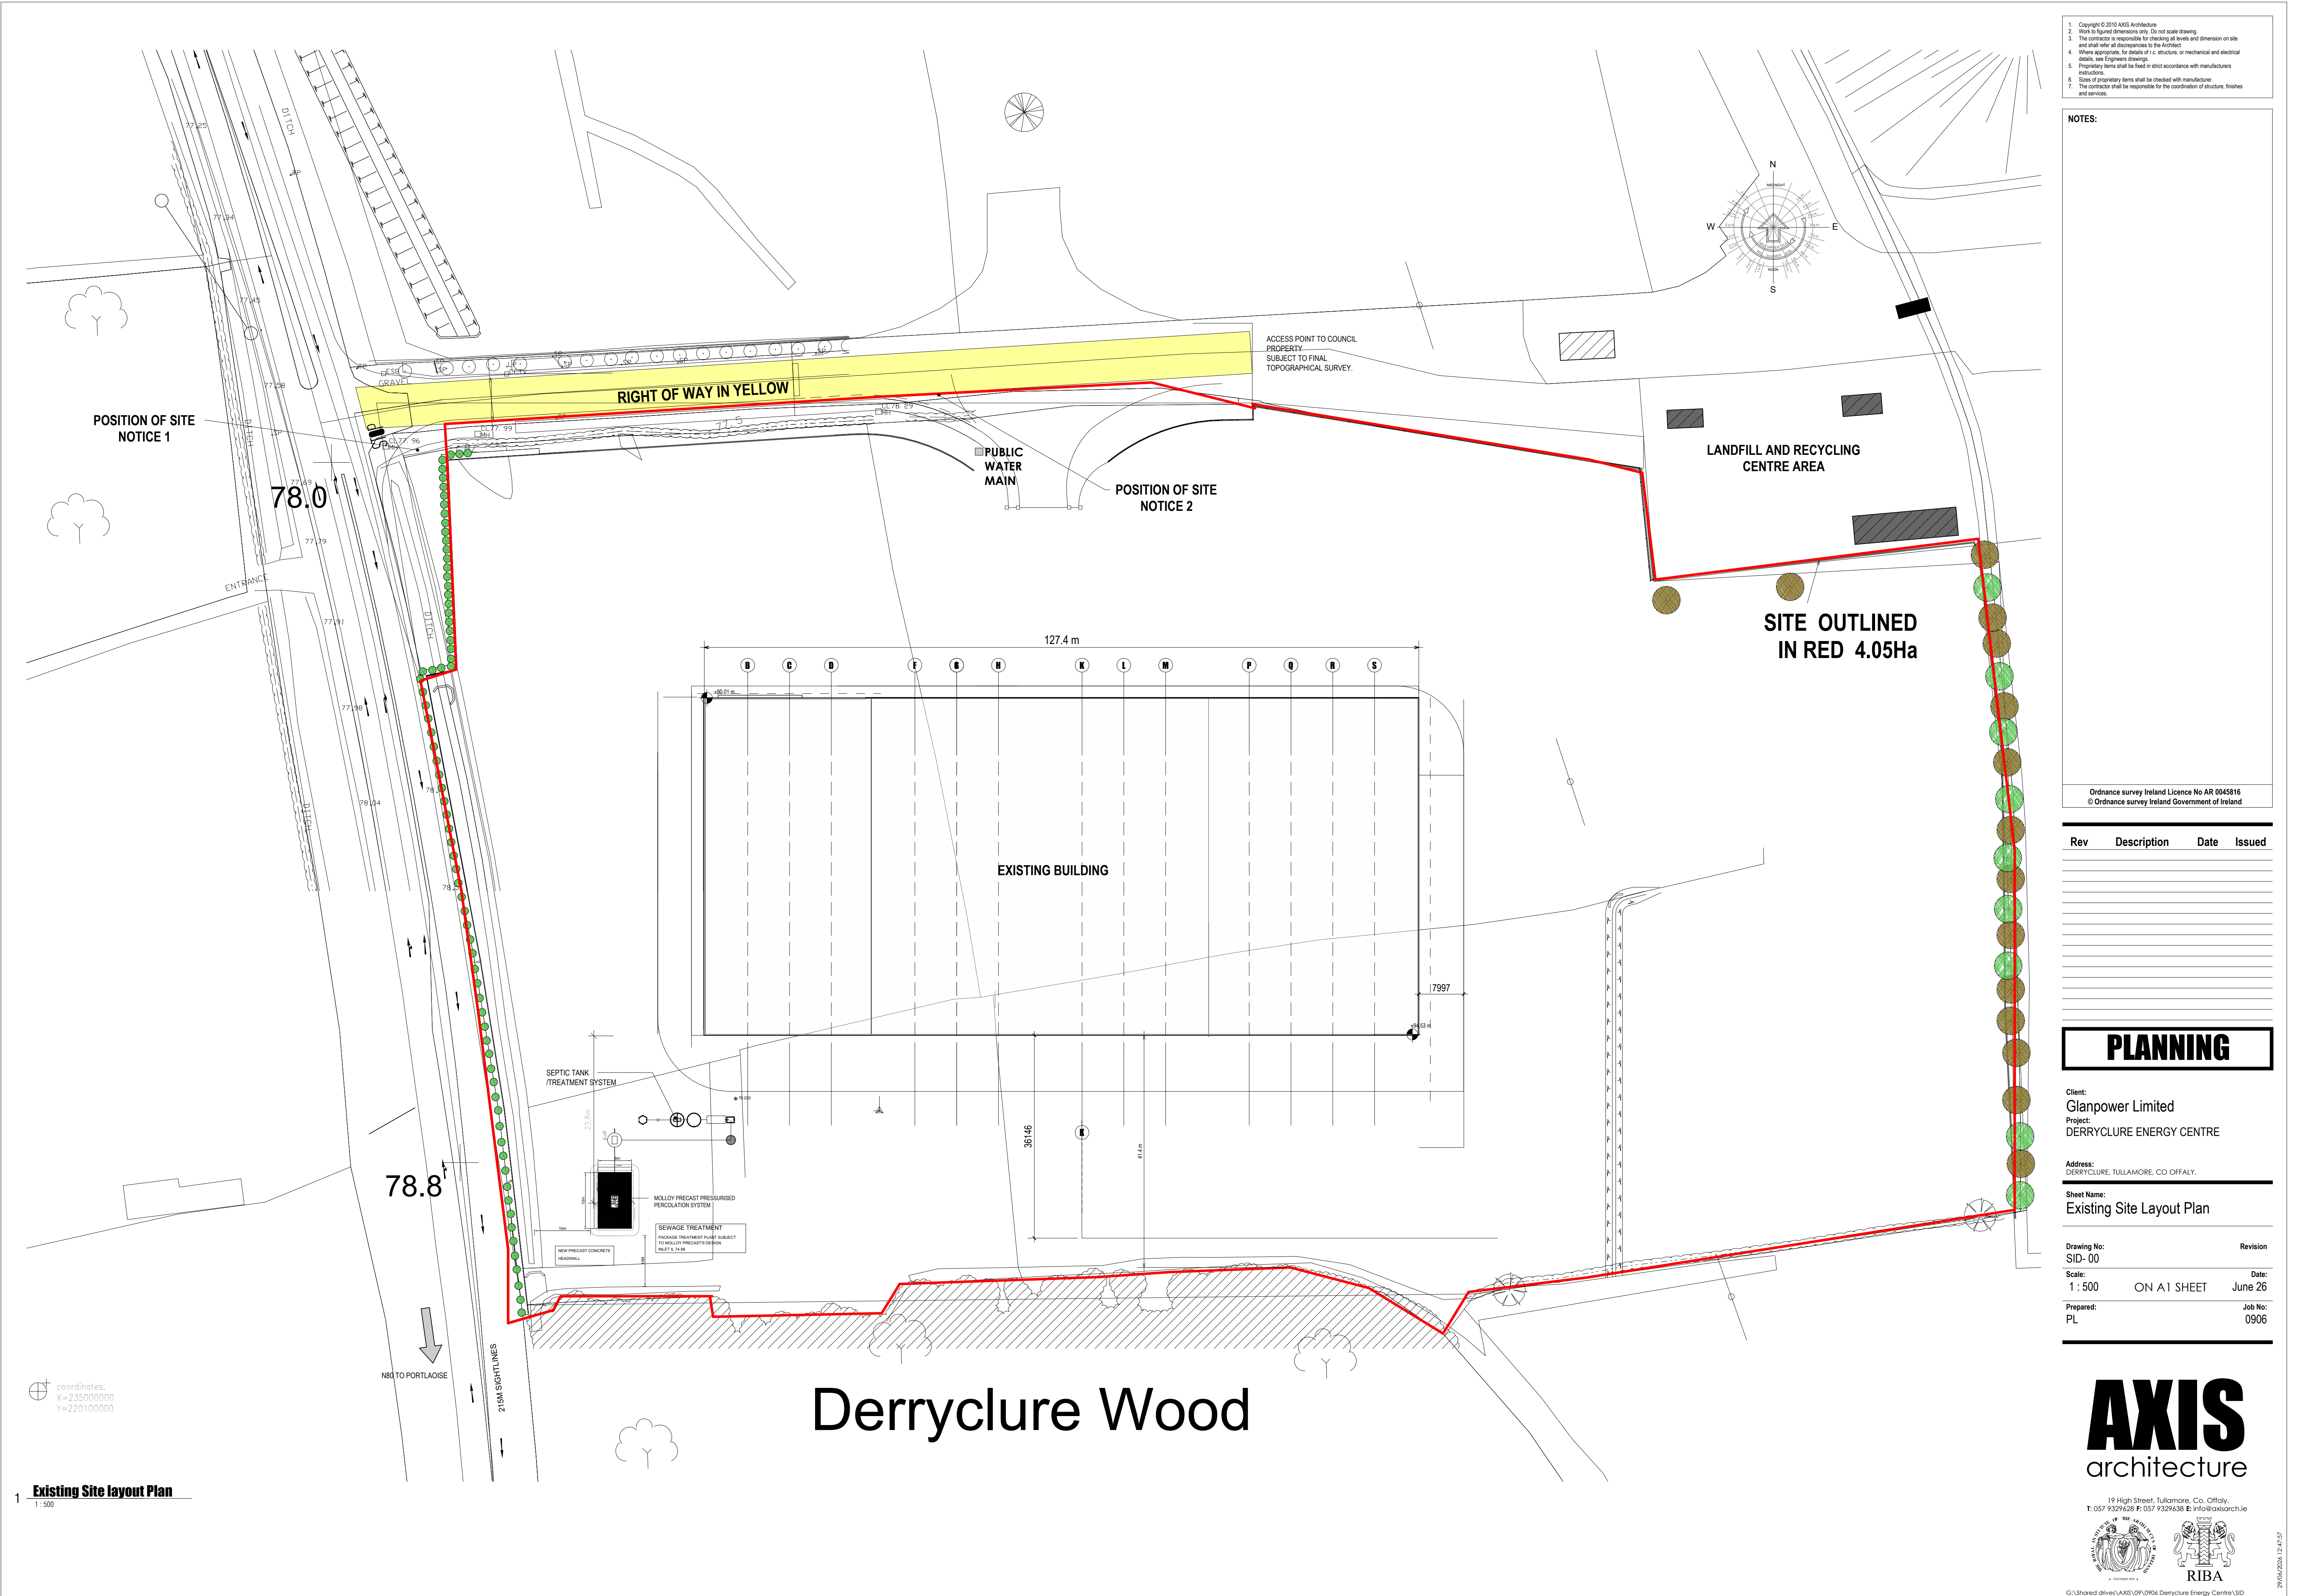

1. Copyright © 2010 AXIS Architecture
2. Work to figure dimensions only. Do not scale drawing.
3. The contractor is responsible for checking all levels and dimension on site and shall refer all discrepancies to the Architect.
4. Where appropriate, for details of c/c structure, or mechanical and electrical details, see Engineers drawings.
5. Proprietary items shall be fixed in strict accordance with manufacturers instructions.
6. Sizes of proprietary items shall be checked with manufacturer.
7. The contractor shall be responsible for the coordination of structure, finishes and services.

NOTES:

Ordnance survey Ireland Licence No AR 0045816
© Ordnance survey Ireland Government of Ireland

Rev	Description	Date	Issued
-----	-------------	------	--------

PLANNING

Client:
Glanpower Limited
Project:
DERRYCLURE ENERGY CENTRE

Address:
DERRYCLURE, TULLAMORE, CO. OFFALY.

Sheet Name:
Existing Site Layout Plan

Drawing No: SID- 00	Revision
Scale: 1 : 500	Date: June 26
Prepared: PL	Job No: 0906

AXIS
architecture

19 High Street, Tullamore, Co. Offaly.
T: 057 9329628 F: 057 9329638 E: info@axisarch.ie



G:\Shared drives\AXIS\09\0906 Derryclure Energy Centre\SID
appreciation\0906 SID 03.rvt