


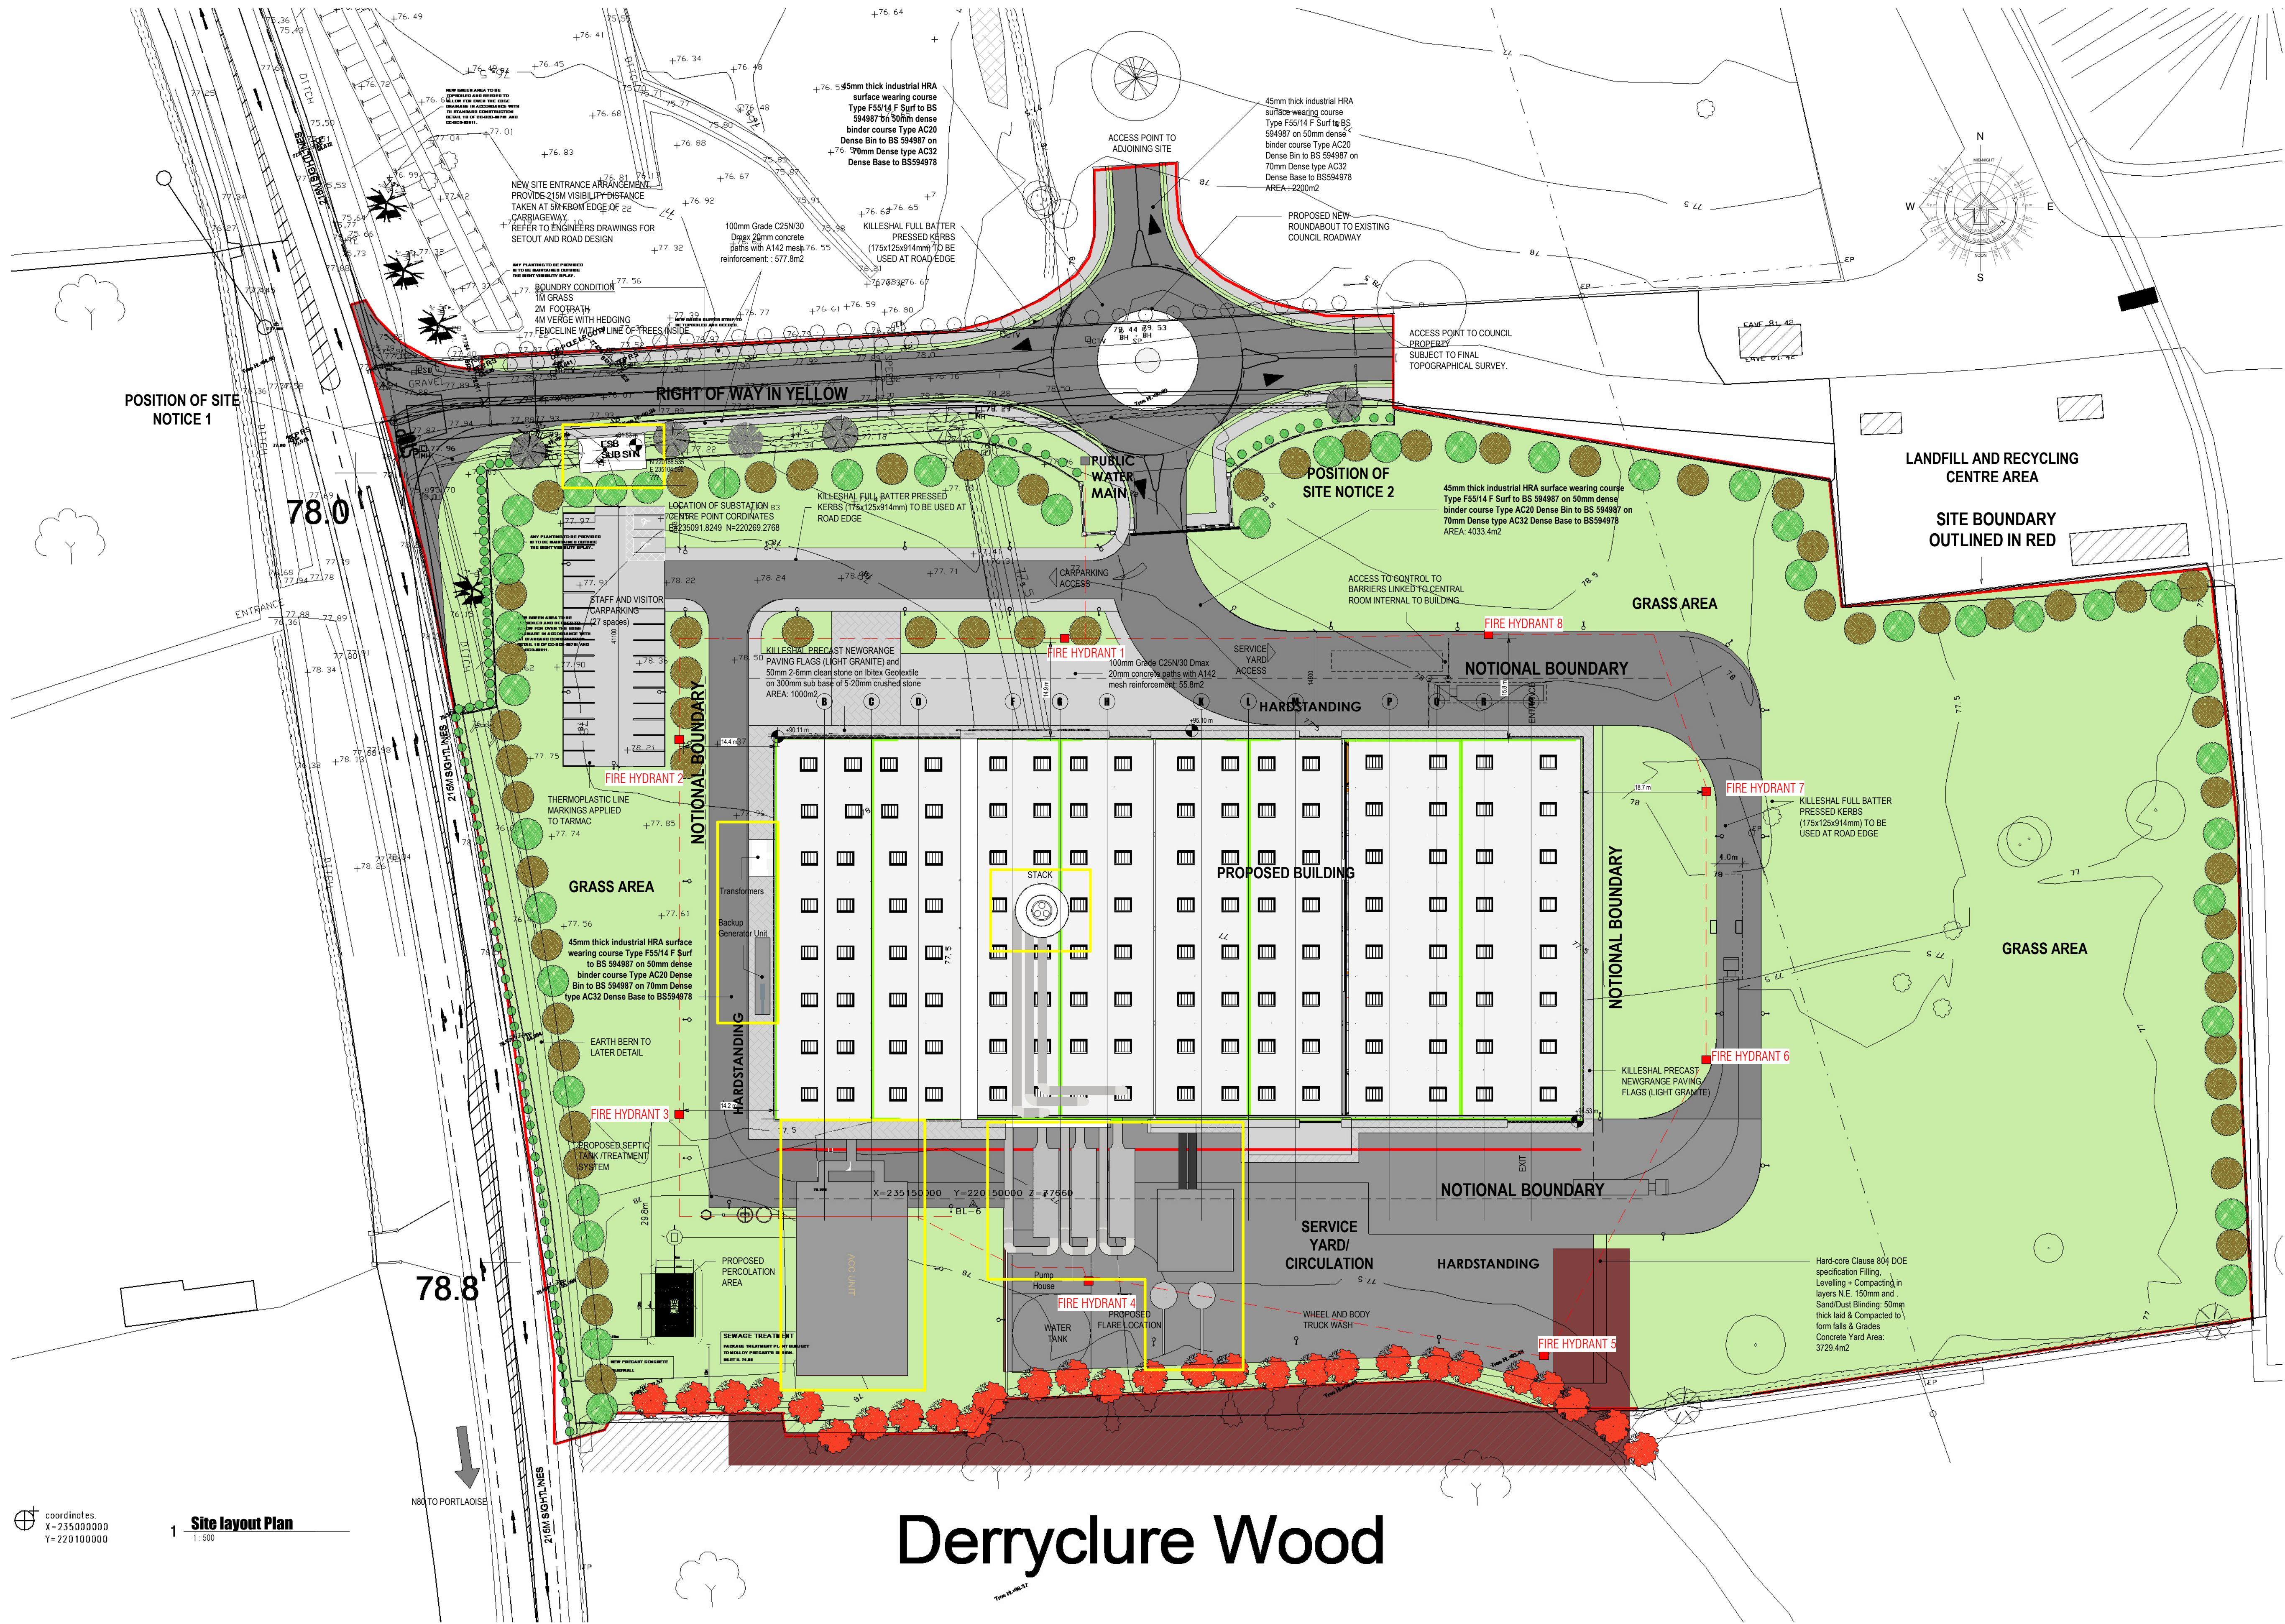

- Copyright © 2022 AXIS Architecture
- Work to be done on site only. Do not scale drawing.
- The contractor is responsible for checking all levels and dimensions on site and shall refer all discrepancies to the Architect.
- Where appropriate, for details of c. structure, or mechanical and electrical details, see Engineers drawings.
- Proprietary items shall be fixed in strict accordance with manufacturers instructions.
- Size of proprietary items shall be checked with manufacturer.
- The contractor shall be responsible for the coordination of structure, finishes and services.

NOTES:

Ordnance survey Ireland Licence No AR 0045822
© Ordnance survey Ireland Government of Ireland

Rev	Description	Date	Issued
-----	-------------	------	--------

DRAFT

Client:
Glanpower Limited
Project:
DERRYCLURE ENERGY PARK

Address:
DERRYCLURE, TULLAMORE, CO. OFFALY.

Sheet Name:
Site Layout plan

Drawing No:	Revision
SK- 01	
Scale:	Date:
1 : 500	ON A1 SHEET
Prepared:	Job No:
PL	0906

AXIS
architecture

O'Moore Hall, O'Moore Street, Tullamore, Co. Offaly.
T: 057 9329628 P: 057 9329638 E: info@axisarch.ie

