

- NOTES: Finishes Legend

- 01 Plant Mezzanine  
+87.0 m

02 Level 1 Officer 181.7 m

### Sprinkler System Layout

Ordnance survey Ireland Licence No AR 0045822  
© Ordnance survey Ireland Government of Ireland

[illegible]

**Address:**  
DERRYCLURE, TULLAMORE, CO OFFALY.

Sheet Name:  
Elevations (Sheet 2)

Drawing No: SK- 04

Scale: 1:200      Date: July 25

|           |         |
|-----------|---------|
| Prepared: | Job No: |
| mmcq      | 0906    |


**AXIS**  
architecture

O'Moore Hall, O'Moore Street, Tullamore, Co. Offaly  
T: 057 9329628 E: 057 9329638 E: [info@axisarch.ie](mailto:info@axisarch.ie)




1 10710000 17.01.02

G:\Shared drives\AXIS\09\0906 Demysture Energy Centre\Drawings\Stage 5\0906 - SID- SK01.rvt

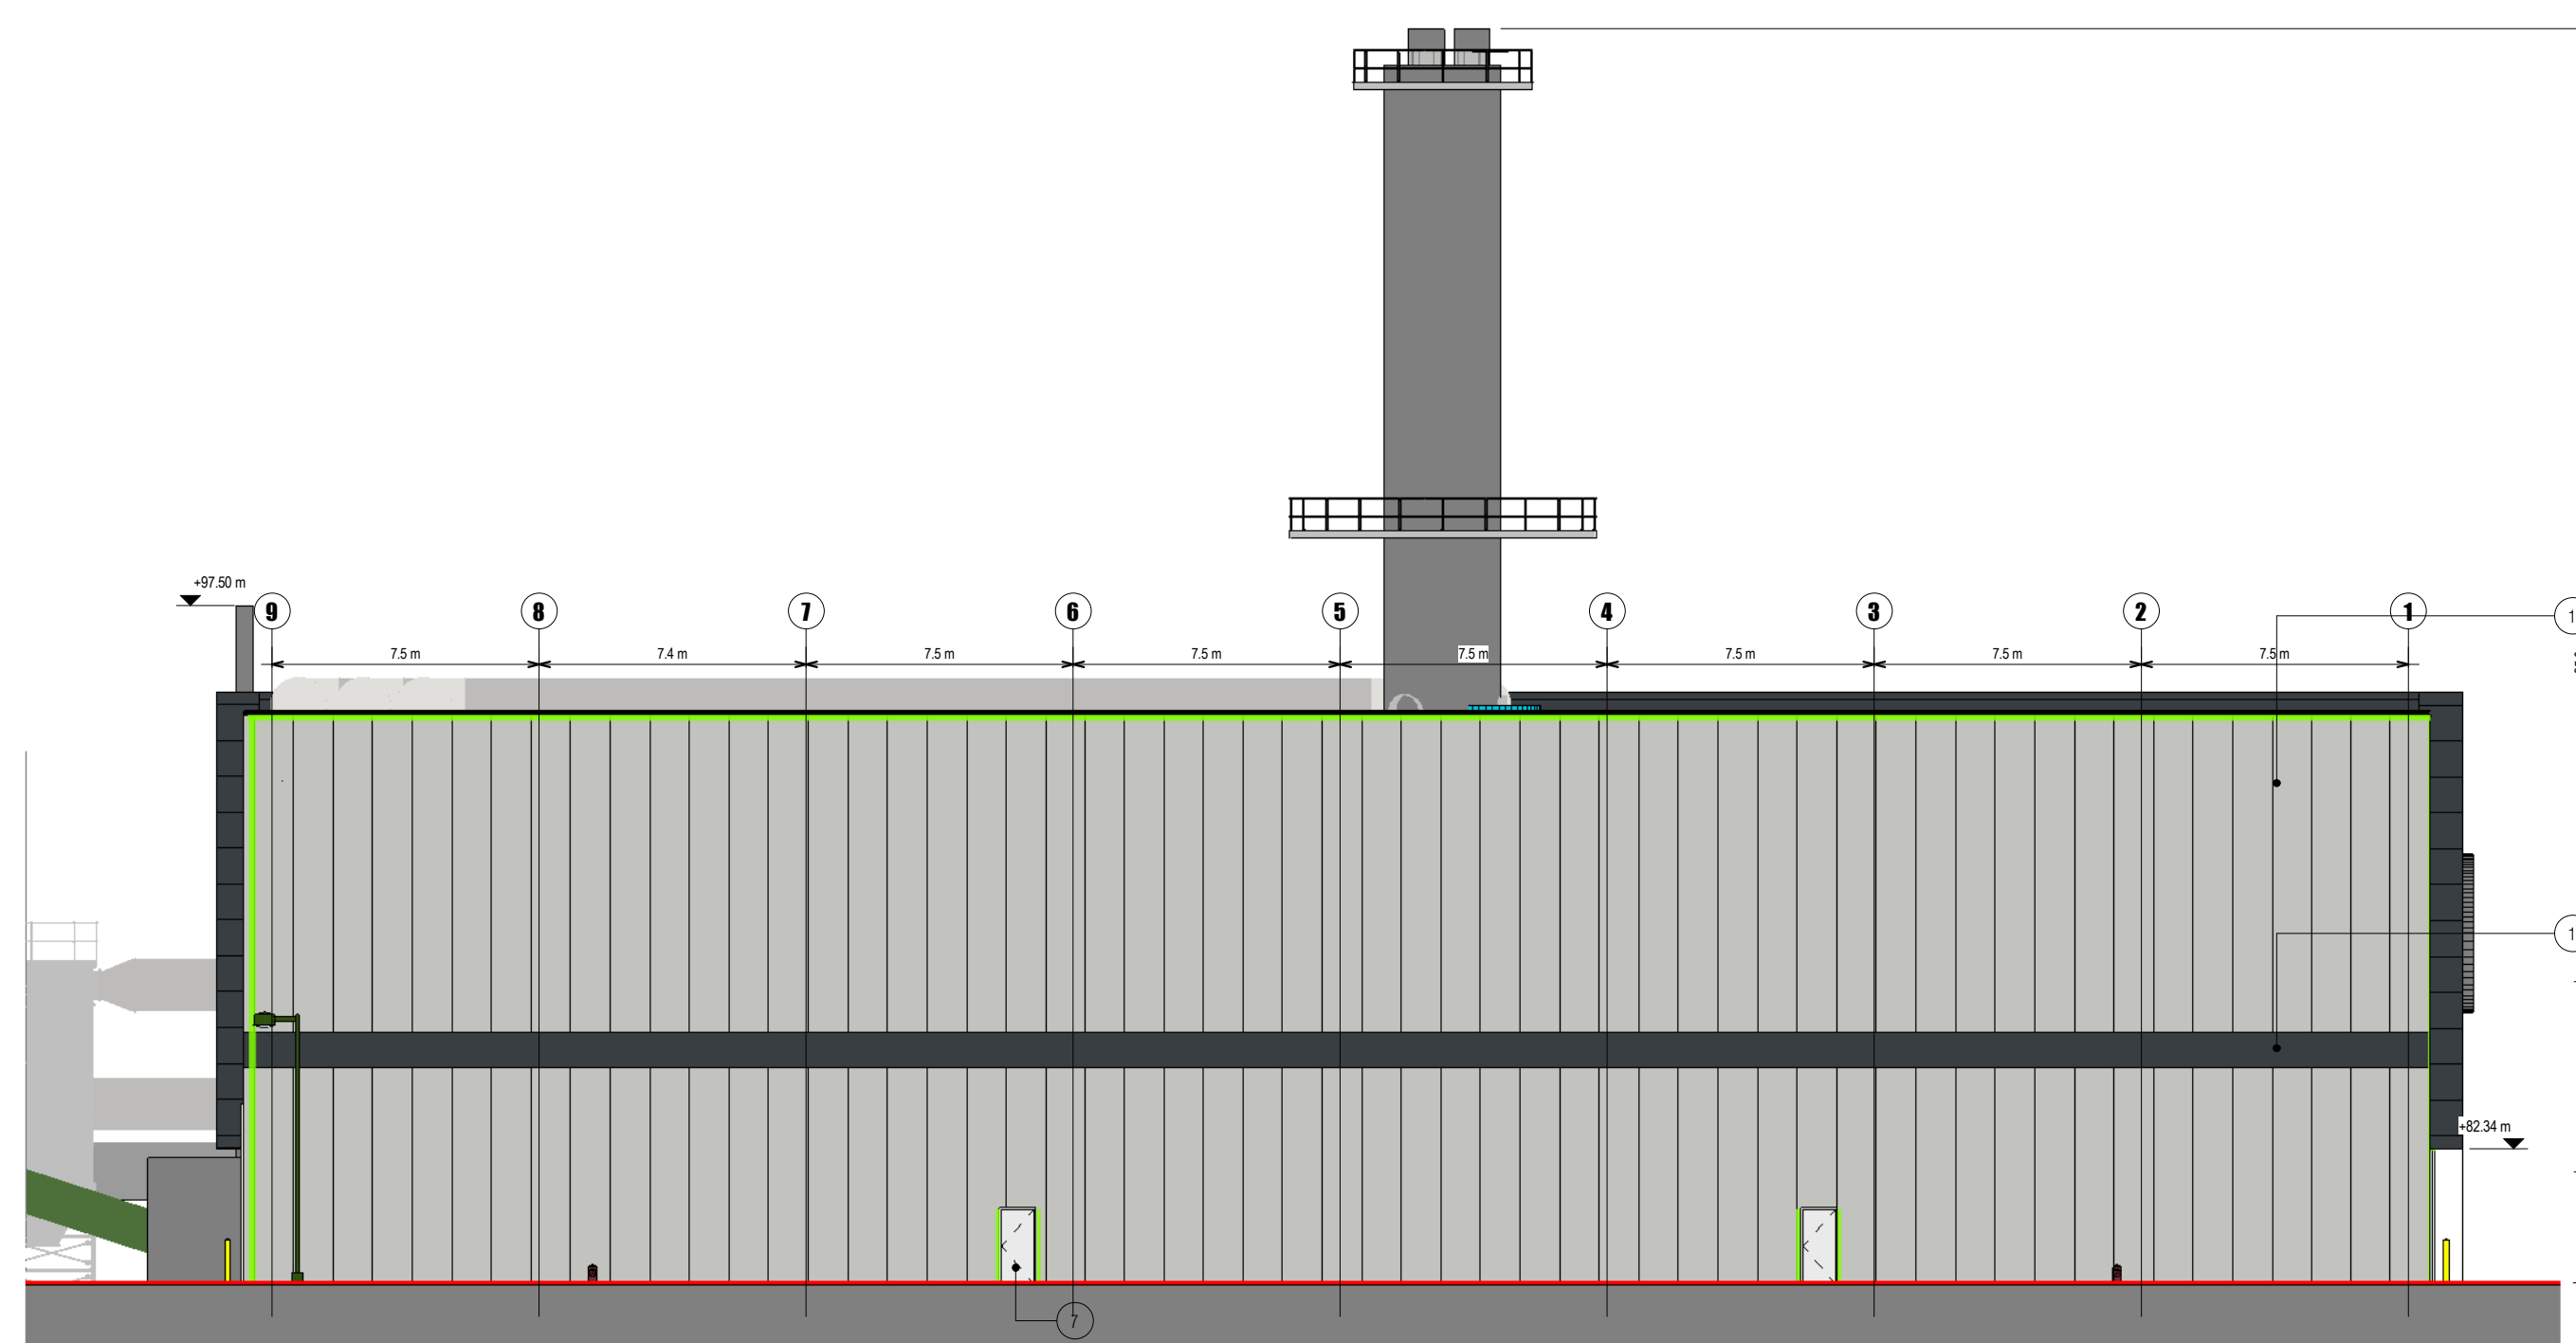

1 **East Elevation**  
1:200

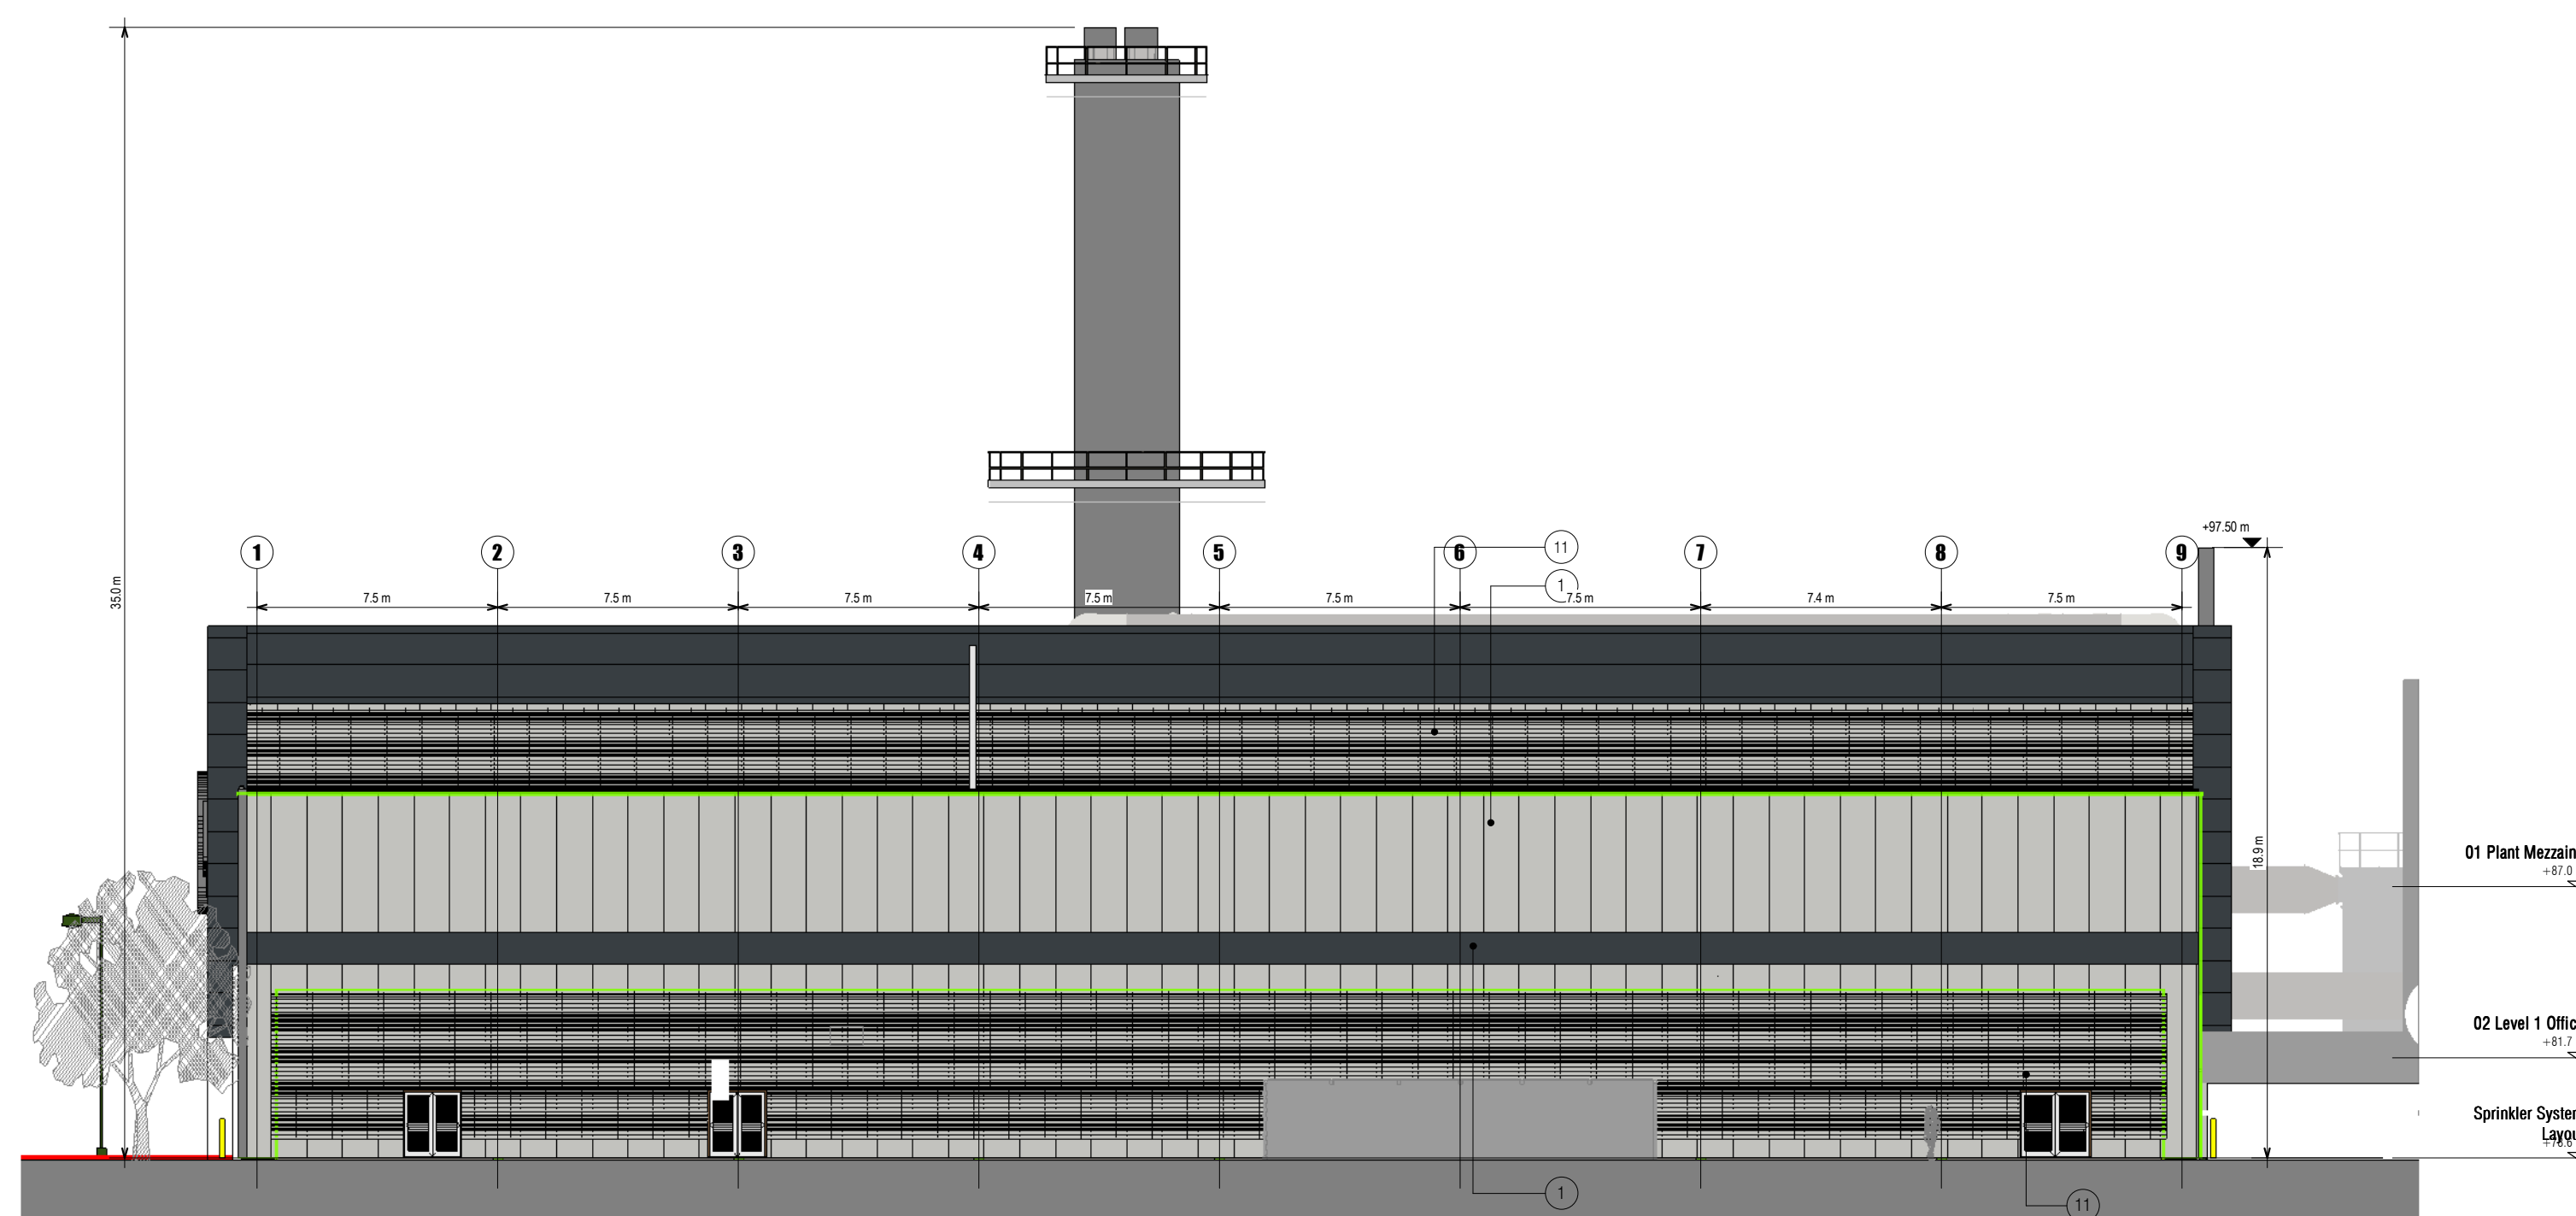

2 **West Elevation**  
1 : 200