



NOTES:


1. ALL DRAWINGS TO BE READ IN CONJUNCTION WITH THE SPECIFICATIONS AND ALL ENGINEERS AND ARCHITECTS DRAWINGS.
2. ALL DRAWINGS TO BE PRINTED IN COLOUR.
3. ALL DIMENSIONS IN mm UNLESS OTHERWISE STATED. NO DIMENSIONS SHALL BE SCALED FROM THE DRAWINGS.
4. THIS DRAWING IS FOR PLANNING PURPOSES ONLY.
5. MODULE EXTERNAL COLOUR: RAL 7026 MATT FINISH GREY

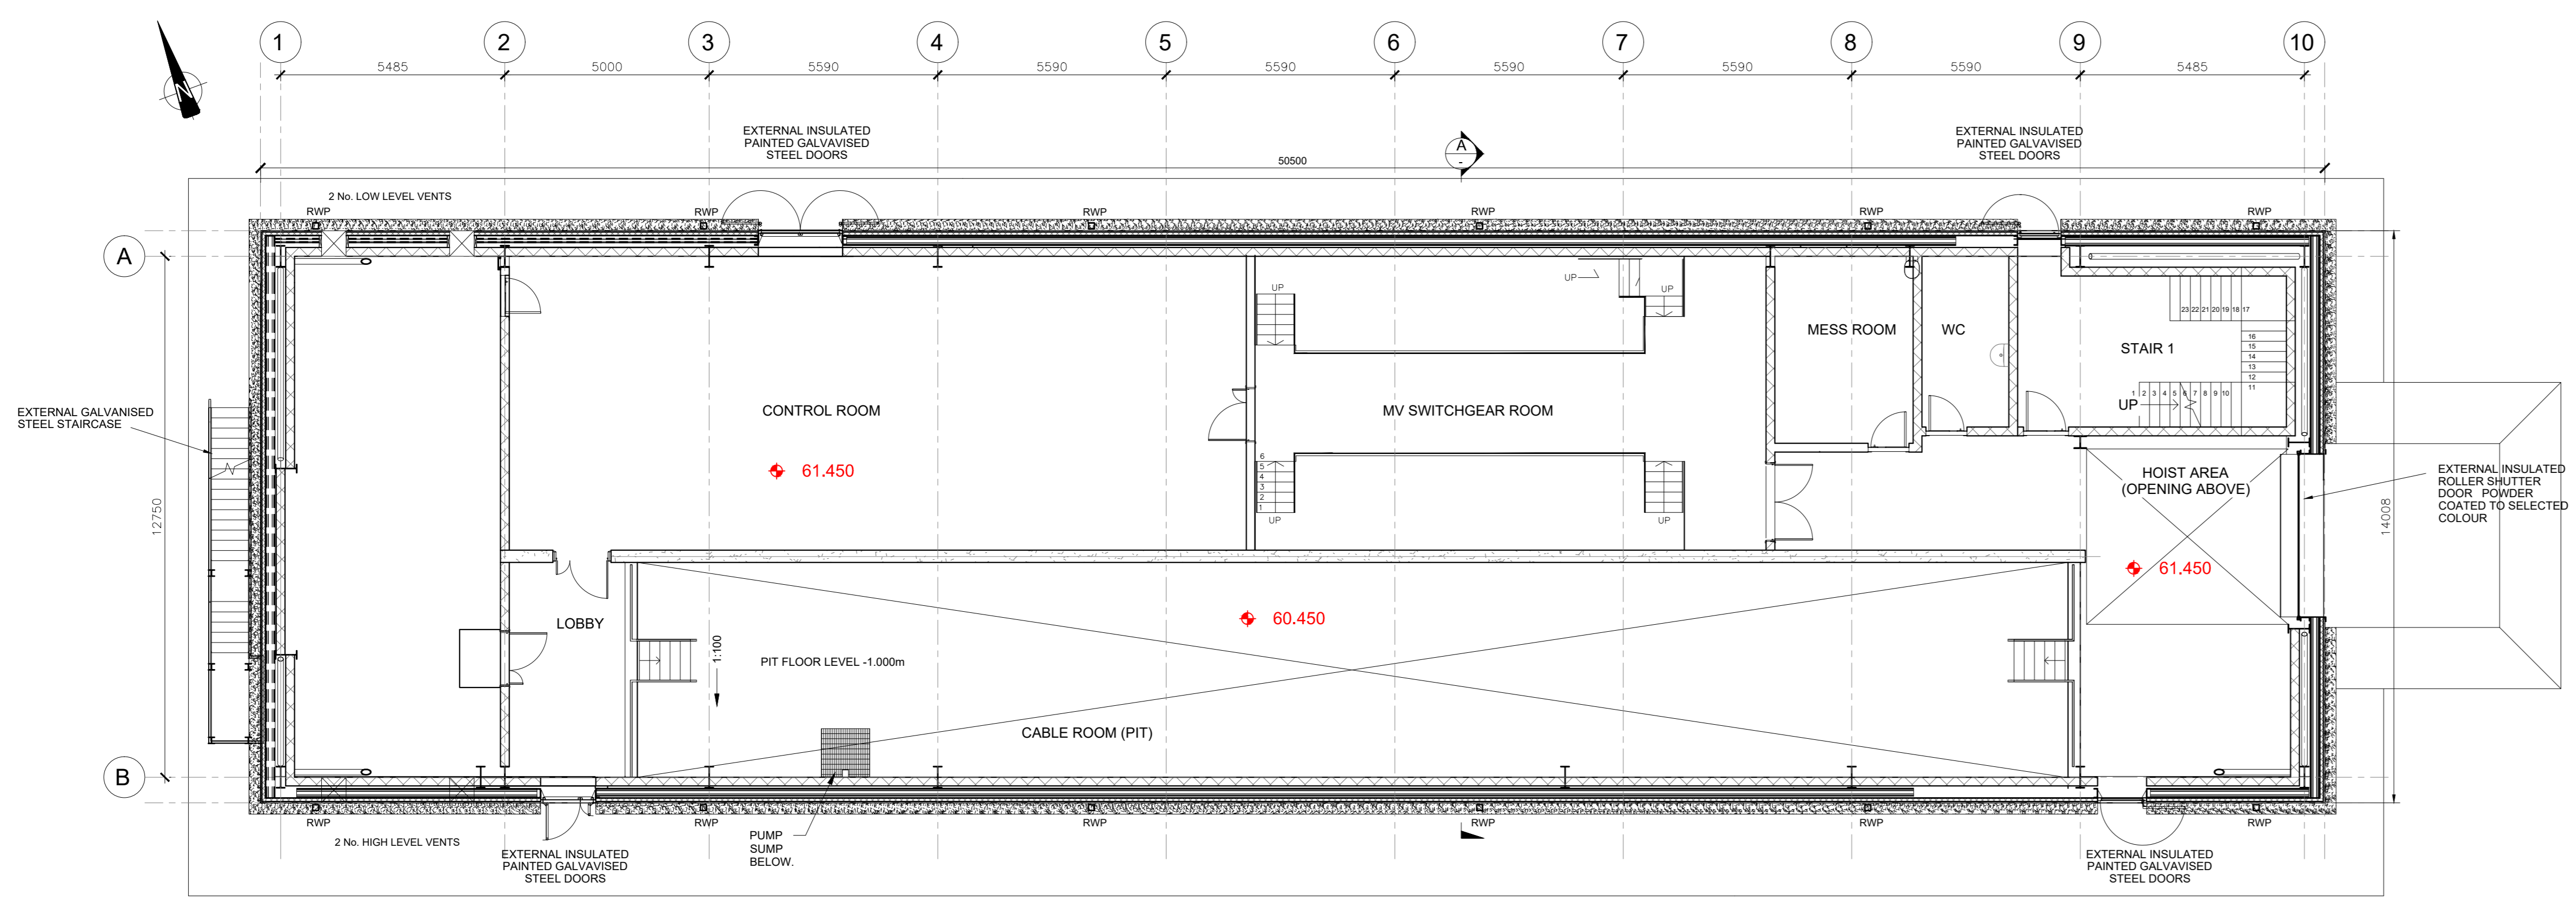


GROUND FLOOR PLAN
SCALE 1:100

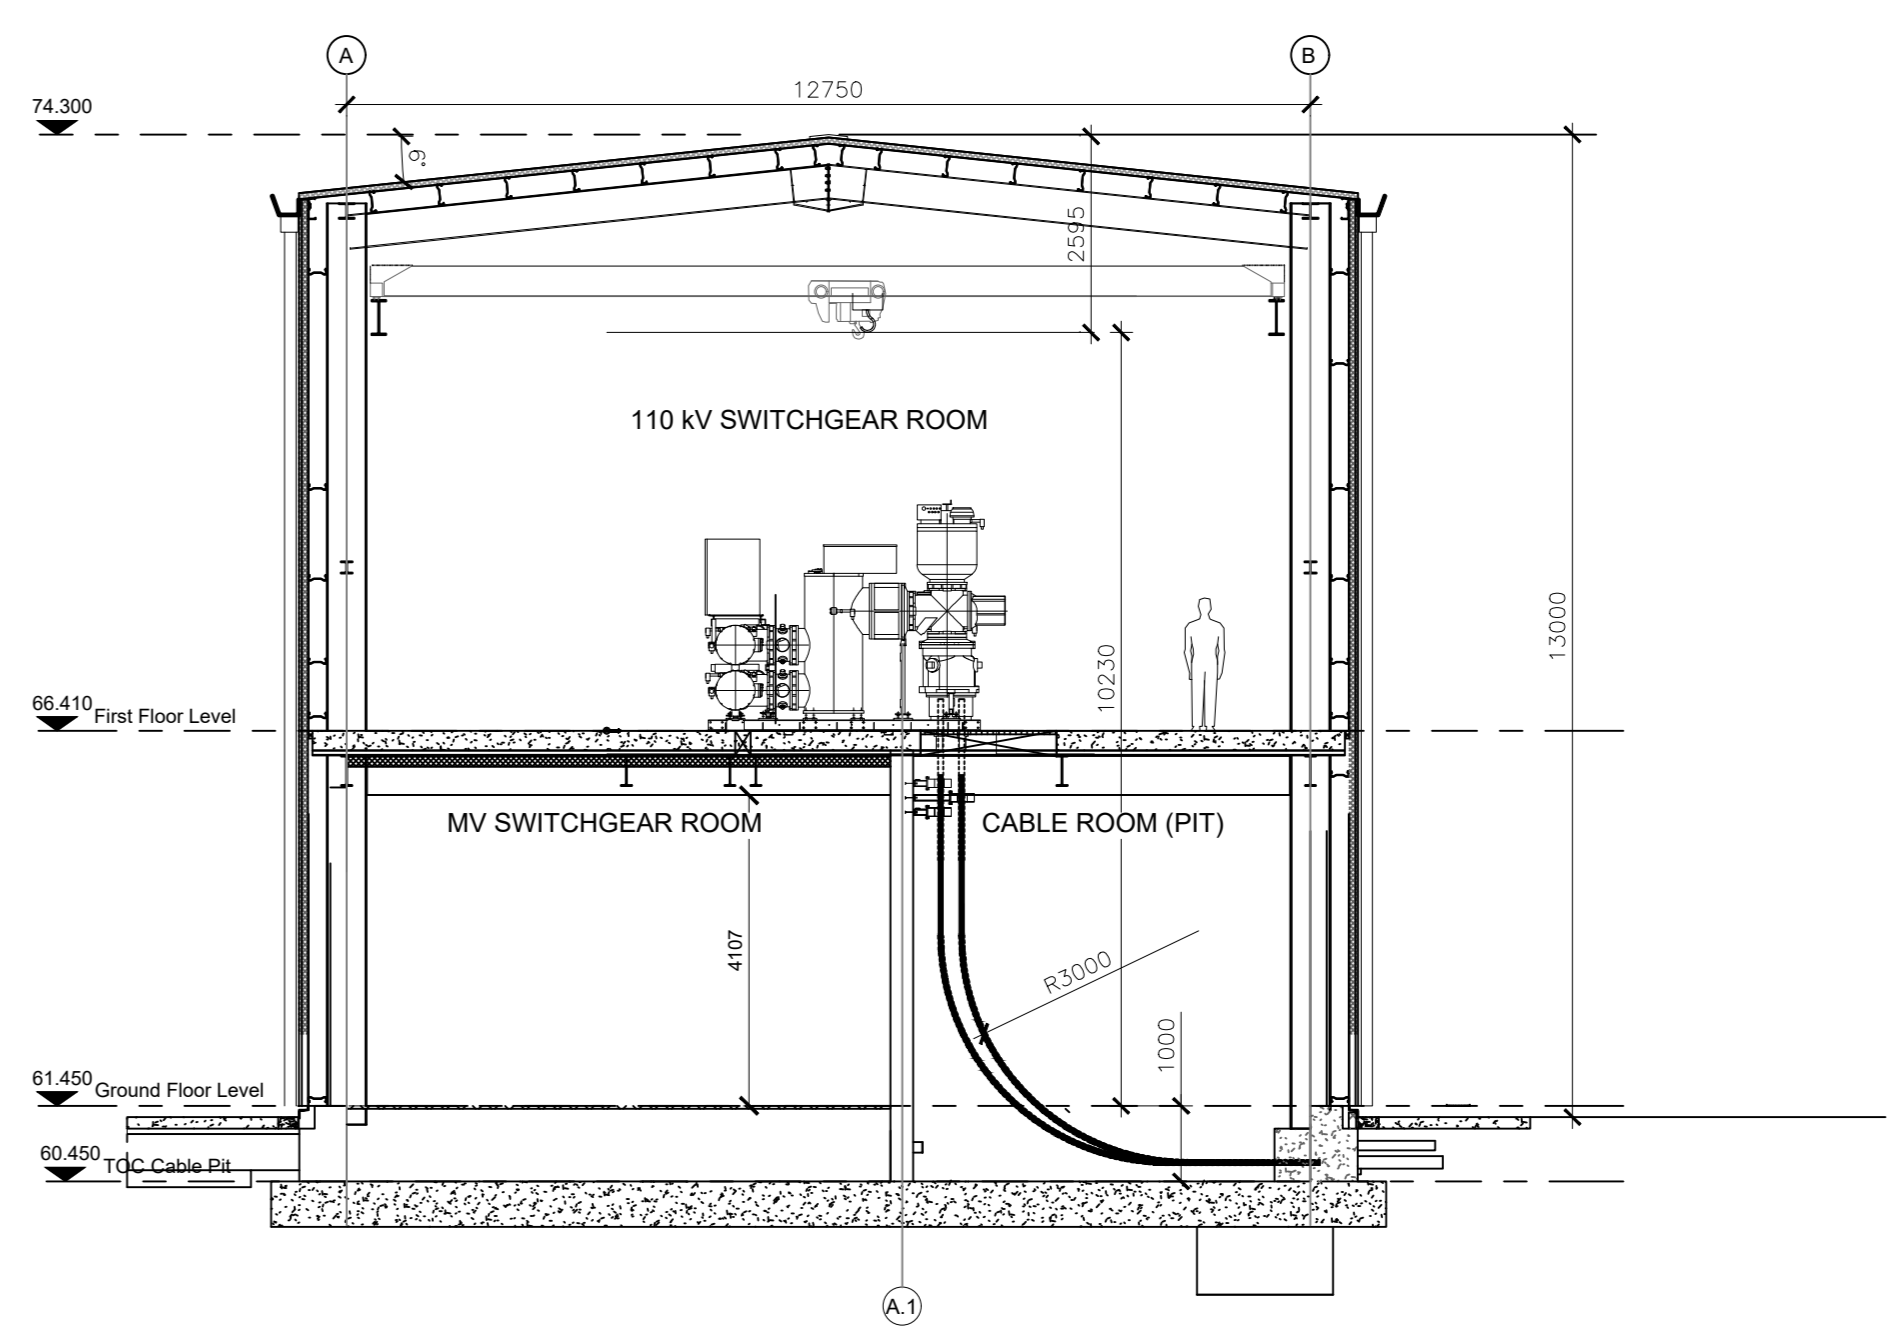


SECTION A-A
SCALE 1:100

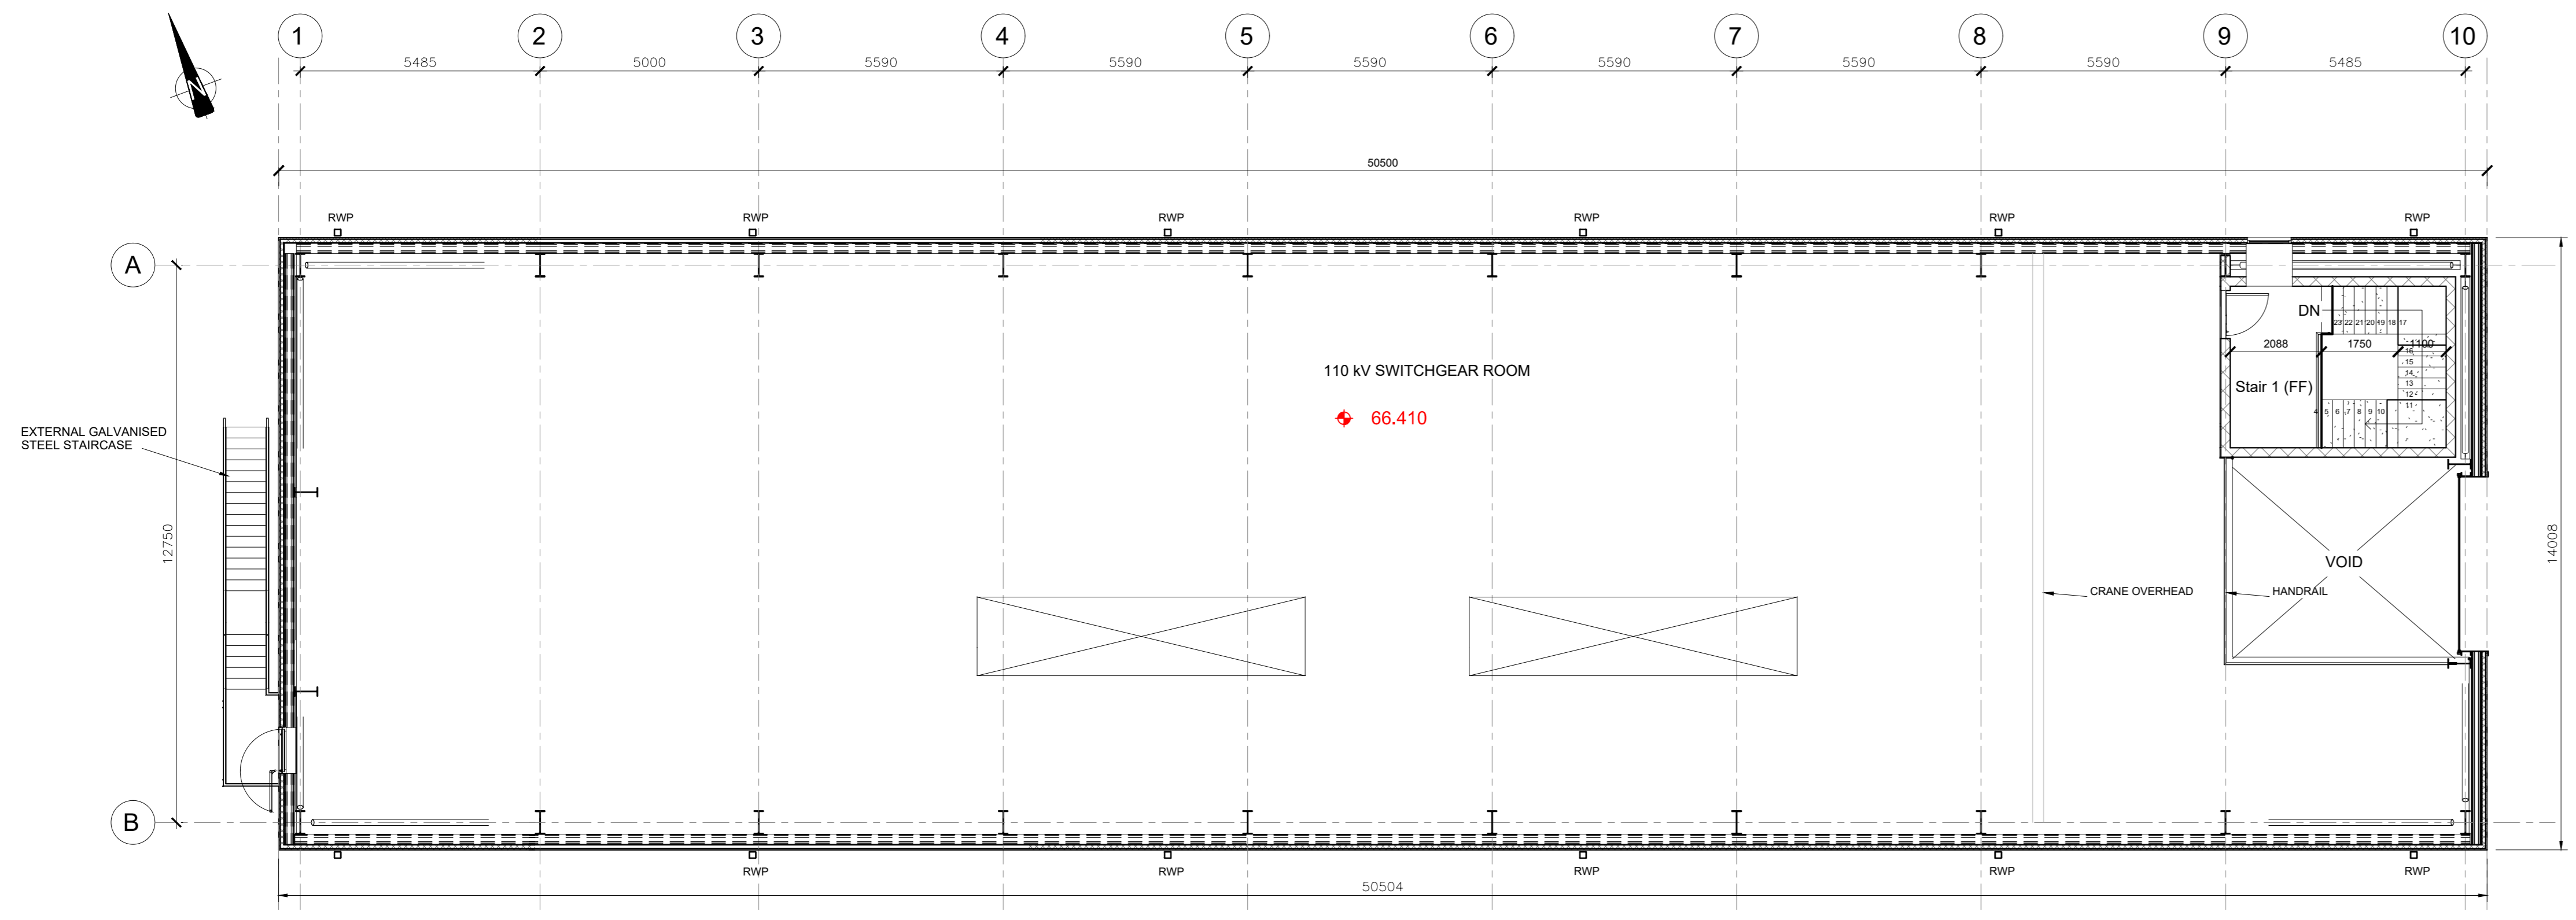

FIRST FLOOR PLAN
SCALE 1:100

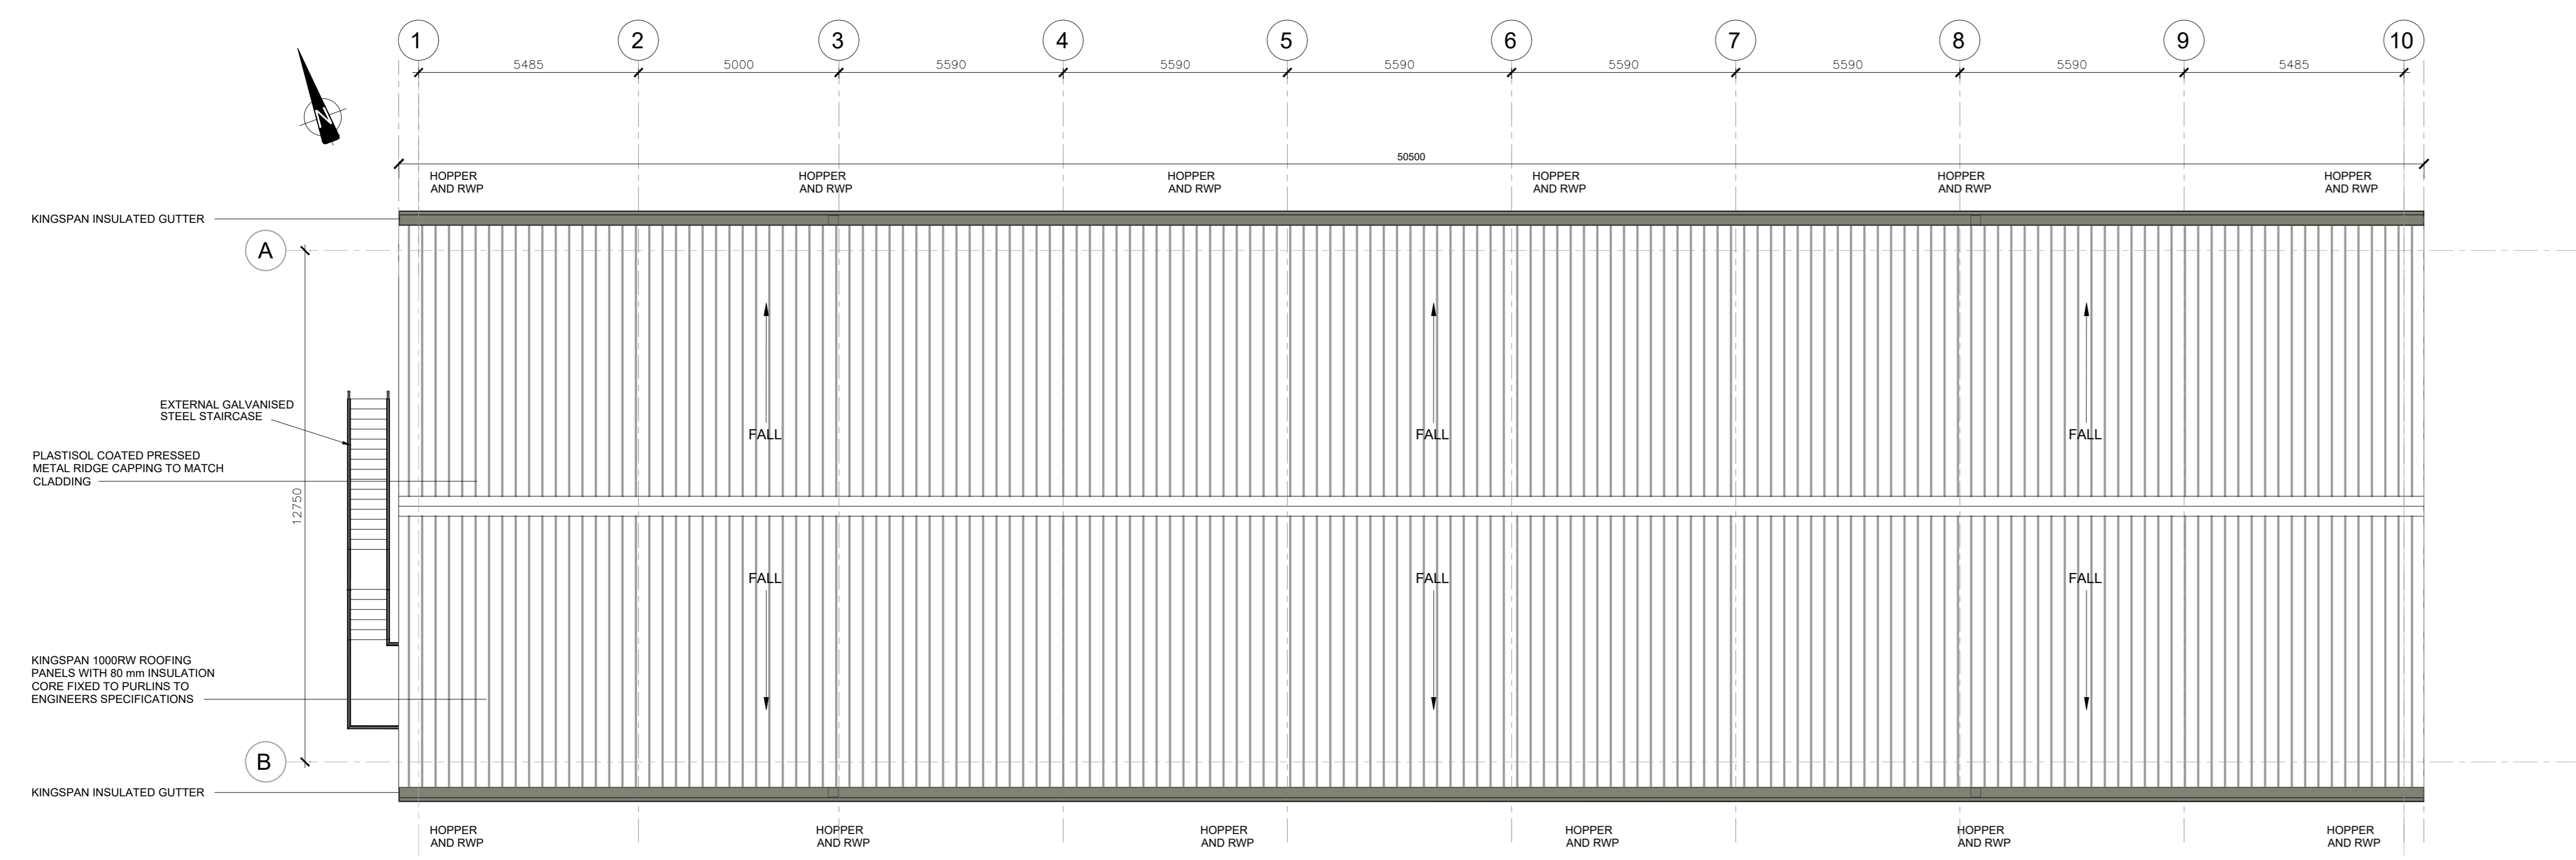

ROOF PLAN
SCALE 1:100

1	JULY 25	ISSUED FOR PLANNING							
0	JULY 25	ISSUED FOR REVIEW	JB	KP	LMM	SD			
REV	DATE	REVISION DESCRIPTION	DRN	PROJ	VER	VER	APP		
<small>COPYRIGHT © ESB ALL RIGHTS RESERVED. NO PART OF THIS FORM MAY BE REPRODUCED OR COPIED IN ANY FORM OR BY ANY MEANS - GRAPHIC, ELECTRONIC OR MECHANICAL, INCLUDING PHOTOCOPYING, RECORDING, TAPING OR USED FOR ANY PURPOSE OTHER THAN ITS DESIGNATED PURPOSE, WITHOUT THE WRITTEN PERMISSION OF ESB.</small>									
PURPOSE OF ISSUE: PRELIMINARY UNLESS INDICATED CLIENT APPROVAL: <input type="checkbox"/> PLANNING <input checked="" type="checkbox"/> TENDER <input type="checkbox"/> CONSTRUCTION <input type="checkbox"/> AS BUILT <input type="checkbox"/>									
CLIENT: ESB NETWORKS									
PROJECT: FOSTERTOWN 110kV SUBSTATION									
CONTRACT: I_TM0342B									
DRAWING TITLE: FOSTERTOWN 110kV SUBSTATION BUILDING PLANS & SECTION									
PRODUCTION UNIT: Transmission and Distribution Delivery									
 Engineering and Major Projects, One Dublin Airport Central, Dublin Airport, Cloughrue, Co. Dublin, IR17 4F7Z, Ireland Tel: +353 (0)1 703 8000 Web: www.esb.ie Engineering and Major Projects is a division of ESB.									
DRAWN	PRODUCED	VERIFIED 1	VERIFIED 2	APPROVED	APPROVAL DATE				
J. Byrne	J. Byrne	S. Connolly		R. O'Connell	24/07/2025				
CLIENT REF	TC202706	NO. OF SHEETS	1	SIZE	A0	SCALE	As Shown		
DRAWING NUMBER				SHEET		REV			
PE492-D282-016-006-001									