


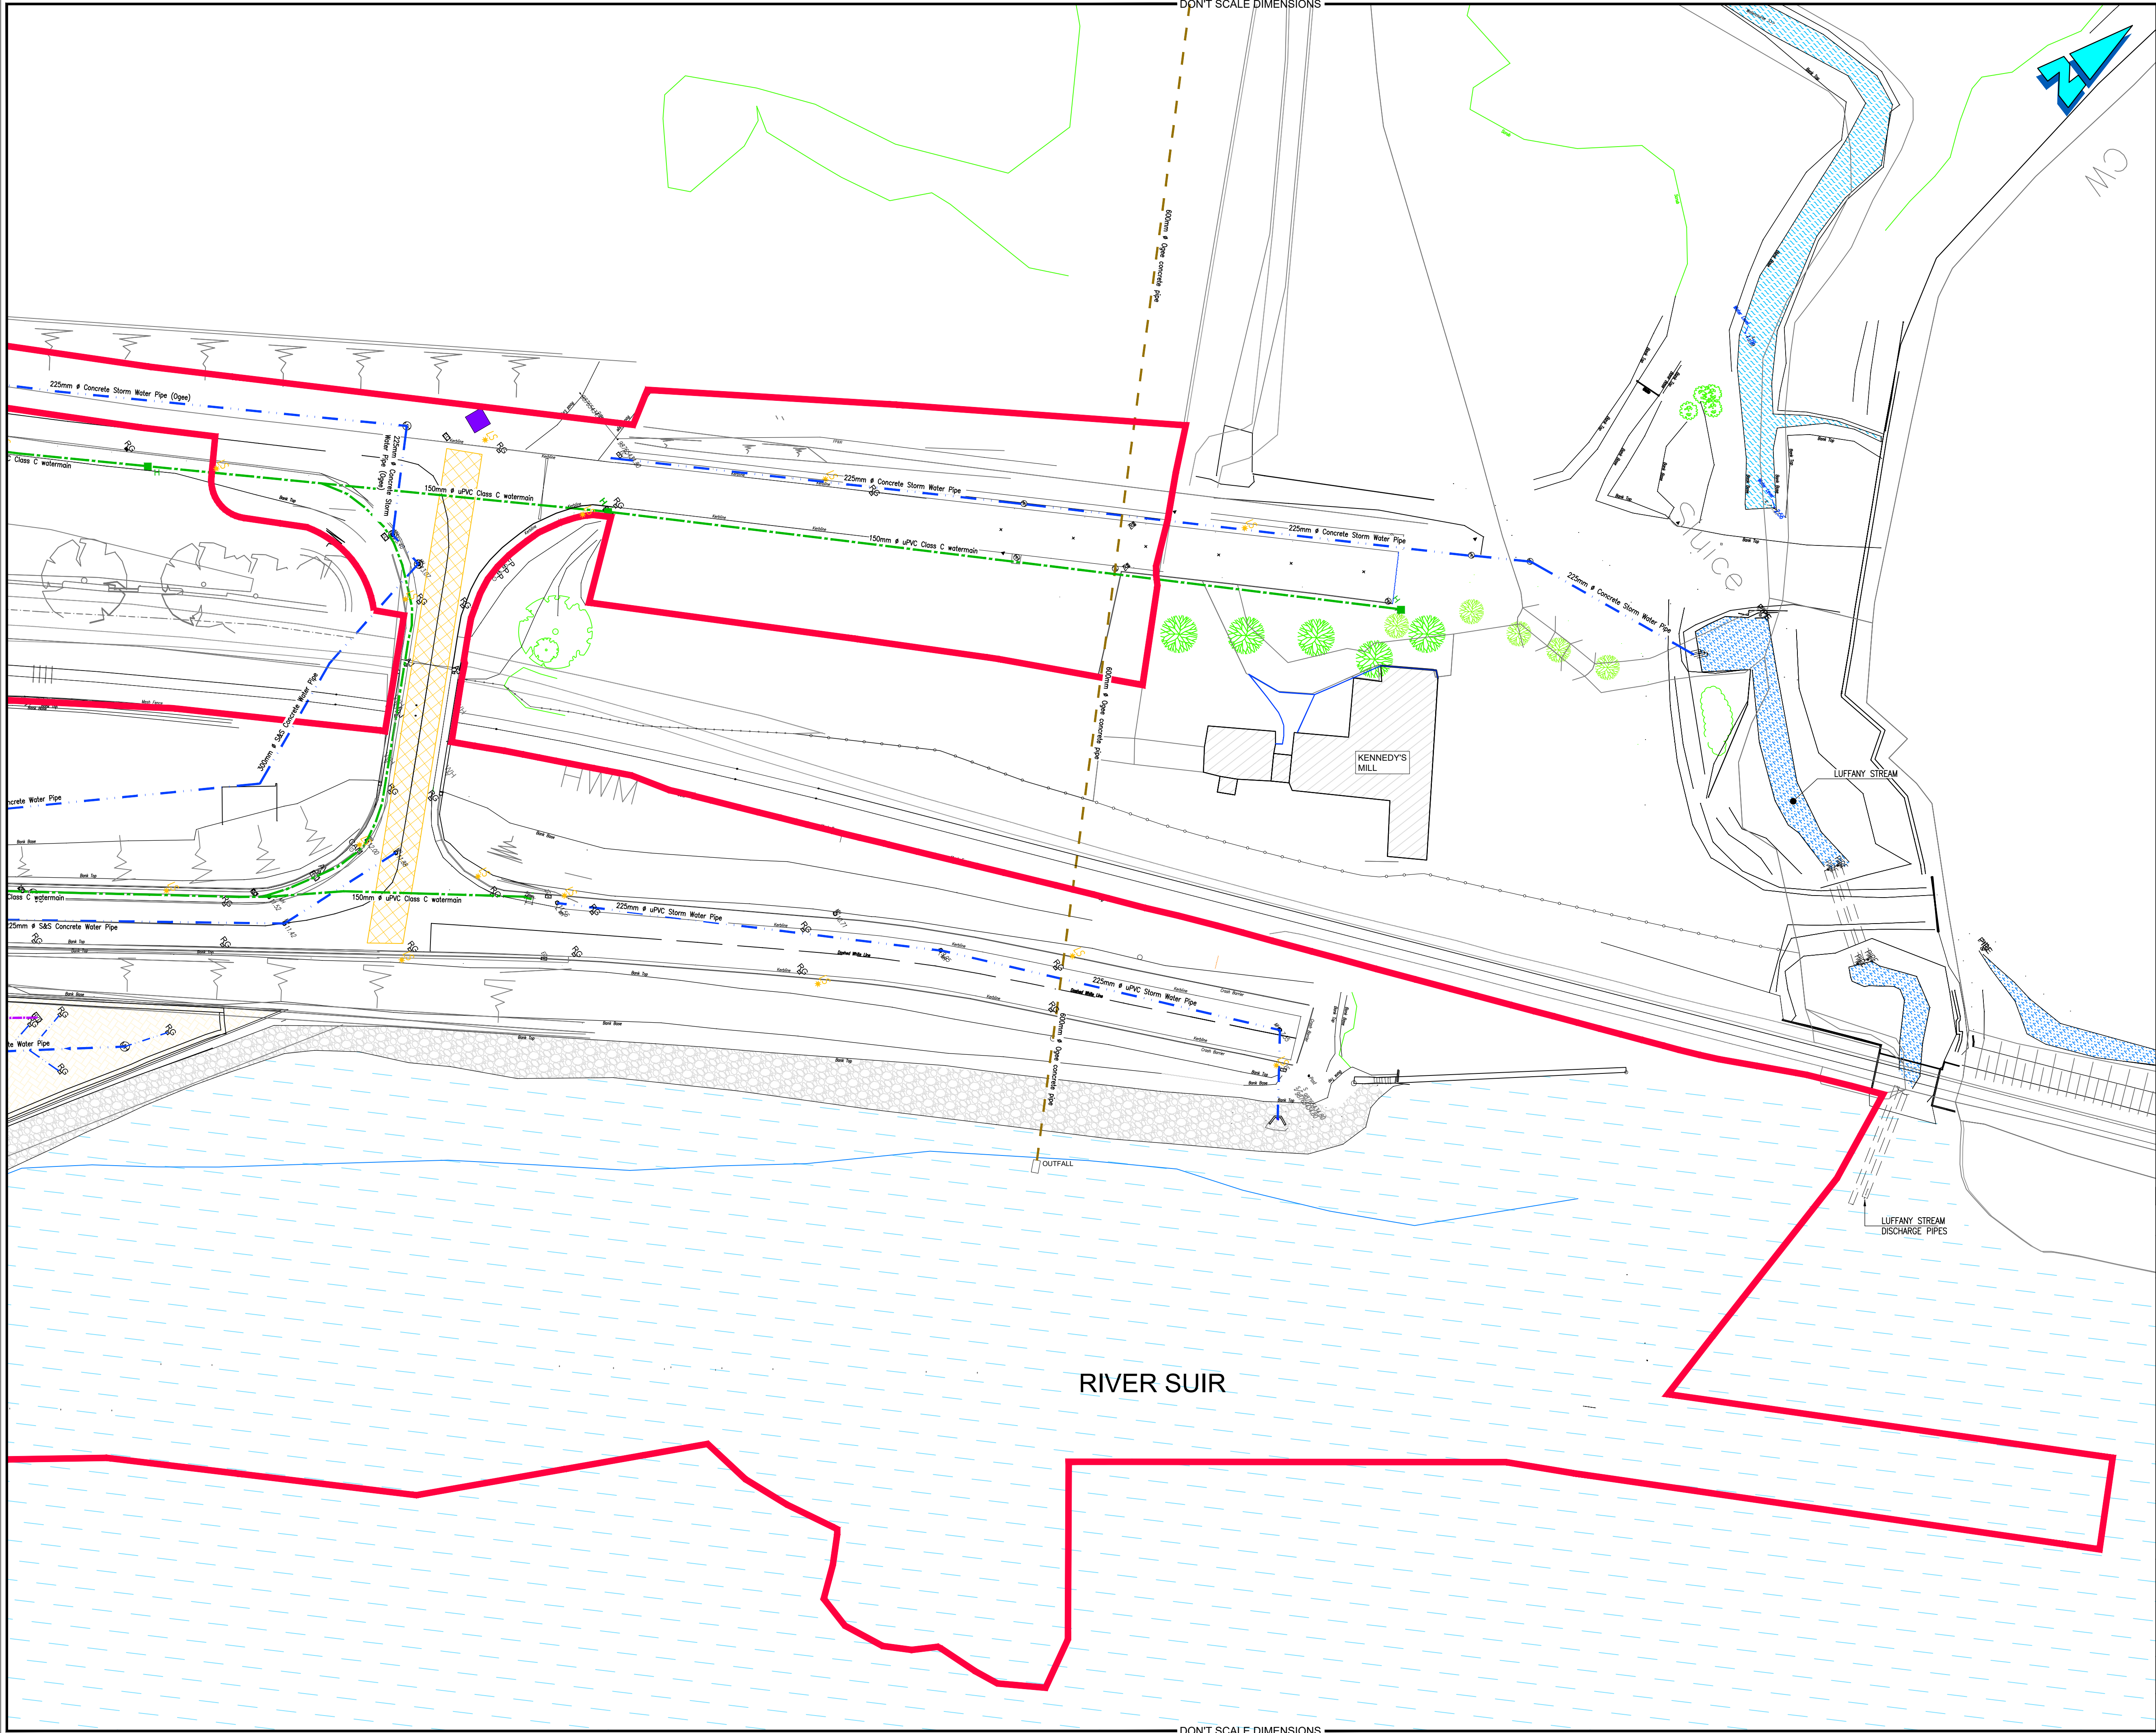

Health and Safety:

THIS DRAWING TO BE READ IN CONJUNCTION WITH ALL OTHER RELEVANT DRAWINGS, THE SPECIFICATION AND THE SAFETY AND HEALTH PLAN.

Note:

- NO PART OF THIS DRAWING MAY BE REPRODUCED OR TRANSMITTED IN ANY FORM OR STORED IN ANY RETRIEVAL SYSTEM OF ANY NATURE WITHOUT THE WRITTEN PERMISSION OF MALONE O'REGAN CONSULTING ENGINEERS AS COPYRIGHT HOLDER EXCEPT AS AGREED FOR USE ON THE PROJECT FOR WHICH THE DRAWING WAS ORIGINALLY ISSUED.
- ALL DIMENSIONS IN mm UNLESS NOTED OTHERWISE.
- ALL LEVELS ARE TO POOLBEG DATUM

LEGEND:

PROPOSED PLANNING OUTLINE
DENOTED THUS:

EXISTING STORM WATER DRAIN
DENOTED THUS: ---

EXISTING DRAINAGE FROM SMARTPLY SITE
DENOTED THUS: ---

EXISTING WATERMAIN
DENOTED THUS: ---

EXISTING FIREMAIN
DENOTED THUS: ---

0	PLANNING ISSUE	05.09.2025	JD	ES									
Rev.	Description	Date	Drawn	Chkd									
Status: P3 - ISSUED FOR PLANNING													
 MALONE O'REGAN CONSULTING ENGINEERS 3-4 Canada Street Waterford Co. Waterford. X91 V52K Tel: +353 51 876 855 Email: waterford@mor.ie Web: www.maloneoregan.com Offices also in: <table><tr><td>DUBLIN :</td><td>Tel: +353 1 260 2655</td><td>Email: dublin@mor.ie</td></tr><tr><td>GALWAY:</td><td>Tel: +353 91 531 069</td><td>Email: galway@mor.ie</td></tr><tr><td>LONDON:</td><td>Tel: +44 208 5281685</td><td>Email: london@mor.ie</td></tr></table>					DUBLIN :	Tel: +353 1 260 2655	Email: dublin@mor.ie	GALWAY:	Tel: +353 91 531 069	Email: galway@mor.ie	LONDON:	Tel: +44 208 5281685	Email: london@mor.ie
DUBLIN :	Tel: +353 1 260 2655	Email: dublin@mor.ie											
GALWAY:	Tel: +353 91 531 069	Email: galway@mor.ie											
LONDON:	Tel: +44 208 5281685	Email: london@mor.ie											
Client  PORT OF WATERFORD COMPANY													
Job PROPOSED OFFSHORE RENEWABLE ENERGY CAPABLE TERMINAL ON A 250m WHARF EXTENSION & ANCILLARY OPERATIONAL SUPPORT INFRASTRUCTURE													
Drawing EXISTING WATERMAIN & DRAINAGE LAYOUT SHEET 2													
Job No W20088	Revision 0	Approver ES	Scale A1 1:500 A3 1:1,000	Sheet A1									
Drg No W20088-XX-XXX-DR-MOR-CE-01208													

R:\2020\W20088\07_Design and Drawings\1 MOR\VL - Planning\250m Wharf Extension\Submission Drawings\W20088-XX-XXX-DR-MOR-CE-01207_01208 - Existing Watermain & Drainage Layouts.dwg