


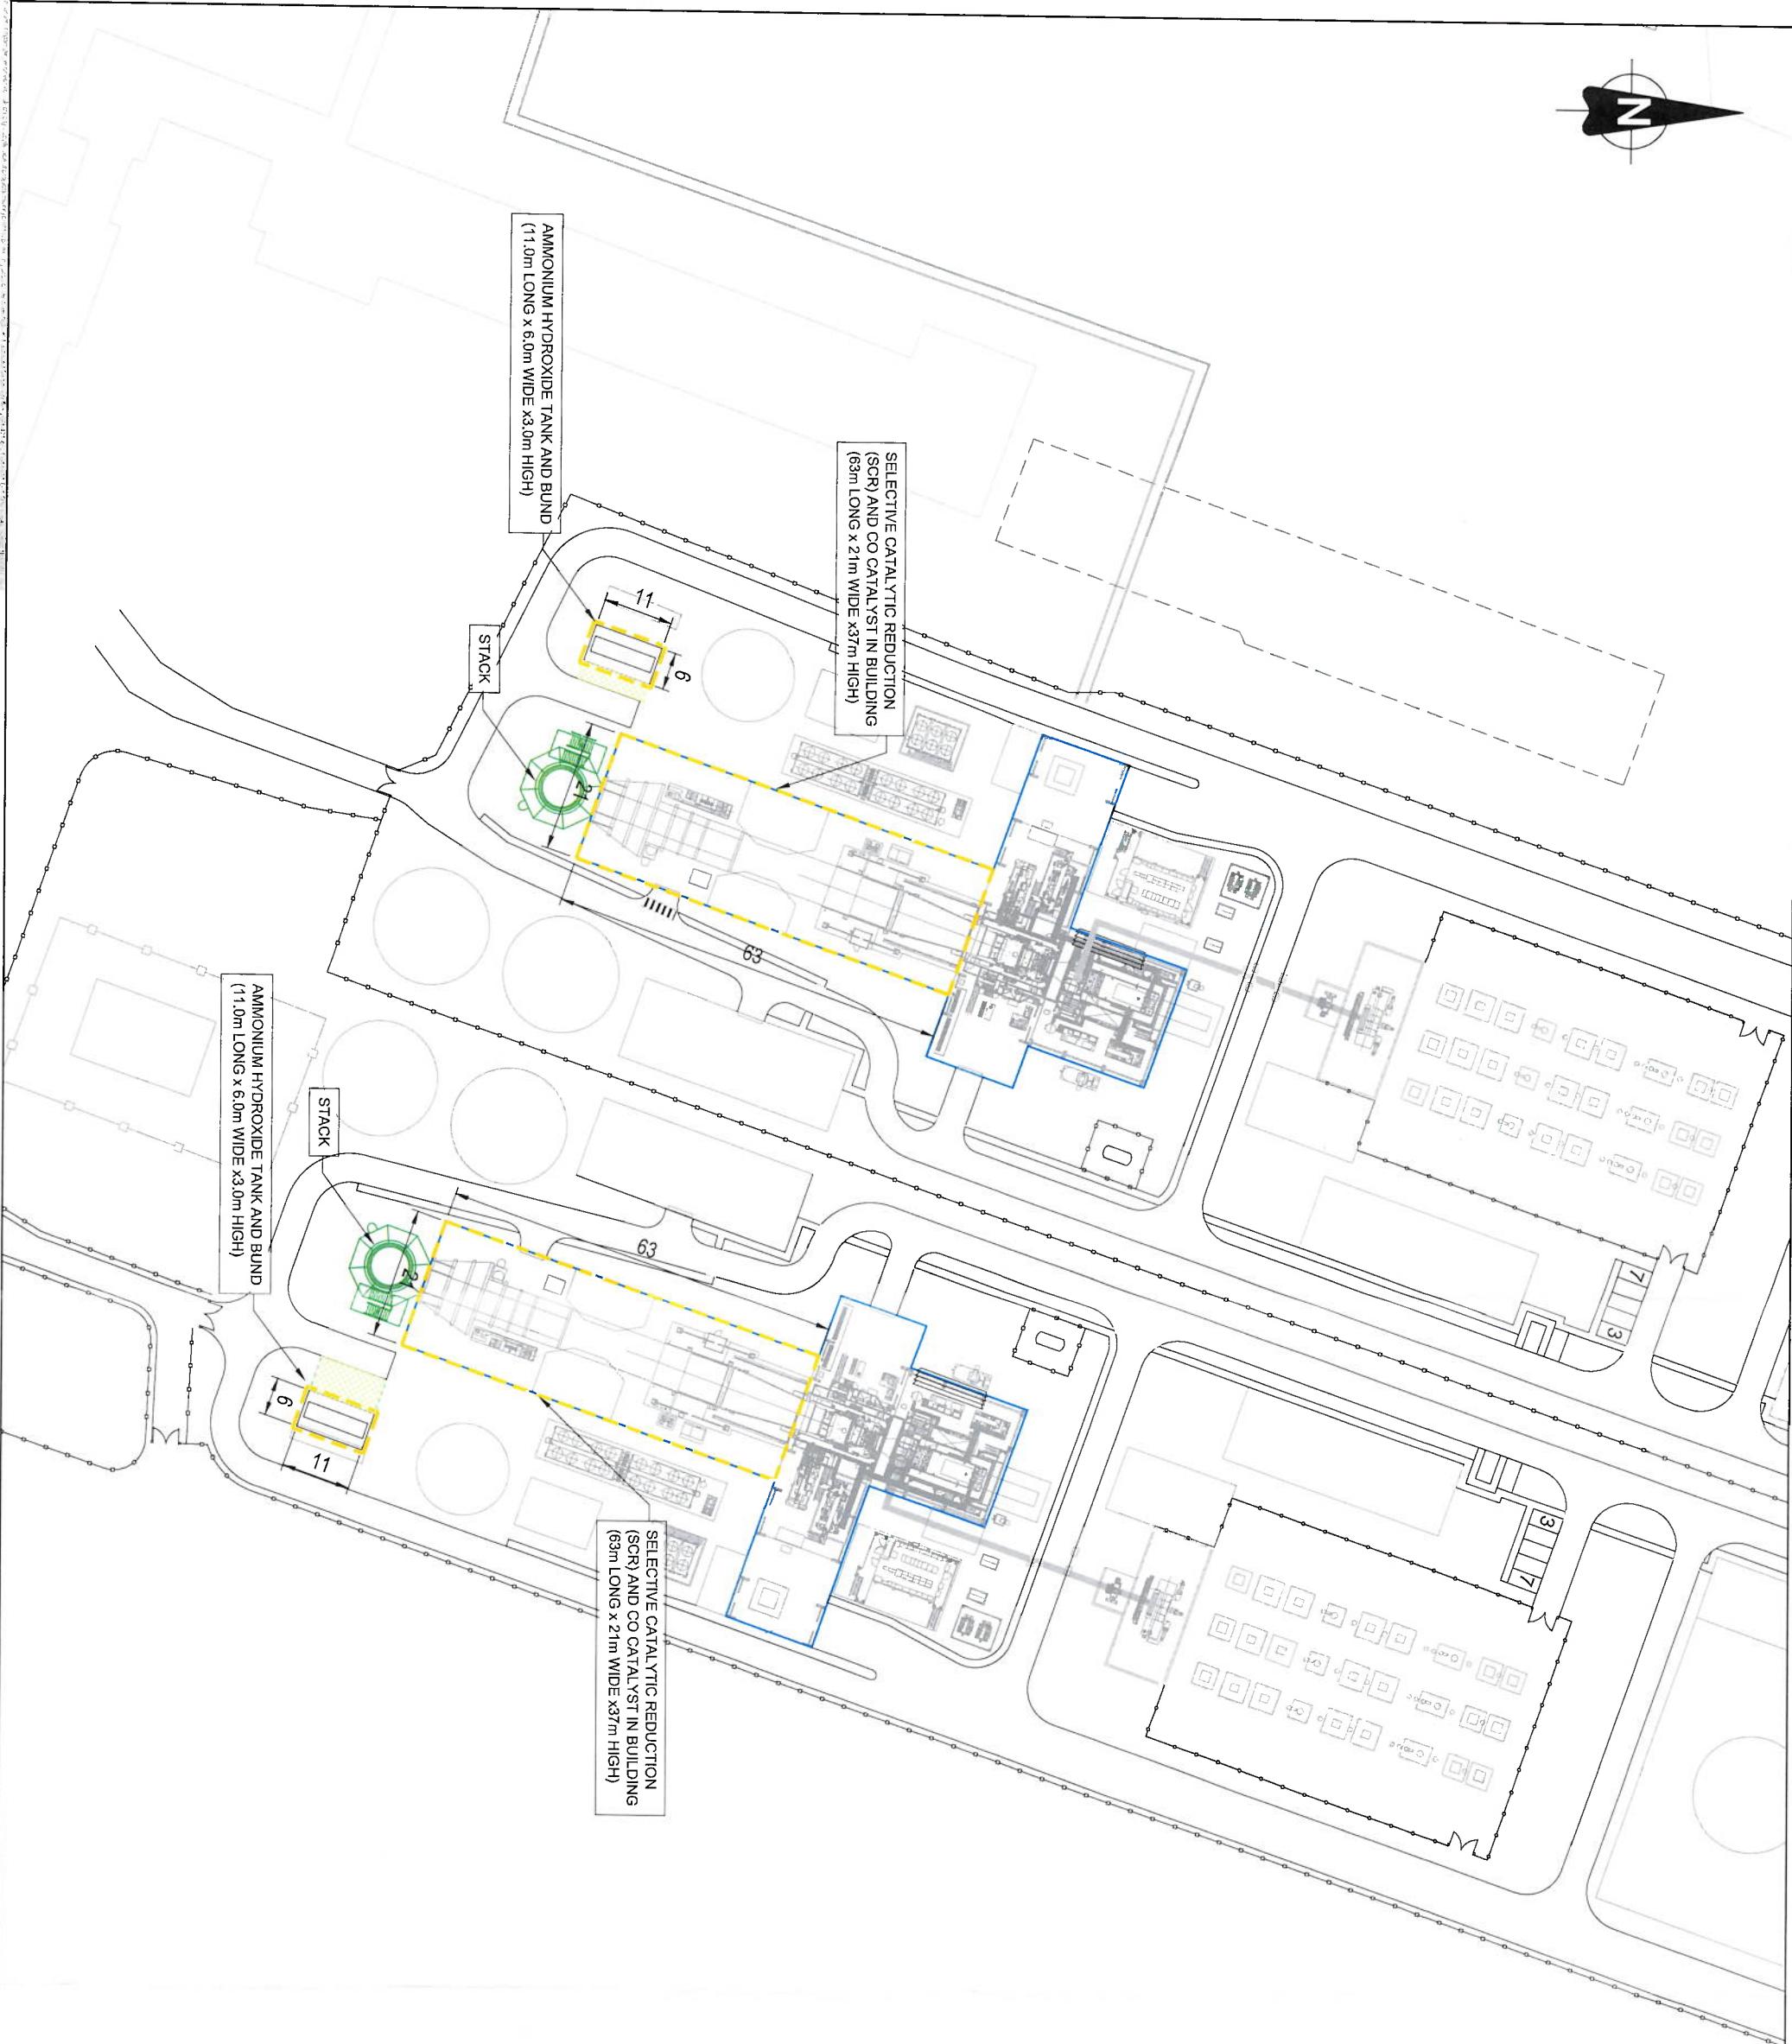

- NOTES:
- CO-ORDINATES TO ITM GRID.
 - LEVELS TO MAIN HEAD DATUM.
 - ALL DIMENSIONS ARE IN METERS. NO DIMENSIONS SHALL BE SCALED FROM THE DRAWINGS.
 - CO CATALYST WITHIN THE PROPOSED STACKFLUE.

PRELIM

CONCEPT LAYOUT

LEGEND	
	PERIMETER FENCE LINE
	HIGH VOLTAGE COMPOUND FENCE LINE
	ELEMENTS SUBJECT TO DESIGN FLEXIBILITY
	POWER PLANT BUILDING OUTLINE

Scale 1:500

THIS DRAWING UTILISES TALKIE EIREANN 11:000
SCALE VECTOR MAP SHEET NUMBERS 4789 & 4790

Talkie Eireann Licence No. CYA5044214 © Talkie Eireann - Surveying

REVISION INFORMATION		DATE	BY	CHKD	APPD
000	12.12.25	ISSUED FOR INFORMATION			
001	12.12.25	REVISION DESCRIPTION			
002	12.12.25	REVISION DESCRIPTION			
003	12.12.25	REVISION DESCRIPTION			
004	12.12.25	REVISION DESCRIPTION			
005	12.12.25	REVISION DESCRIPTION			
006	12.12.25	REVISION DESCRIPTION			
007	12.12.25	REVISION DESCRIPTION			
008	12.12.25	REVISION DESCRIPTION			
009	12.12.25	REVISION DESCRIPTION			
010	12.12.25	REVISION DESCRIPTION			

ALL RIGHTS RESERVED. NO PART OF THIS WORK MAY BE REPRODUCED OR COPIED IN ANY FORM OR BY ANY MEANS, ELECTRONIC OR MECHANICAL, INCLUDING PHOTOCOPYING, RECORDING, OR BY ANY INFORMATION STORAGE AND RETRIEVAL SYSTEM, WITHOUT THE WRITTEN PERMISSION OF ESB.

PURPOSE OF ISSUE - PRELIMINARY UNLESS INDICATED

CLIENT ☐ PLANNING ☐ TENDER ☐ CONSTRUCTION ☐ AS-BUILT ☐

CLIENT ☐ ESB GENERATION & TRADING

PROJECT ☐ MONEYPOINT REPOWERING

CONTRACT ☐

DRAWING TITLE ☐ DESIGN FLEXIBILITY REQUEST: SCENARIO 1, 2 & 3

PRODUCED FOR ☐ CIVIL, ENVIRONMENTAL & RENEWABLE ENGINEERING

Engineering and Major Projects
One Dublin Airport Central, Dublin Airport,
Cloughran, Co. Dublin, K67 XFR2, Ireland.
Tel: +353 (0)1 703 3000. [Web: www.esb.ie](http://www.esb.ie)

Energy for generations
Engineering and Major Projects is a division of ESB

DRAWN	PRODUCED	APPROVED	APPROVAL DATE
W. McGarrigle	J. Greene	J. Greene	Sep 2025
CLIENT REF	NO. OF SHEETS	SIZE	SCALE
	1	A1	1:500

DRAWING NUMBER	SHEET	REV
P000471-CE21-04-0001-001-000		



- NOTES:
1. CO-ORDINATES TO ITM GRID.
 2. LEVELS TO MAIN HEAD DATUM.
 3. ALL DIMENSIONS ARE IN METERS. NO DIMENSIONS SHALL BE SCALED FROM THE DRAWINGS.

PRELIM

CONCEPT LAYOUT

LEGEND
PERIMETER FENCE LINE
HIGH VOLTAGE COMPOUND FENCE LINE
POWER PLANT BUILDING OUTLINE

Scale 1:500

0 10 20 50

THIS DRAWING UTILISES TALLTE EIREANN 1:1000
SCALE VECTOR MAP SHEET NUMBERS 4788 & 4790

Tallte Eireann Licence No. CYAUS04514 © Tallte Eireann - Surveying

NO.	12.09.21	ISSUED FOR INFORMATION	WKG	JS	JH	JS
REV.	DATE	REVISION DESCRIPTION	DRN	PRD	VER	APP
COPYRIGHT © ESB						
ALL RIGHTS RESERVED. NO PART OF THIS WORK MAY BE REPRODUCED, STORED IN A RETRIEVABLE SYSTEM, TRANSMITTED, OR BY ANY MEANS, ELECTRONIC OR MECHANICAL, INCLUDING PHOTOCOPYING, RECORDING, OR BY ANY INFORMATION STORAGE AND RETRIEVAL SYSTEM, WITHOUT THE WRITTEN PERMISSION OF ESB.						

PURPOSE OF ISSUE - PRELIMINARY UNLESS INDICATED

CLIENT ☐ PLANNING ☐ TENDER ☐ CONSTRUCTION ☐ AS-BUILT ☐

PROJECT ☐ ESB GENERATION & TRADING

PROJECT MONEYPOINT REPOWERING

CONTRACT

DRAWING TITLE

DESIGN FLEXIBILITY REQUEST:
SCENARIO 4



Engineering and Major Projects
One Dublin Airport Central, Dublin Airport,
Cloghran, Co. Dublin, K67 XFT2, Ireland.
Tel: +353 (0)1 715 8000 Web: www.esb.ie
Engineering and Major Projects is a division of ESB

DRAWN	PRODUCED	VERIFIED	APPROVED	APPROVAL DATE
W. McLaughlin	J. Heaverty	J. Heaverty	J. Greene	Sep 2024
CLIENT REF	NO. OF SHEETS	SIZE	SCALE	
	1	A1	1:500	

DRAWING NUMBER P000471-CE21-04-0002-001-000