


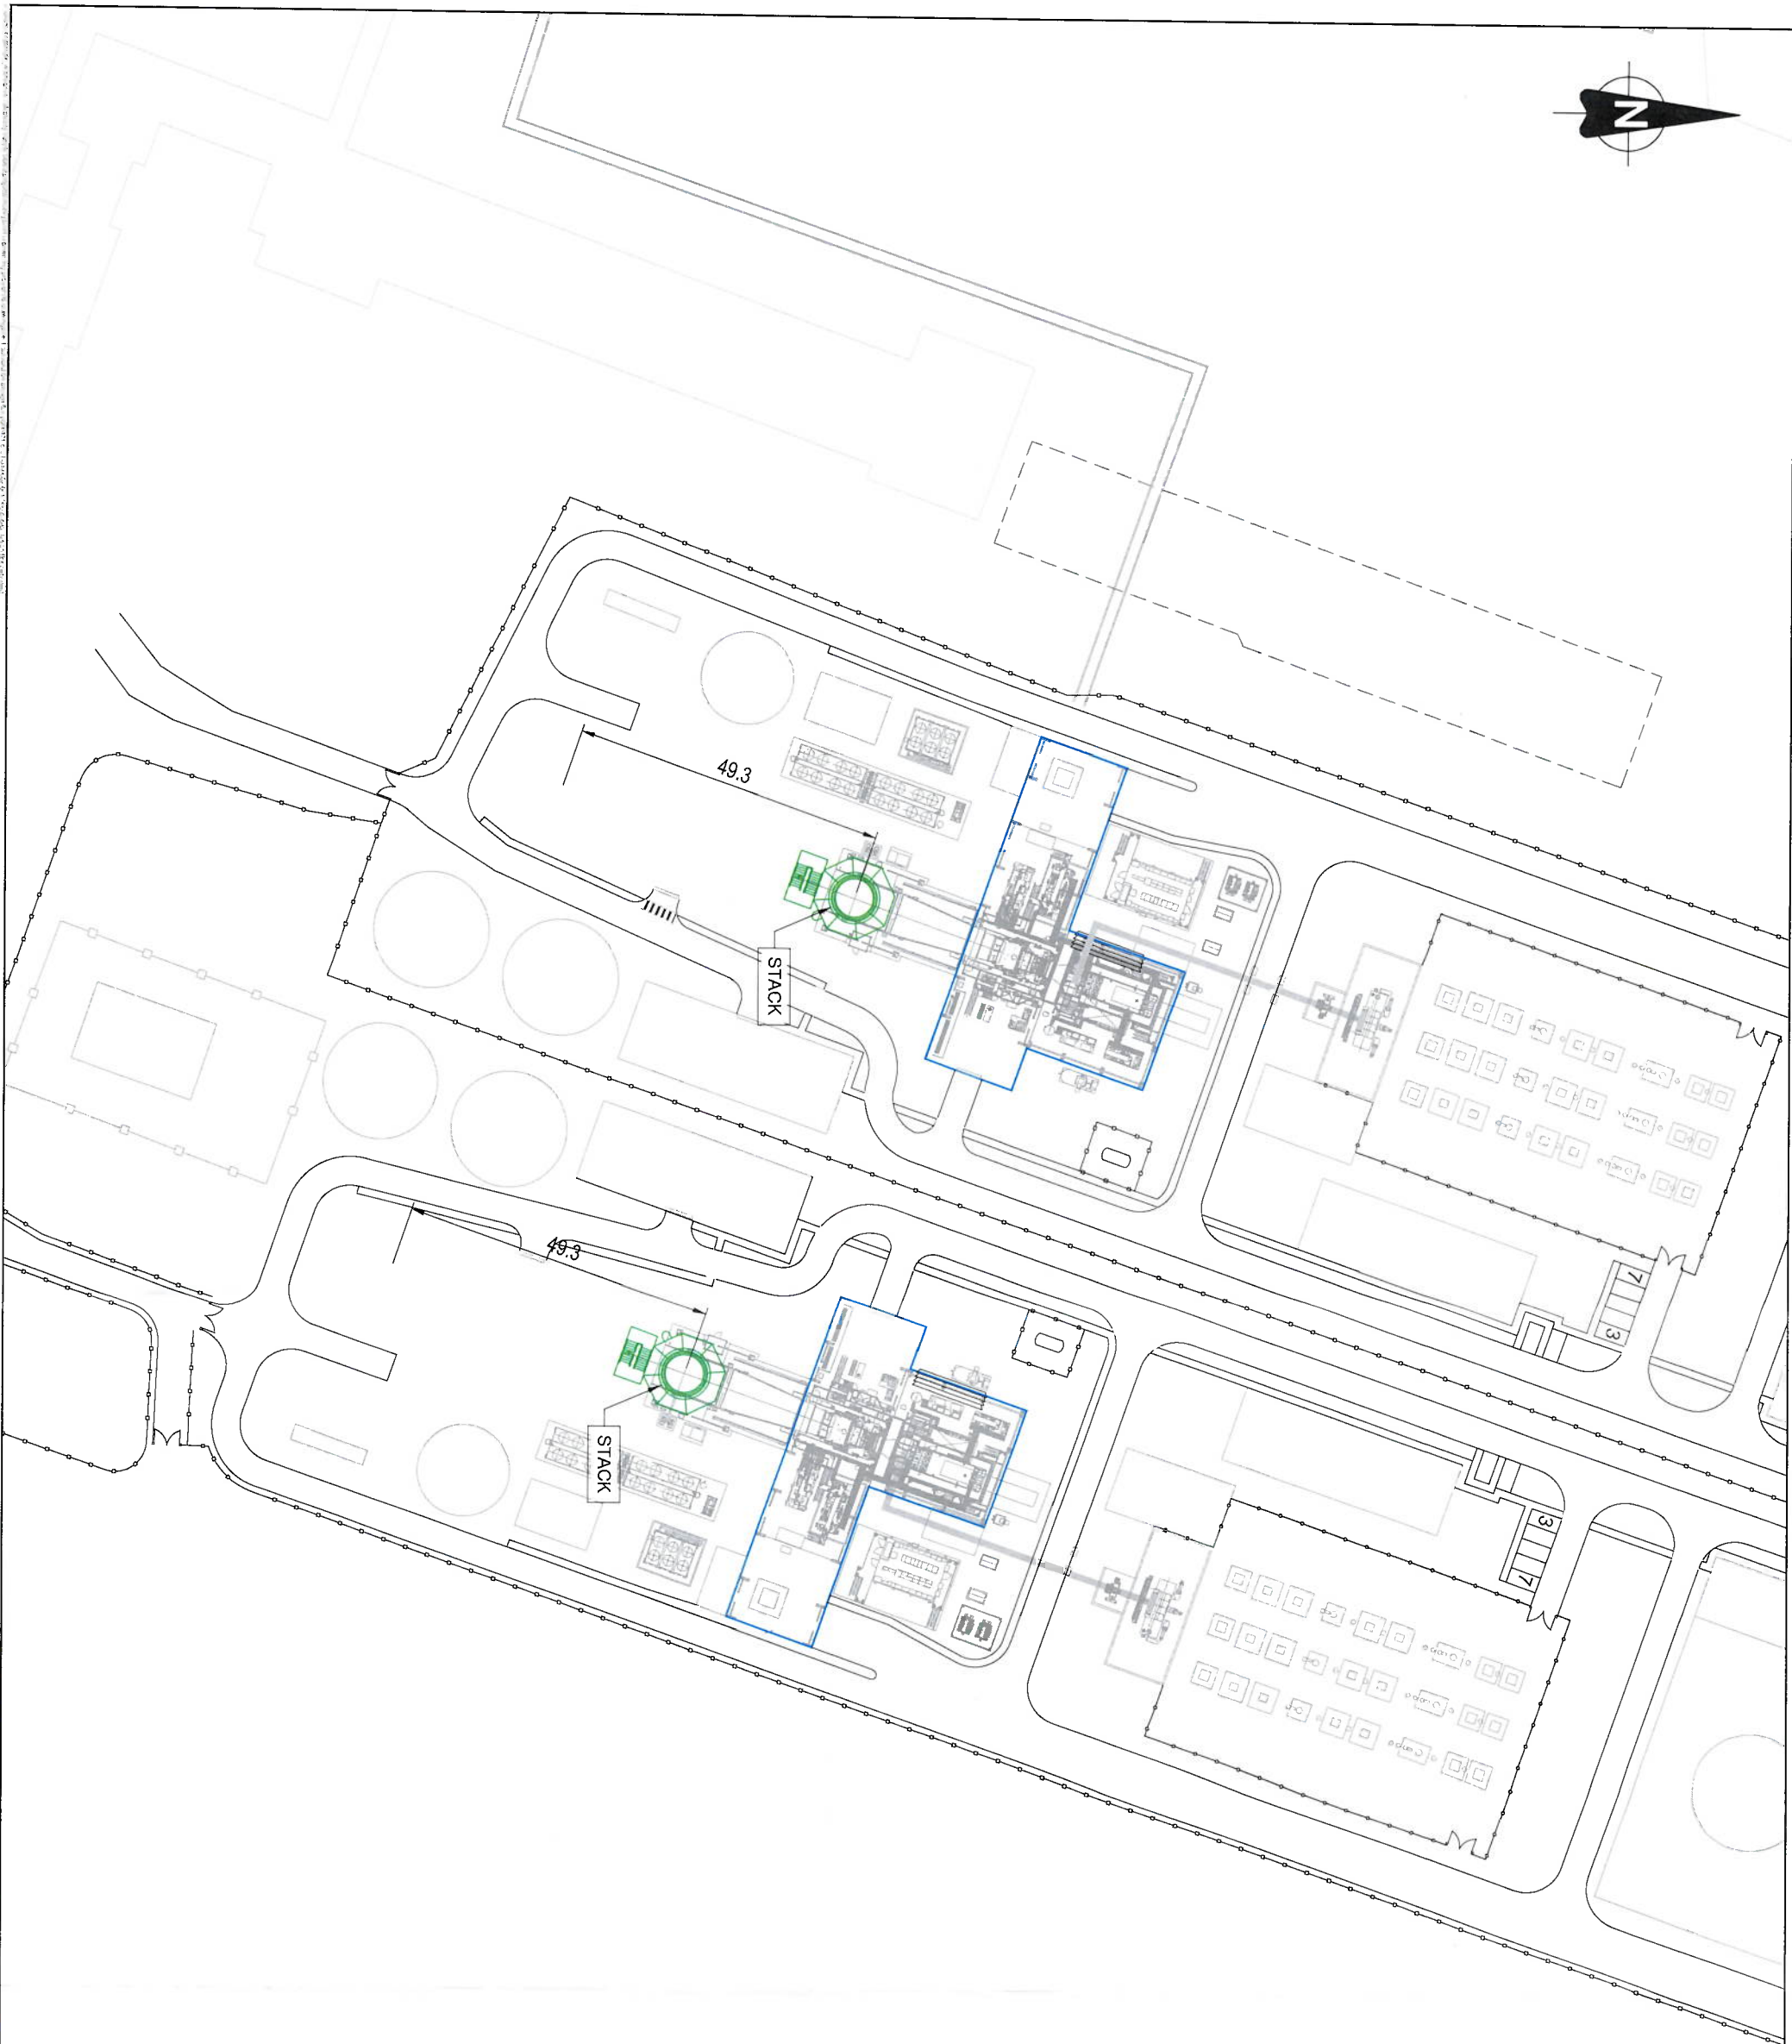

- NOTES:**
- CO-ORDINATES TO ILM GRID.
 - LEVELS TO MAIN HEAD DATUM.
 - ALL DIMENSIONS ARE IN METERS. NO DIMENSIONS SHALL BE SCALED FROM THE DRAWINGS.

PRELIM

CONCEPT

LAYOUT

LEGEND	
	PERIMETER FENCE LINE
	HIGH VOLTAGE COMPOUND FENCE LINE
	POWER PLANT BUILDING OUTLINE

Scale 1:500

THIS DRAWING UTILISES TALE FIREMAN 11:000

SCALE VECTOR MAP SHEET NUMBERS 4789 & 4790

Talme Fireman Licence No. CYA1504214 © Talme Fireman - Surveying

REVISION		DATE	BY	CHKD	APPD
000	ISSUED FOR INFORMATION				
001	REVISION DESCRIPTION				
REV	DATE	BY	CHKD	APPD	

COPYRIGHT © ESB
ALL RIGHTS RESERVED. NO PART OF THIS WORK MAY BE REPRODUCED OR COPIED IN ANY FORM
WITHOUT THE WRITTEN PERMISSION OF ESB.
THIS DRAWING IS THE PROPERTY OF ESB AND IS NOT TO BE USED FOR ANY PURPOSE OTHER THAN ITS SPECIFIED PURPOSE WITHOUT THE WRITTEN PERMISSION OF ESB.

PURPOSE OF ISSUE - PRELIMINARY UNLESS INDICATED

CLIENT ☐ PLANNING ☐ TENDER ☐ CONSTRUCTION ☐ AS BUILT ☐

CLIENT ☐ ESB GENERATION & TRADING

PROJECT ☐ MONEYPPOINT REPOWERING

CONTRACT ☐

DRAWING TITLE
DESIGN FLEXIBILITY REQUEST:
SCENARIO 4

PRODUCTION UNIT
CIVIL, ENVIRONMENTAL & RENEWABLE ENGINEERING

Engineering and Major Projects
One Dublin Airport Central Dublin Airport,
Clonshanagh, Co. Dublin, K67 XRT2, Ireland.
Tel: +353 (0)1 700 8000 [Web: www.esb.ie](http://www.esb.ie)
Engineering and Major Projects is a division of ESB

DRAWN	PRODUCED	VERIFIED	APPROVED	APPROVAL DATE
W. McGuire	J. Greene	J. Heaney	J. Greene	Sep 2024
CLIENT REF	NO. OF SHEETS	SHEET	SCALE	
1	1	A1	1:500	

DRAWING NUMBER
P000471-CE21-04-0002-001-000