


ISO A1 594mm x 841mm

Project Management Initials: Designer: LP Checked: ER Approved: AC

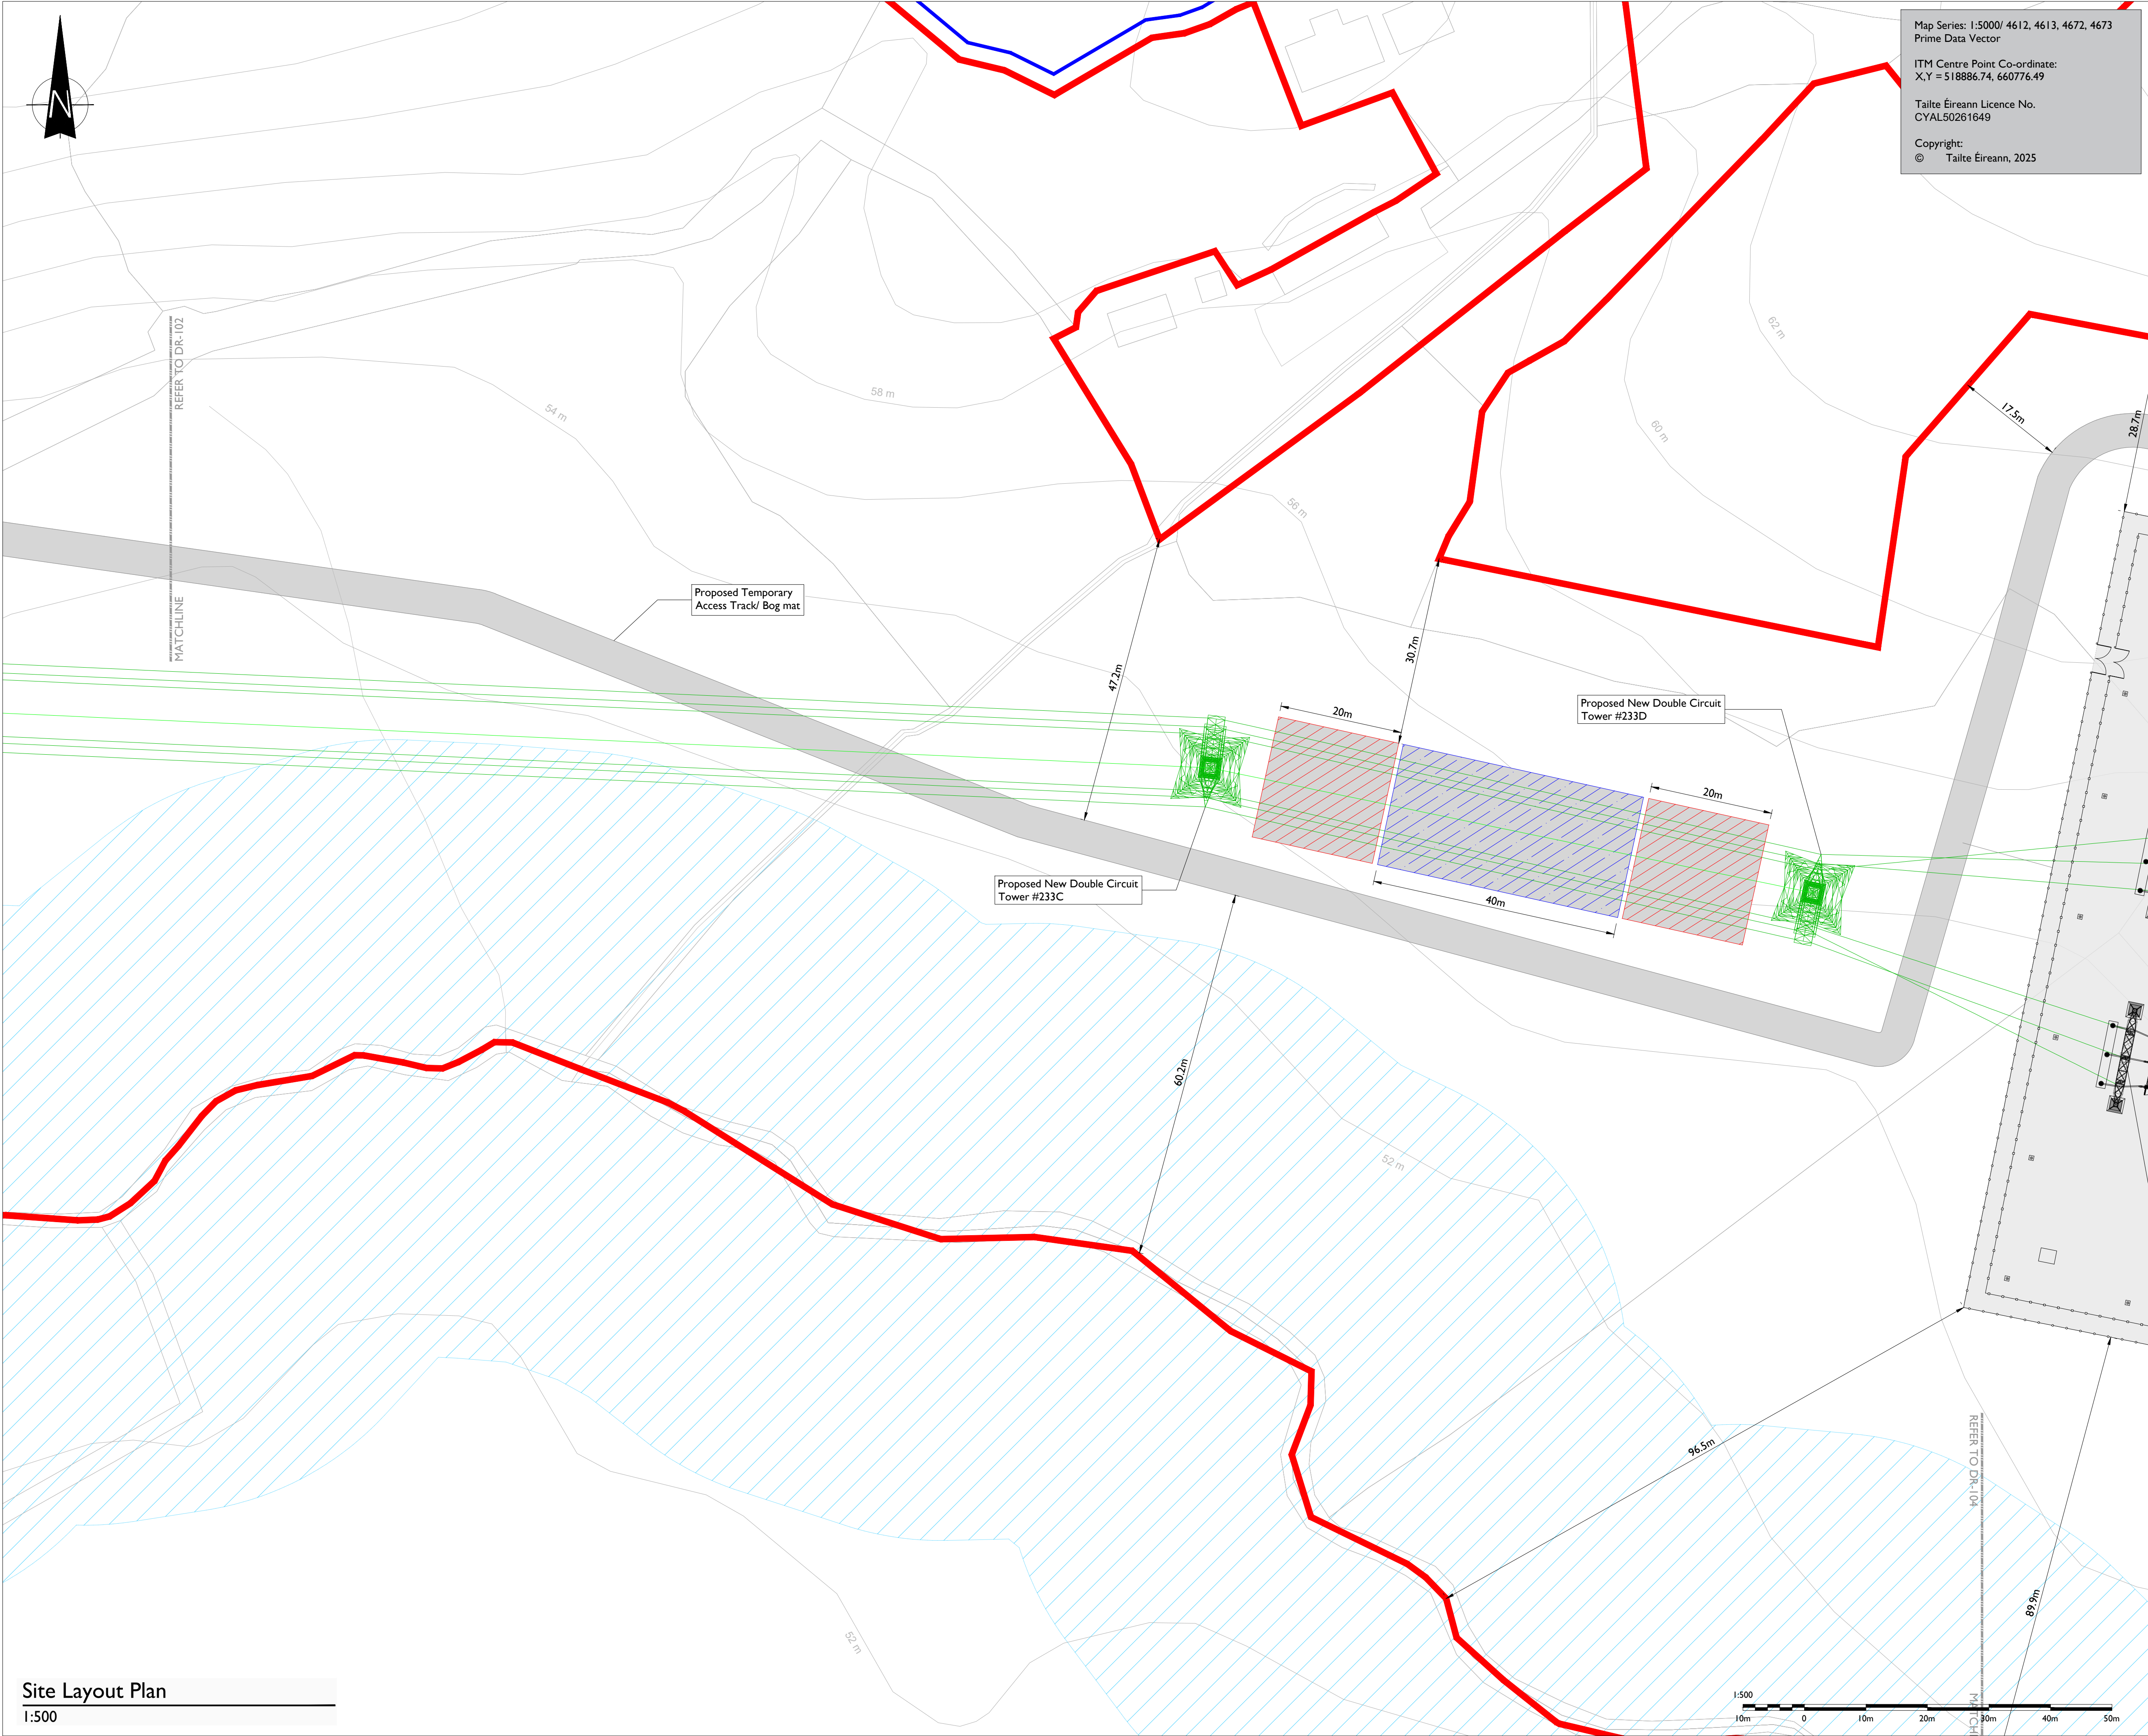

Map Series: 1:5000/ 4612, 4613, 4672, 4673
Prime Data Vector

ITM Centre Point Co-ordinate:
X,Y = 518886.74, 660776.49

Tailte Éireann Licence No.
CYAL50261649

Copyright:
© Tailte Éireann, 2025



Head Office
Beenreigh,
Abbeydorney,
Tralee, Co. Kerry
Ireland
Tel: 00353 66 7135710

Regional Office
Basepoint Business Centre
Scroudley Road, Basingstoke,
Hampshire,
RG24 8UP, UK
Tel: 00 44 1256406664

PROJECT

Cloonkett Wind Farm

CLIENT



CONSULTANTS

- NOTES: -
- This drawing is to be used only for the purpose of the planning application and is subject to detailed design.
 - Other services may be encountered on the route.
 - Access to the substation and Temporary compounds will be provided through the internal wind farm access tracks.
 - Drainage infrastructure is not shown. Please refer to the 0100 series planning application drawings for the drainage layout

LEGEND: -

Folio Boundaries	
Proposed Site Boundary	
Proposed Tower Type 223	
Proposed 220kV OHL Conductor	
Proposed Shieldwire	
Stream Buffer (50m)	
Temporary Track for Construction	
Tower Lay Down Area	
Crane Hardstand Area	

ISSUE/REVISION

I/R	DATE	DESCRIPTION
P3	12.09.25	For Planning
P2	07.07.25	For Planning
P1	04.04.25	For Planning
N1	21.03.25	For Information

PROJECT NUMBER

05 - 997

SHEET TITLE

Site Layout Plan
Sheet 3 of 6

SHEET NUMBER

05997-DR-103