

A0 A B C D E F G H I J K L M N O P Q R S T U

1

2

3

4

5

6

7

8

9

10


11

12


13

14

15

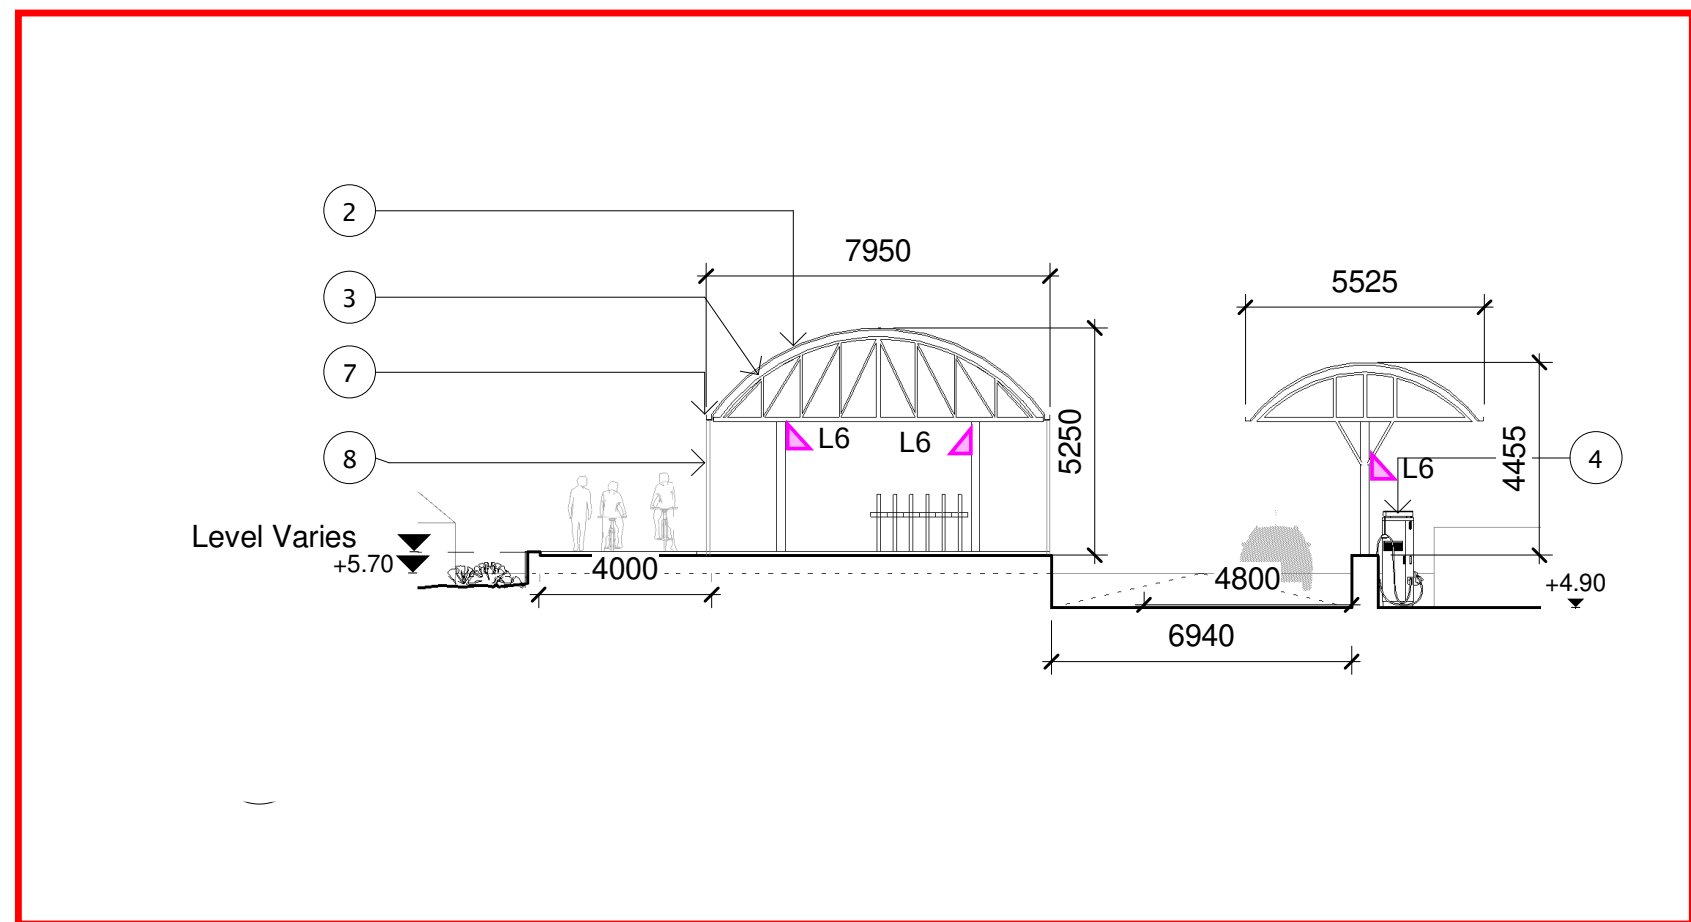

Detail A: Typical Cross Section of Mobility Hub Canopy

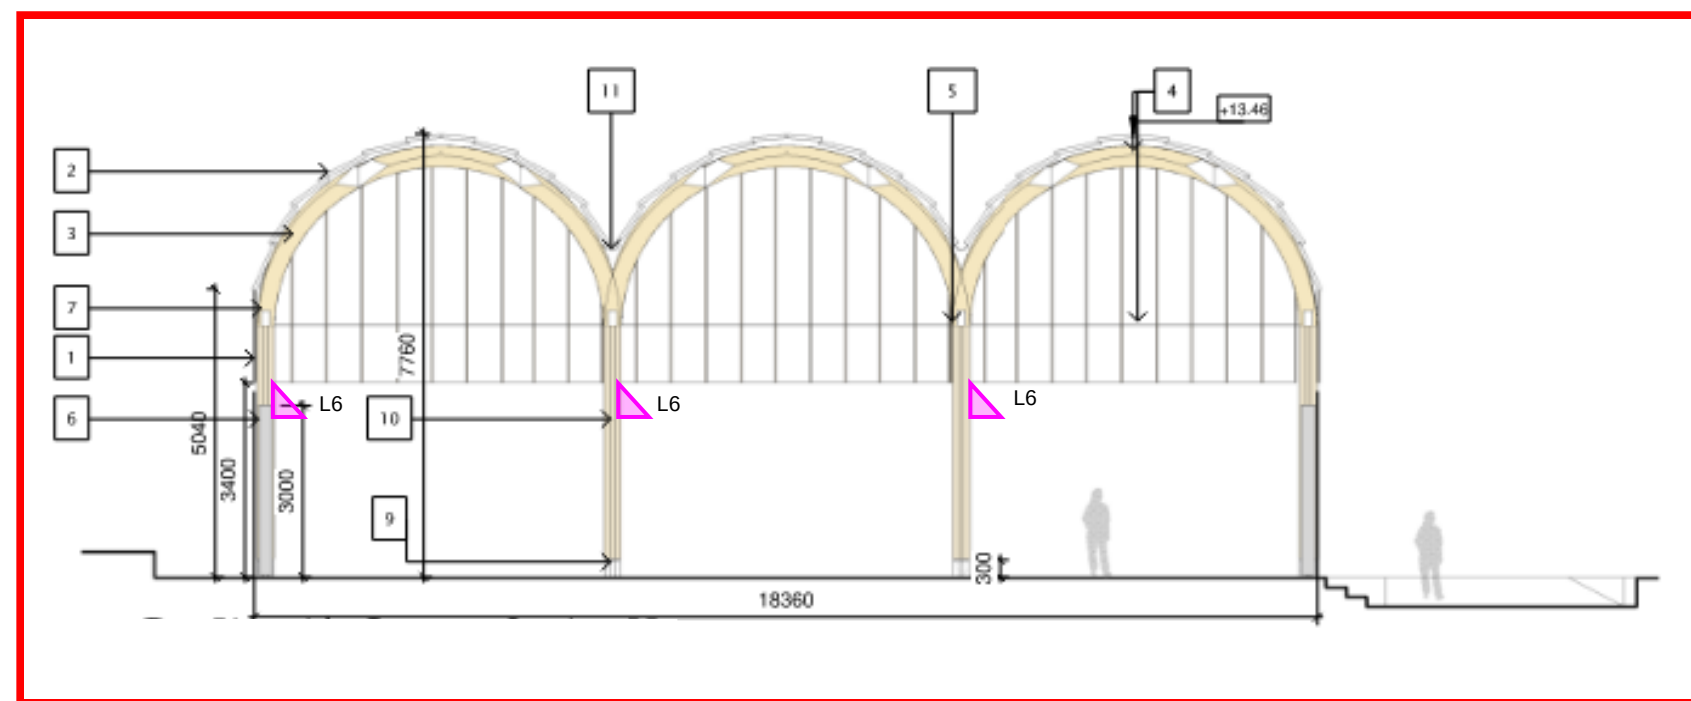

Detail B: Typical Cross Section of Riverside Canopy

Ref	Symbol	Image	Legend
L1			LEDs: 4000K, 1m outreach, 2700K, 2700K
L1a			As above but mounted at the lower height of 3.0m
L2			LEDs: 4000K, 1m outreach, 2700K, 2700K
L3			LEDs: 4000K, 1m outreach, 2700K, 2700K
L3a			As above but mounted at the lower height of 3.0m
L4			LEDs: 4000K, 1m outreach, 2700K, 2700K
L5			LEDs: 4000K, 1m outreach, 2700K, 2700K
L6			LEDs: 4000K, 1m outreach, 2700K, 2700K
L100			LEDs: 4000K, 1m outreach, 2700K, 2700K

C01	03/10/25	AM	AM	VA
P05	05/09/25	AM	AM	VA
P04	15/08/25	AM	AM	VA
P03	01/08/25	AM	AM	VA
P02	08/07/25	AM	AM	VA
P01	04/07/25	AM	AM	VA
Rev	Date	By	CHK'd	App'd

ARUP

One Albert Quay
Civic, T12 2BME, Belfast
Tel: +44 (0)1234 432 1000
www.arup.com

Client
Limerick Twenty Thirty

Project Title
Cleaves Residential Quarter

Drawing Title
Lighting Layout

Scale at A0
NTS

Rule
Electrical

Status
A2 - Issued for Planning

Arup Job No
265545-00

Rev
C01

ID
CRQMP-ARUP-ZZ-00-SK-EE-2101

Calculation Targets			
Class	Min Avg (lux)	Min Point (lux)	Min Uniformity
P3	7.5	1.5	0.2