
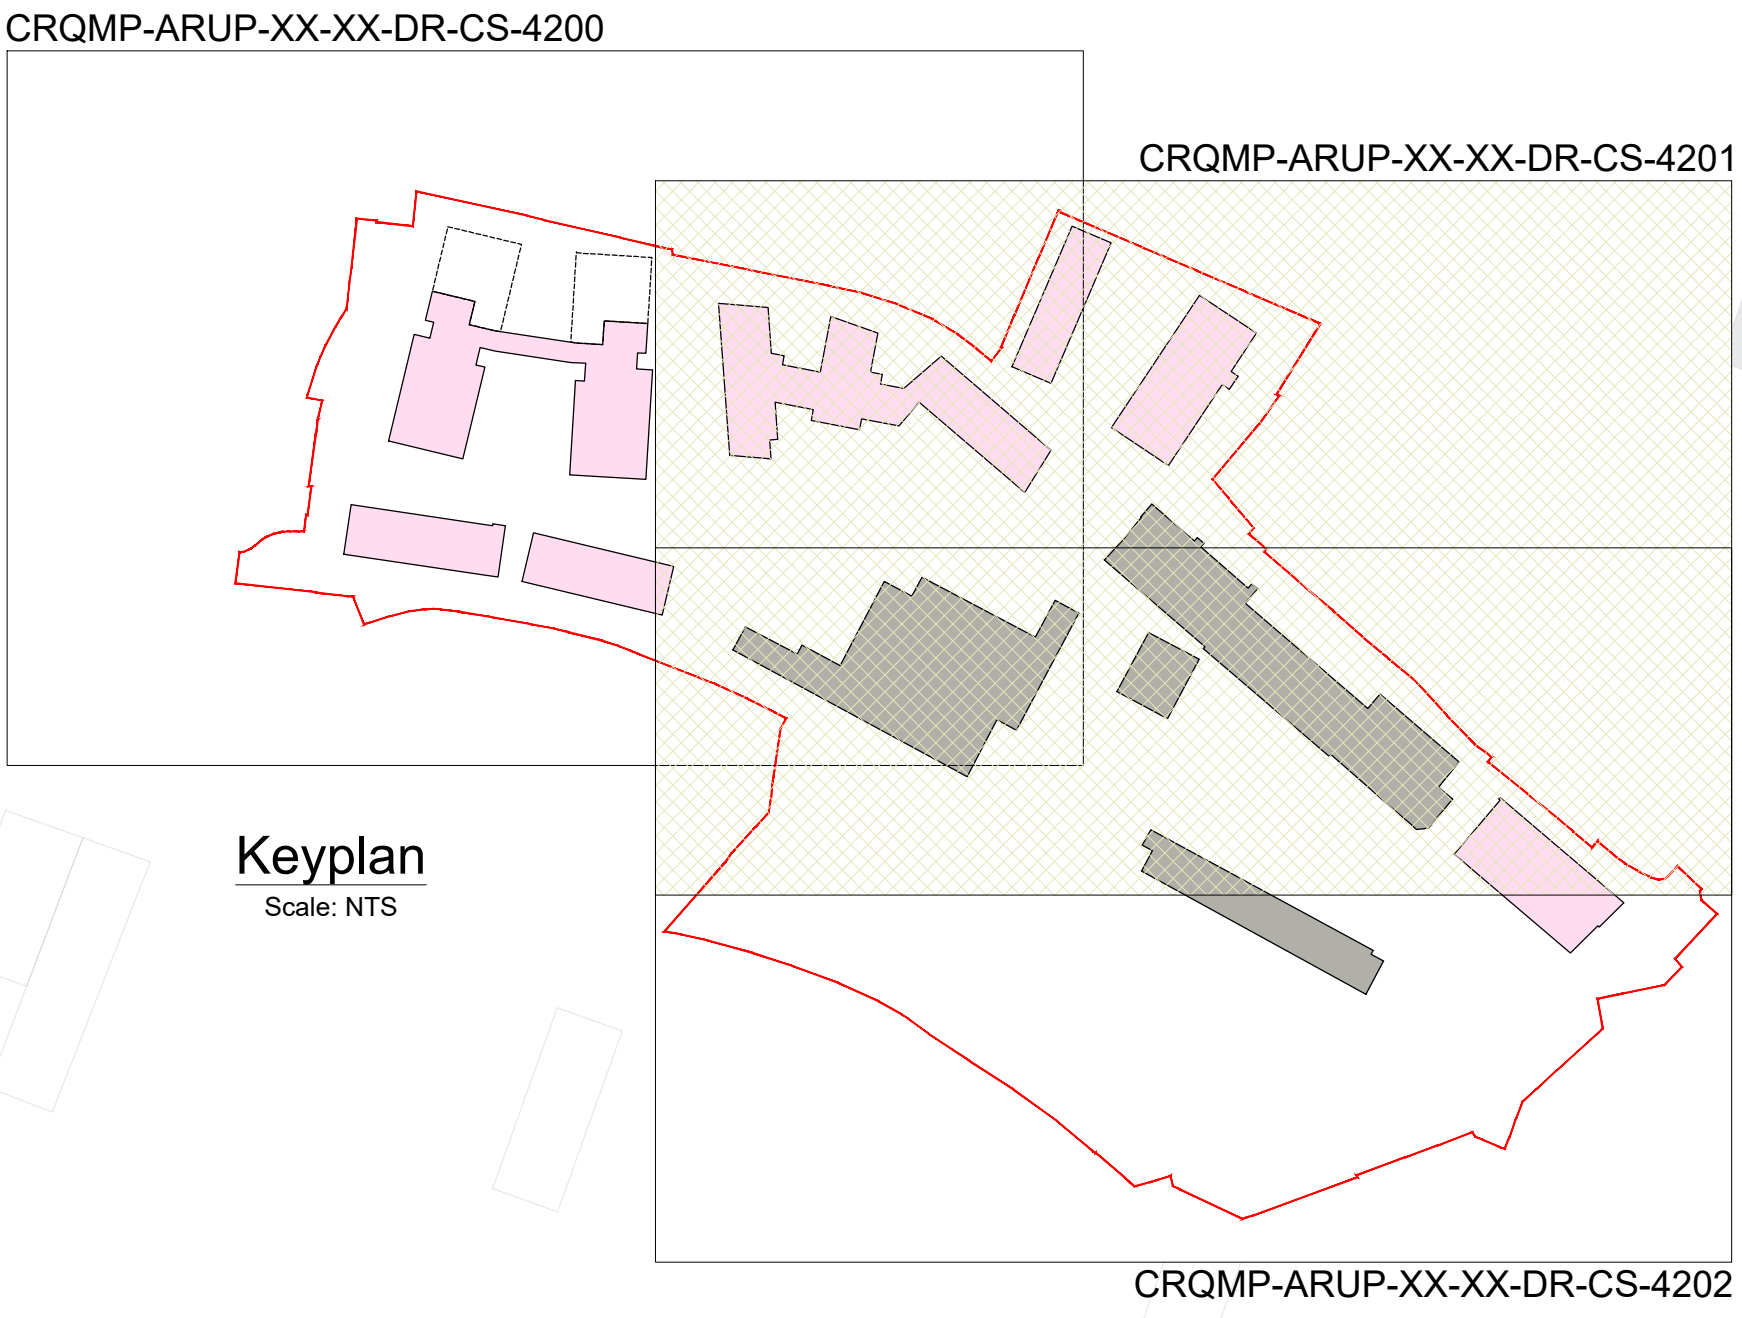


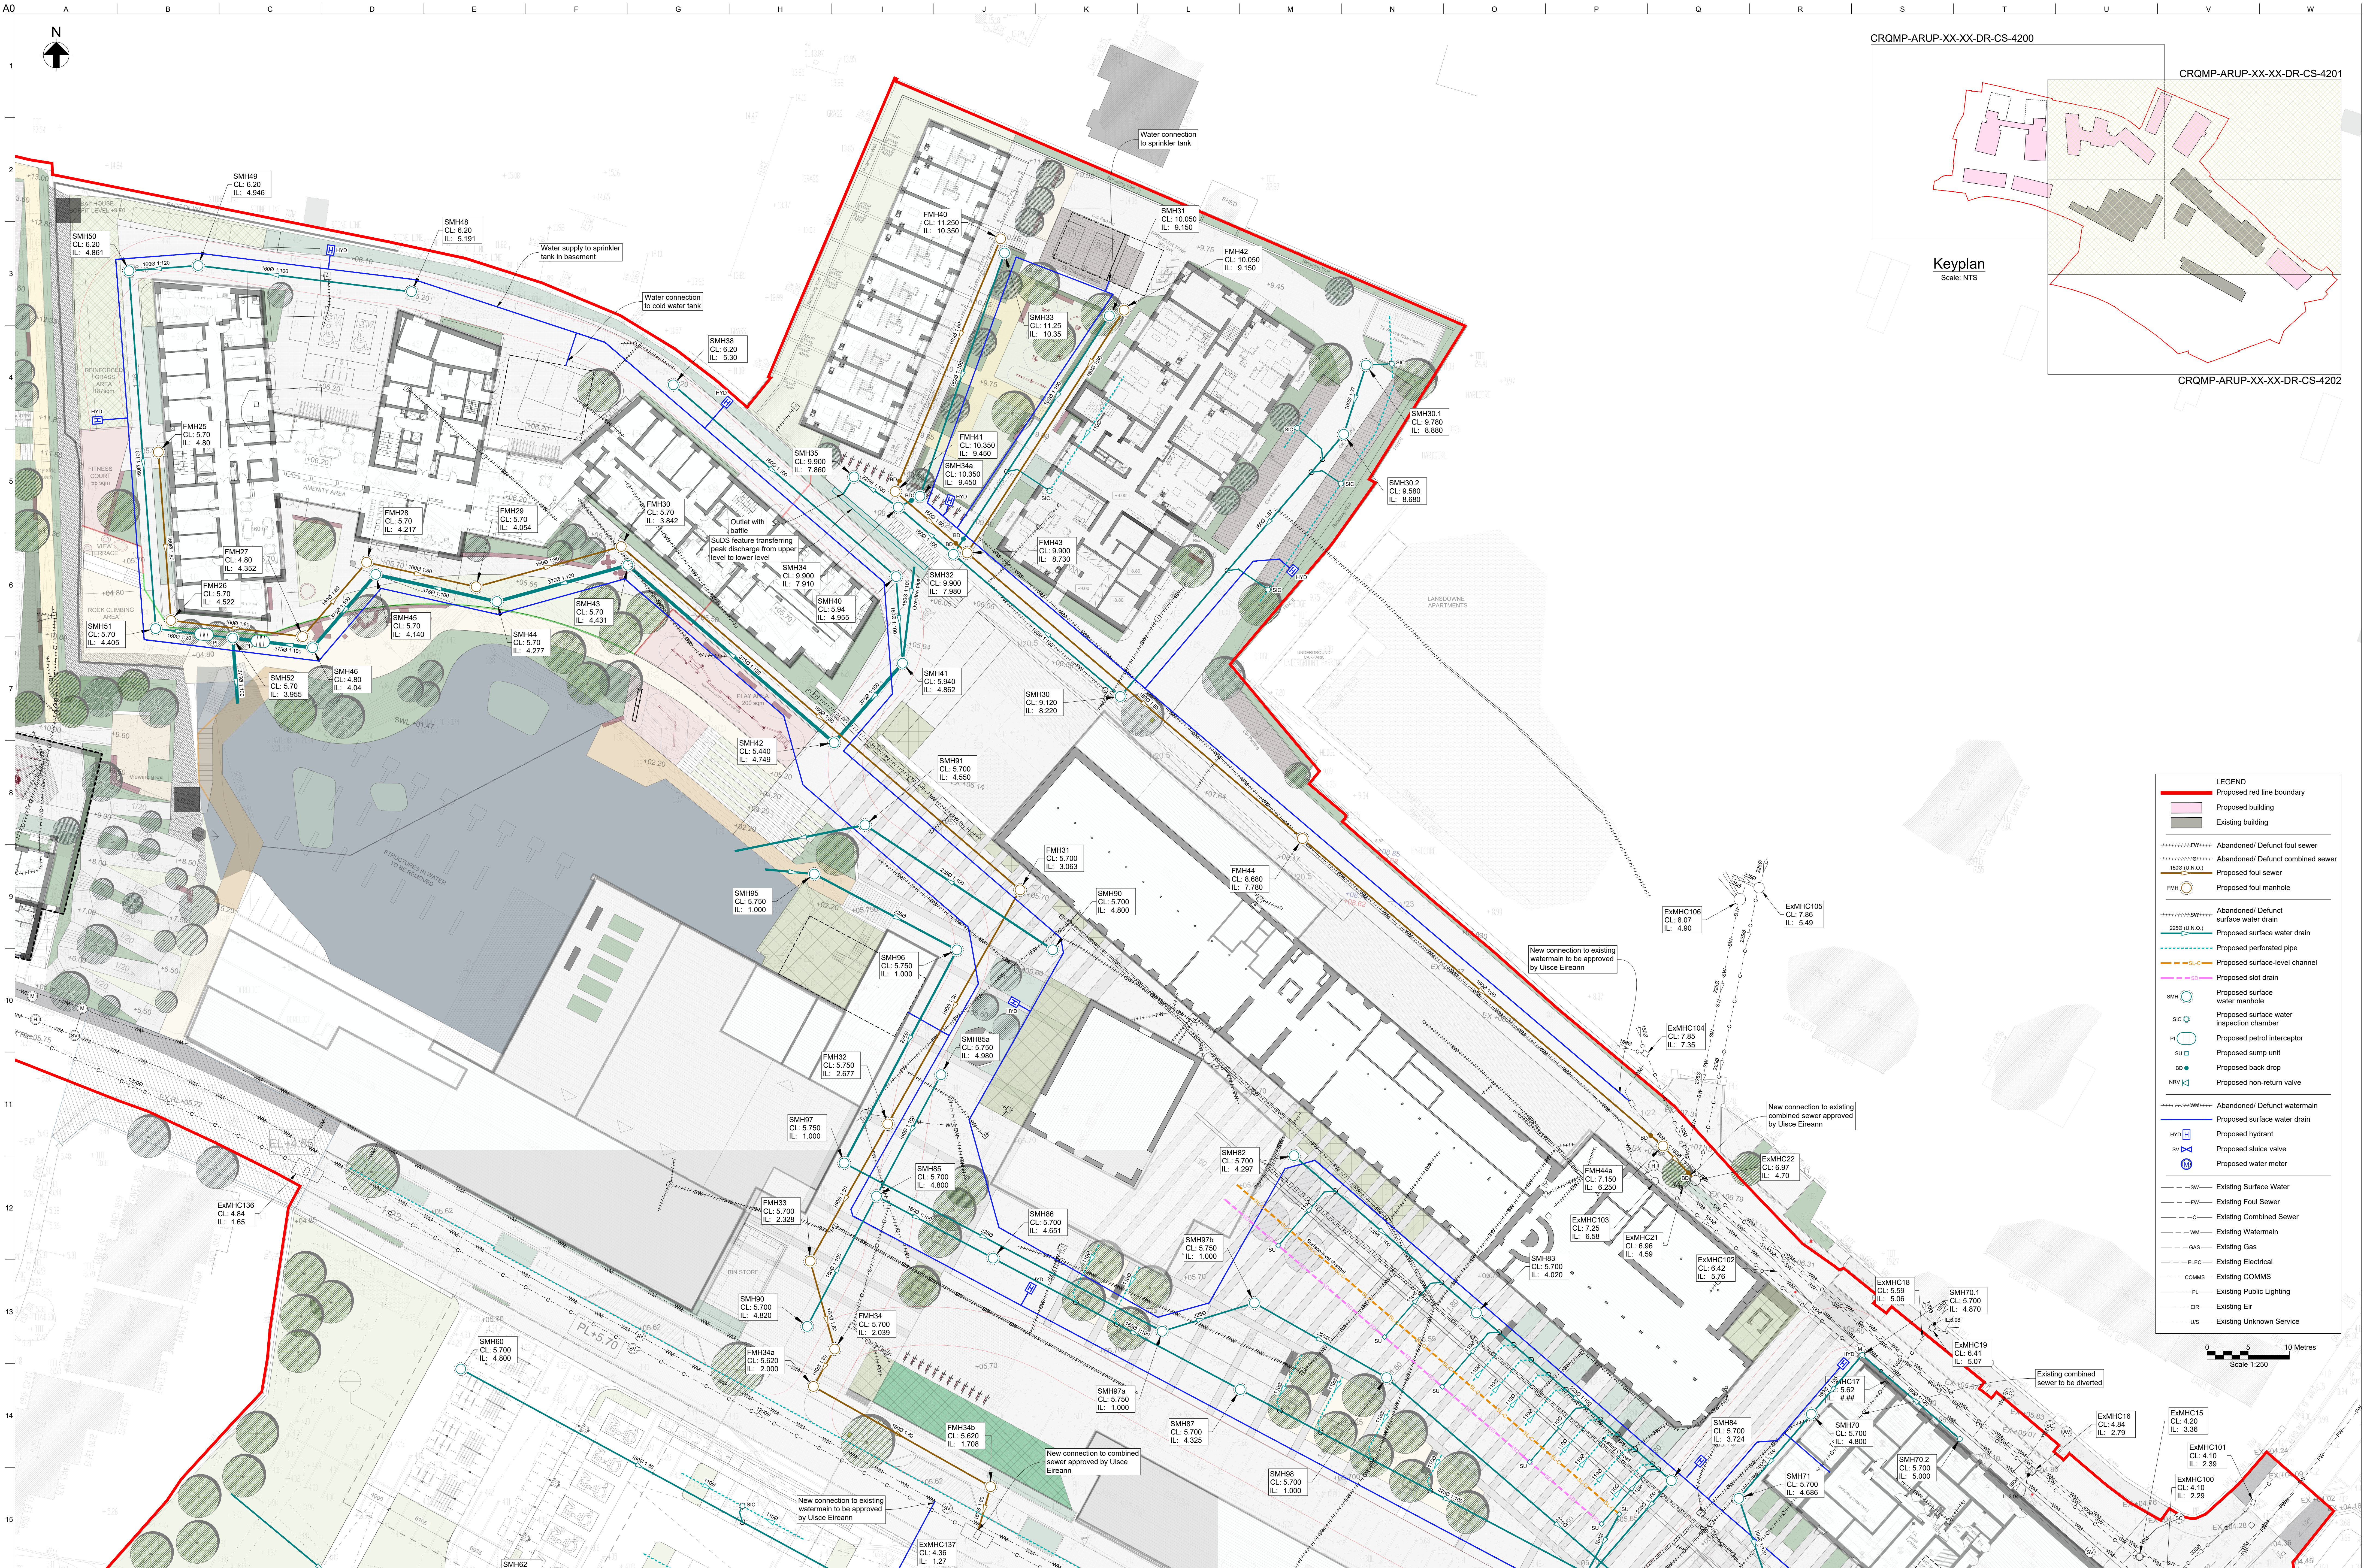

- LEGEND**
- Proposed red line boundary
 - Proposed building
 - Existing building
 - Abandoned/ Defunct foul sewer
 - Abandoned/ Defunct combined sewer
 - Proposed foul sewer
 - Proposed foul manhole
 - Abandoned/ Defunct surface water drain
 - Proposed surface water drain
 - Proposed perforated pipe
 - Proposed surface-level channel
 - Proposed slot drain
 - Proposed surface water manhole
 - Proposed surface water inspection chamber
 - Proposed petrol interceptor
 - Proposed sump unit
 - Proposed back drop
 - Proposed non-return valve
 - Abandoned/ Defunct watermain
 - Proposed surface water drain
 - Proposed hydrant
 - Proposed sluice valve
 - Proposed water meter
 - Existing Surface Water
 - Existing Foul Sewer
 - Existing Combined Sewer
 - Existing Watermain
 - Existing Gas
 - Existing Electrical
 - Existing COMMS
 - Existing Public Lighting
 - Existing Eir
 - Existing Unknown Service

0 5 10 Metres
Scale 1:250

Notes:

Backgrounds to be updated to latest architects and landscape architect's plans

ARUP

Avon, 60 Ringland Road
Dunmurry, Dublin 11
Tel: +353(0)1 233 4455 Fax: +353(0)1 608 3169

Client: Limerick Twenty Thirty

Project Title: Cleaves Riverside Quarter Masterplan

Drawing Title: The Quarry & Stonetown Terrace Proposed Drainage Layout

Scale at A0: 1:250

Rate:	Civil Drainage
Status:	A2 - Issued for Planning
Drawn:	277975-00
Designed:	AS
Design Check:	GS
Document Number (E):	CRQMP-ARUP-XX-00-DR-CE-4201
Rev:	C01