



Floor Plan
Scale 1:100


Section A-A
Scale 1:100

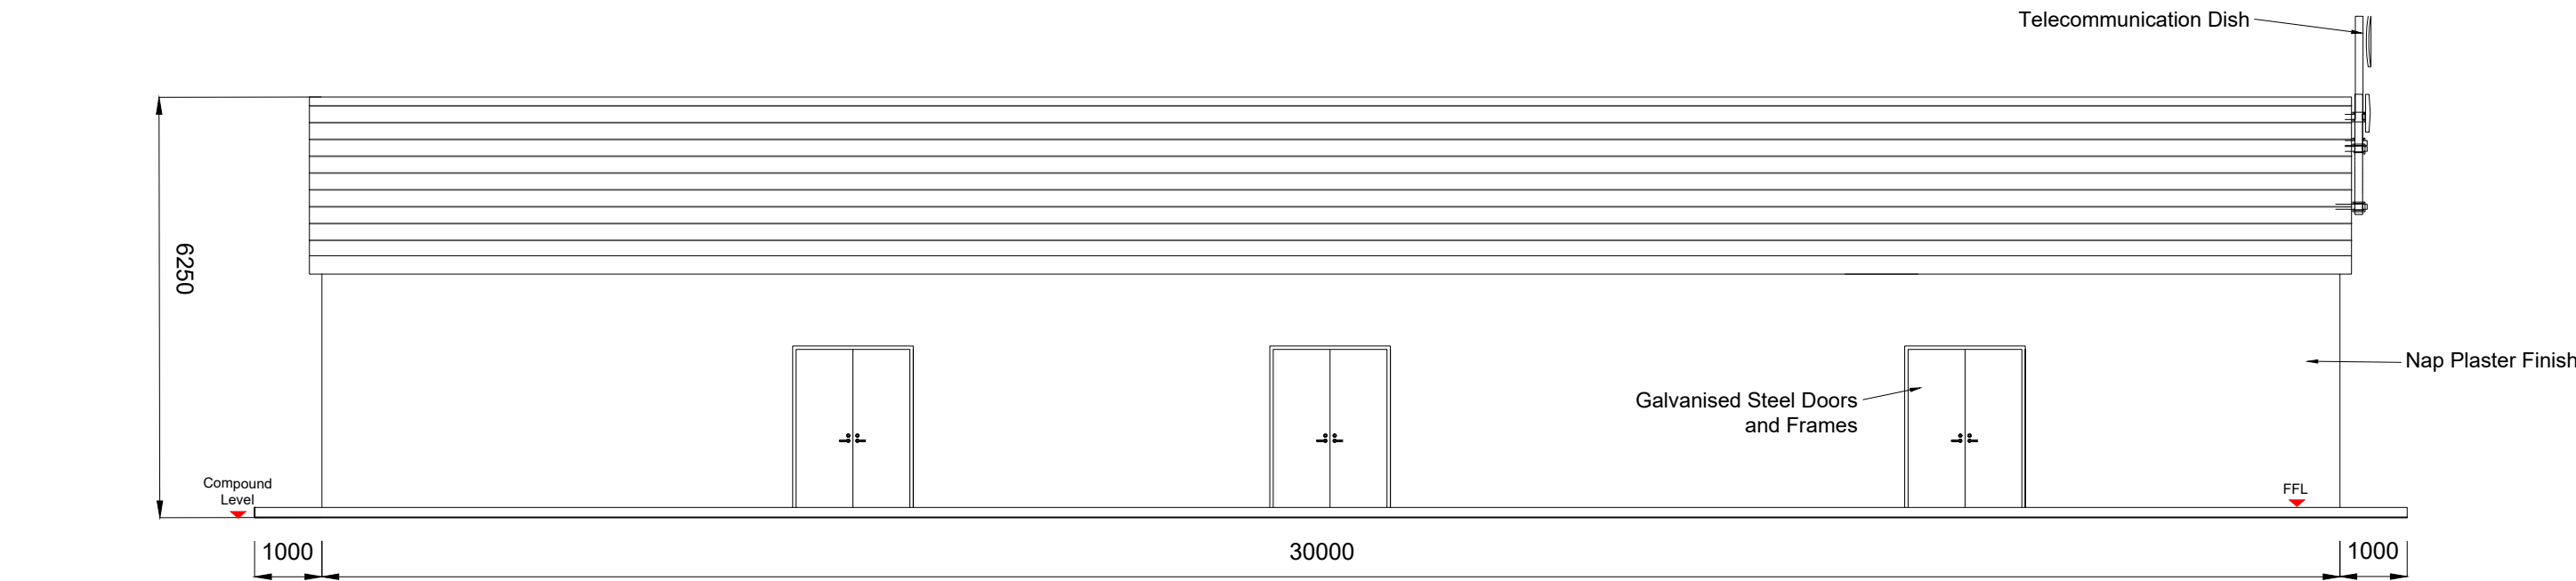


Elevation B
Scale 1:100

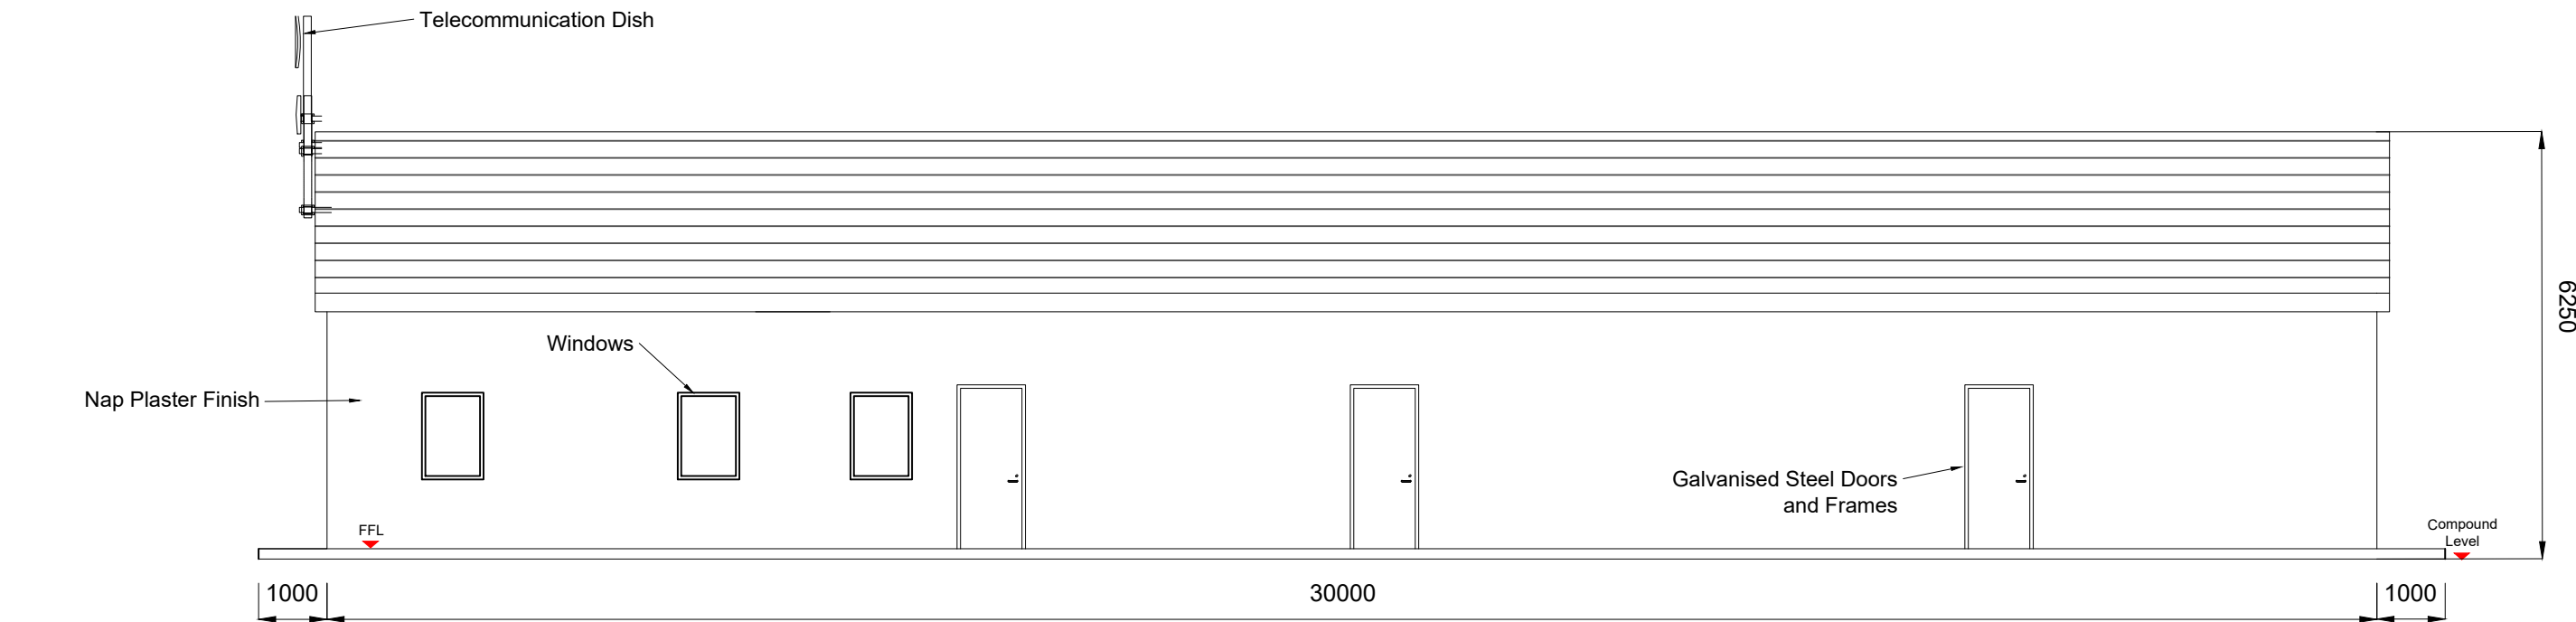


Elevation D
Scale 1:100

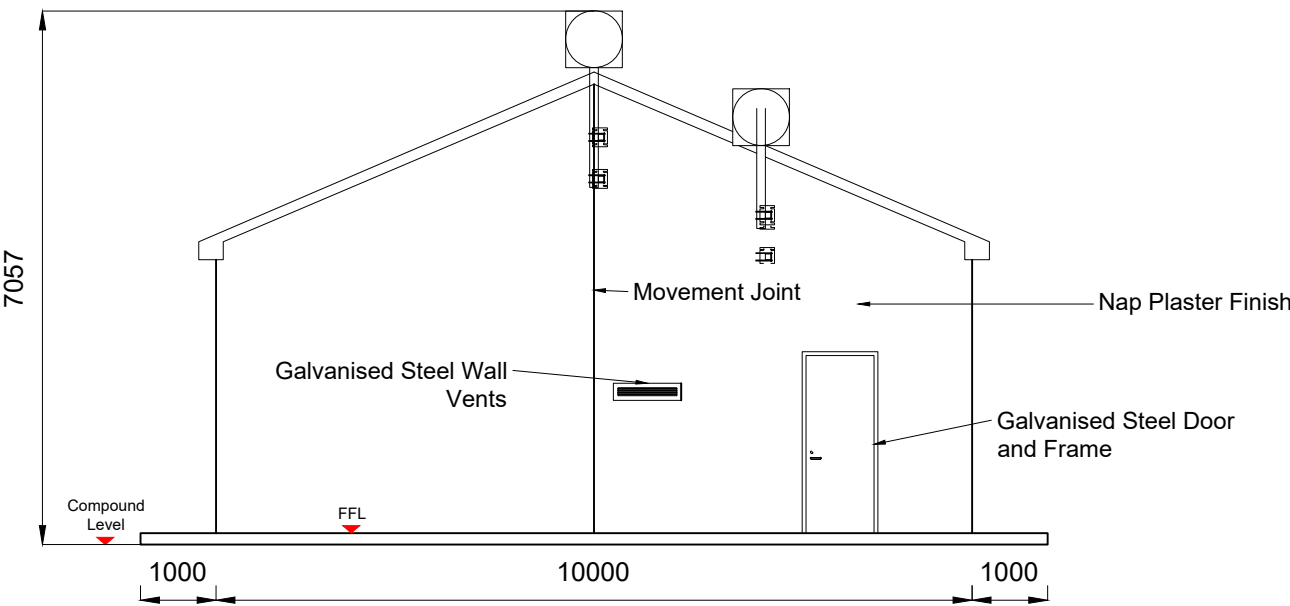

Elevation A
Scale 1:100

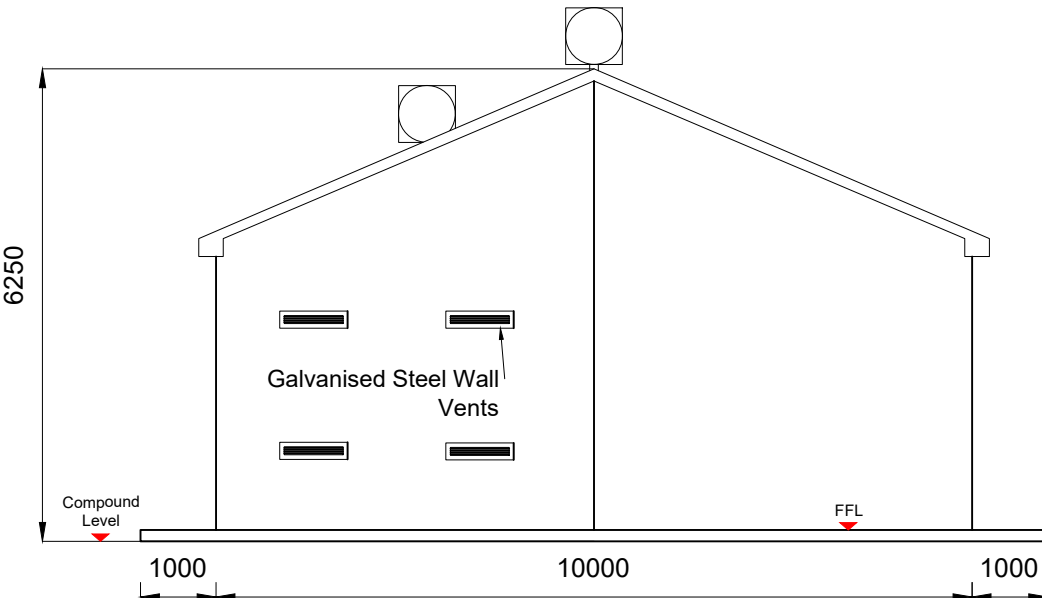

Elevation C
Scale 1:100

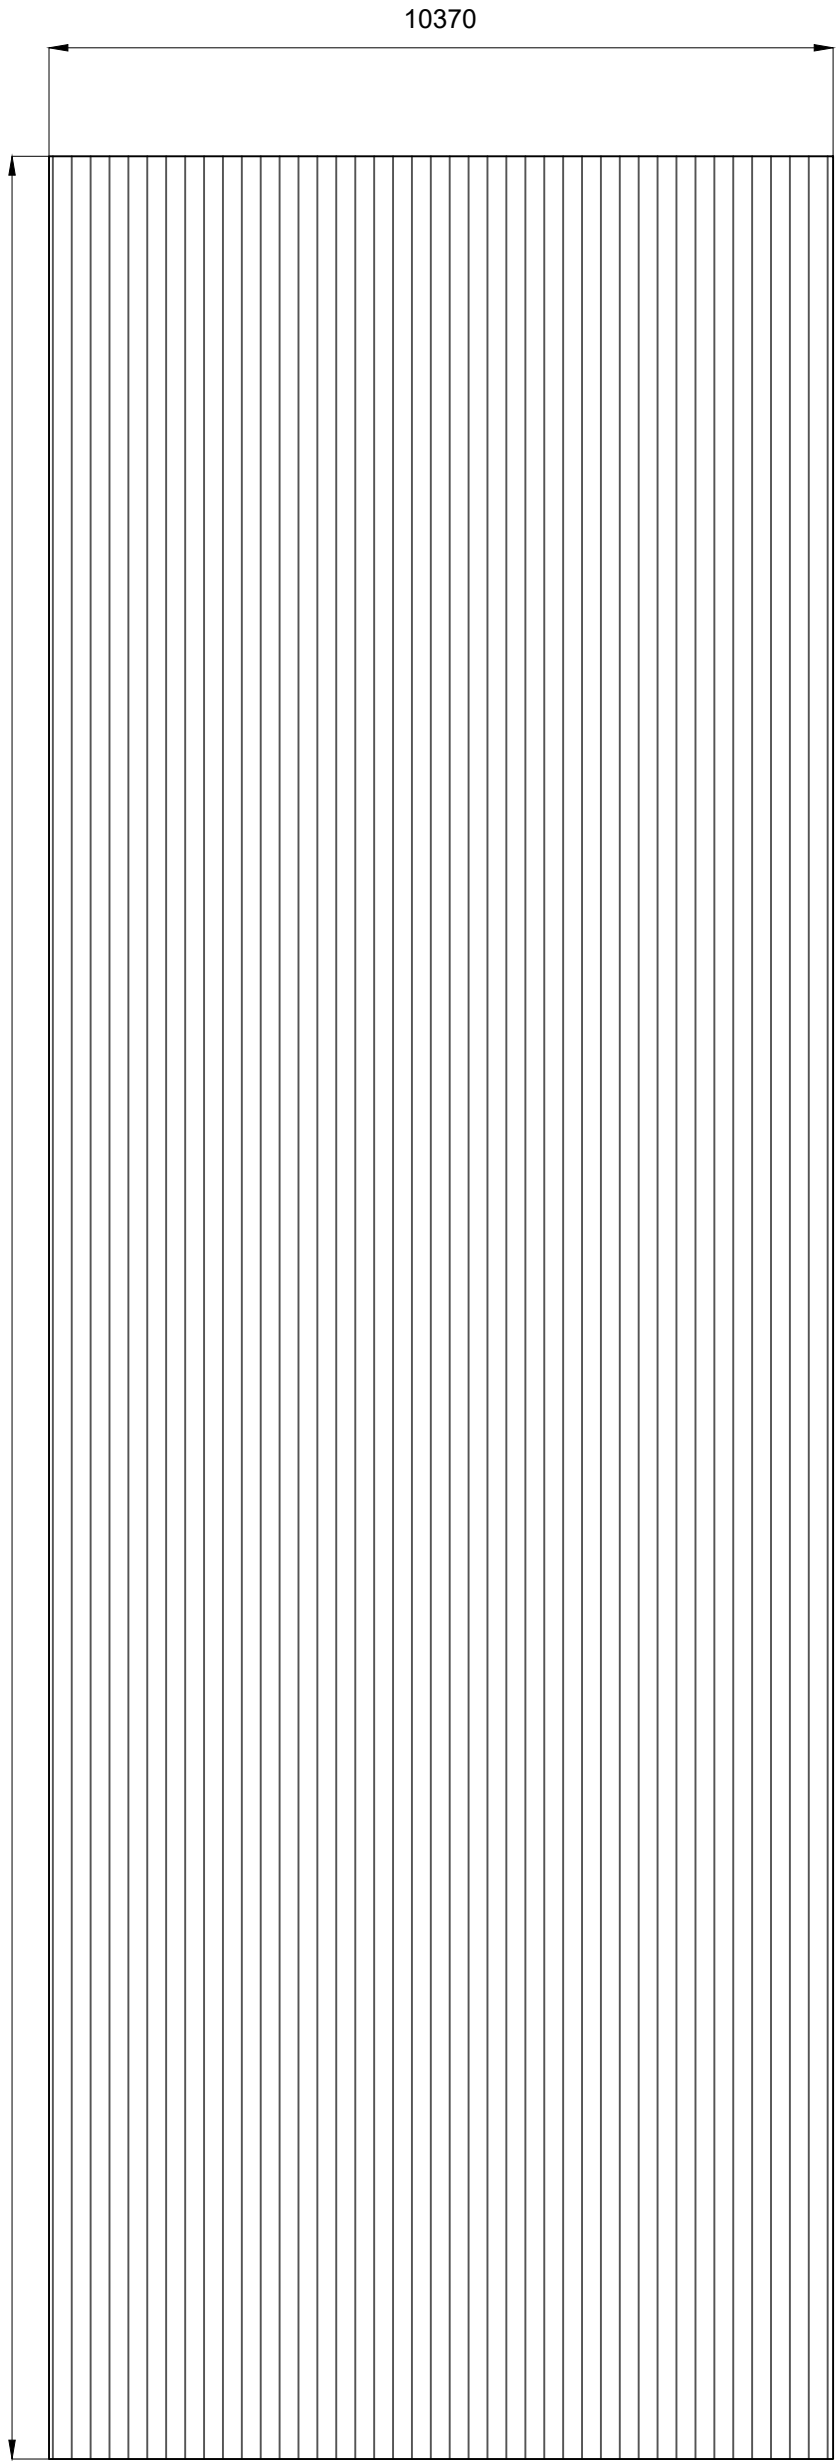

Roof Plan
Scale 1:100

Notes

All dimensions in meters unless otherwise noted.
Do not scale from drawings, use figured dimensions only.
Refer to site layout plan for finished floor levels

Drawings are for planning only and should not be used for detailed design. The detailed design will be subject to EirGrid approval based on their latest specification at the time, and equipment dimensions/sittings may vary once the exact specifications are determined.

Legend

Design Team

Prepared By: Terra Solar Developments
Reviewed By: ARG Grid Solutions



Revisions

REV	DATE	DESCRIPTION
0	30.09.25	Issued for Planning

Drawn By: RH
Approved By: MMC

Summary

Project
Ballyloo Substation & Grid Connection

Location
Ballyloo, Co. Carlow

Title
Substation Option A & B & C - IPP Control Building

Drawing Number
BYLOO-DR-036

Scale
1:100 @ A1

Ballyloo Solar Farm Limited
Commercial House
Millbank Business Park
Lucan
Co. Dublin