


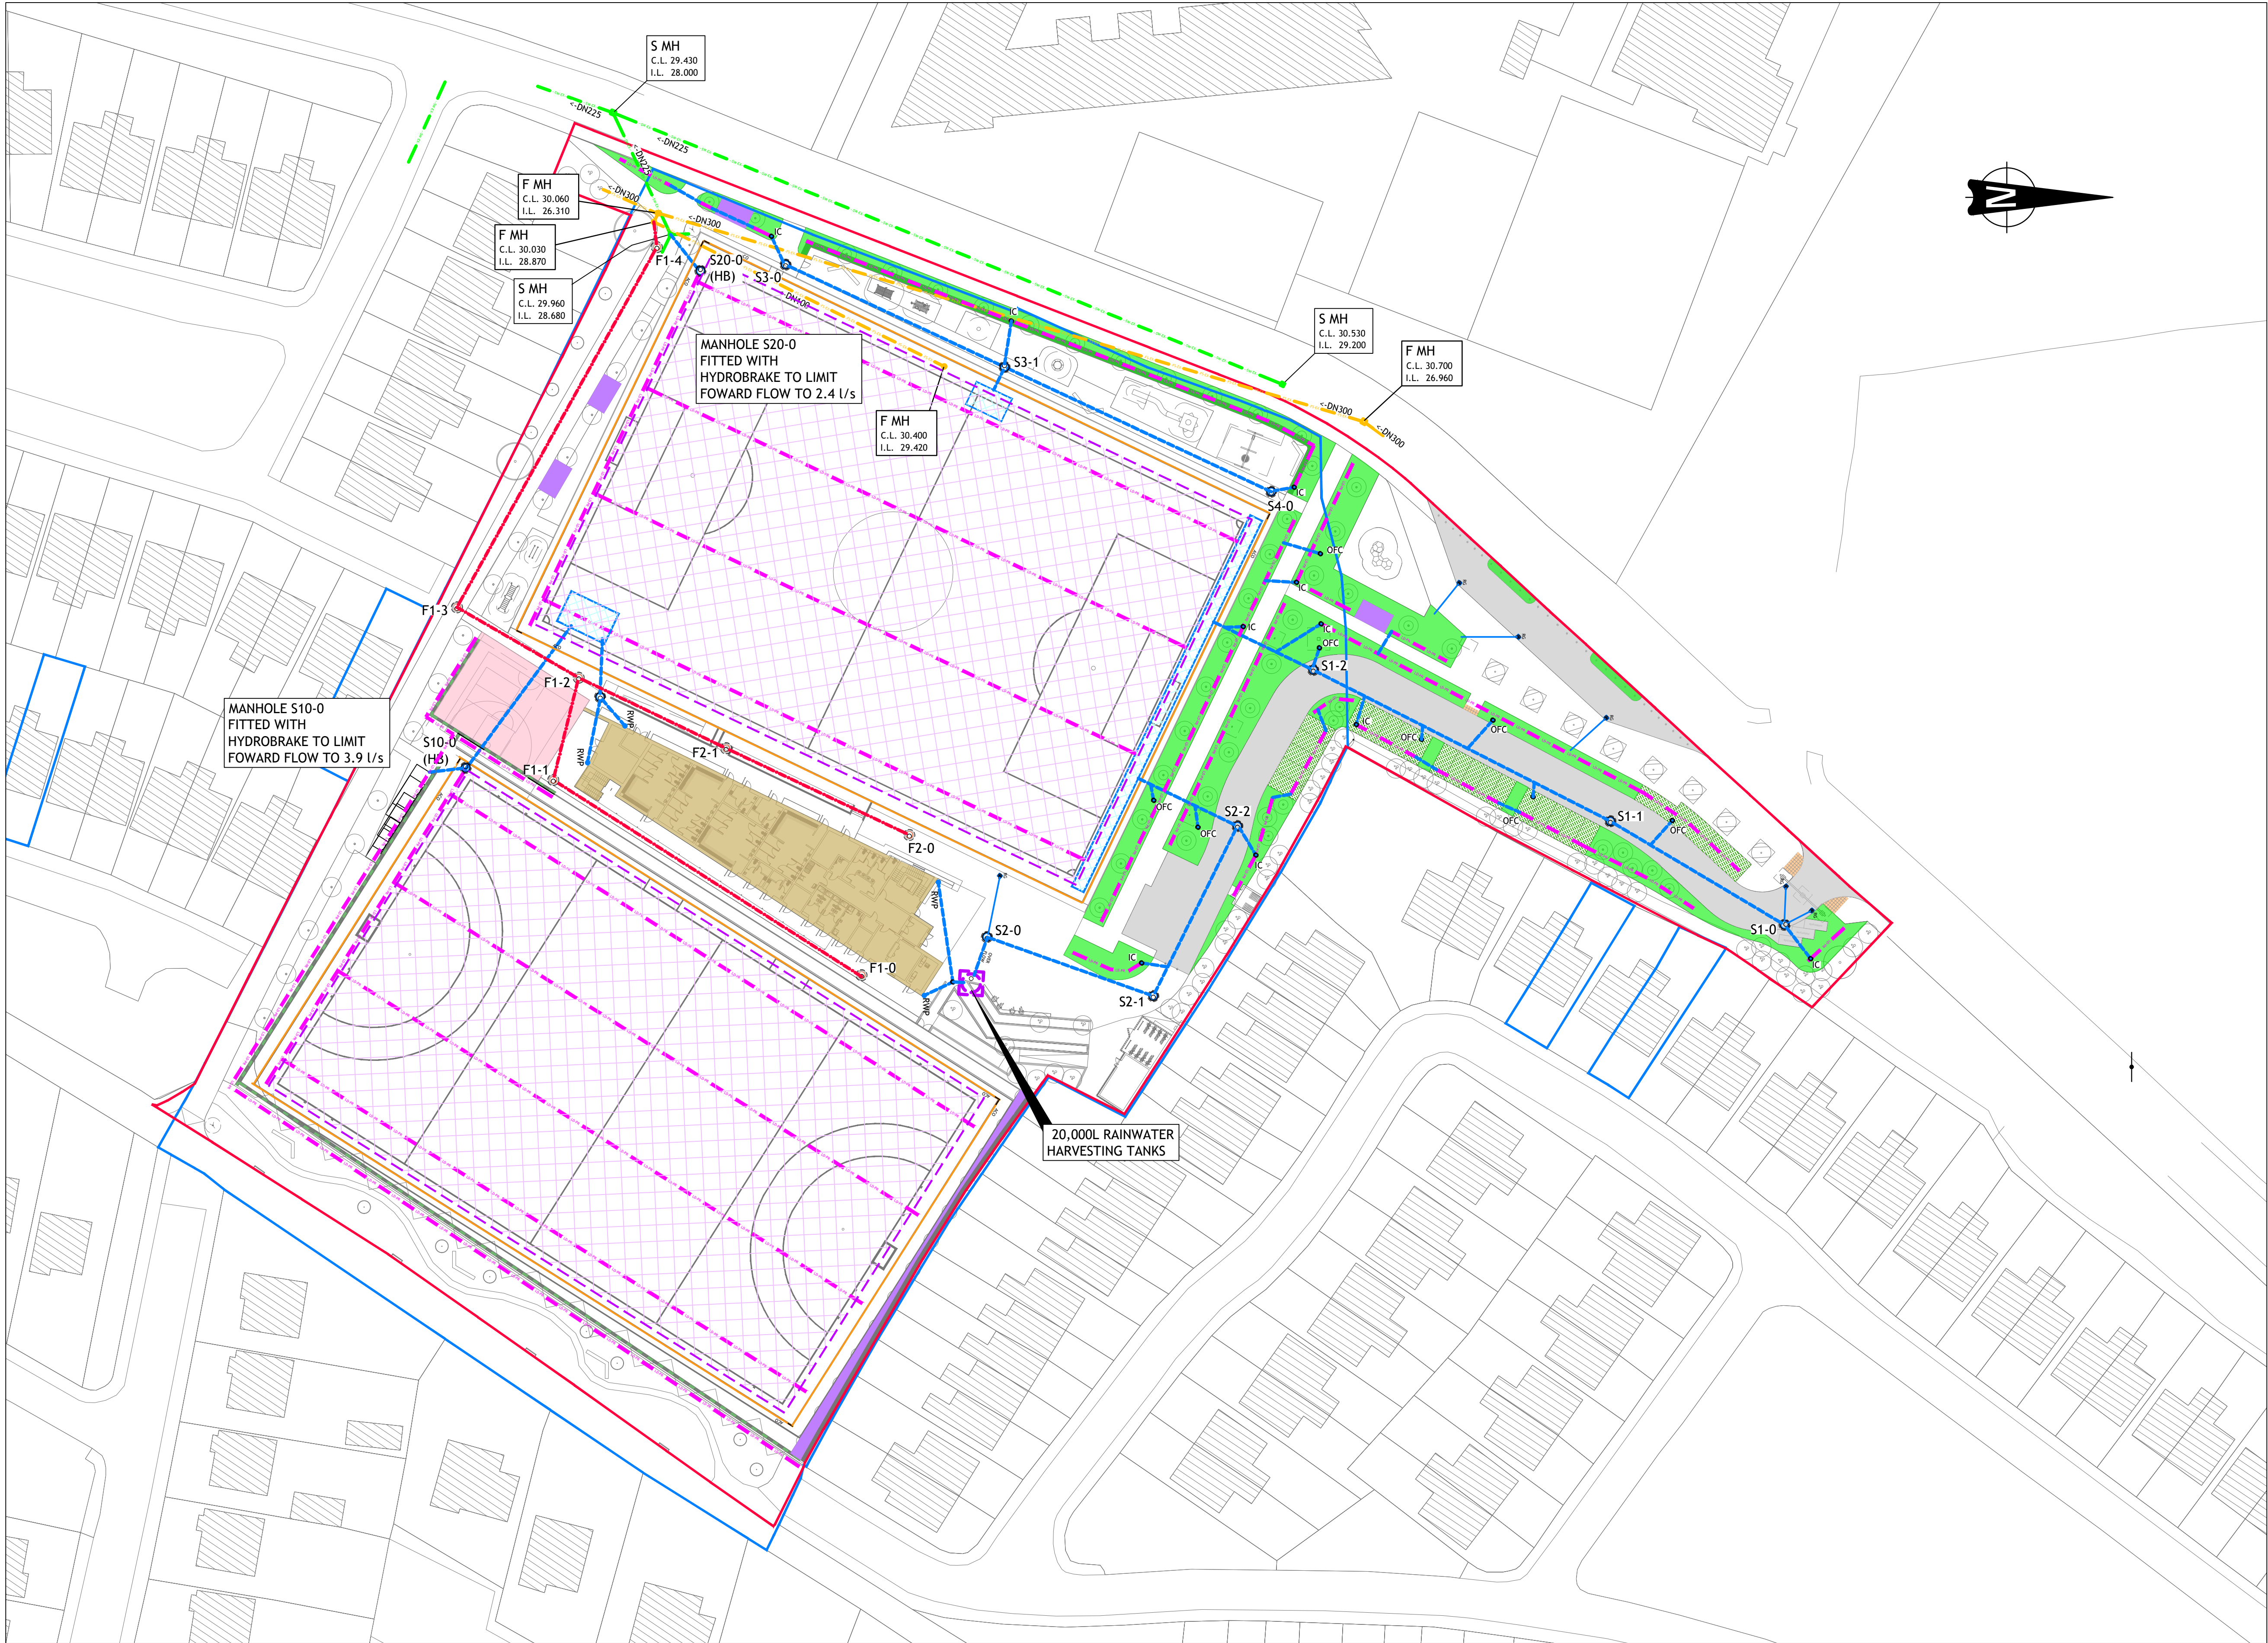

LEGEND

SITE BOUNDARY

LAND WITHIN OWNERSHIP OF THE APPLICANT

PROPOSED BUILDING

EXISTING BUILDING

EXISTING SURFACE WATER SEWER

EXISTING SURFACE WATER MANHOLE

PROPOSED SURFACE WATER SEWER

PROPOSED SURFACE WATER MANHOLE

PROPOSED OVERFLOW CHAMBER

PROPOSED GULLY

EXISTING COMBINED SEWER

EXISTING FOUL SEWER

EXISTING FOUL MANHOLE

EXISTING GULLY

PROPOSED FOUL SEWER

PROPOSED FOUL MANHOLE

PROPOSED FILTER DRAIN

PROPOSED RAINWATER DROP PIPE

PROPOSED ACO DRAINAGE CHANNEL

PROPOSED DIFFUSER BOX

ATTENUATION LAYER UNDER PITCH

S1 - MACADAM CARRIAGEWAY

S2 - PARKING BAYS - REINFORCED GRASS

S8 - SELF BINDING GRAVEL (TO LANDSCAPE ARCHITECTS SPECIFICATION)

S9 - PEDESTRIAN PATH - COLOURED BITUMEN MACADAM

EXTRACT OS SHEETS 3407-B, 3407-13, 3407-14
© ORDNANCE SURVEY IRELAND. ALL RIGHTS RESERVED.
LICENCE NUMBER 2024/24CCMA/GALWAY CITY COUNCIL

Tailte Éireann Licence No. CYAL50443614
© Tailte Éireann - Surveying.

© PUNCH Consulting Engineers

This drawing and any design hereon is the copyright of the Consultants and must not be reproduced without their written consent.
All drawings remain the property of the Consultants.
Figured dimension only to be taken from this drawing.
Consultants to be informed immediately of any discrepancies before work proceeds.



Rev	Amendment	By	Date	Rev	Amendment	By	Date	Client:
P01	FOR REVIEW & COMMENT	PJM	2025-09-17					GALWAY CITY COUNCIL
C01	ISSUED FOR PLANNING	PJM	2025-10-17					
C02	ISSUED FOR PLANNING	PJM	2025-10-31					

PUNCH
consulting engineers
Dublin | Limerick | Cork | Galway | Glasgow
Carleycon House, Main Street, Oranmore,
Co. Galway, H91 T026
t +353 91 703 500 | w punchconsulting.com

Project:	KINGSTON PARK AND MILLERS LANE - PUBLIC PARK AND URBAN REALM PROJECT						
Title:	MILLERS LANE - PROPOSED DRAINAGE LAYOUT						
Drawn:	PJ Mulcahy	Date drawn:	2025-09-17	Technician Check:	PJ Mulcahy	Engineer Check:	Metias McCabe
Project No:	233114	Model Ref:	233114-PUNCH-ML-XX-M2-C-0101	Drawing Status:	A0 (Planning)	Approved:	Matthew Greene
Scale @ A1:	1:500	Document No:	233114-PUNCH-ML-XX-DR-C-0101	Revision No:	C02		