

**Notes**

All dimensions in meters unless otherwise noted.  
 Do not scale from drawings, use figured dimensions only.  
 Refer to site layout plan for finished floor levels

**Drawings are for planning only and should not be used for detailed design. The detailed design will be subject to EirGrid approval based on their latest specification at the time, and equipment dimensions/sitings may vary once the exact specifications are determined.**

**Legend**

**Revisions**

REV	DATE	DESCRIPTION
0	13.10.25	Draft
1	24.11.25	Draft
2	08.12.25	Issued for Planning

Drawn By: RH  
 Approved By: MMC

**Summary**

**Project**  
 Drumdowney Substation & Grid Connection


**Location**  
 Rathpatrick, Co. Kilkenny

**Title**  
 IPP Control Building


**Drawing Number**  
 DRMDY-DR-003

**Scale**  
 1:100 @ A1


Drumdowney Solar Farm Limited  
 Commercial House  
 Millbank Business Park  
 Lucan  
 Co. Dublin

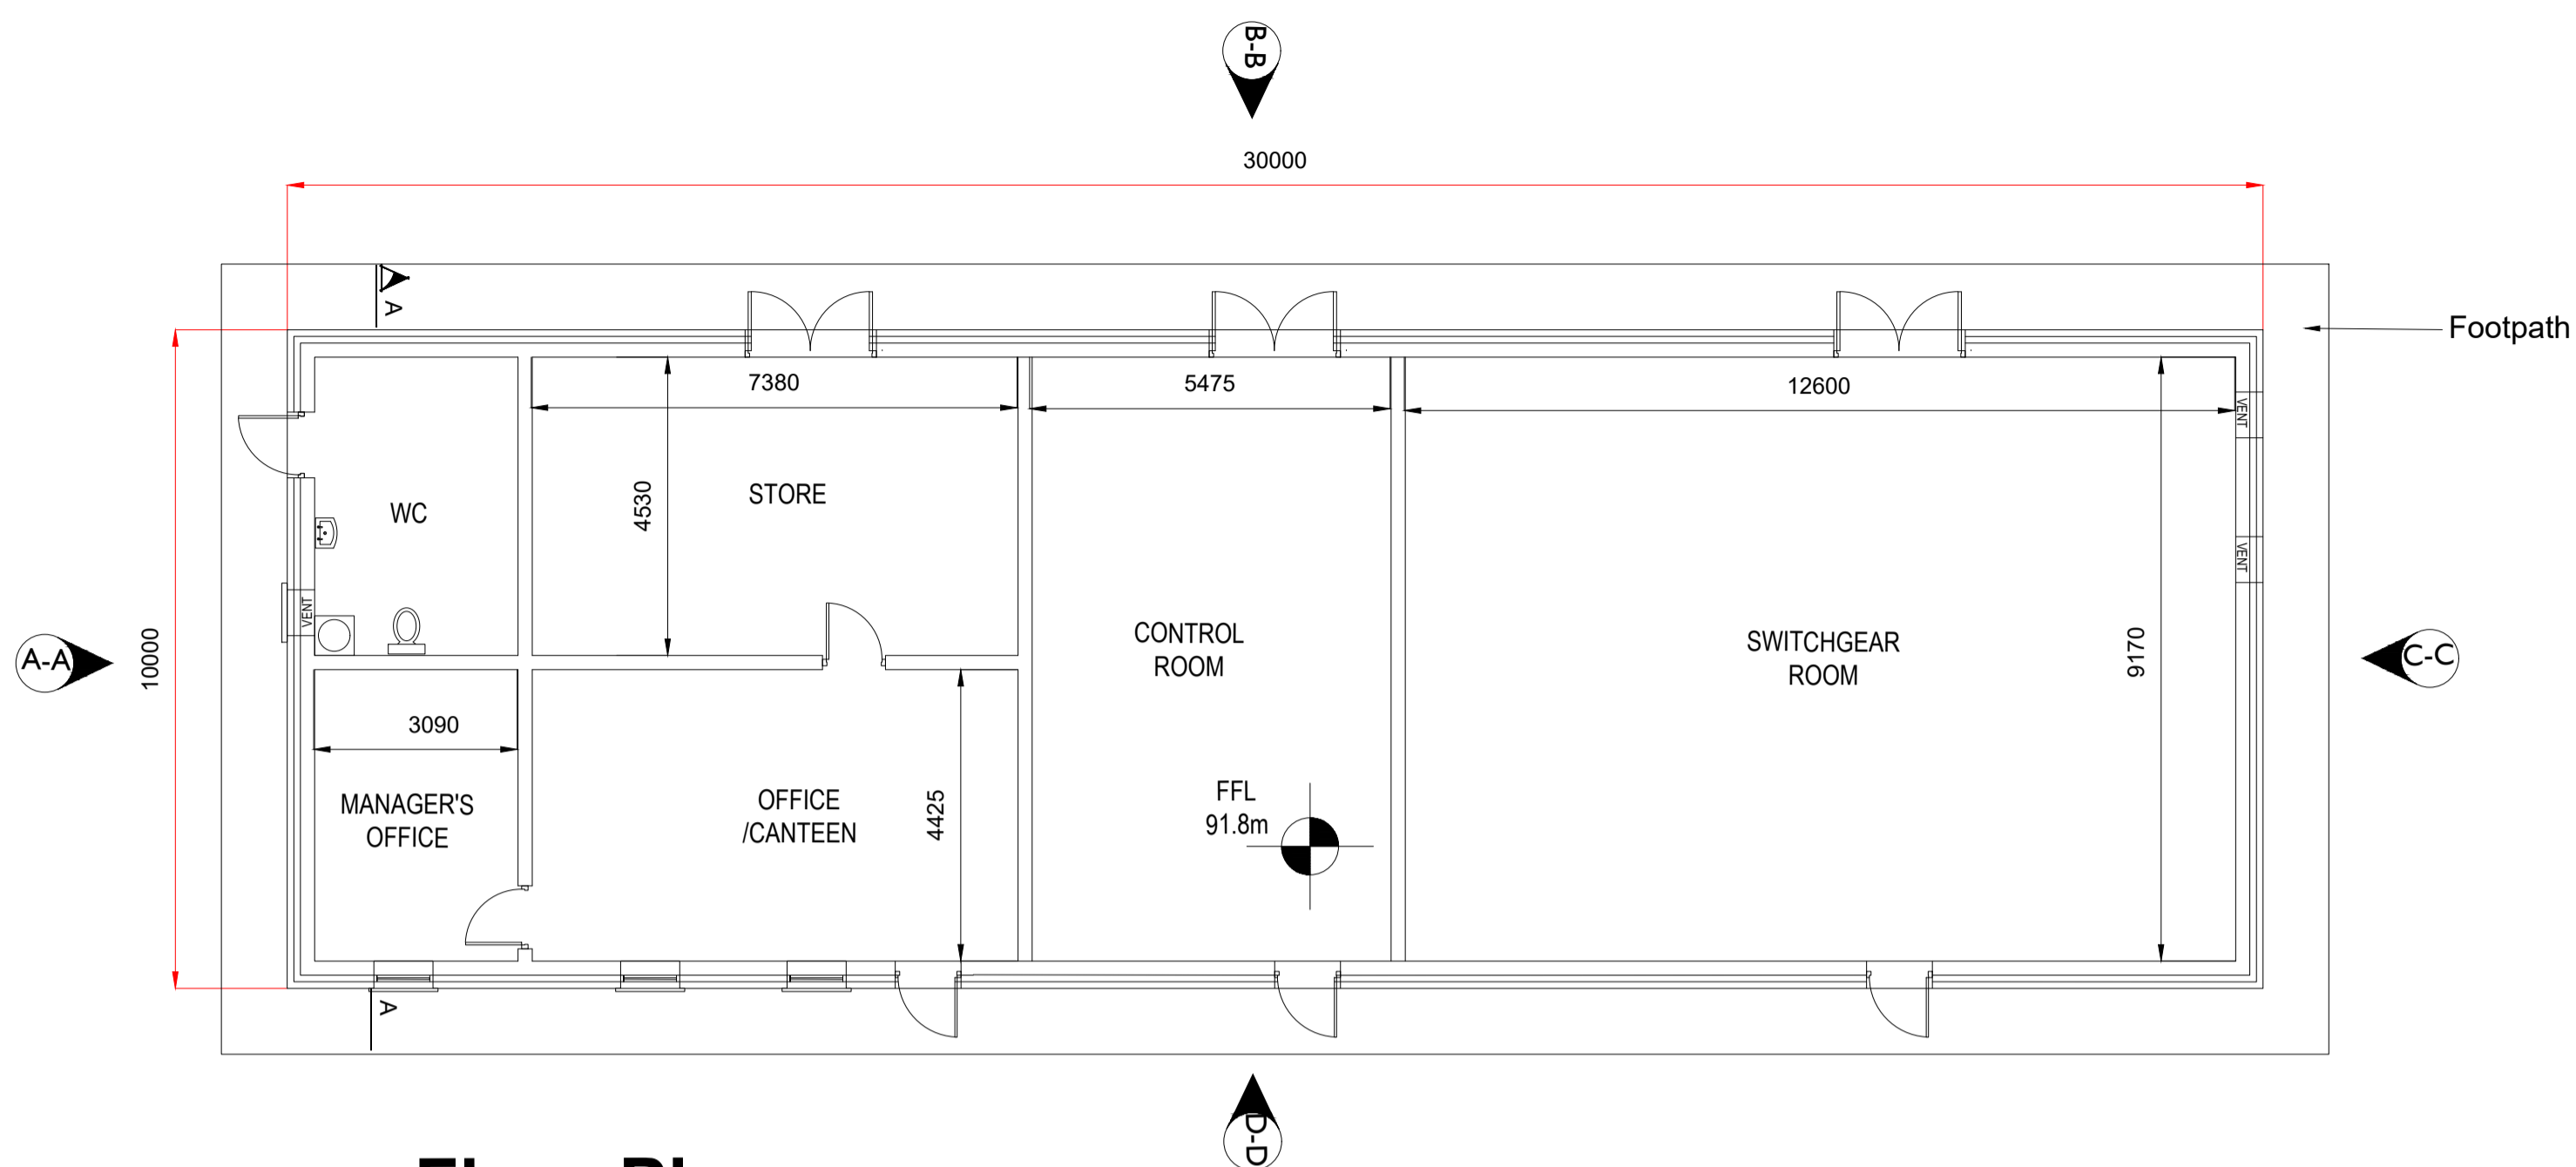


**Floor Plan**  
 Scale 1:100

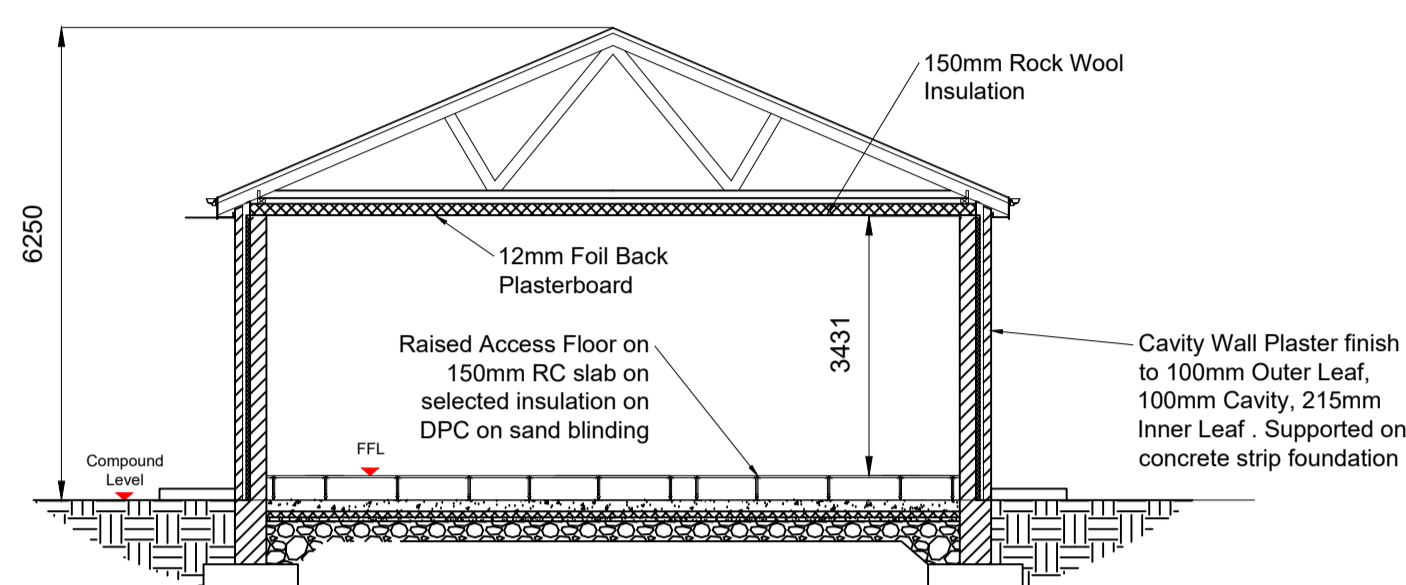


**Section A-A**  
 Scale 1:100

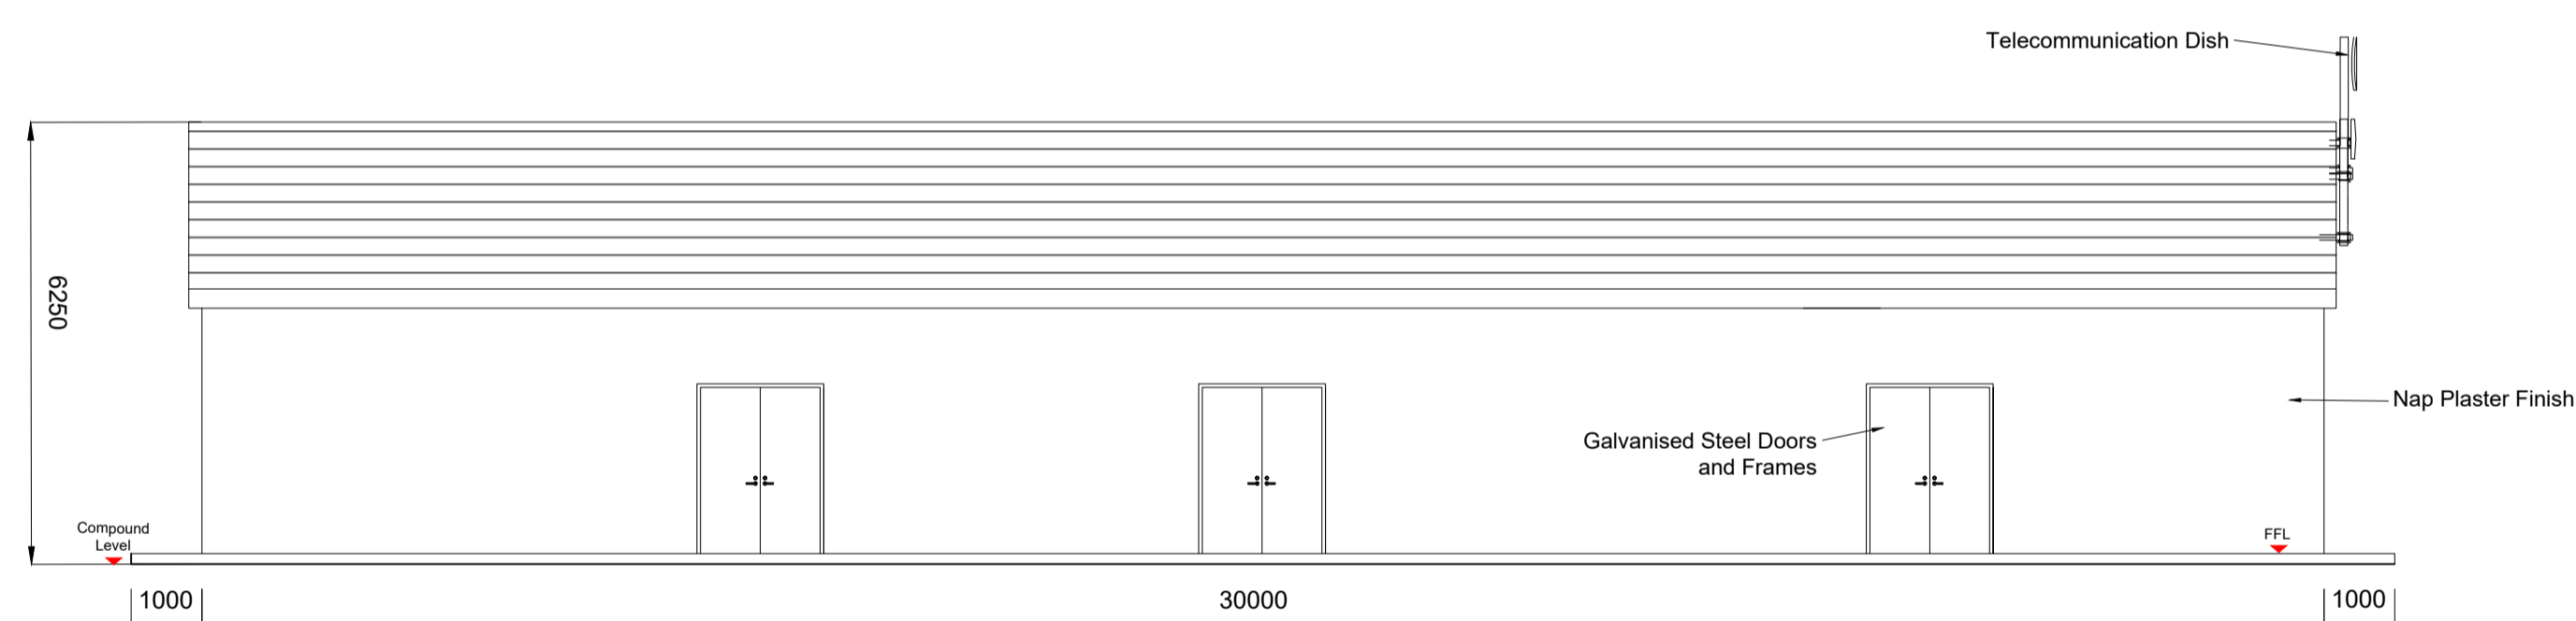


**Elevation B**  
 Scale 1:100

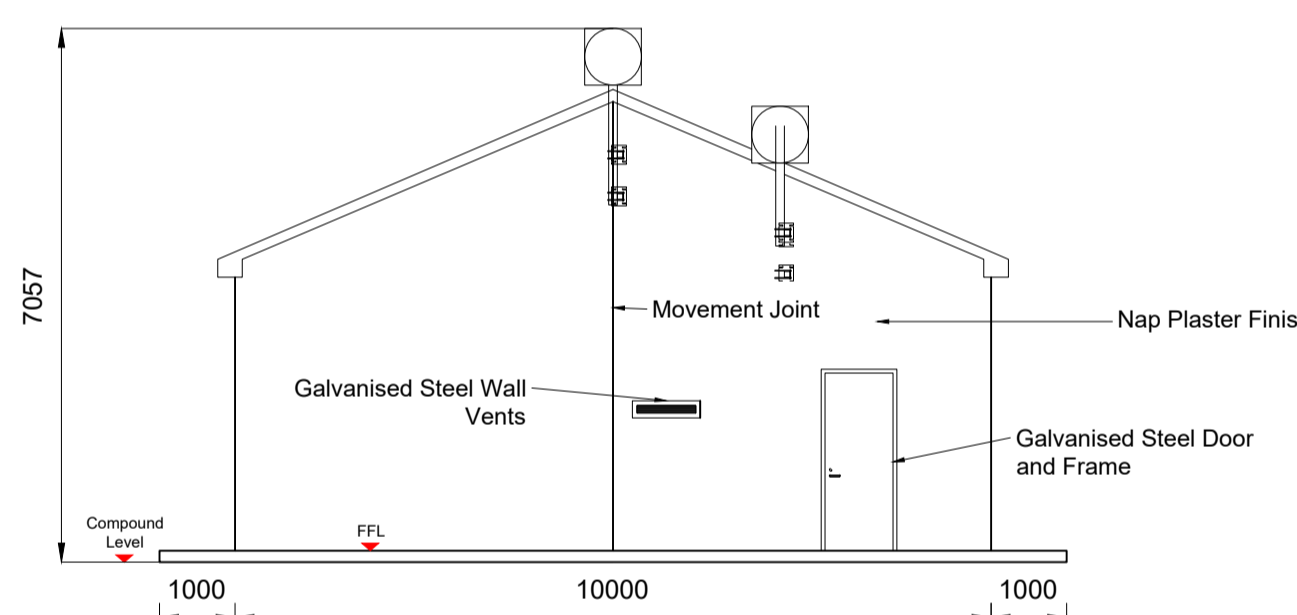


**Elevation A**  
 Scale 1:100

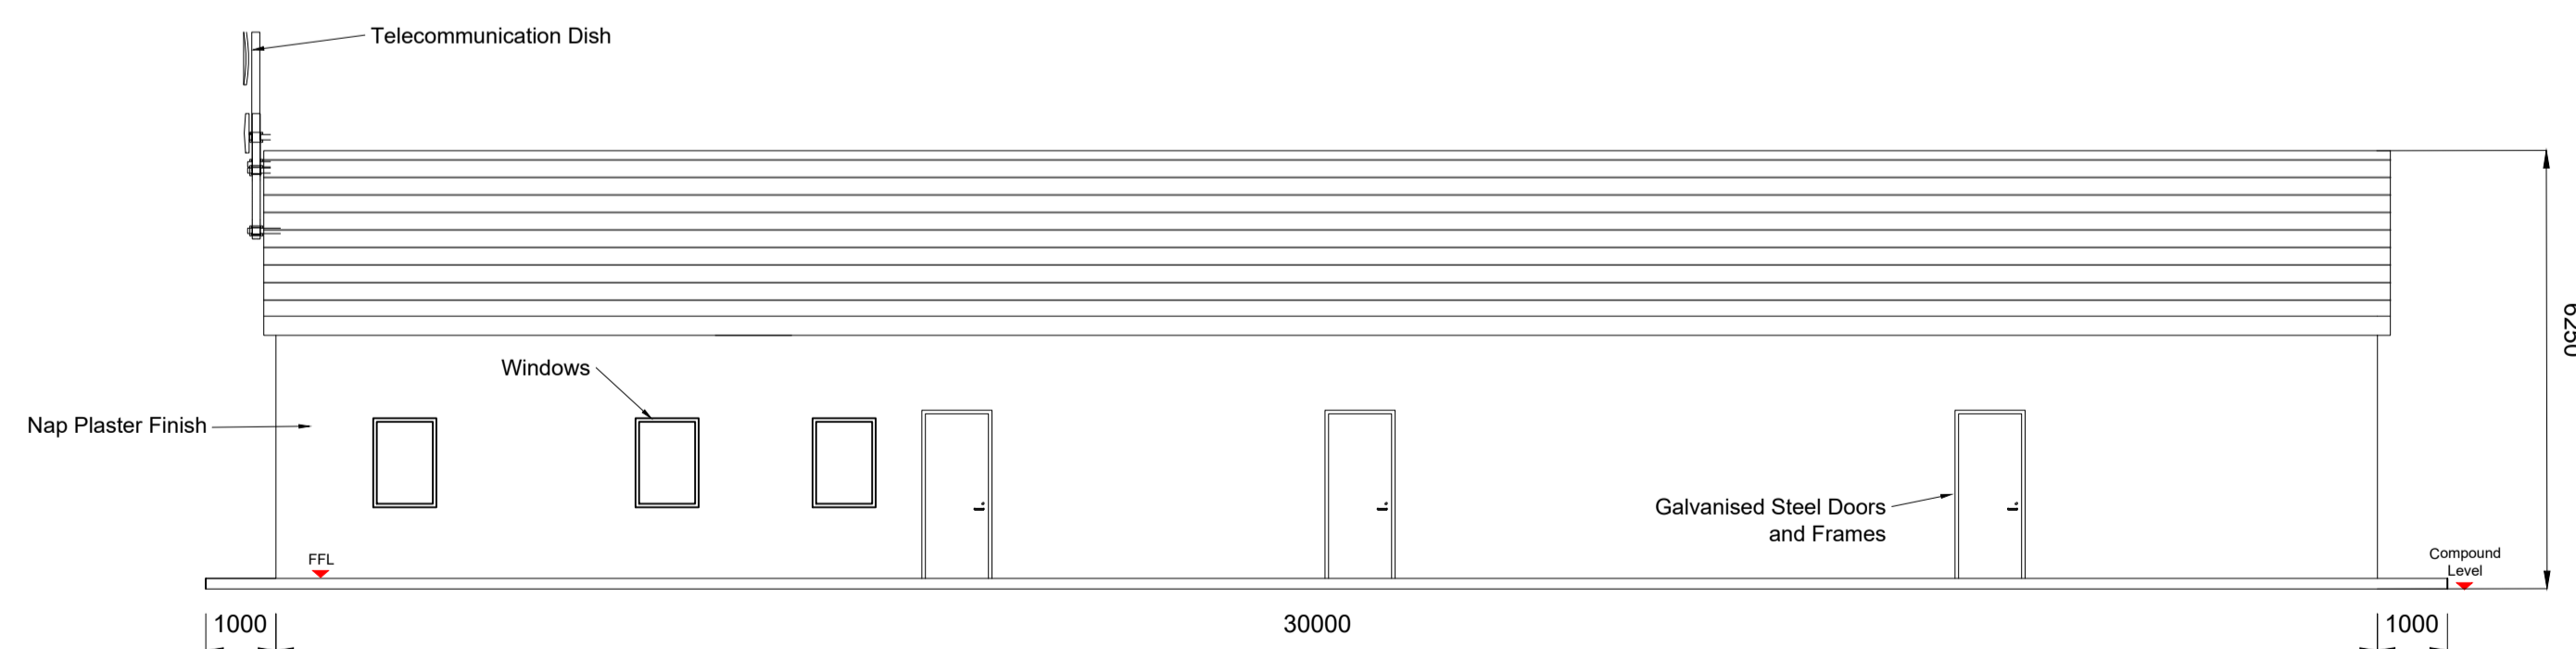

**Elevation D**  
 Scale 1:100

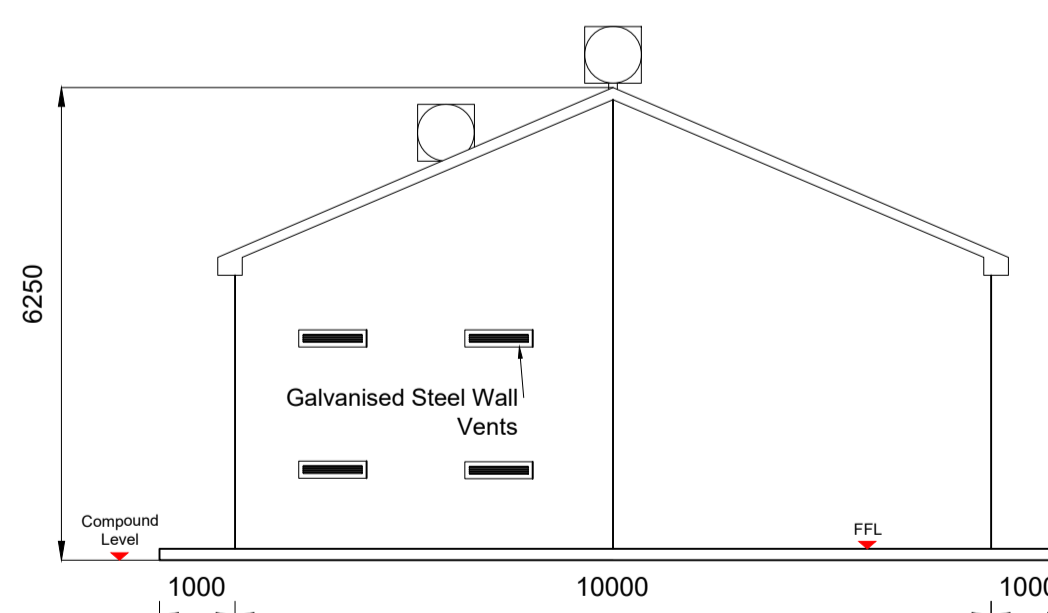

**Elevation C**  
 Scale 1:100

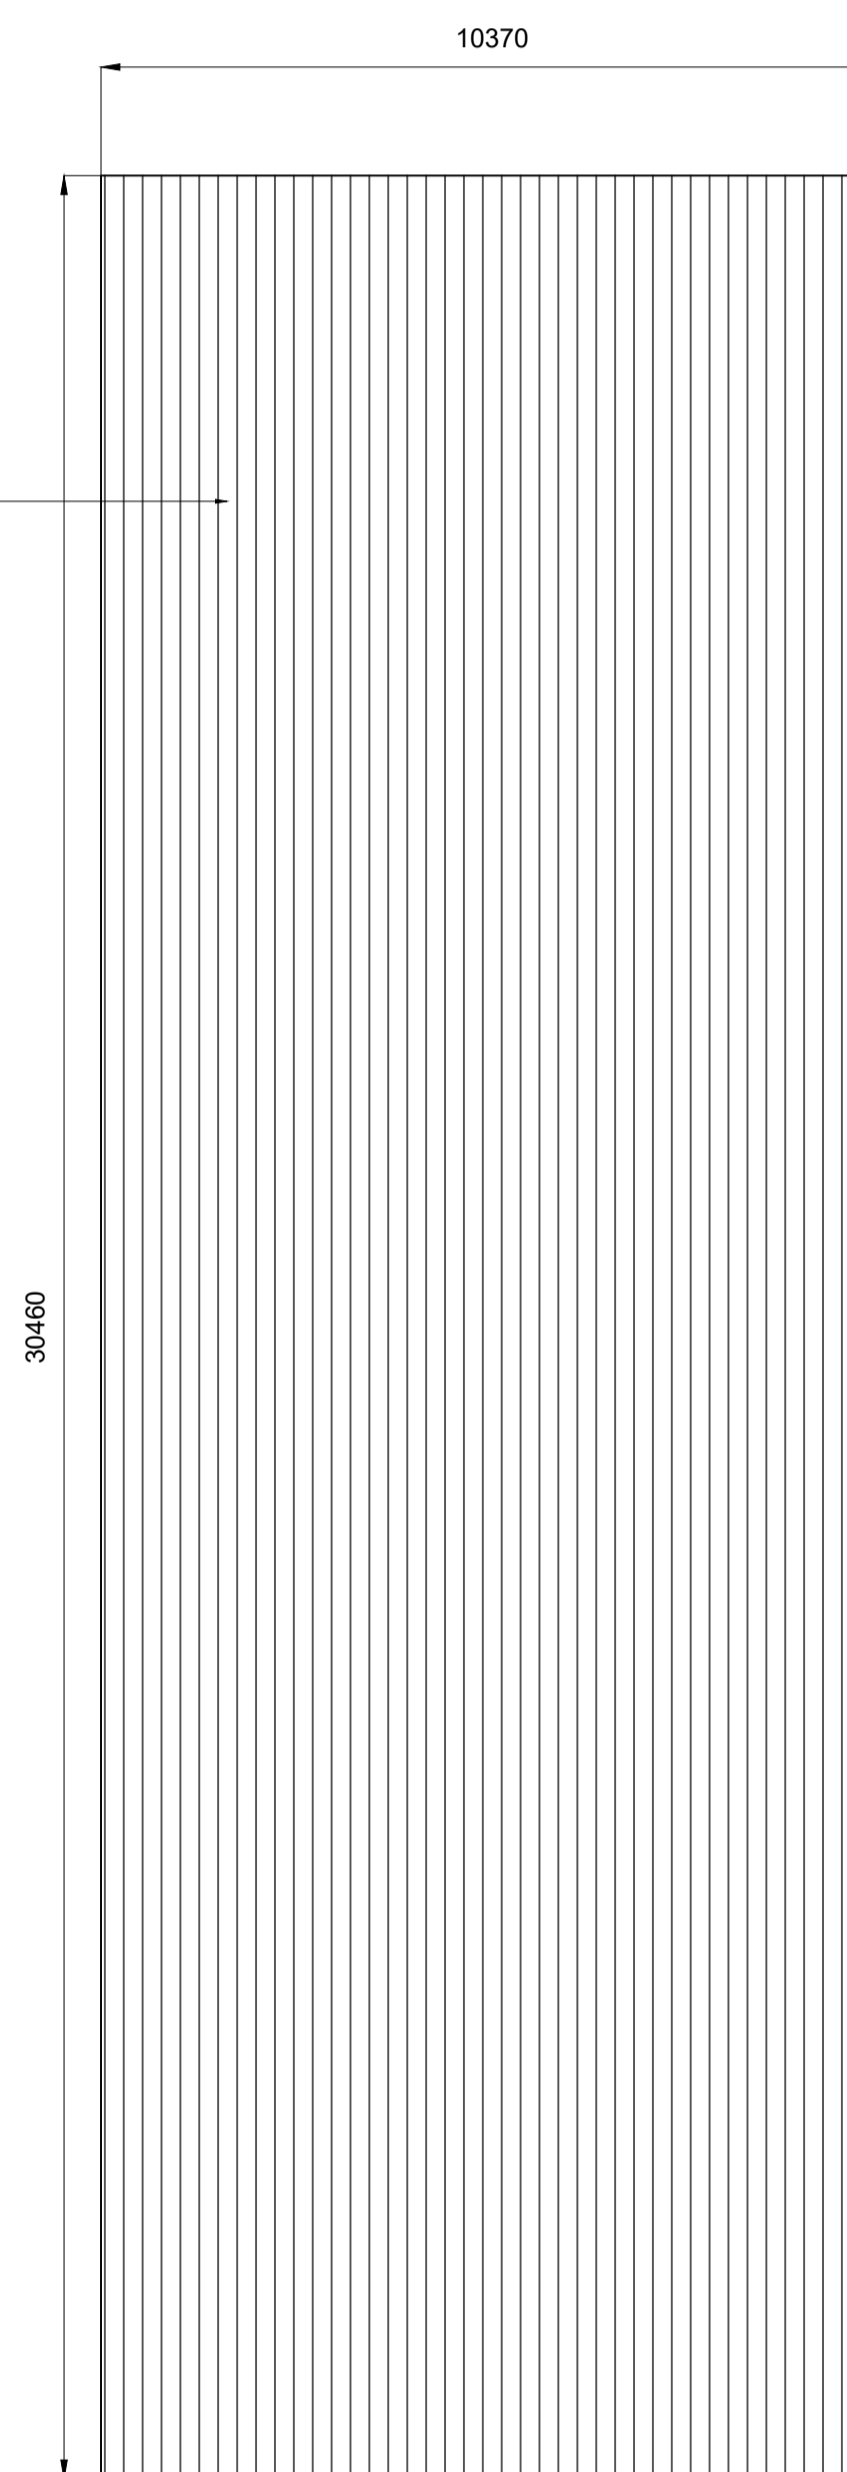

**Roof Plan**  
 Scale 1:100