


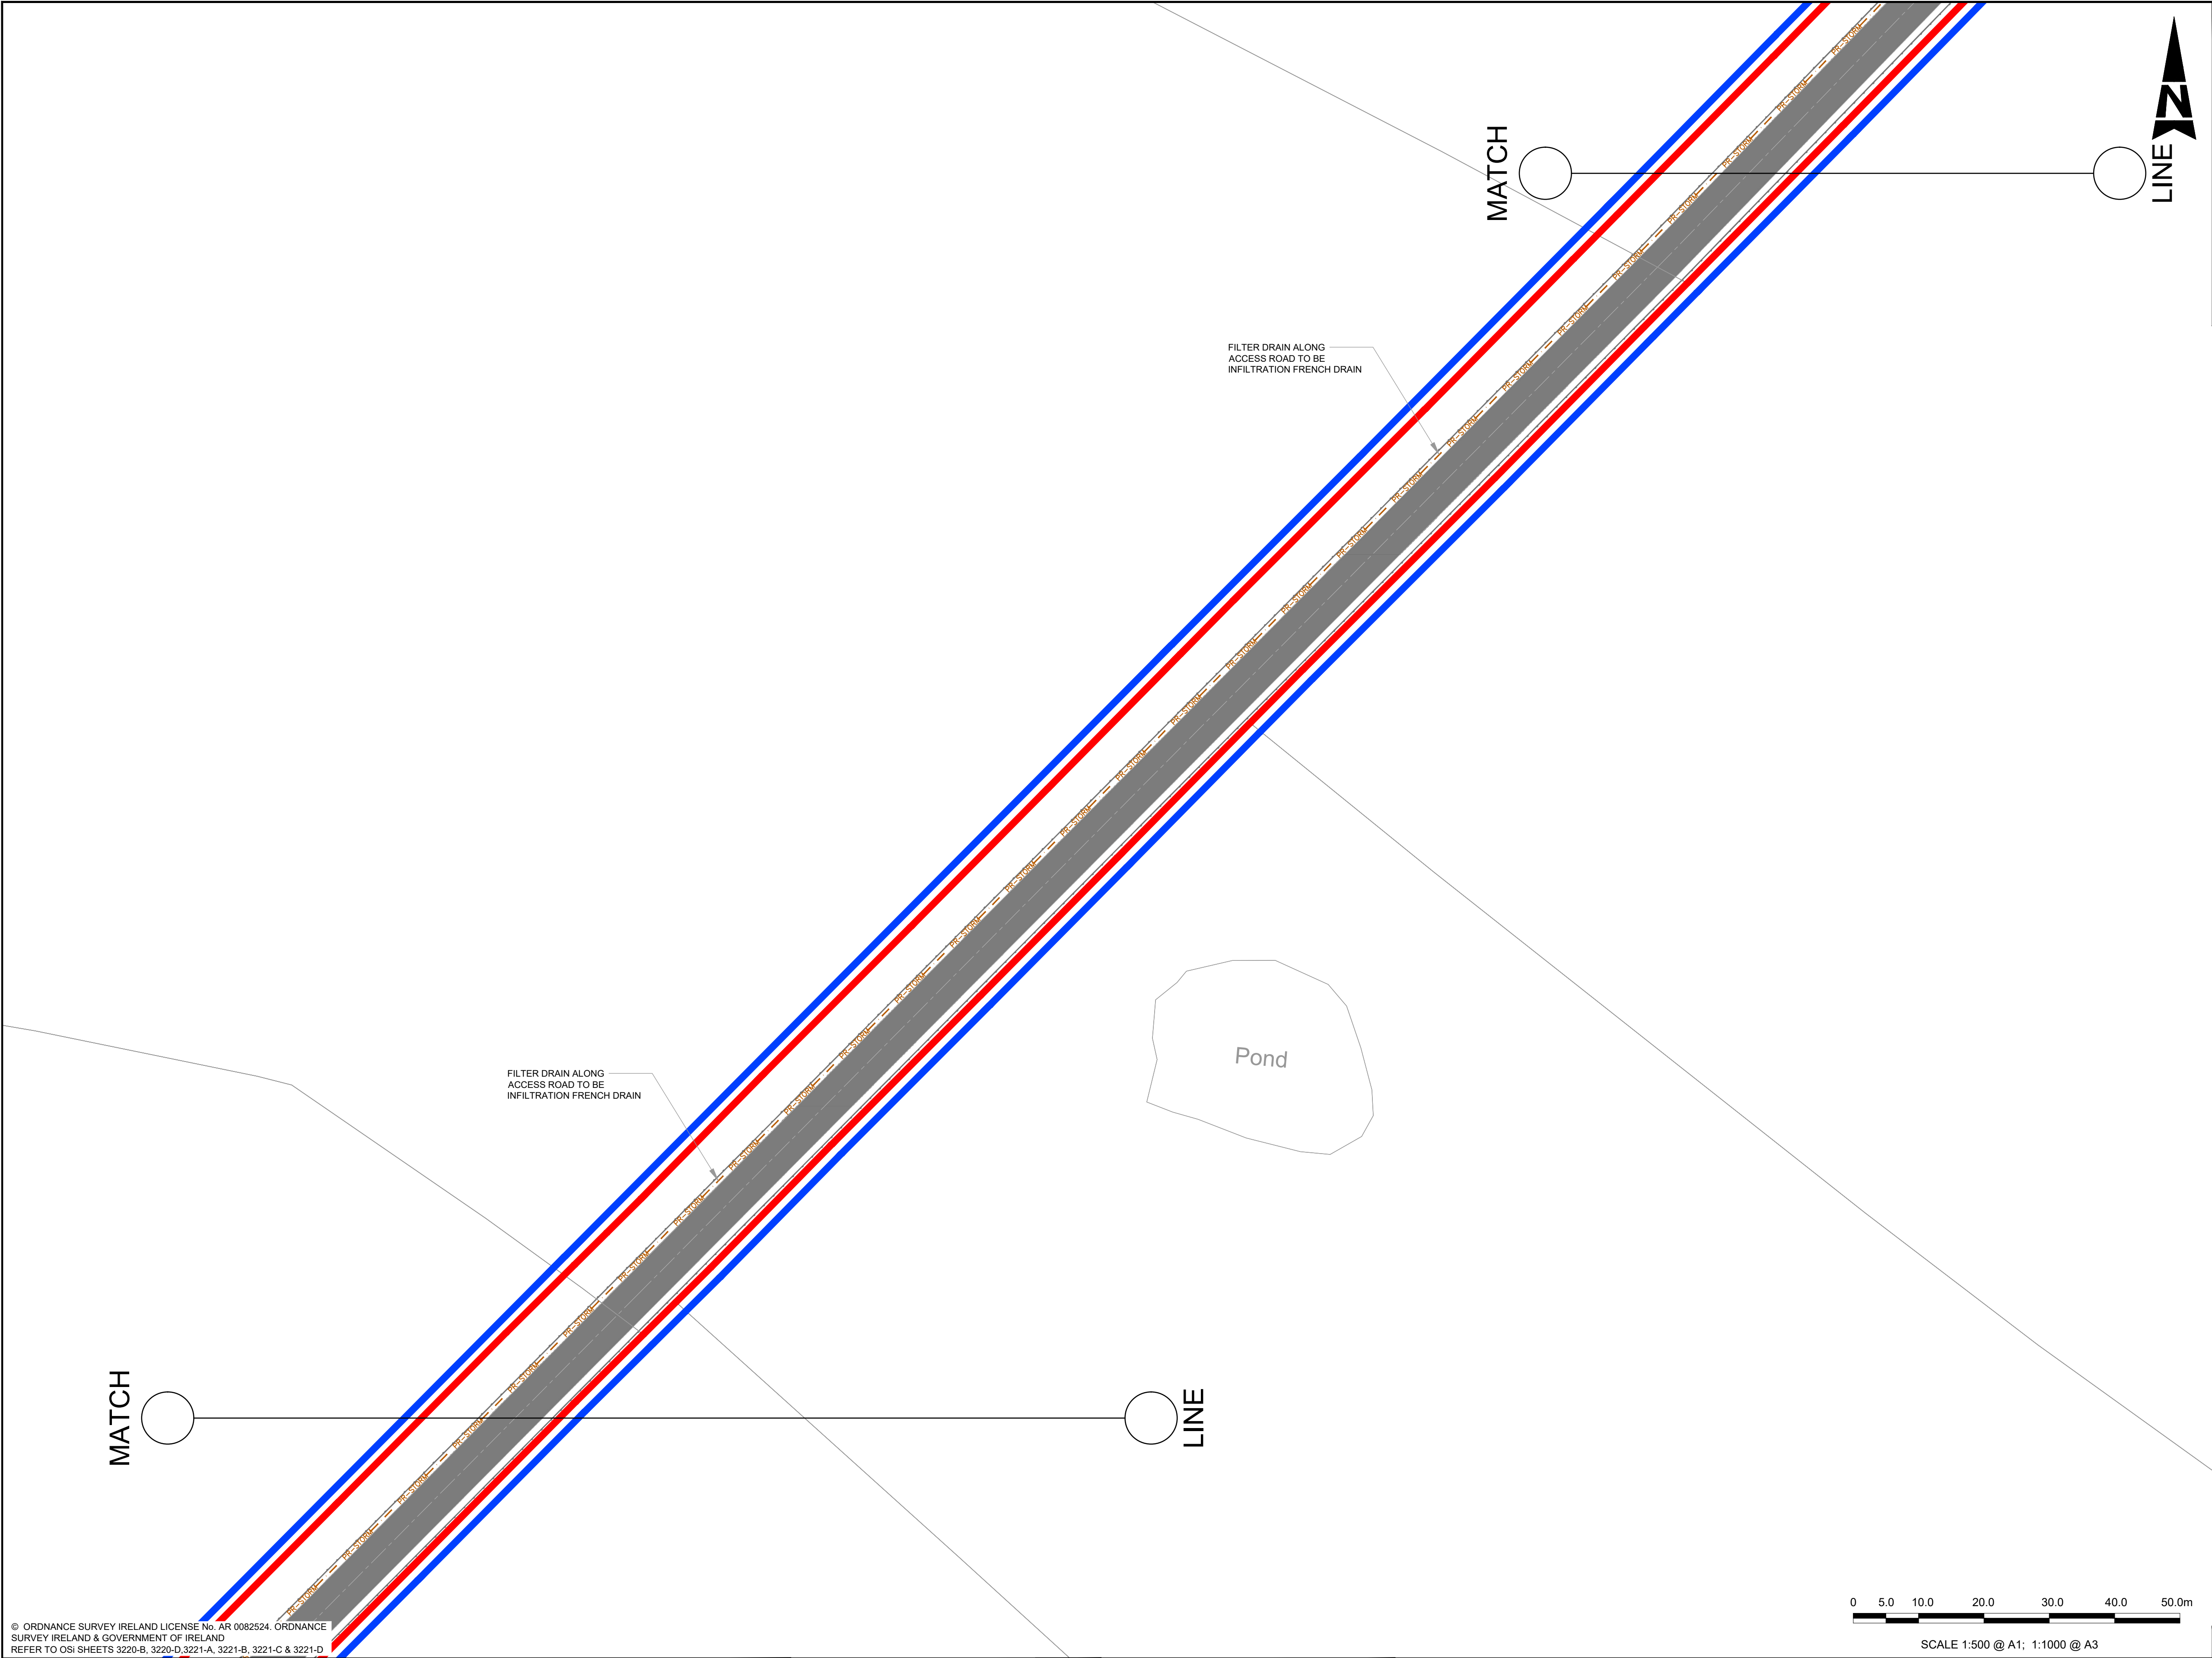

© ORDNANCE SURVEY IRELAND LICENSE No. AR 0082524. ORDNANCE SURVEY IRELAND & GOVERNMENT OF IRELAND REFER TO OSI SHEETS 3220-B, 3220-D, 3221-A, 3221-B, 3221-C & 3221-D.

Rev	Description	By	Date	Chk'd	Auth
0	ISSUED FOR PLANNING	PS	01.12.25	ND	AJB



DUBLIN | CORK | GALWAY | DUNDALK

ATKINS HOUSE, 150 AIRSIDE BUSINESS PARK,
SWORDS, DUBLIN, K67 K5W4.
Tel : +353 1 810 8000 Email : info.ie@atkinsrealis.com



Bord Gáis Energy

CASHLA PEAKER PLANT
Rathmorrisy and Pollnagroagh
(Townlands), Athenry, Co. Galway.

GENERAL NOTES

- ALL DIMENSIONS ARE IN METERS UNLESS NOTED OTHERWISE
- ONLY WRITTEN DIMENSIONS SHALL BE USED. NO DIMENSIONS SHALL BE SCALED FROM THE DRAWINGS
- ALL LEVELS ARE IN METERS AND ARE TO MALIN HEAD DATUM
- ALL COORDINATES ARE IN METERS AND ARE TO IRISH TRANSVERSE MERCATOR
- DRAWINGS ARE TO BE READ IN CONJUNCTION WITH THE SPECIFICATION
- THIS DRAWING IS TO BE USED ONLY FOR THE PURPOSES OF THE PLANNING APPLICATION AND IS SUBJECT TO DETAILED DESIGN.

LEGEND

- PROJECT BOUNDARY FOR PLANNING
- LAND OWNERSHIP BOUNDARY
- PR-STORM
- PROPOSED FILTER DRAIN

Purpose	PLANNING				
Title	STORM DRAINAGE LAYOUT SHEET 04				
Original Scale	Design/Drawn	Checked	Authorised		
1:500 at A1	PS	ND	AJB		
Date	01.12.25	Date	01.12.25	Date	01.12.25
Status	Drawing Number			Rev	
A2	PEK3-ATK-ZZ-01-DR-CE-900504			0	