



110 kV Circuit - Grid Route Line Diagram

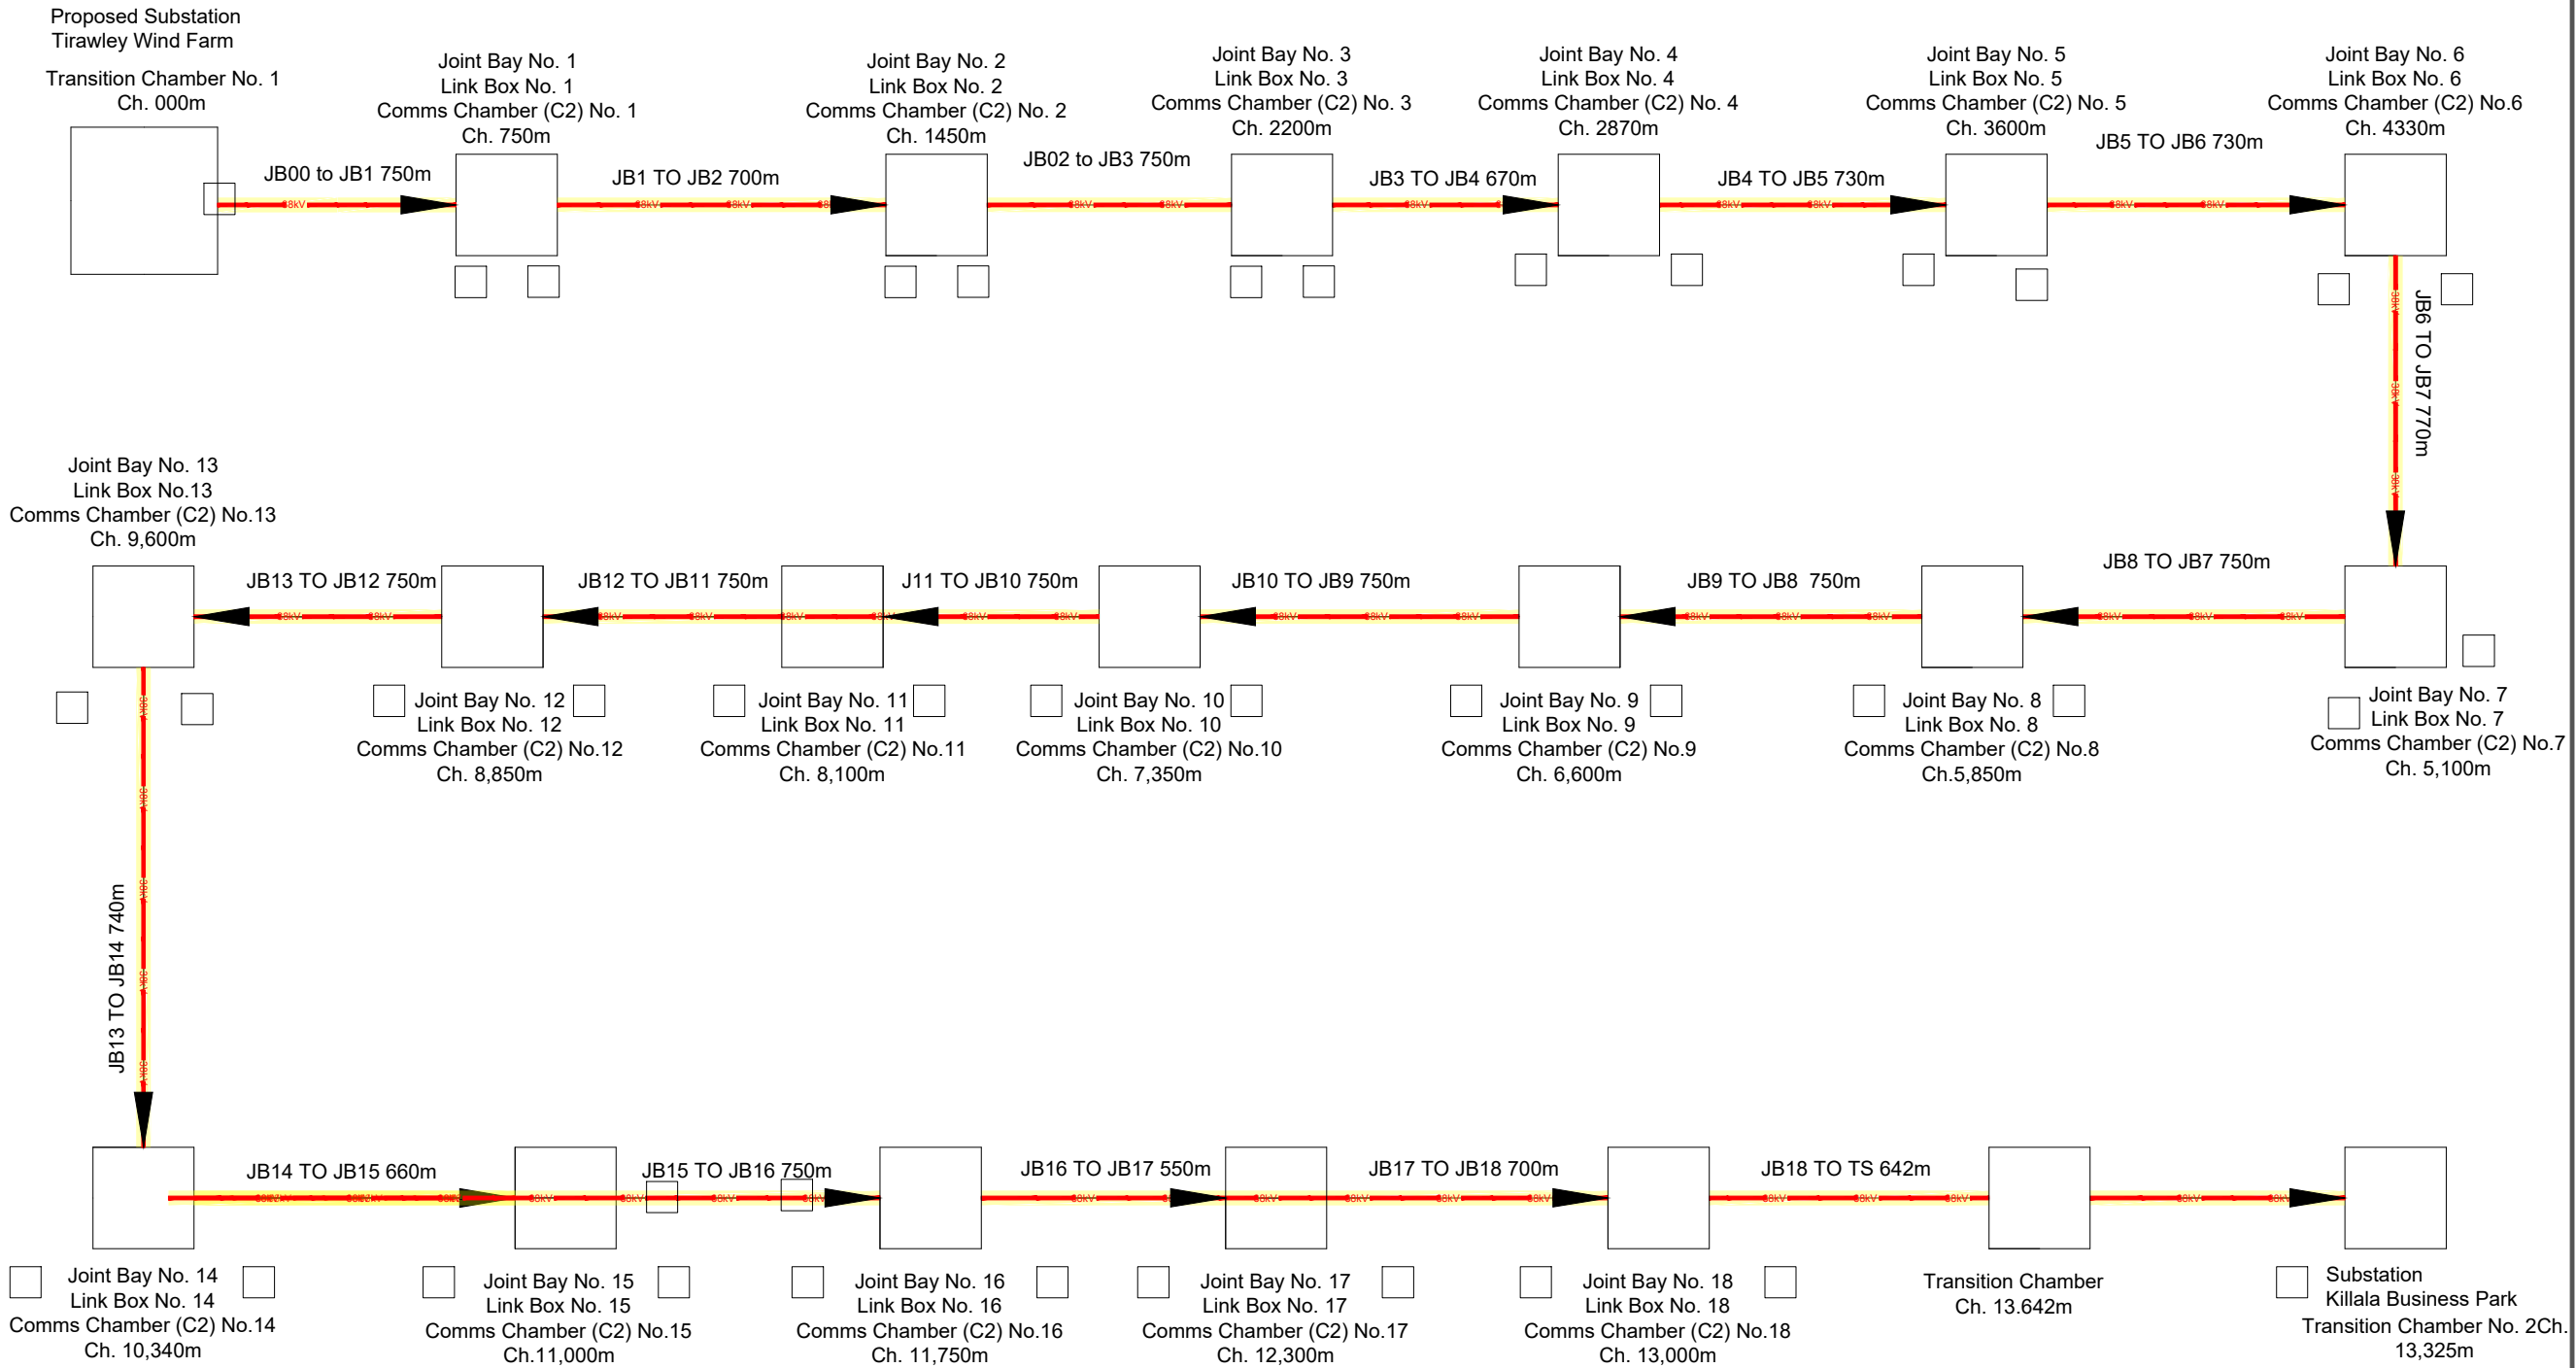

rev.	modifications	D	C	A

Client	CONSTANT ENERGY LTD
Project	TIRAWLEY WIND FARM CO. MAYO
Stage	PLANNING
Title	CABLE ROUTE OVERVIEW SINGLE LINE DIAGRAM
Scales	NTS (A3)
Surveyed	JOD
Prepared	LB
Checked	MG / DT
Approved	DK
Date	April 2026

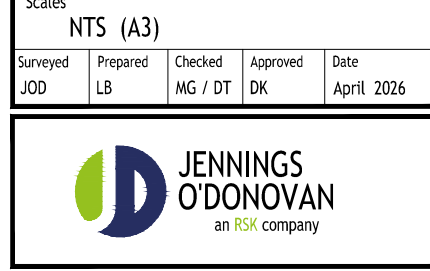

© COPYRIGHT OF
JENNINGS O'DONOVAN AND PARTNERS LIMITED
FINISKLIN Tel (+353) 719 161 416
SLIGO Email. info@jodireland.com
IRELAND www.jodireland.com

@JOD_Sligo Jennings O'Donovan & Partners

Drawing no.	6289-PL-GR-1400	Revision	
-------------	-----------------	----------	--