
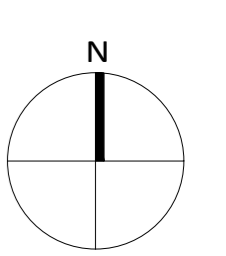


- 12m High Acoustic Wall
- Retaining Wall
- Woodland Meadow Mix
- Wild Flower Meadow
- Main Roadway: Tarmacadam (to Engineer's Specification)
- New Tree Proposed Planting
- Concrete: In-situ concrete. Brushed with trowel edge finish (to Engineer's Specification)
- Existing Hedge Retain
- Fence 3m high
- Native Hedge

Site Extent - NTS

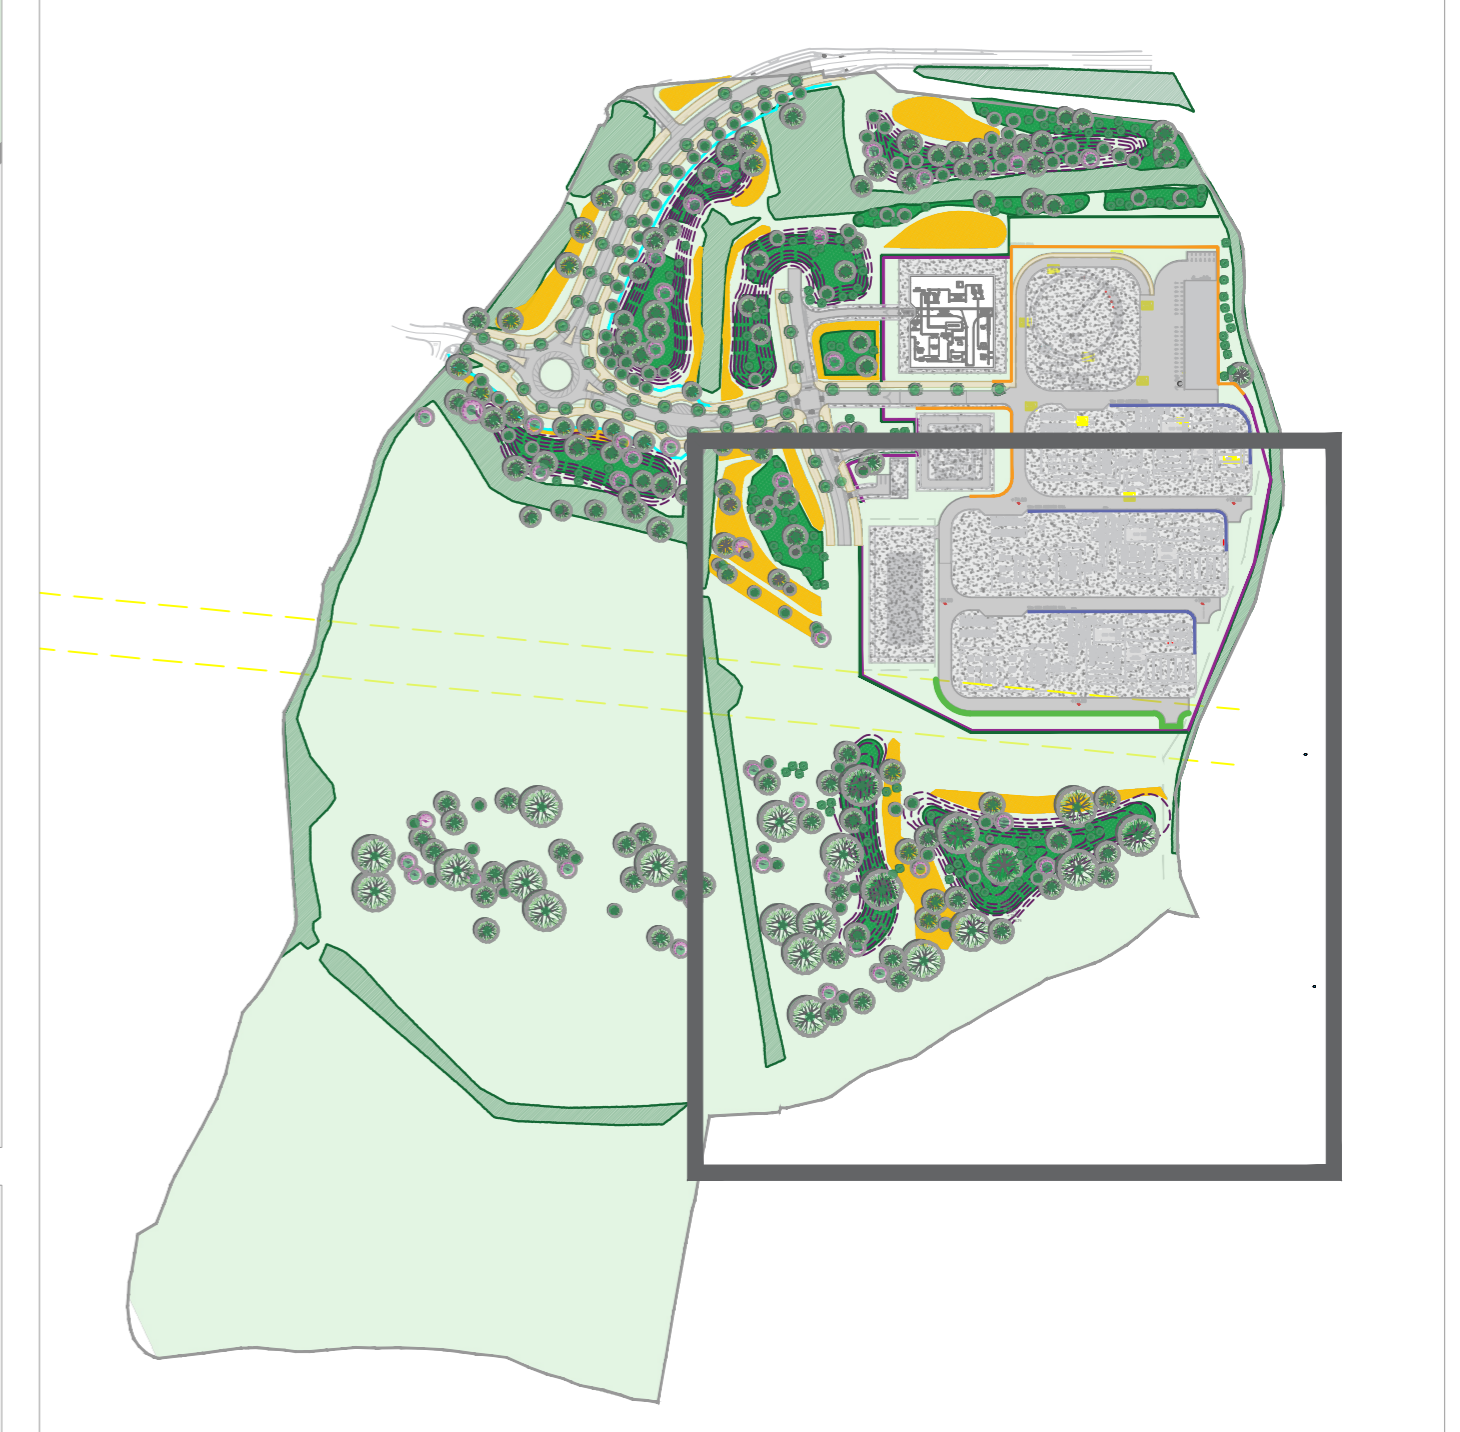

- Existing Hedges**
To be retained
- SOFT LANDSCAPE**
Proposed Tree Planting
Fagus sylvatica 'Davyck', Quercus robur, Fagus sylvatica, Aesculus hippocastanum, Pinus sylvestris, Salix alba tristis, Acer pseudoplatanus, Acer platanoides, Prunus avium, Juglans regia
- Amenity Grass - Public Area**
300mm min. Topsoil depth
- Mounding**
- Woodland Meadow Mix**
Species Name
Allium ursinum, Campanula latifolia, Circea lutetiana, Digitalis purpurea, Fragaria vesca, Geranium robertianum, Geum urbanum, Hyacinthoides non-scripta, Hypericum pulchrum, Primula vulgaris, Silene dioica, Silene flos-cuculi, Stachys sylvatica, Teucrium scorodonia, Torilis japonica, Vicia sepium, Viola riviniana.
- Wild Flower Meadow**
An appropriate dry meadow type with wildflowers for these areas would simulate NVC type MG5. Appropriate herbs for this type of meadow include:
Common knapweed (Centaurea nigra), Ribwort plantain (Plantago lanceolata), Red clover (Trifolium pratense), Bird's-foot trefoil (Lotus corniculatus), Bulbous buttercup (Ranunculus bulbosus), Meadow buttercup (Ranunculus acris), Lady's-bedstraw (Galium verum), Cowslip (Primula veris), Oxeye daisy (Leucanthemum vulgare), Yellow Rattle (Rhinanthus minor), Common sorrel (Rumex acetosa), Burnet saffrage (Pimpinella saxifraga), Autumn hawkbit (Leontodon autumnalis), Rough hawkbit (Leontodon hispidus)

- H1 - Proposed Native Hedgerow**
450mm topsoil dept/100cm Double Staggered Row
Species Name
Craetagus monogyna, Prunus spinosa, Ilex aquifolium, Rosa canina, Lonicera periclymenum 'Graham Thomas'
- HARD LANDSCAPE**
Main Roadway
(to Engineer's Specification)
Tarmacadam or similar approved
- Concrete**
(to Engineer's Specification)
In-situ concrete. Brushed with trowel edge finish or similar approved
- Cycle Path**
(to Engineer's Specification)
Tarmacadam, colour to be decided or similar approved

- BOUNDARY TREATMENTS**
Boundary Treatment 1
System Fence 3m high or similar approved
- Boundary Treatment 2**
2m High Butt wall and Railing or similar approved
- Boundary Treatment 3**
12m High Acoustic Wall or similar approved
- Boundary Treatment 4**
Retaining Wall or similar approved

Project Title: **Kilshane Power Plant SID**

REV	DATE	BY	CHECKED	DESCRIPTION
D	28/11/2025	MSC	RMD	Draft
C	21/11/2025	MSC	RMD	Draft
B	31/07/2025	MSC	RMD	Draft
A	30/07/2025	MSC	RMD	Draft
00	12/06/2025	MSC	RMD	Draft

Client: Kilshane Energy Ltd.	Dwg No. 01
Drawing Title: Landscape Masterplan	Scale 1,500
Job No. 1961	Date 12/06/2025

RMDA
LANDSCAPE ARCHITECTS + CONSULTANTS

Ronan MacDiarmada + Associates Ltd.
Landscape Architects and Consultants.
Gort Na Si, Main Street, Newcastle, Co. Dublin. D22A314

tel: +353 1 412 4476
e-mail: info@rmda.ie

This Drawing is Copyright ©