


**D1** Tree Planting Detail - Double Staking  
Extra heavy standard trees (in excess of 14cm girth)  
Scale 1:20


Note: Trees to be a minimum of 5-7m away from Light Standards

End Elevation  
(not to scale)

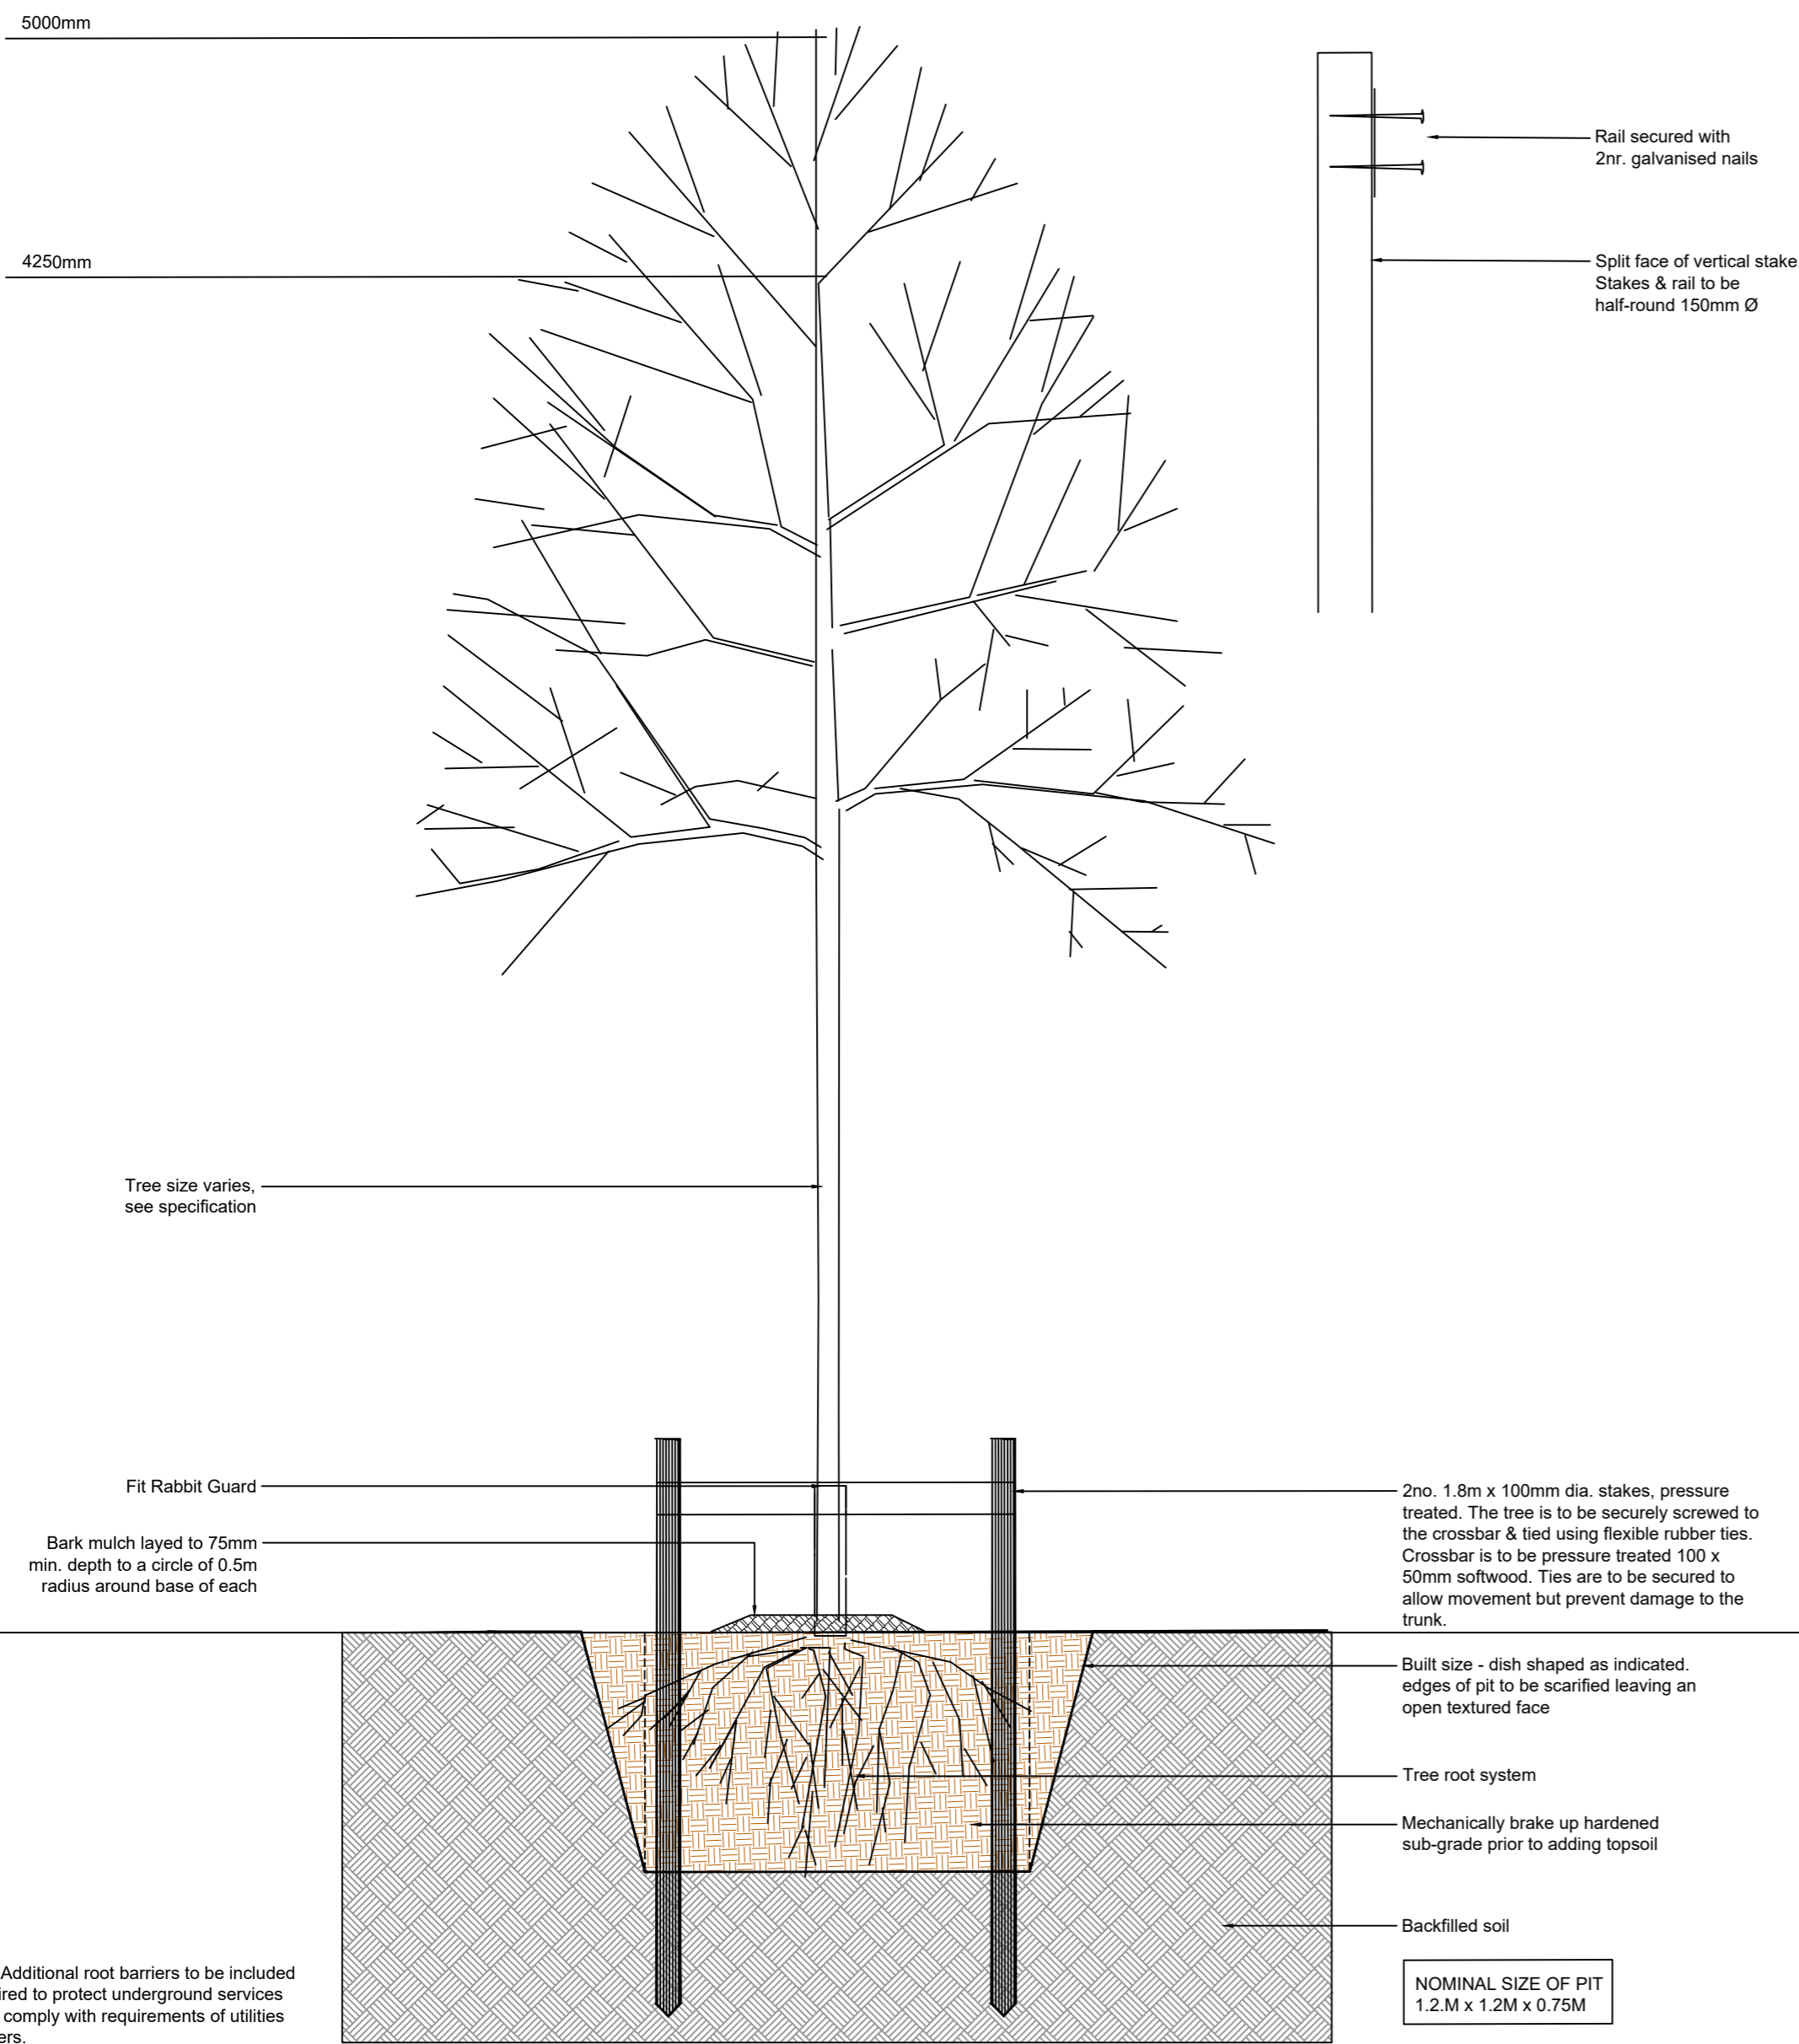


**D2** Tree Planting Detail - Single Staking  
Standard Tree less than 14cm girth  
Scale 1:20


Note: Trees to be a minimum of 5-7m away from Light Standards

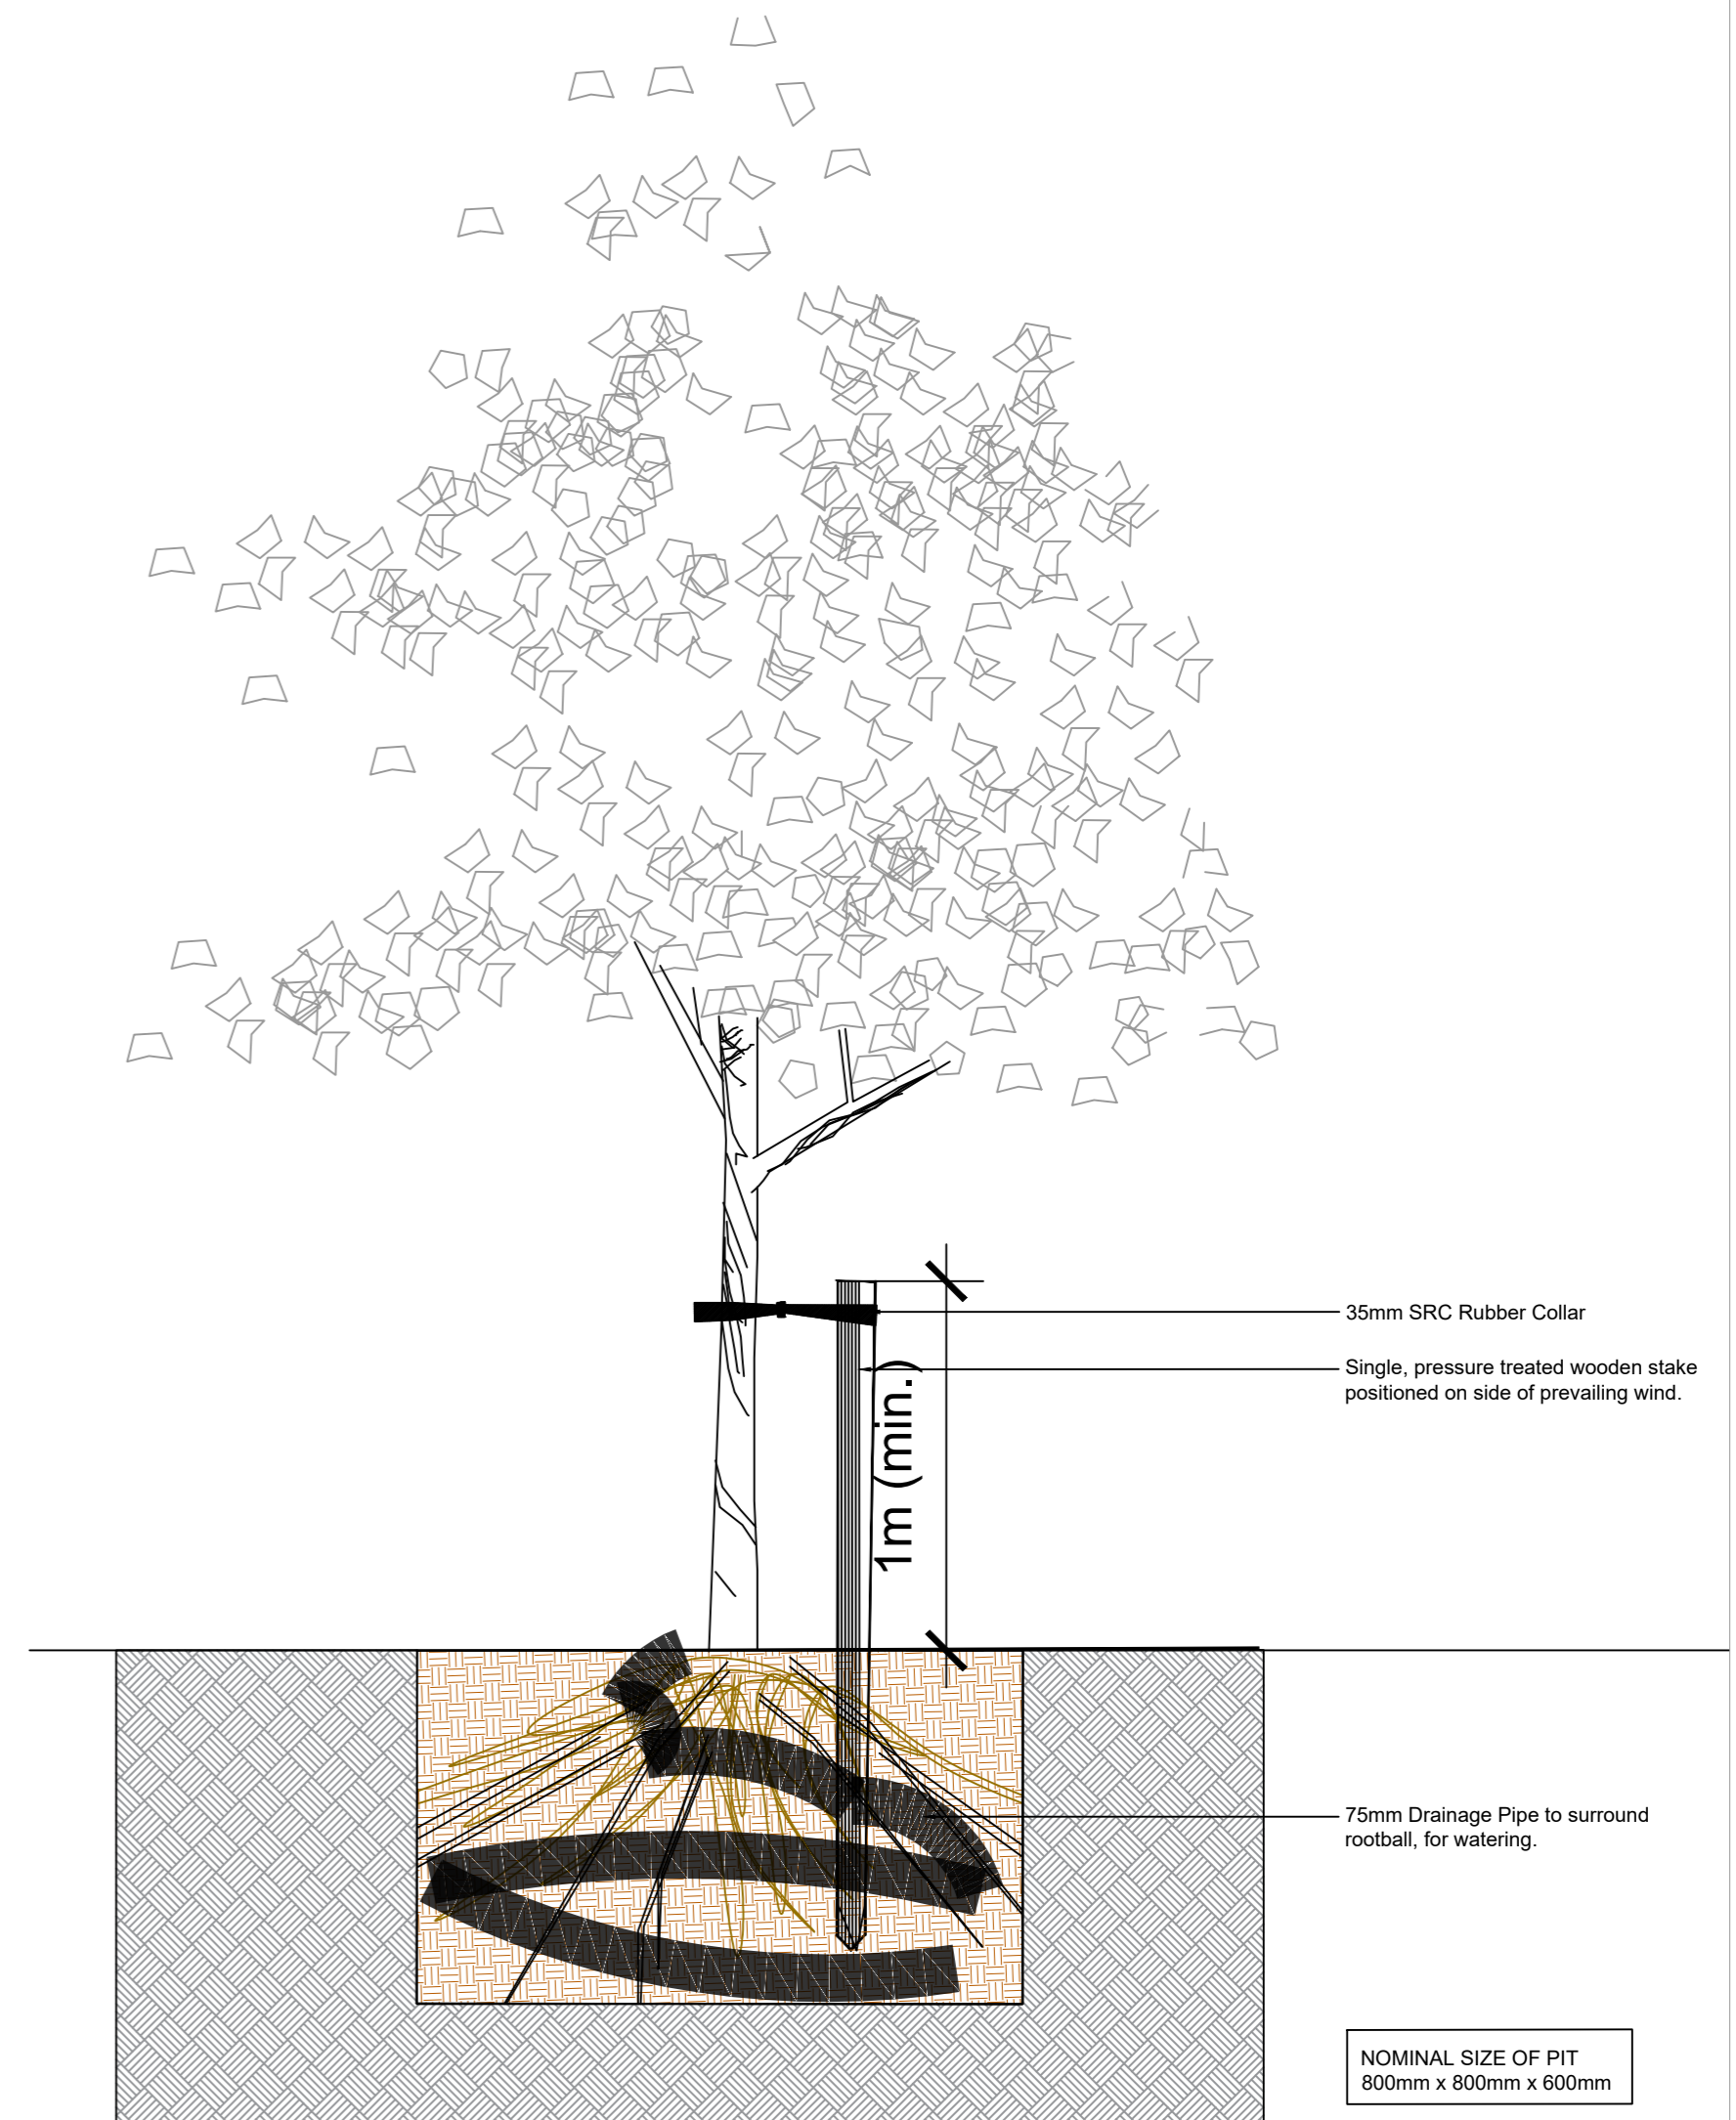

**D5** Minimum Soil Depths  
Scale 1:20

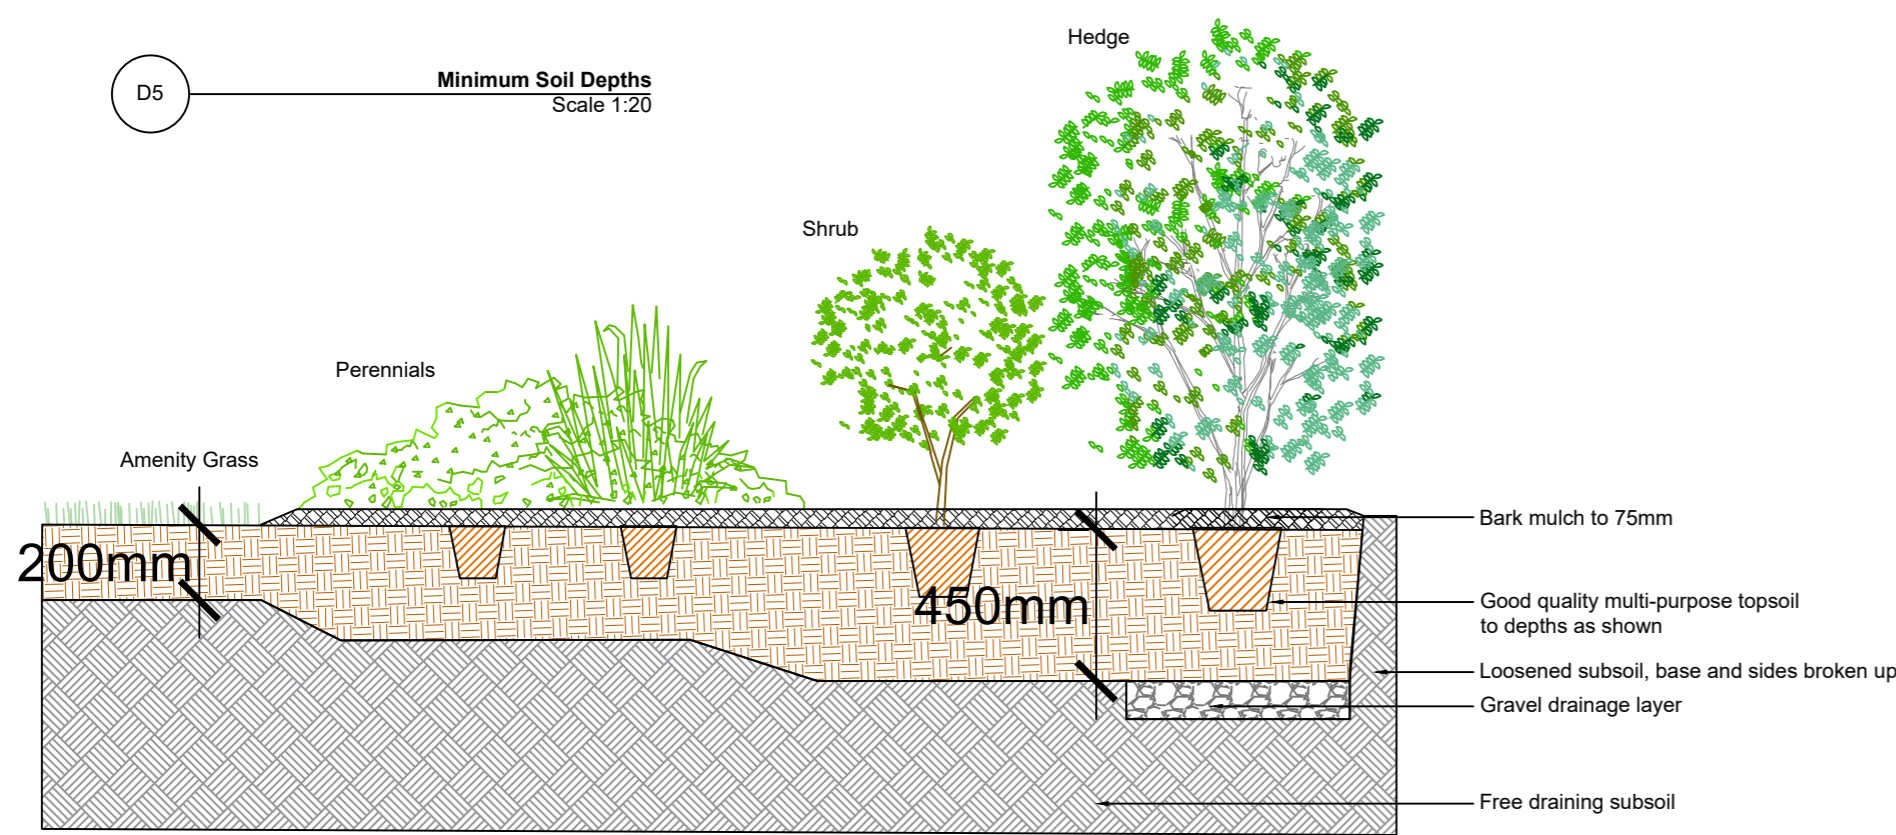


**D7** Shrub Planting Detail  
Scale 1:20

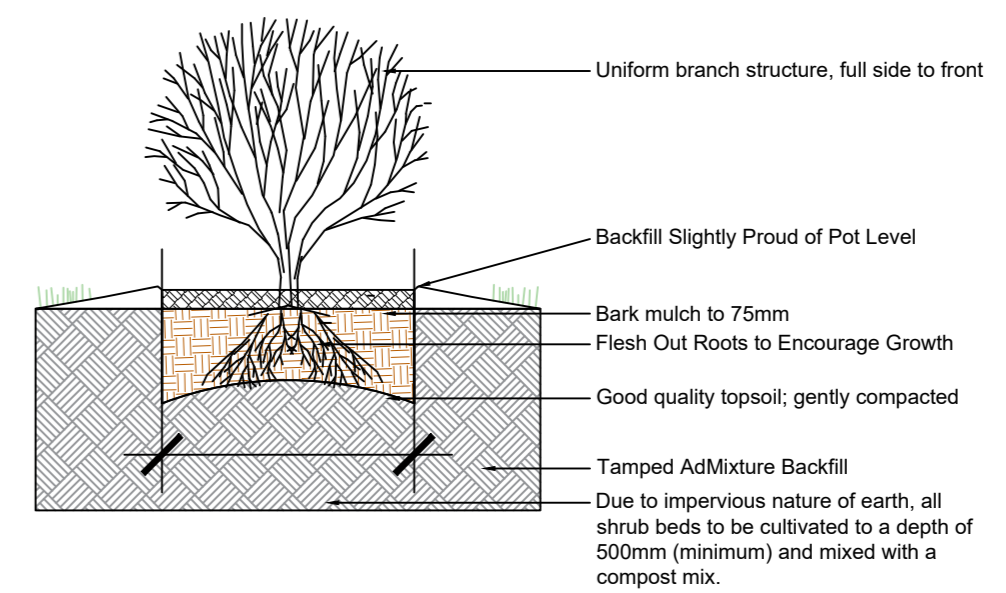


2X Root Diameter Minimum



**D6** Staking Detail  
Scale 1:20

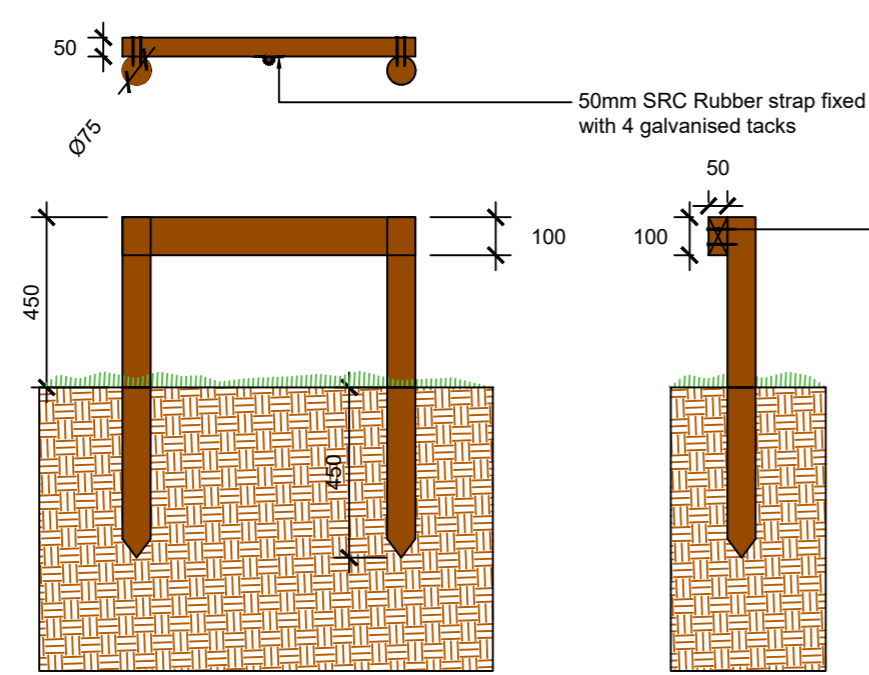

**D8** Amenity Grass Planting  
Scale 1:10

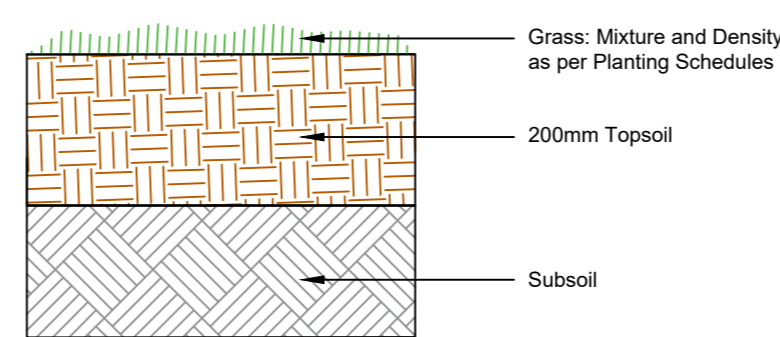

**D3** Native Hedgerow Planting Mix - H1  
Scale 1:5

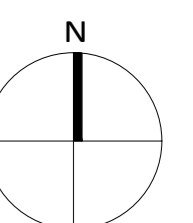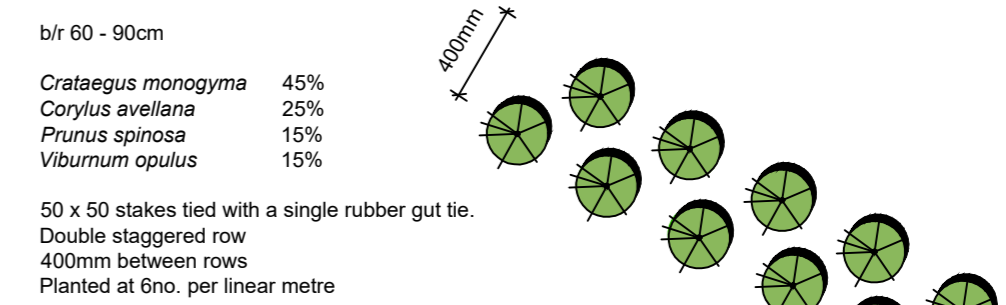

Project Title: <b>Kilshane Power Plant SID</b>					Client: <b>Kilshane Energy Ltd.</b>		Dwg No. 06	
					Drawing Title: <b>Landscape Details</b>		Scale 1:20 / 1:10 / 1:5	
					Job No. 1961		Date 12/06/2025	
					 <b>Ronan MacDiarmada + Associates Ltd.</b> Landscape Architects and Consultants. Gort Na Si, Main Street, Newcastle, Co. Dublin. D22A314 tel: +353 1 412 4476 e-mail: info@rmda.ie			
D	28/11/2025	MSC	RMD	Draft				
C	21/11/2025	MSC	RMD	Draft				
B	31/07/2025	MSC	RMD	Draft				
A	30/07/2025	MSC	RMD	Draft				
00	12/06/2025	MSC	RMD	Draft				
REV	DATE	BY	CHECKED	DESCRIPTION				