




Site Extent - NTS

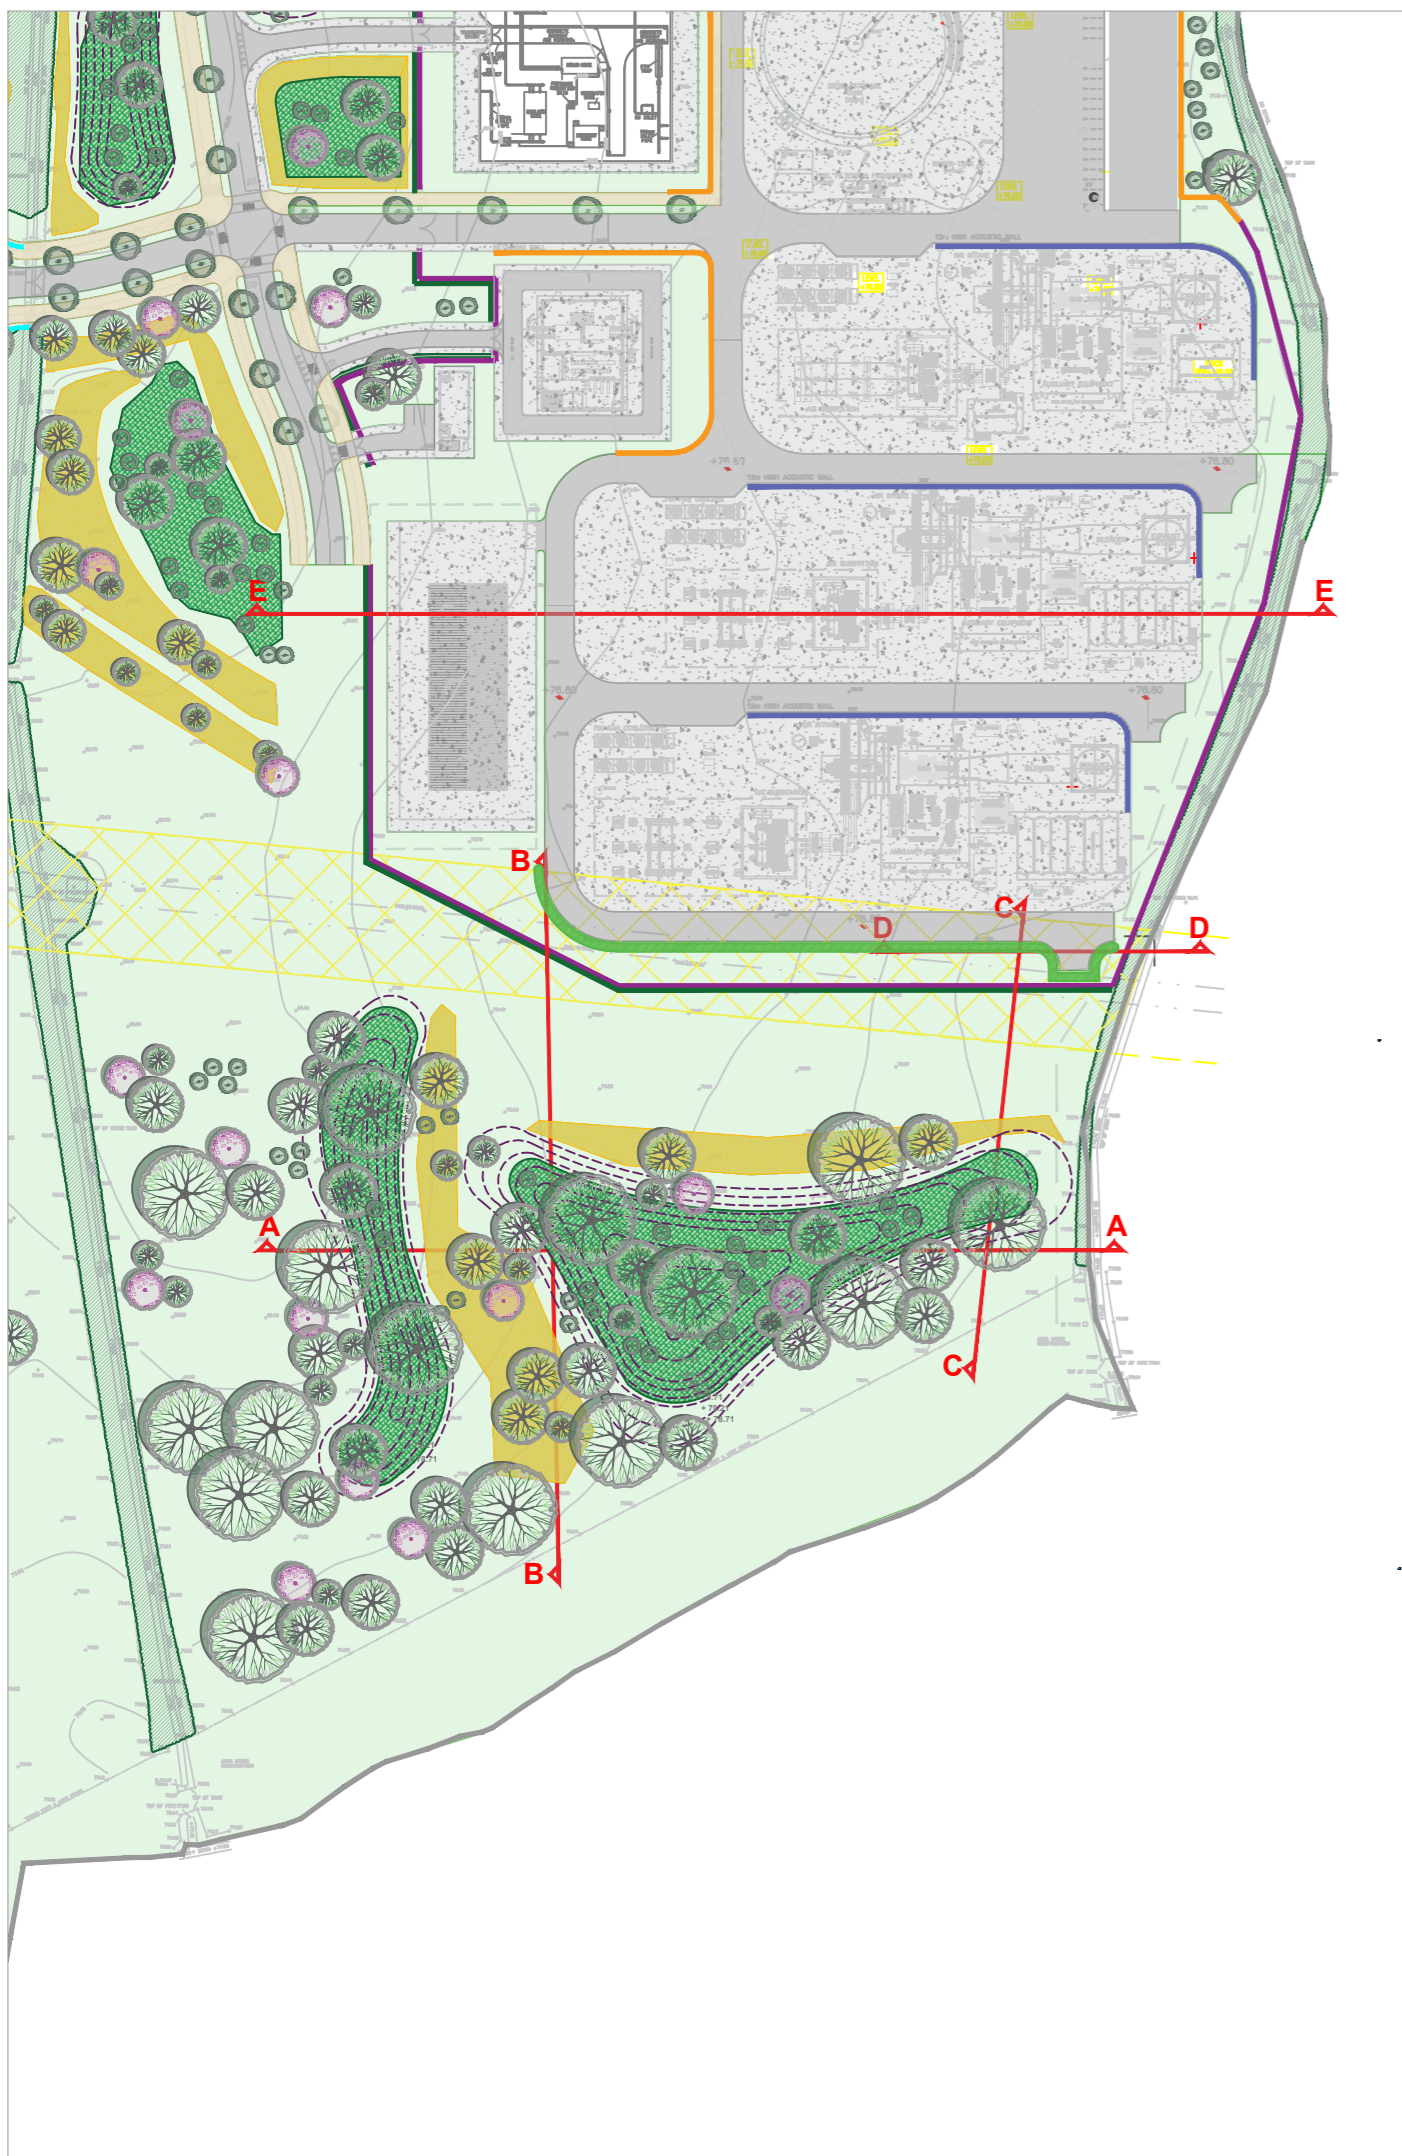


Landscape Section A-A 1:500

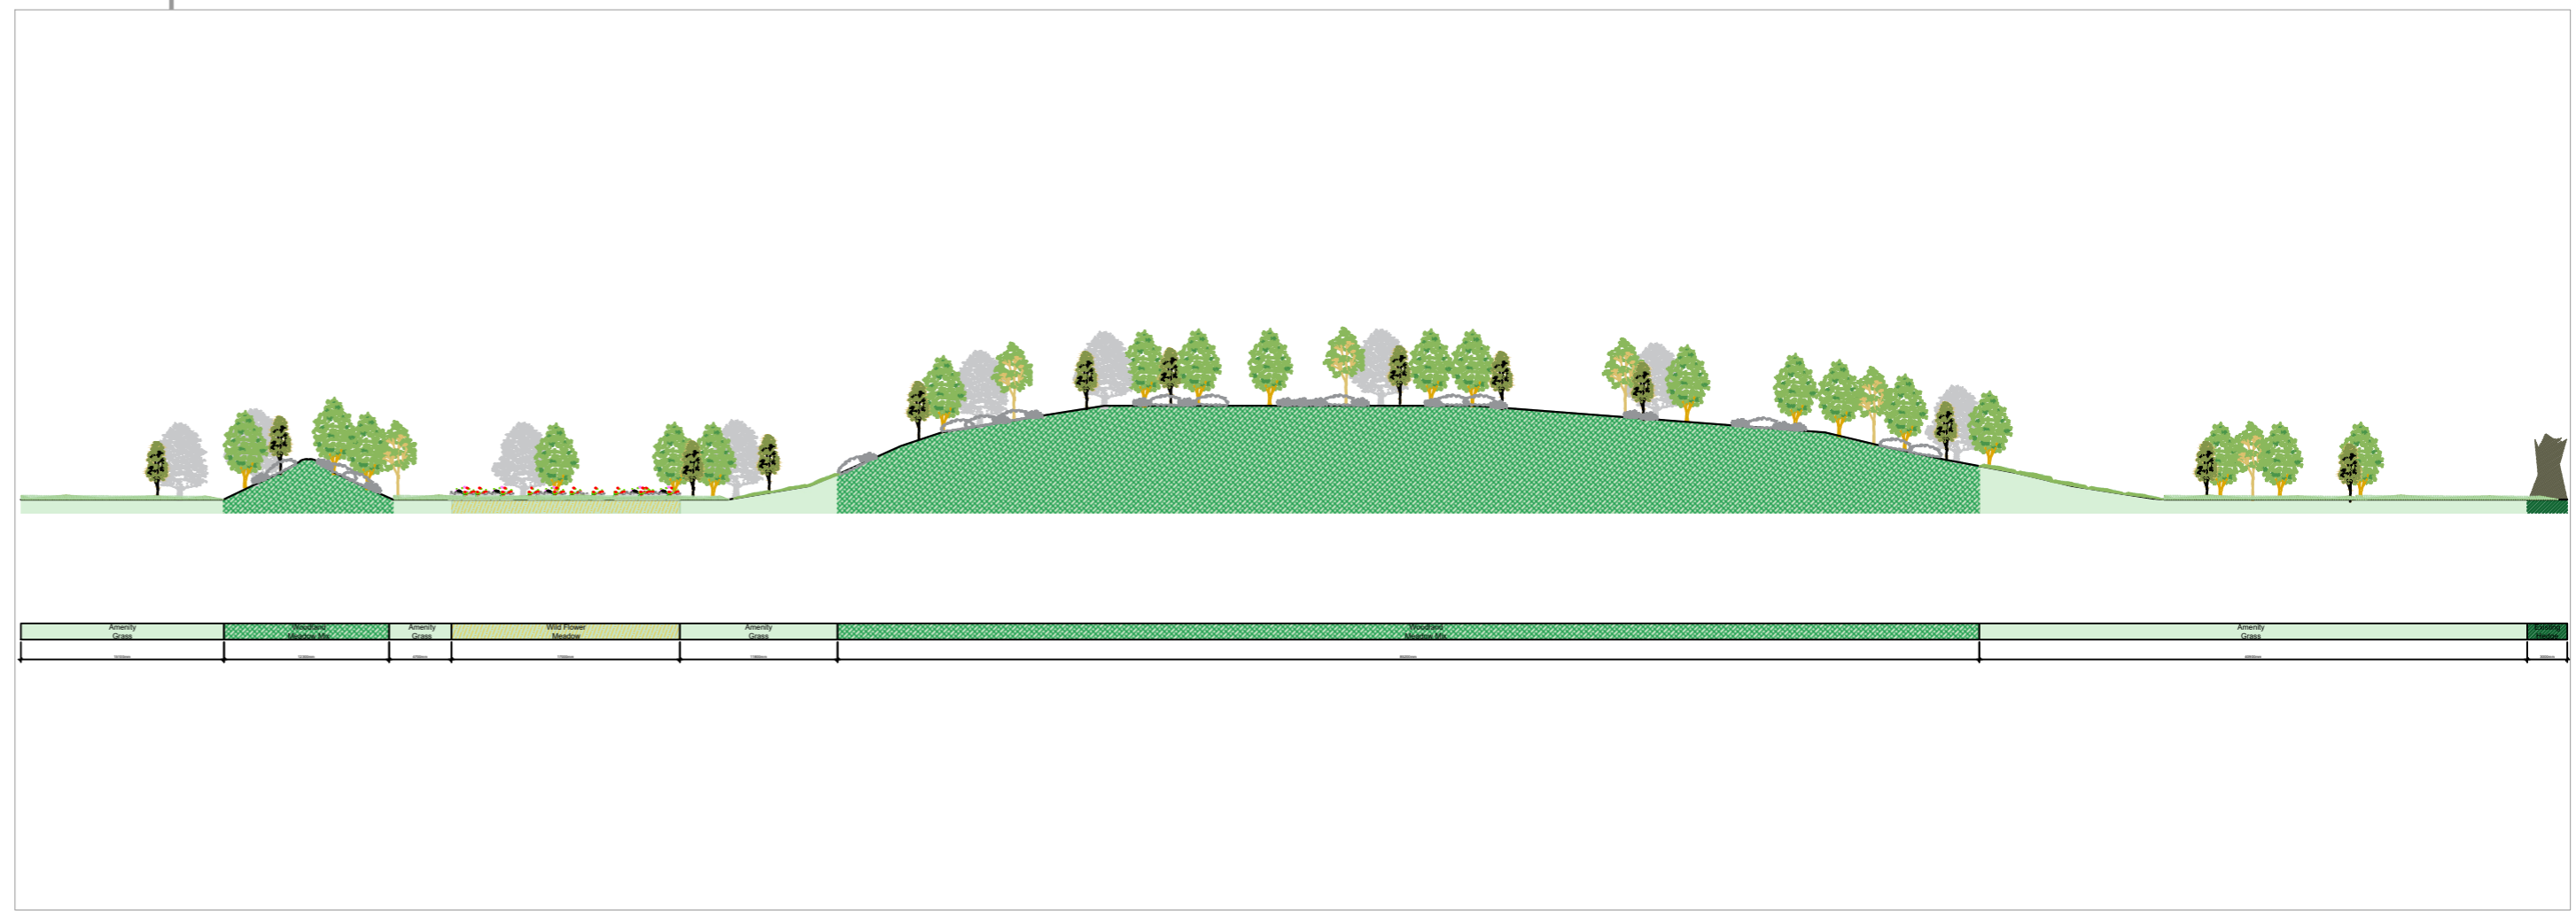


Landscape Section B-B 1:500

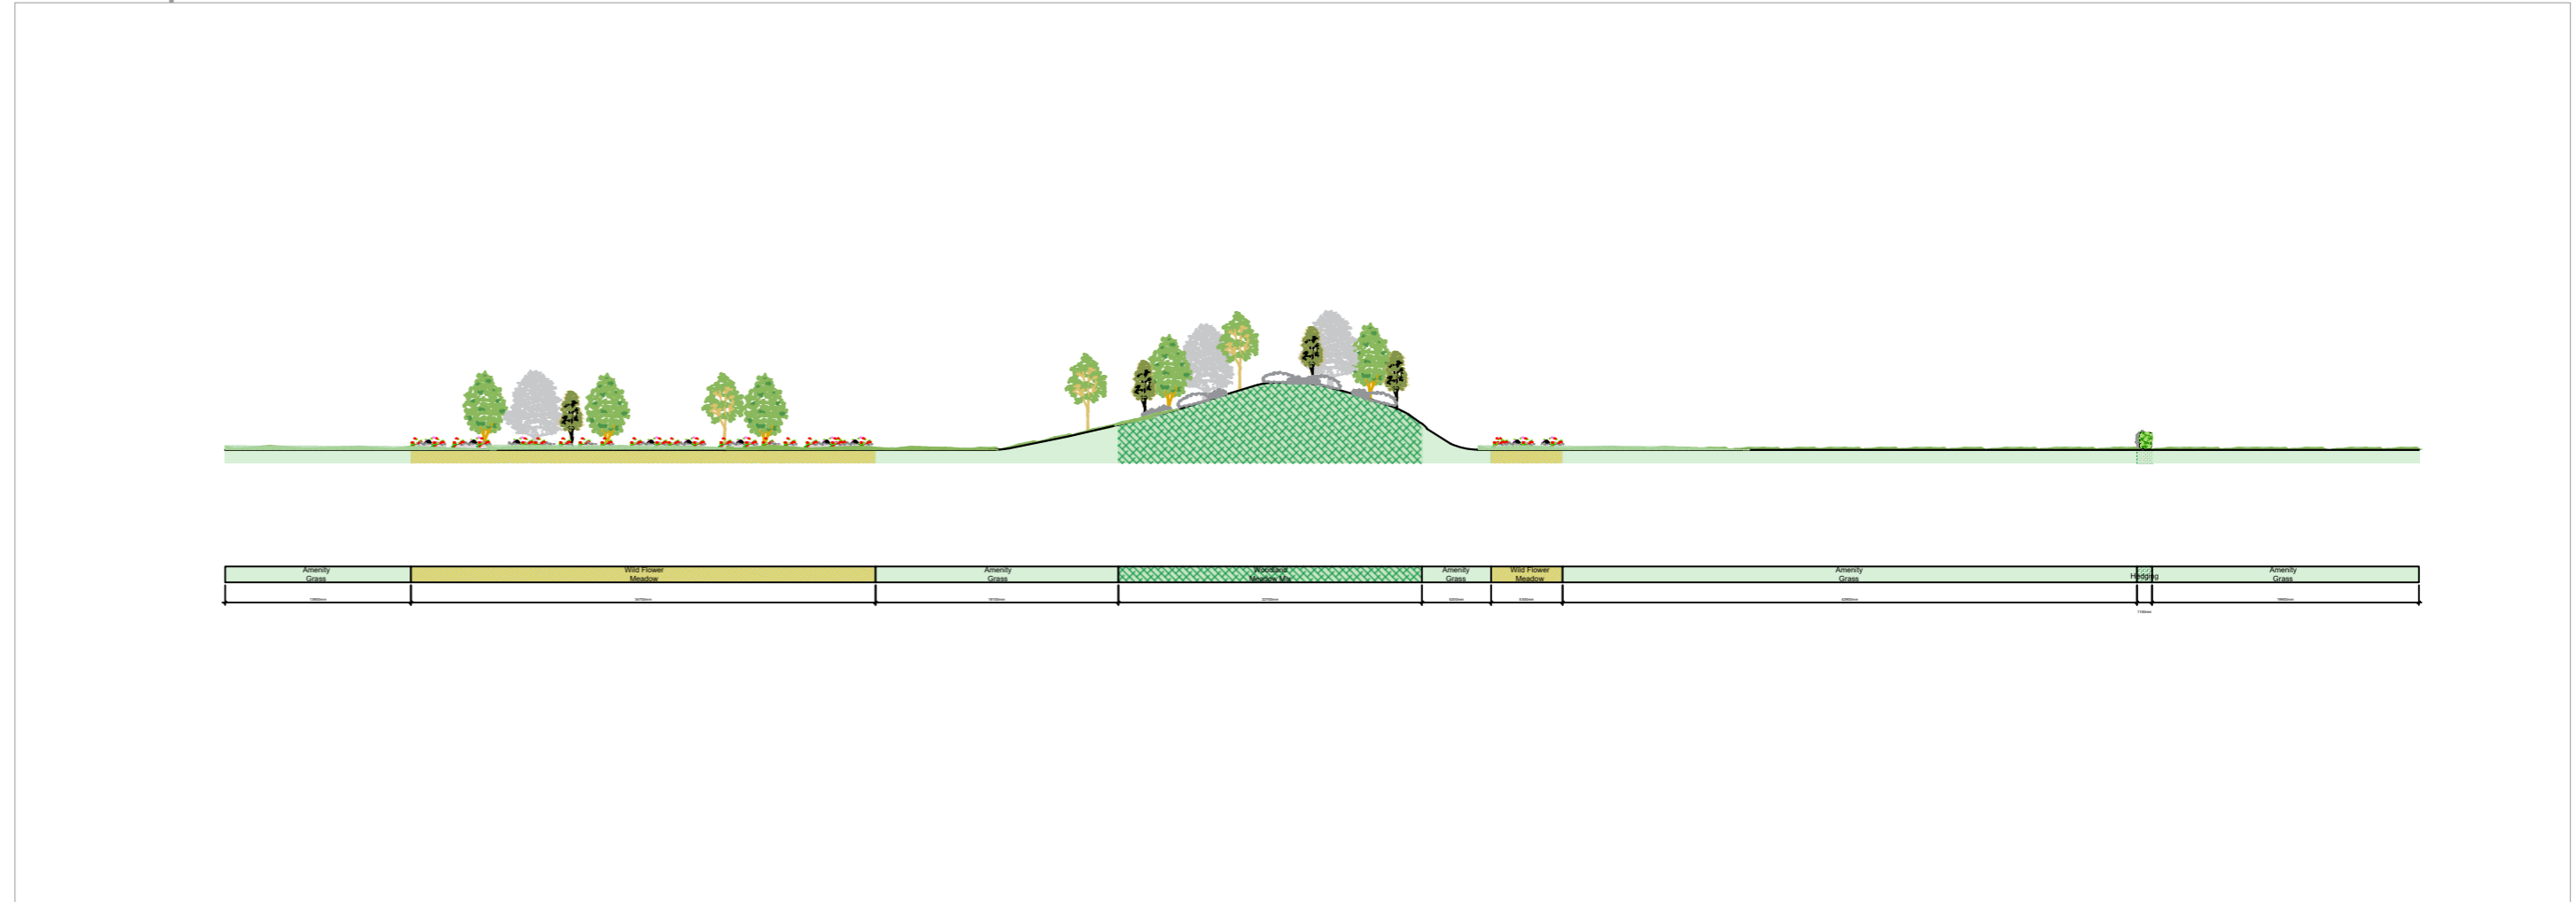


Landscape Section C-C 1:500

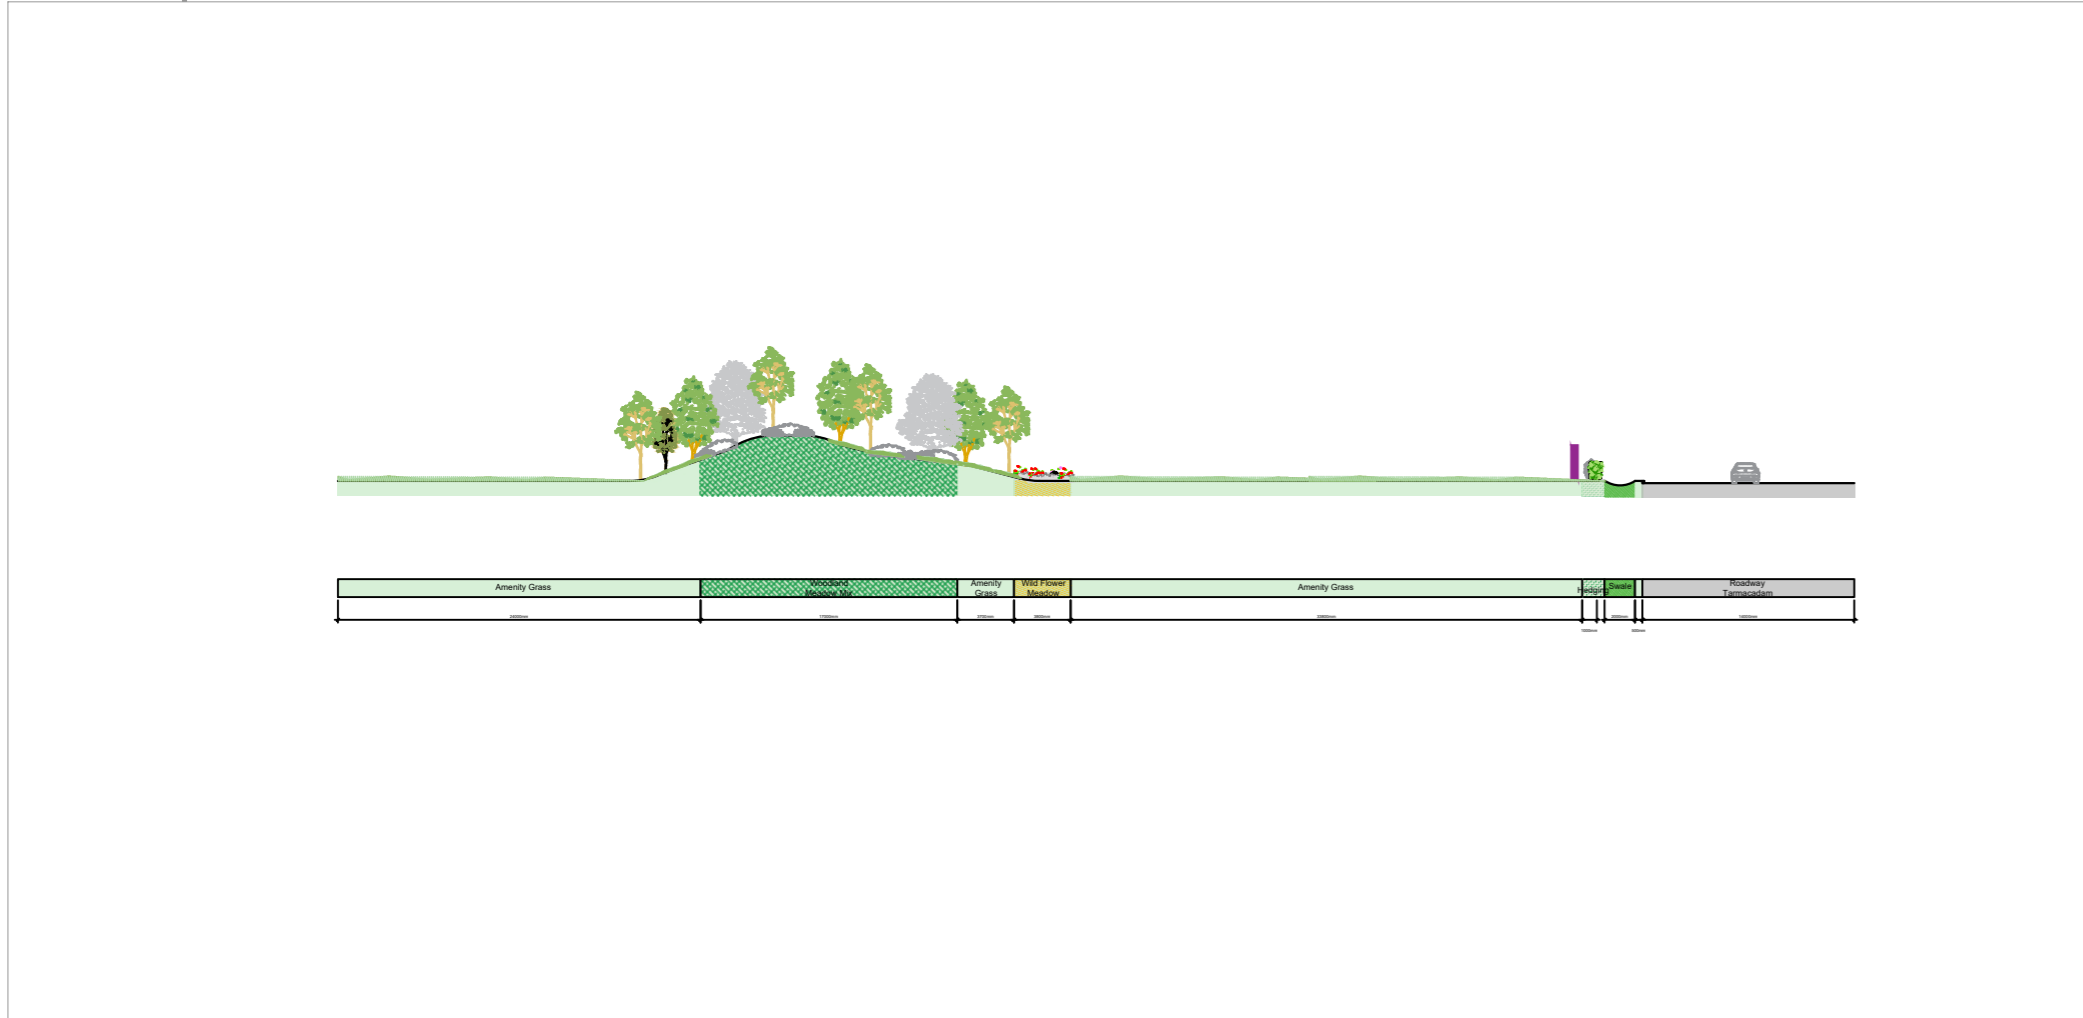

Landscape Section D-D 1:500

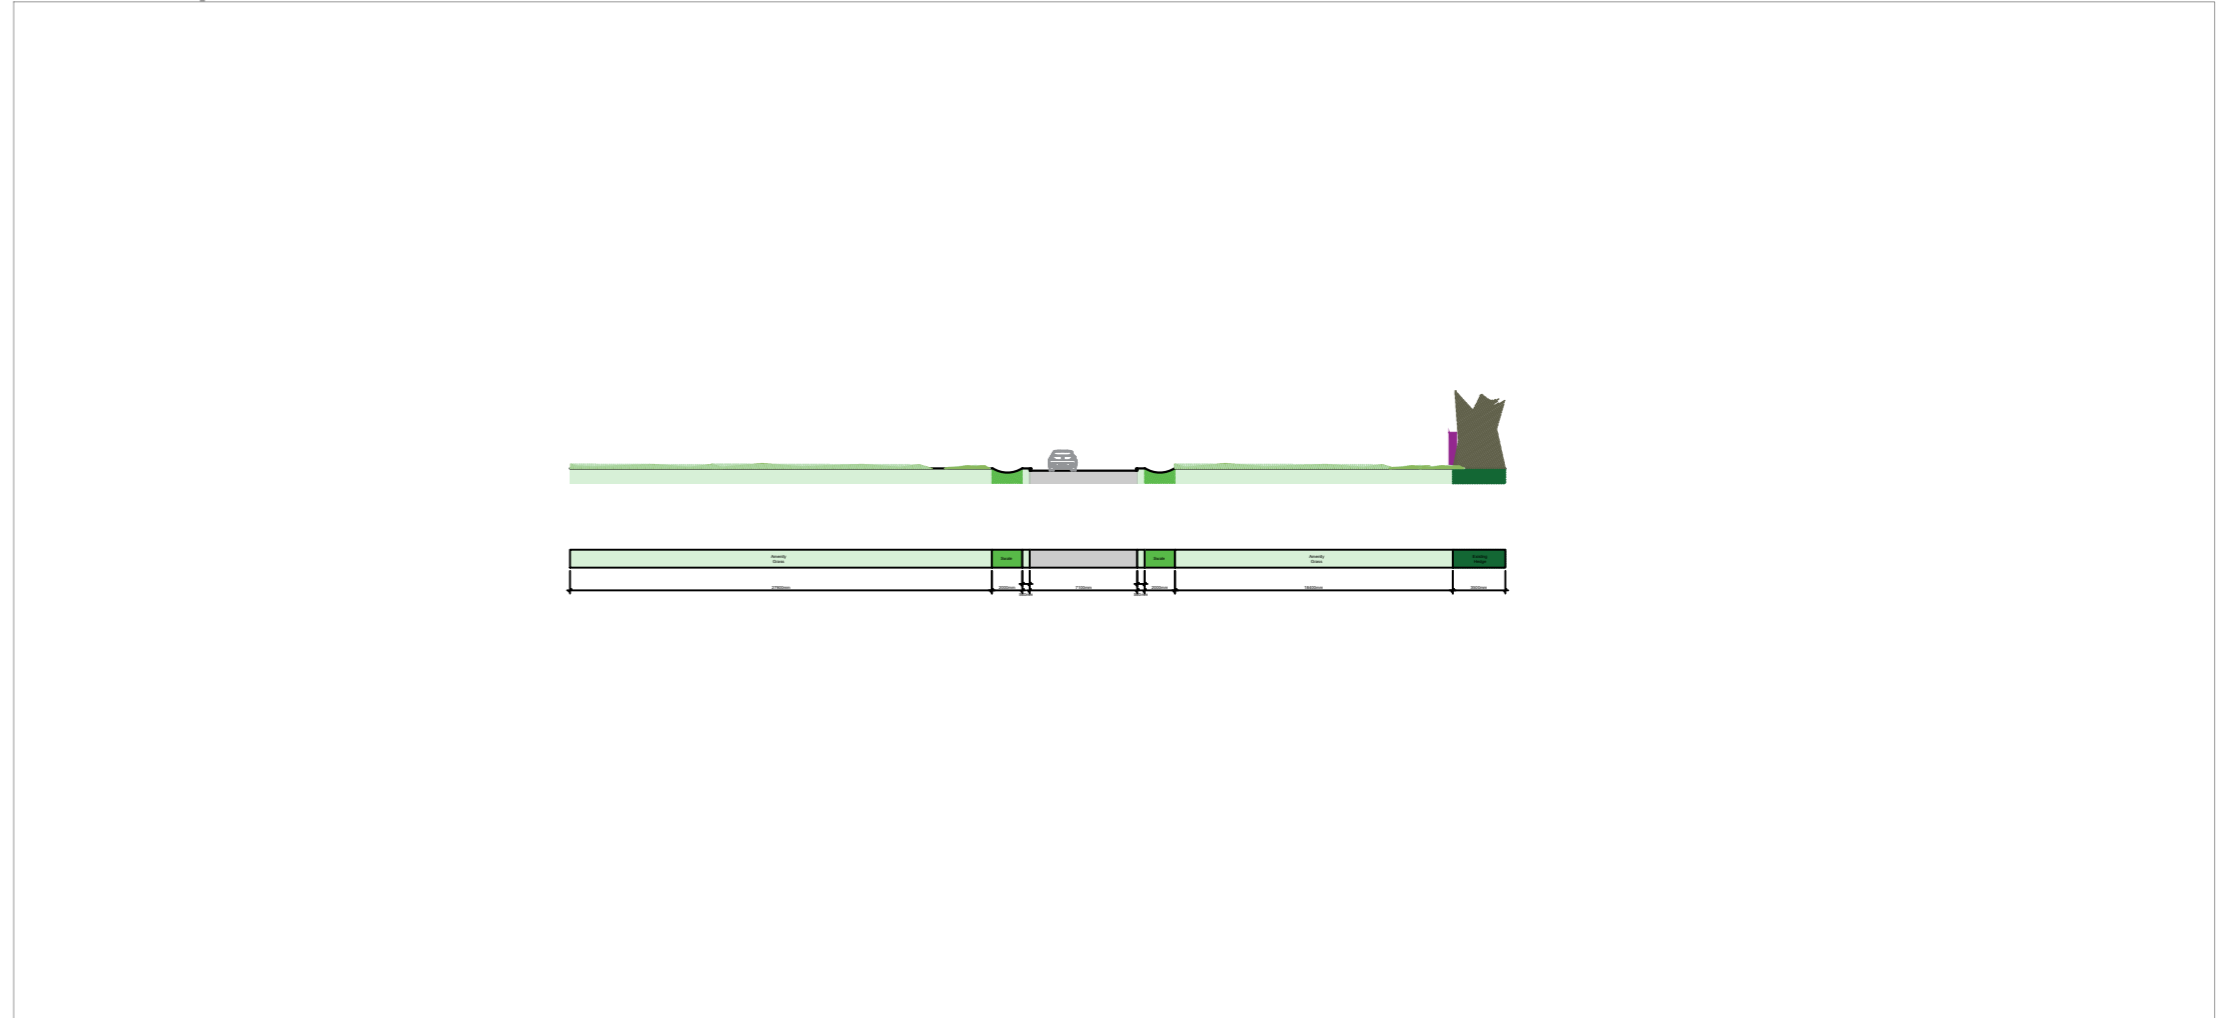

Landscape Section E-E 1:500

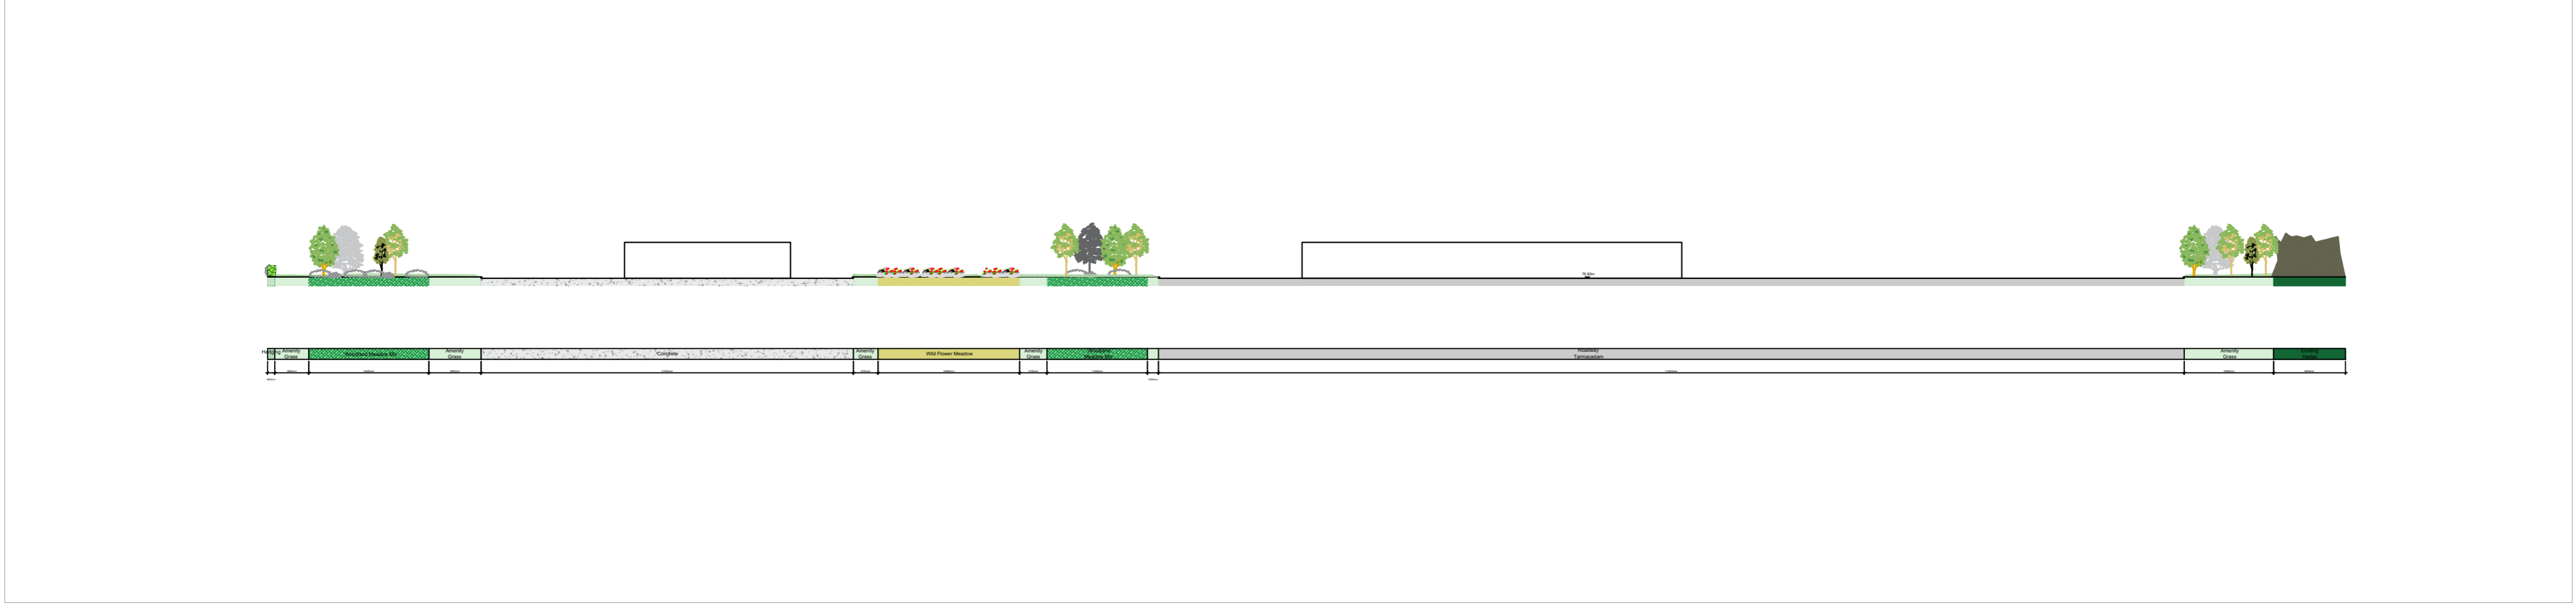

|  |            |     |         |             |                             |   |  |                 |  |
|--|------------|-----|---------|-------------|-----------------------------|---|--|-----------------|--|
| Project Title: <b>Kilshane Power Plant SID</b> |            |     |         |             |                             | Client: <b>Kilshane Energy Ltd.</b>   |  | Dwg No. 07      |  |
|  |            |     |         |             |                             | Drawing Title: Landscape Sections   |  | Scale 1:500 @A1 |  |
|  |            |     |         |             |                             | Job No. 1961  |  | Date 12/06/2025 |  |
|  |            |     |         |             |                             |  <b>RMDA</b><br>LANDSCAPE ARCHITECTS + CONSULTANTS<br><b>Ronan MacDiarmada + Associates Ltd.</b><br>Landscape Architects and Consultants.<br>Gort Na Si, Main Street, Newcastle, Co. Dublin. D22A314<br>tel: +353 1 412 4476<br>e-mail: info@rmda.ie |  |                 |  |
| D  | 28/11/2025 | MSC | RMD     | Draft       |                             |   |  |                 |  |
| C  | 21/11/2025 | MSC | RMD     | Draft       |                             |   |  |                 |  |
| B  | 31/07/2025 | MSC | RMD     | Draft       |                             |   |  |                 |  |
| A  | 30/07/2025 | MSC | RMD     | Draft       |                             |   |  |                 |  |
| 00   | 12/06/2025 | MSC | RMD     | Draft       |                             |   |  |                 |  |
| REV  | DATE       | BY  | CHECKED | DESCRIPTION | This Drawing is Copyright © |   |  |                 |  |