


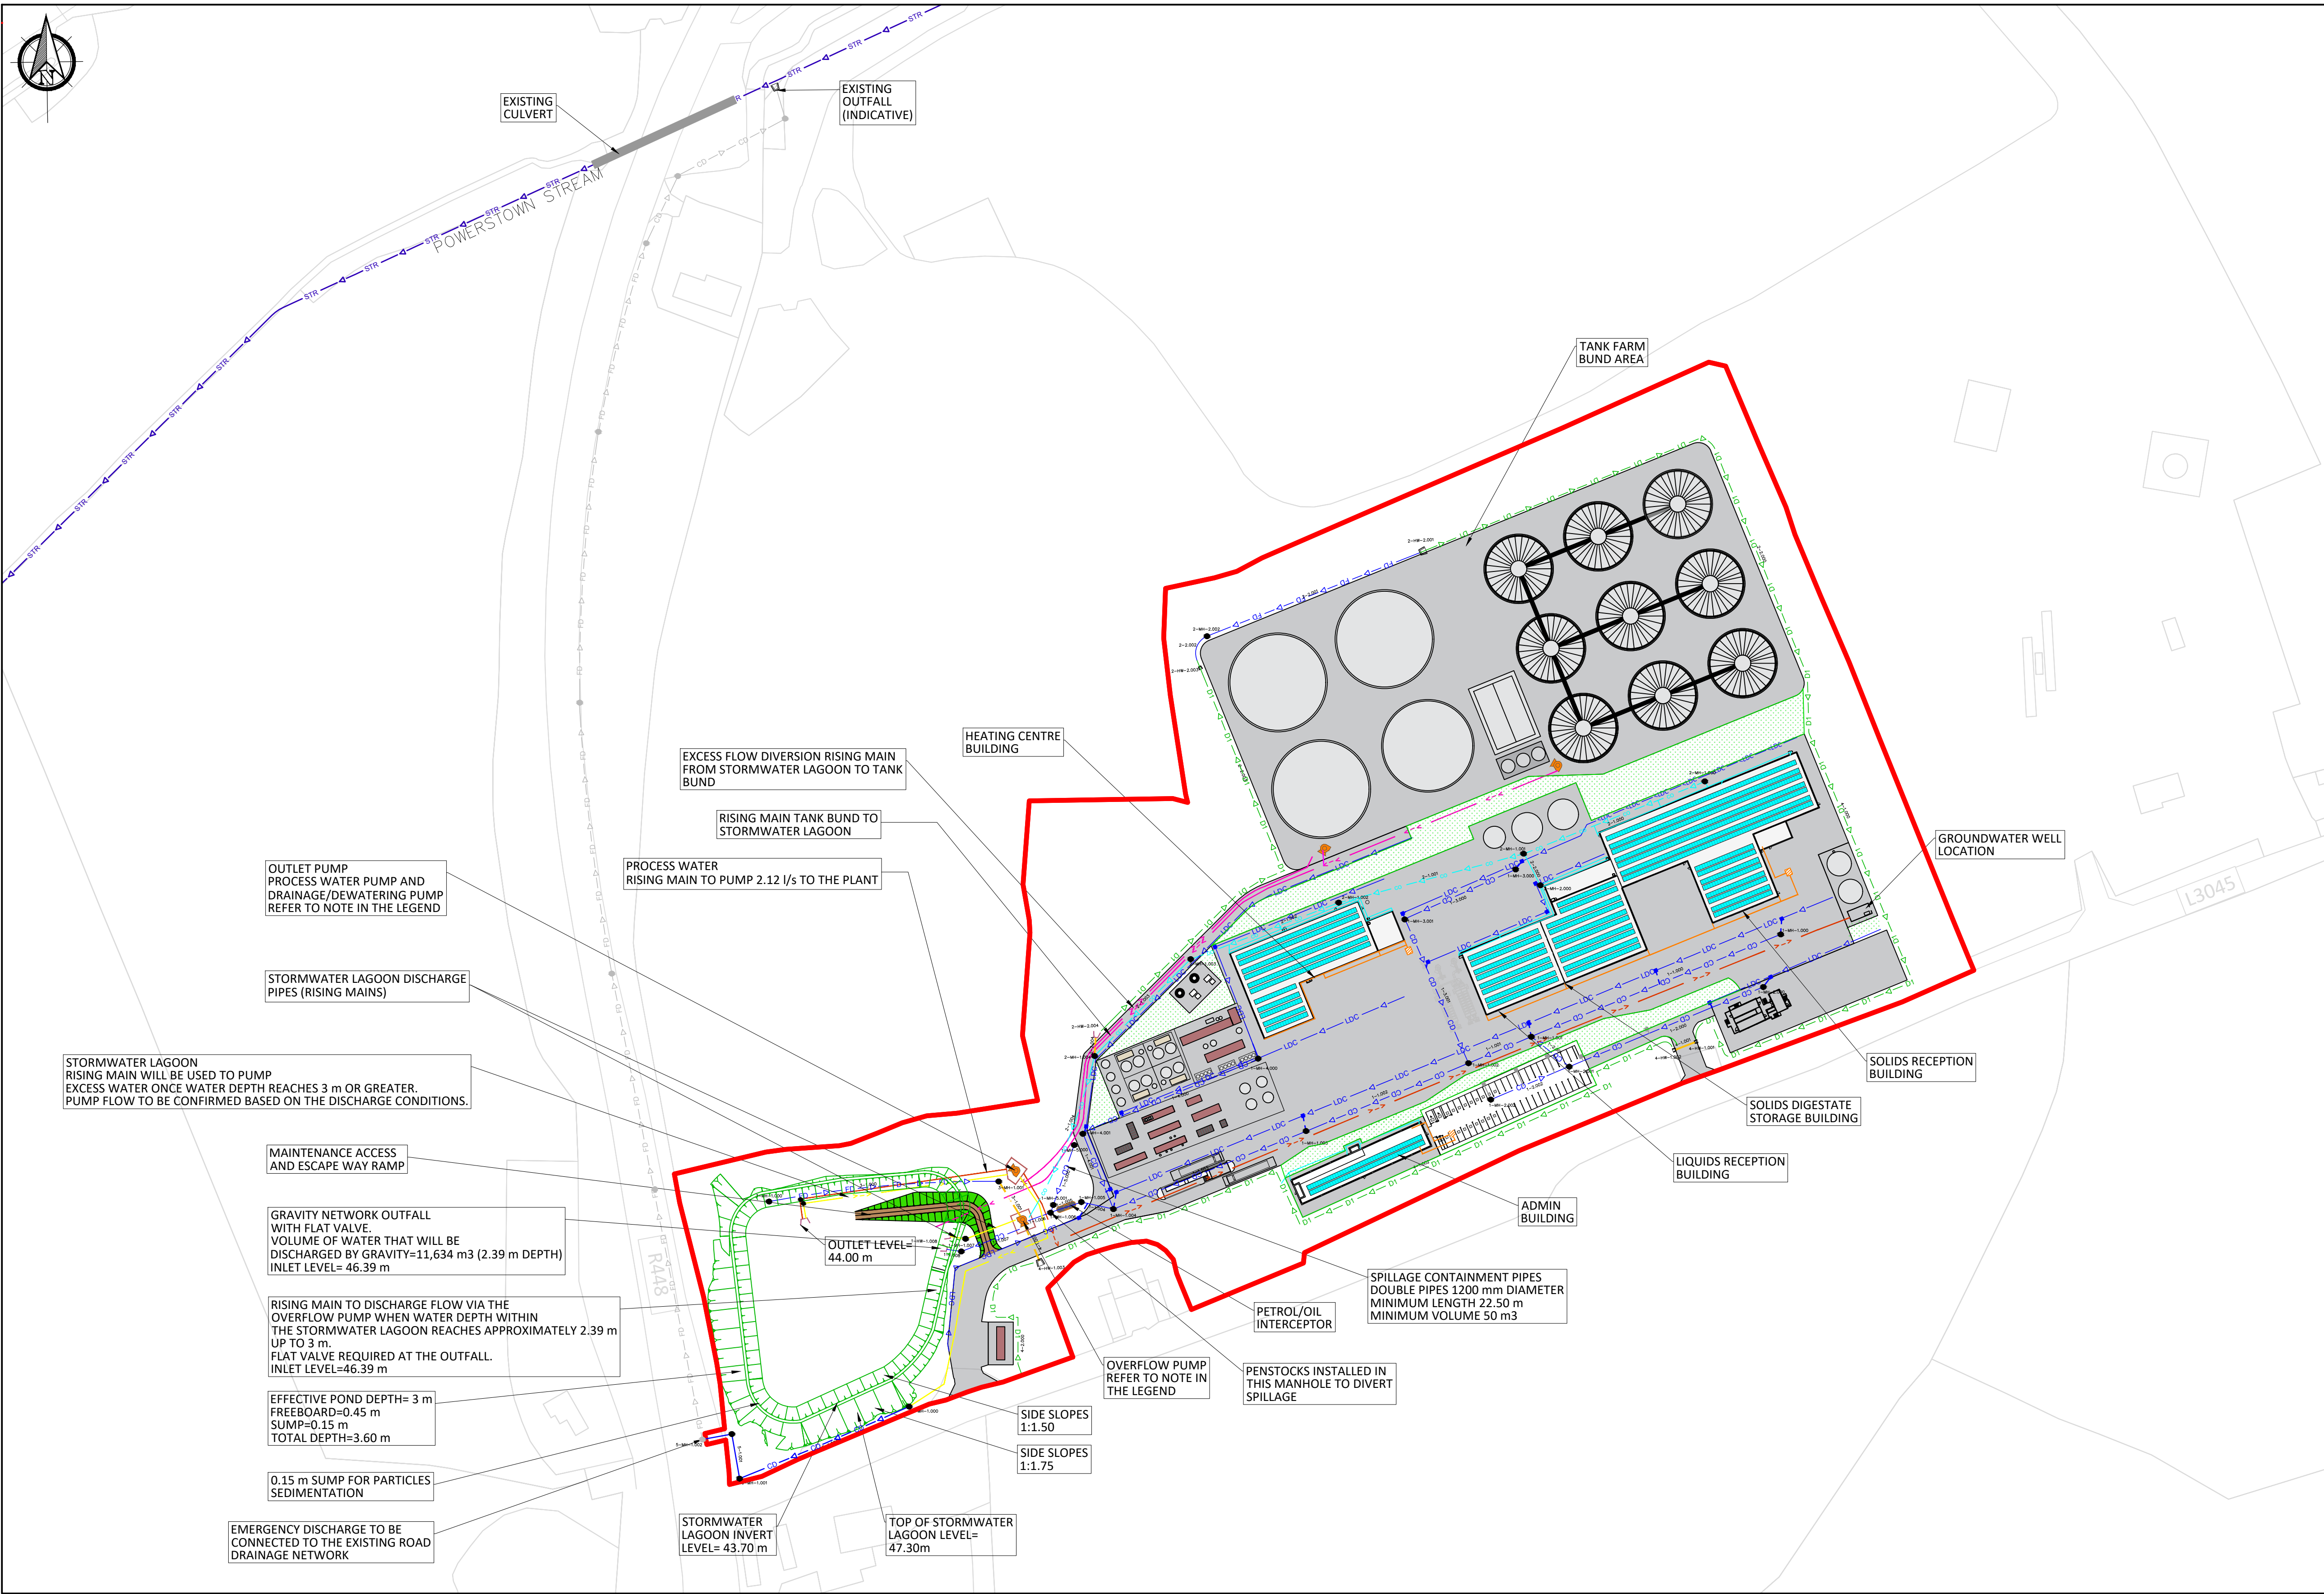

- Legend**
- Site Boundary
 - Interceptor Drains
 - Cross Drains
 - Powerstown Stream
 - Filter Drains
 - Carrier Drains
 - Linear Drainage Channel
 - Linear Drainage Outlet
 - Proposed Gully
 - Rainwater Drainage Collector
 - Rainwater Roof Drainage
 - Manhole
 - Process Water Rising Mains
 - Stormwater Lagoon Rising Mains
 - Rising Mains between Tank Bund to Stormwater Lagoon (both directions)
 - Valve
 - Pump
 - Petrol/Oil Interceptor
 - Foul Water Network
 - Foul Water Tank
 - Existing Filter Drain (Indicative)
 - Existing Carrier Drain (Indicative)
 - Existing Manhole (Indicative)
 - Infiltration Areas
 - Yard & Circulation Areas

If Applicable : Tailte Éireann Licence No. CYAL50368274 © Ordnance Survey Ireland and Government of Ireland 4531-B



Cork | Dublin | Carlow
www.fehilytimoney.ie

No part of this document may be reproduced or transmitted in any form or stored in any retrieval system of any nature without the written permission of Fehily Timoney & Company as copyright holder except as agreed for use on the project for which the document was originally issued. Do not scale. Use figured dimensions only. If in doubt - Ask!

Rev.	Description	App By	Date
P01	ISSUE FOR PLANNING	JON	24.06.26

PROJECT	CLIENT		
POWERSTOWN BIOENERGY			
SHEET	PROPOSED DRAINAGE LAYOUT PLAN	Date 24.06.26	Project number P24-188
		Drawn by EB	Drawing Number P24188-FT-XX-XX-DR-CE-0500
		Checked by JOB	Rev P01

O:\ACAD\2024\P24-188\P24188-FT-XX-XX-DR-CE-0500

29 June 2026 (O:\ACAD\2024\P24-188\P24188-FT-XX-XX-DR-CE-0500)