




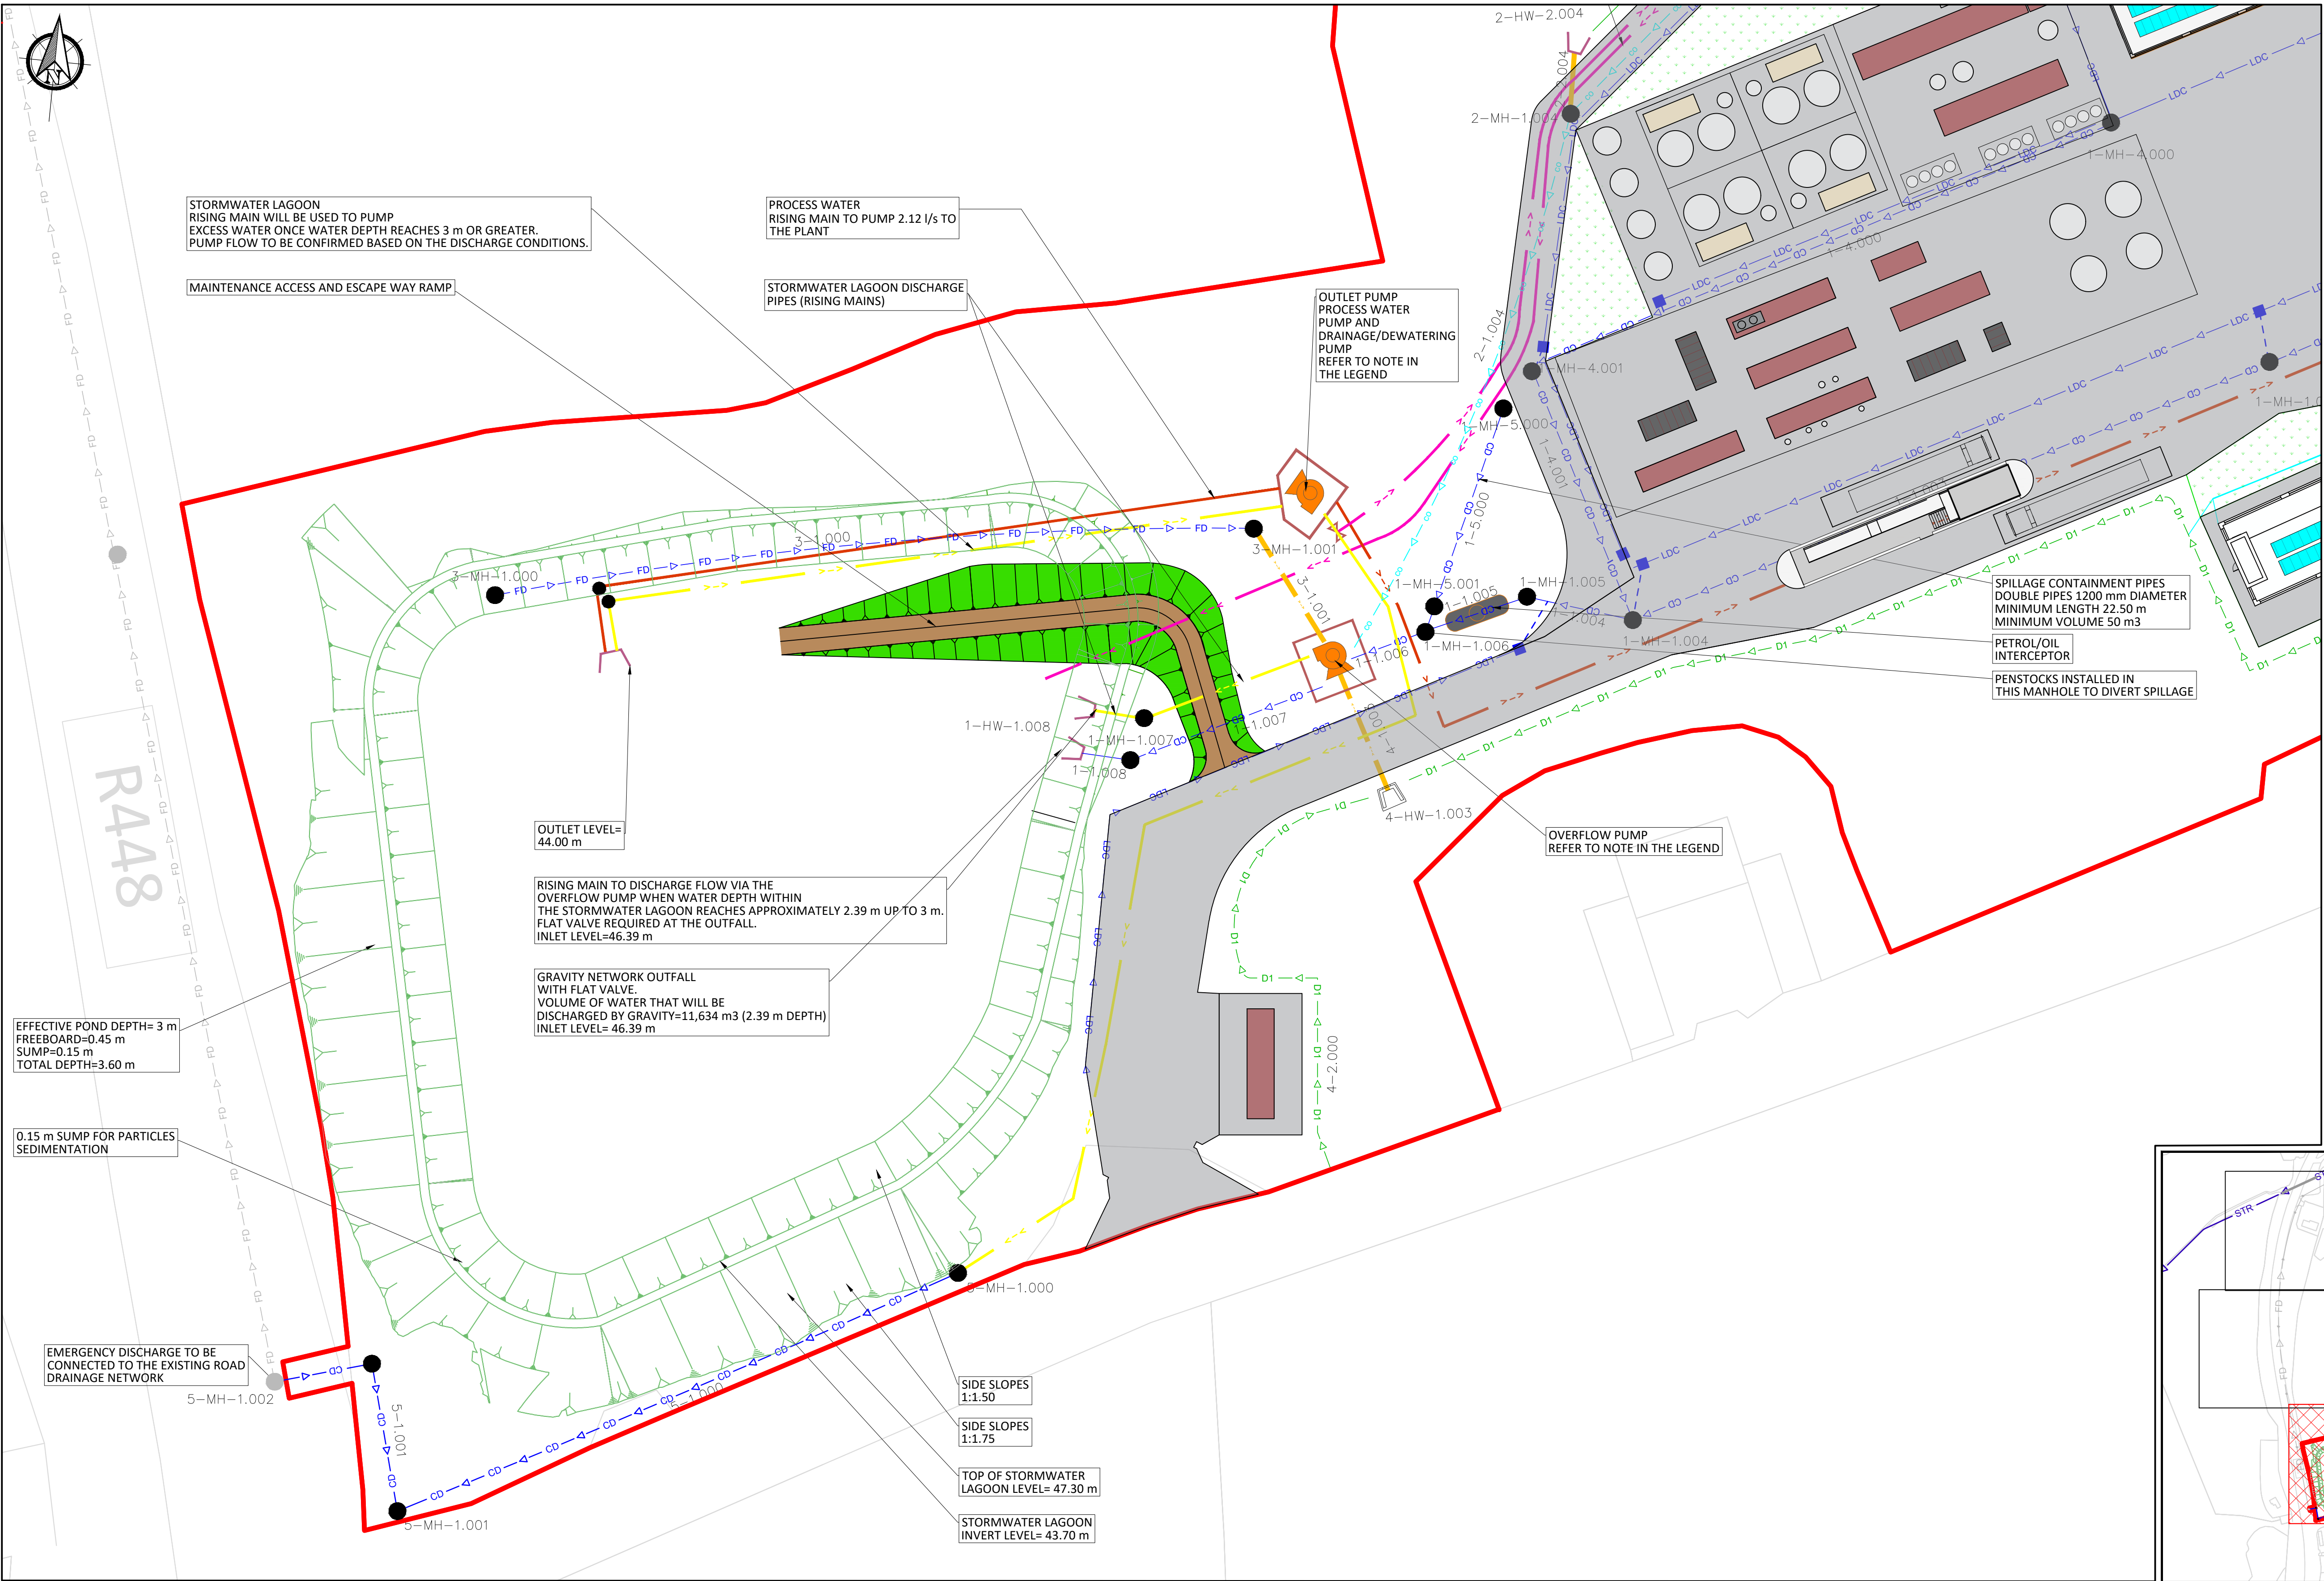

- Legend**
- Site Boundary
  - Interceptor Drains
  - Cross Drains
  - Powerstown Stream
  - Filter Drains
  - Carrier Drains
  - Linear Drainage Channel
  - Linear Drainage Outlet
  - Proposed Gully
  - Rainwater Drainage Collector
  - Rainwater Roof Drainage
  - Manhole
  - Process Water Rising Mains
  - Stormwater Lagoon Rising Mains
  - Rising Mains between Tank Bund to Stormwater Lagoon (both directions)
  - Valve
  - Pump
  - Petrol/Oil Interceptor
  - Foul Water Network
  - Foul Water Tank
  - Existing Filter Drain (Indicative)
  - Existing Carrier Drain (Indicative)
  - Existing Manhole (Indicative)
  - Infiltration Areas
  - Yard & Circulation Areas

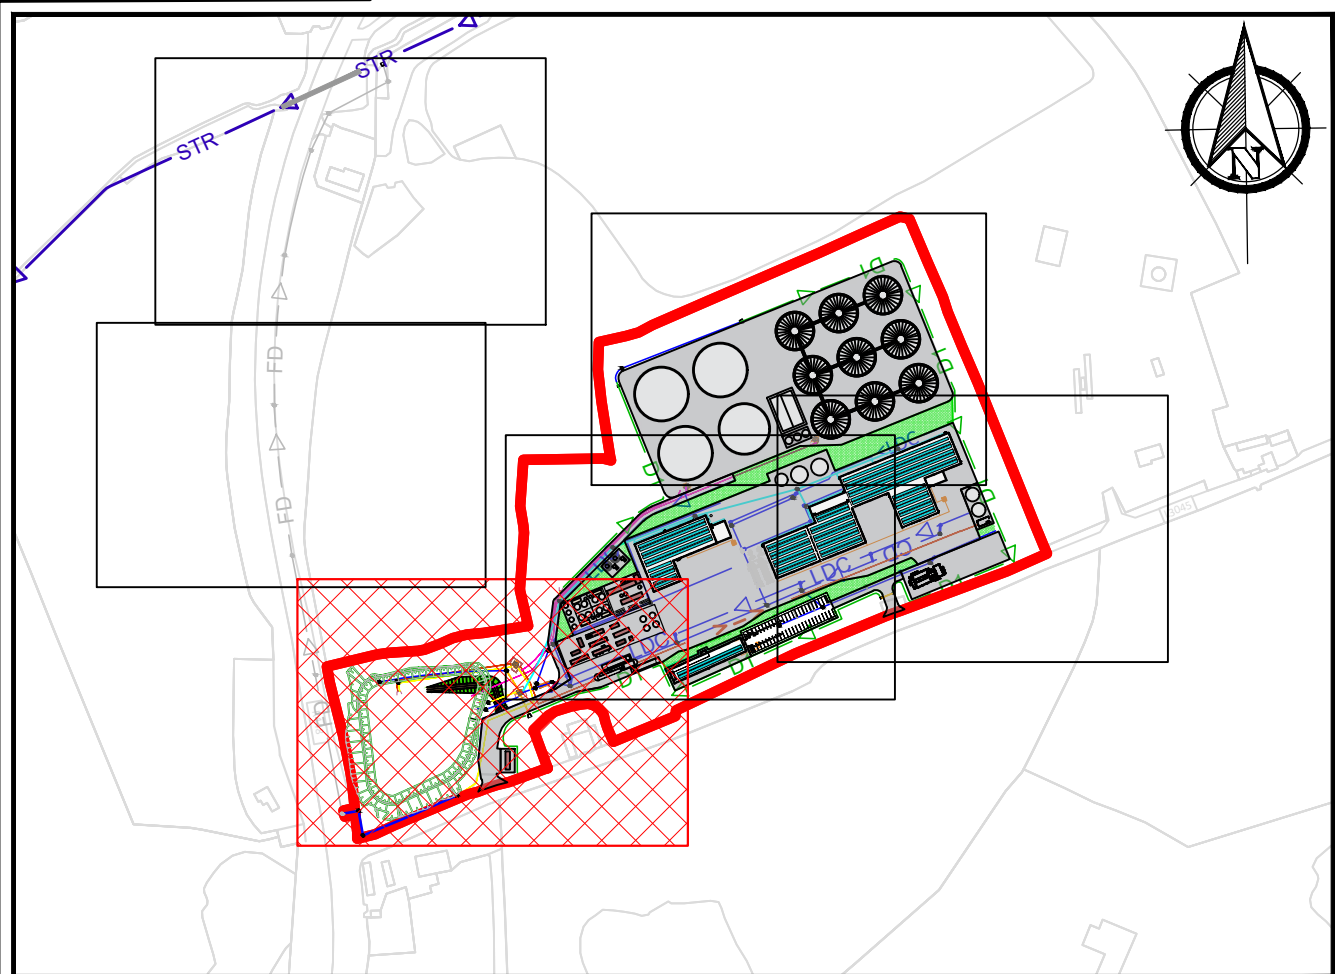

PLAN 0001  
1:375

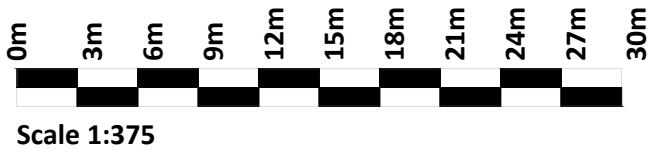

KEY PLAN 0002  
1:5000

If Applicable : Tailte Éireann Licence No. CYAL50368274 © Ordnance Survey Ireland and Government of Ireland 4531-B



Cork | Dublin | Carlow  
www.fehilytimoney.ie

No part of this document may be reproduced or transmitted in any form or stored in any retrieval system of any nature without the written permission of Fehily Timoney & Company as copyright holder except as agreed for use on the project for which the document was originally issued. Do not scale. Use figured dimensions only. If in doubt - Ask!

| Rev. | Description        | App By | Date     |
|------|--------------------|--------|----------|
| P01  | ISSUE FOR PLANNING | JON    | 24.06.26 |
|      |                    |        |          |
|      |                    |        |          |
|      |                    |        |          |
|      |                    |        |          |

|         |                                                 |  |  |            |          |                          |                            |
|---------|-------------------------------------------------|--|--|------------|----------|--------------------------|----------------------------|
| PROJECT | POWERSTOWN BIOENERGY                            |  |  | CLIENT     |          |                          |                            |
| SHEET   | PROPOSED SITE DRAINAGE PLAN<br>- SHEET 3 OF 6 - |  |  | Date       | 24.06.26 | Project number           | P24-188                    |
|         |                                                 |  |  | Drawn by   | EB       | Drawing Number           | P24188-FT-XX-XX-DR-CE-0503 |
|         |                                                 |  |  | Checked by | JON      | Scale (@ A1)<br>As Shown | Rev<br>P01                 |

O:\ACAD\2024\P24-188\P24188-FT-XX-XX-DR-CE-0503

25 June 2026 (O:\ACAD\2024\P24-188\P24188-FT-XX-XX-DR-CE-0503)