



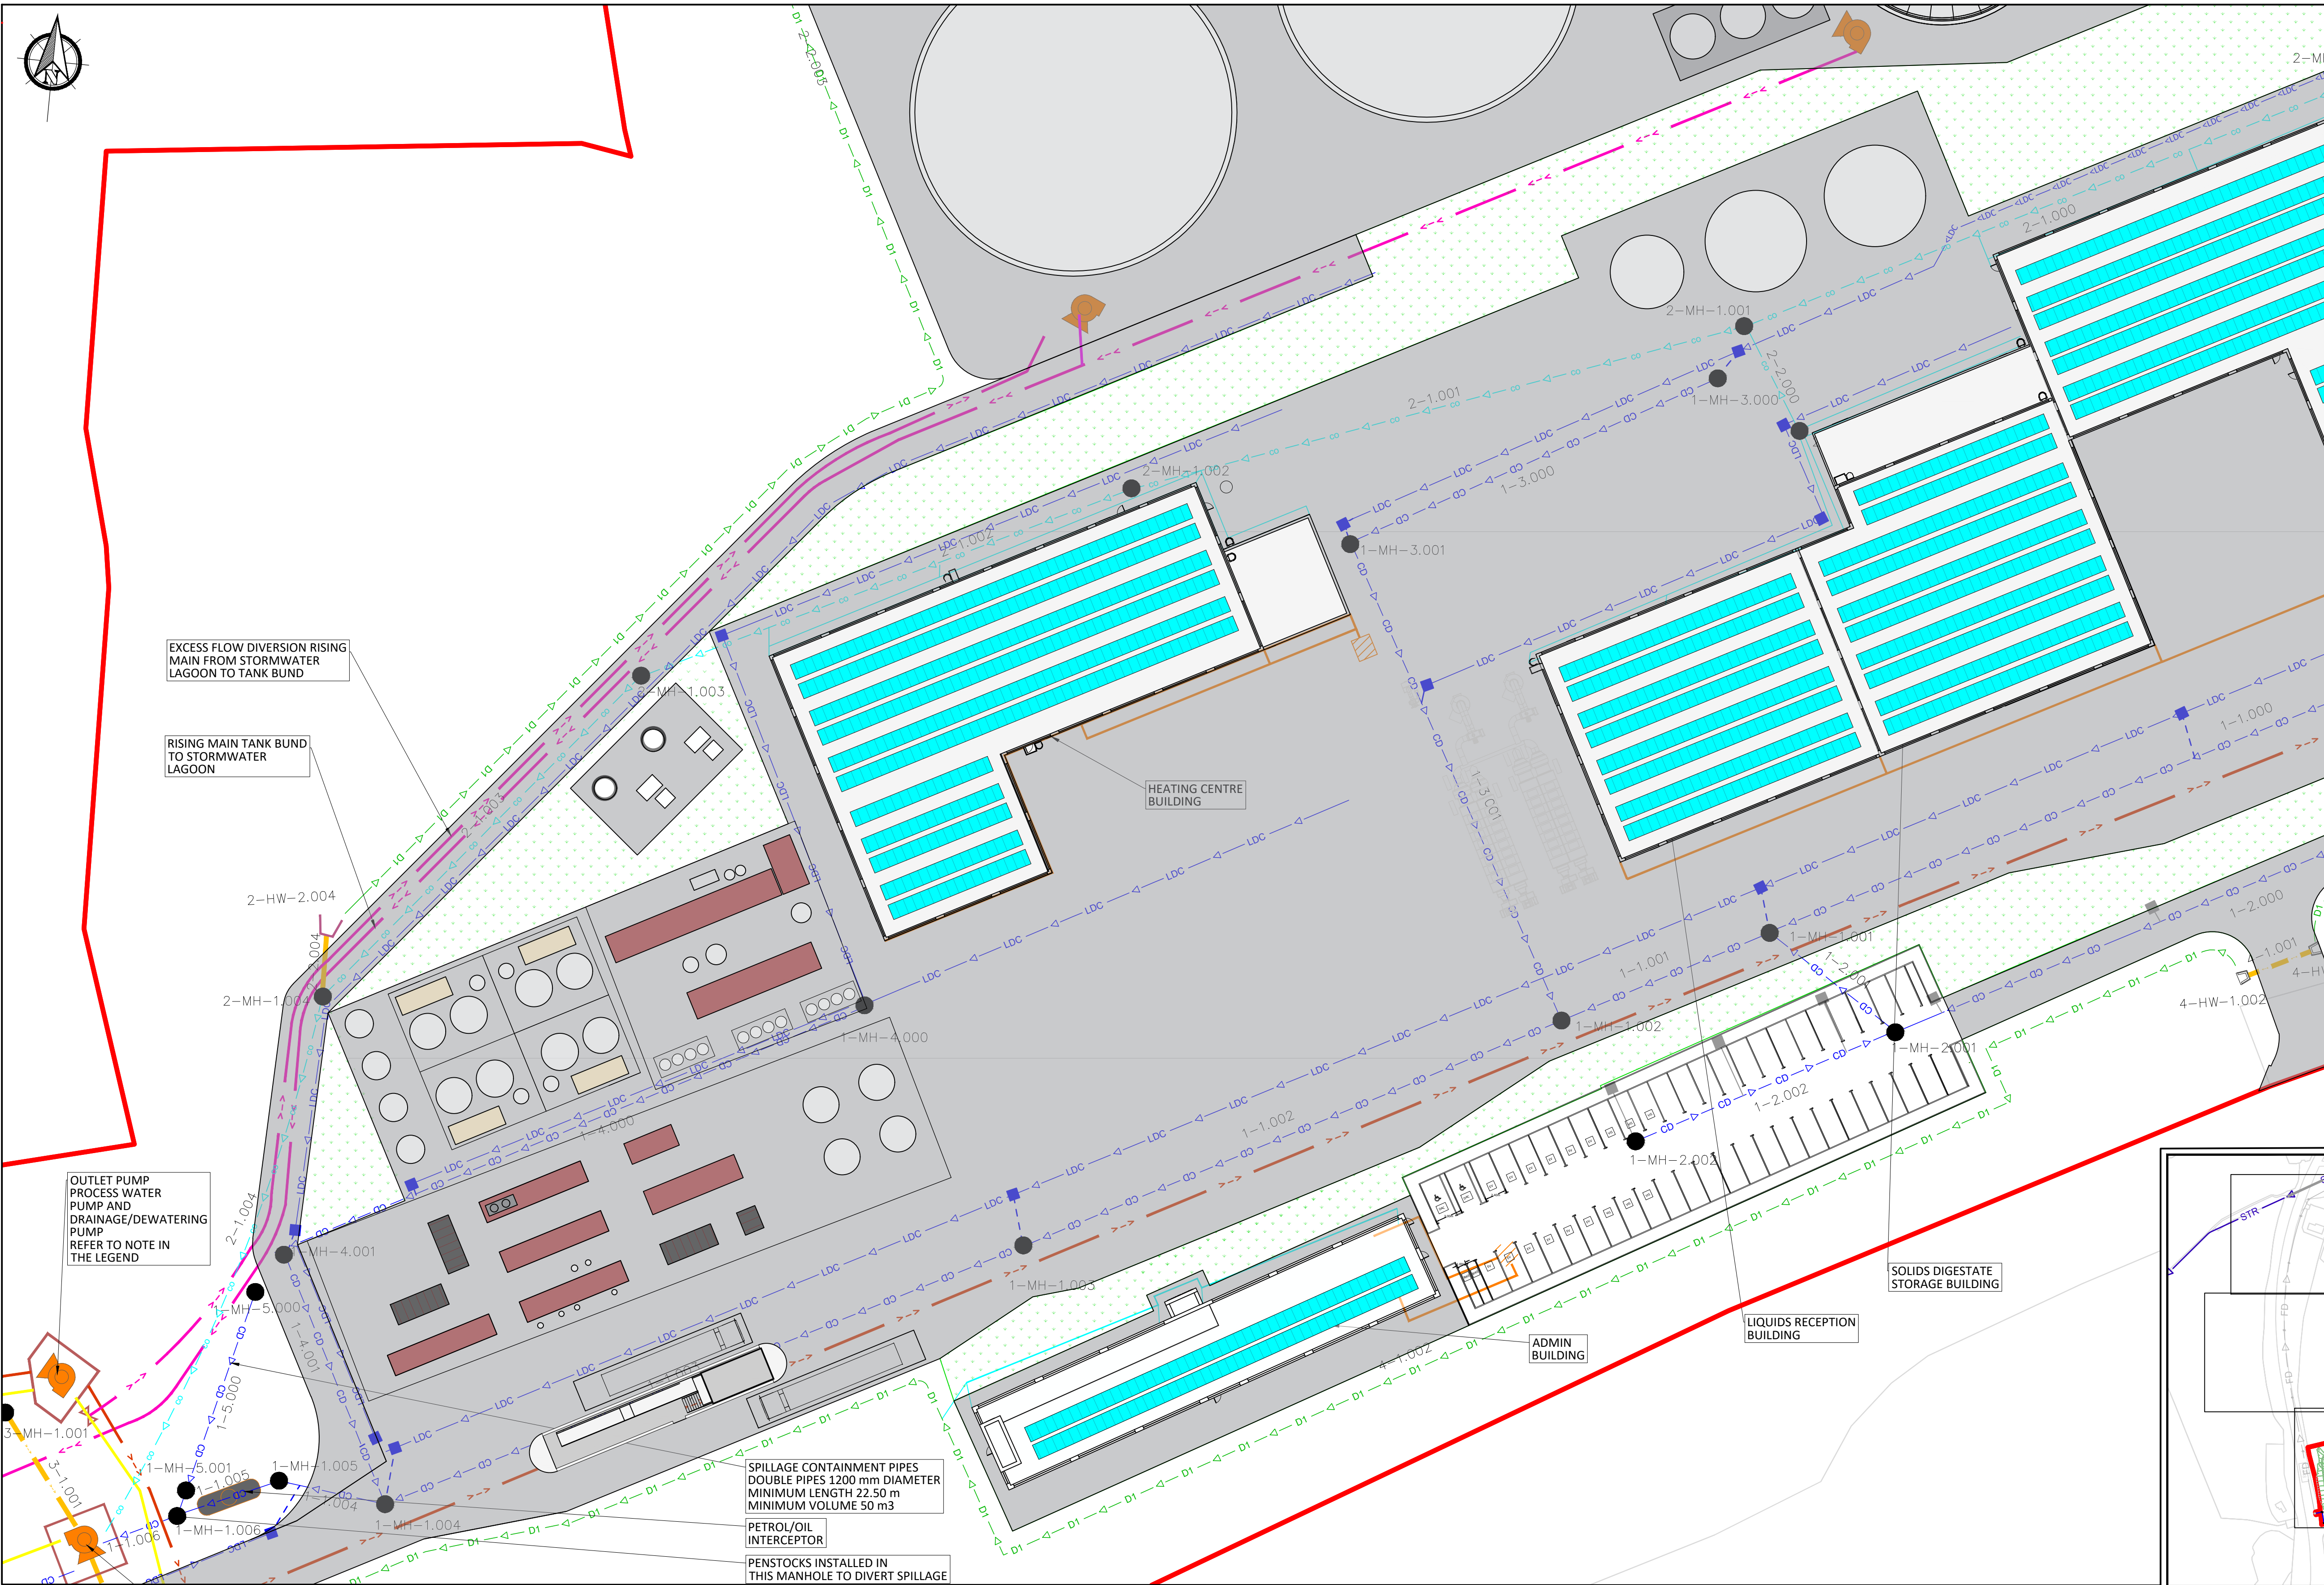

- Legend**
- Site Boundary
 - Interceptor Drains
 - Cross Drains
 - Powerstown Stream
 - Filter Drains
 - Carrier Drains
 - Linear Drainage Channel
 - Linear Drainage Outlet
 - Proposed Gully
 - Rainwater Drainage Collector
 - Rainwater Roof Drainage
 - Manhole
 - Process Water Rising Mains
 - Stormwater Lagoon Rising Mains
 - Rising Mains between Tank Bund to Stormwater Lagoon (both directions)
 - Valve
 - Pump
 - Petrol/Oil Interceptor
 - Foul Water Network
 - Foul Water Tank
 - Existing Filter Drain (Indicative)
 - Existing Carrier Drain (Indicative)
 - Existing Manhole (Indicative)
 - Infiltration Areas
 - Yard & Circulation Areas

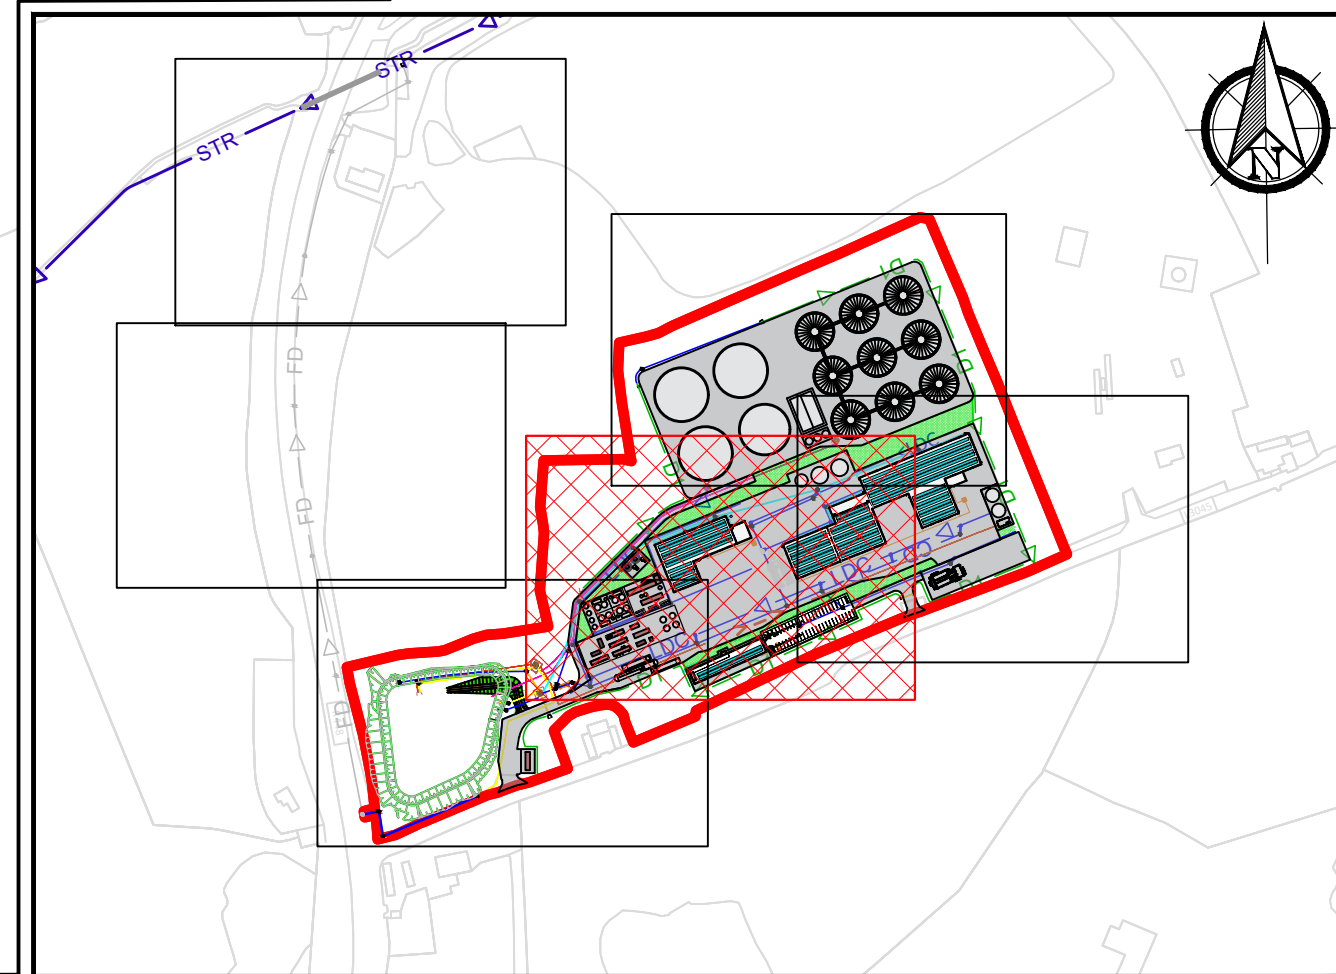

If Applicable : Tailte Éireann Licence No. CYAL50368274 © Ordnance Survey Ireland and Government of Ireland 4531-B

Rev.	Description	App By	Date
P01	ISSUE FOR PLANNING	JON	24.06.26

PROJECT	POWERSTOWN BIOENERGY			CLIENT	Greengate Biogas		
SHEET	PROPOSED SITE DRAINAGE PLAN - SHEET 4 OF 6 -			Date	24.06.26	Project number	P24-188
				Drawn by	EB	Drawing Number	P24188-FT-XX-XX-DR-CE-0504
				Checked by	JON	Scale (@ A1) As Shown	Rev P01

O:\ACAD\2024\P24-188\P24188-FT-XX-XX-DR-CE-0504