


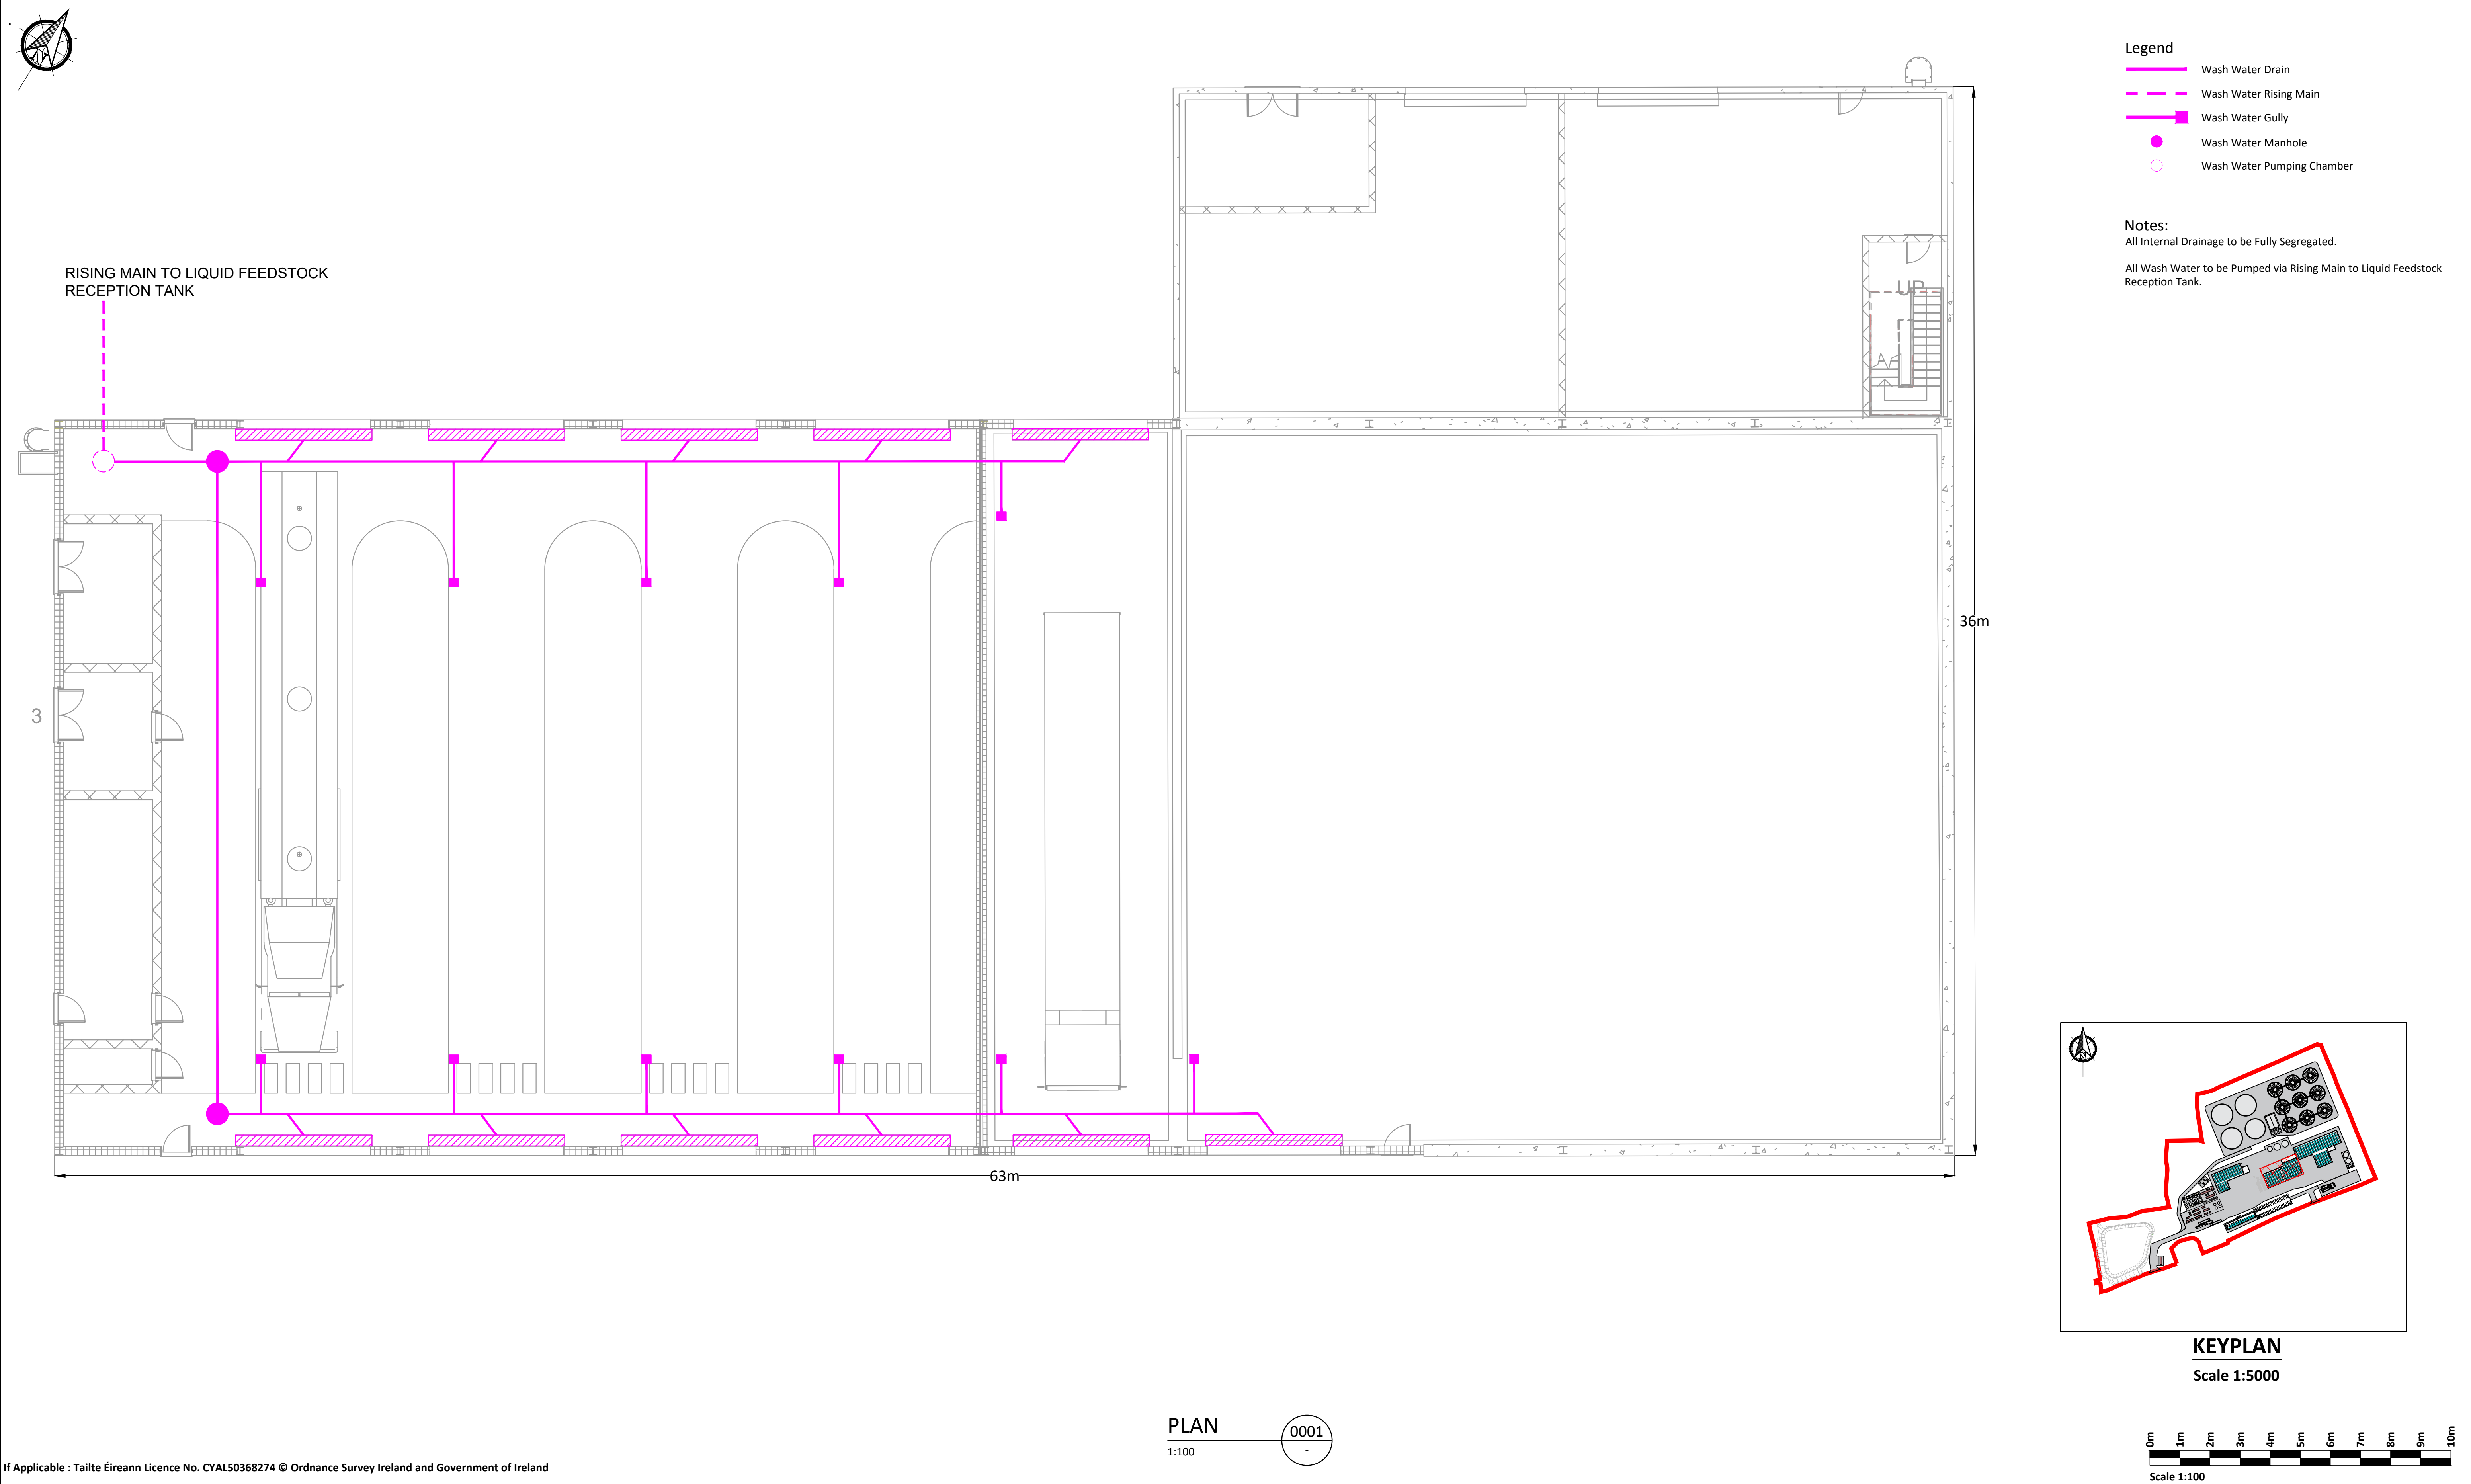

If Applicable : Tailte Éireann Licence No. CYAL50368274 © Ordnance Survey Ireland and Government of Ireland

Rev.	Description	App By	Date
P01	ISSUE FOR PLANNING	JON	18.06.26

PROJECT		CLIENT				
POWERSTOWN BIOENERGY						
SHEET	PROPOSED INTERNAL DRAINAGE PLAN - LIQUIDS RECEPTION BUILDING & SOLID DIGESTATE BUILDING	Date	11.07.26	Project number	P24-188	Scale (@ A1) As Shown
		Drawn by	EB	Drawing Number		Rev P01
		Checked by	JON	P24188-FT-XX-XX-DR-CE-0510		
		(Sheet set subject D500)				

O:\ACAD\2024\P24-188\P24188-FT-XX-XX-DR-CE-0510

29 June 2026 (O:\ACAD\2024\P24-188\P24188-FT-XX-XX-DR-CE-0510)