

NOTES
Drawings for planning purposes only.

Internal Mechanical and Electrical Plant shown for illustrative purposes only, subject to detailed mechanical and electrical design.

Adjacent building(s) omitted for clarity; See Site Layout Plan P24188-FT-XX-XX-DR-CE-0110.

Gross Internal Floor Area = 2386 m2

Levels are relative to Malin Head Datum

Legend

Proposed RC Wall

Proposed Kingspan Cladding


Reception Hall Area

Materials Bunker Area


Electrical and Control Area

Solid Infeed Area(s) Area

Solid Infeed Pretreatment Shredding

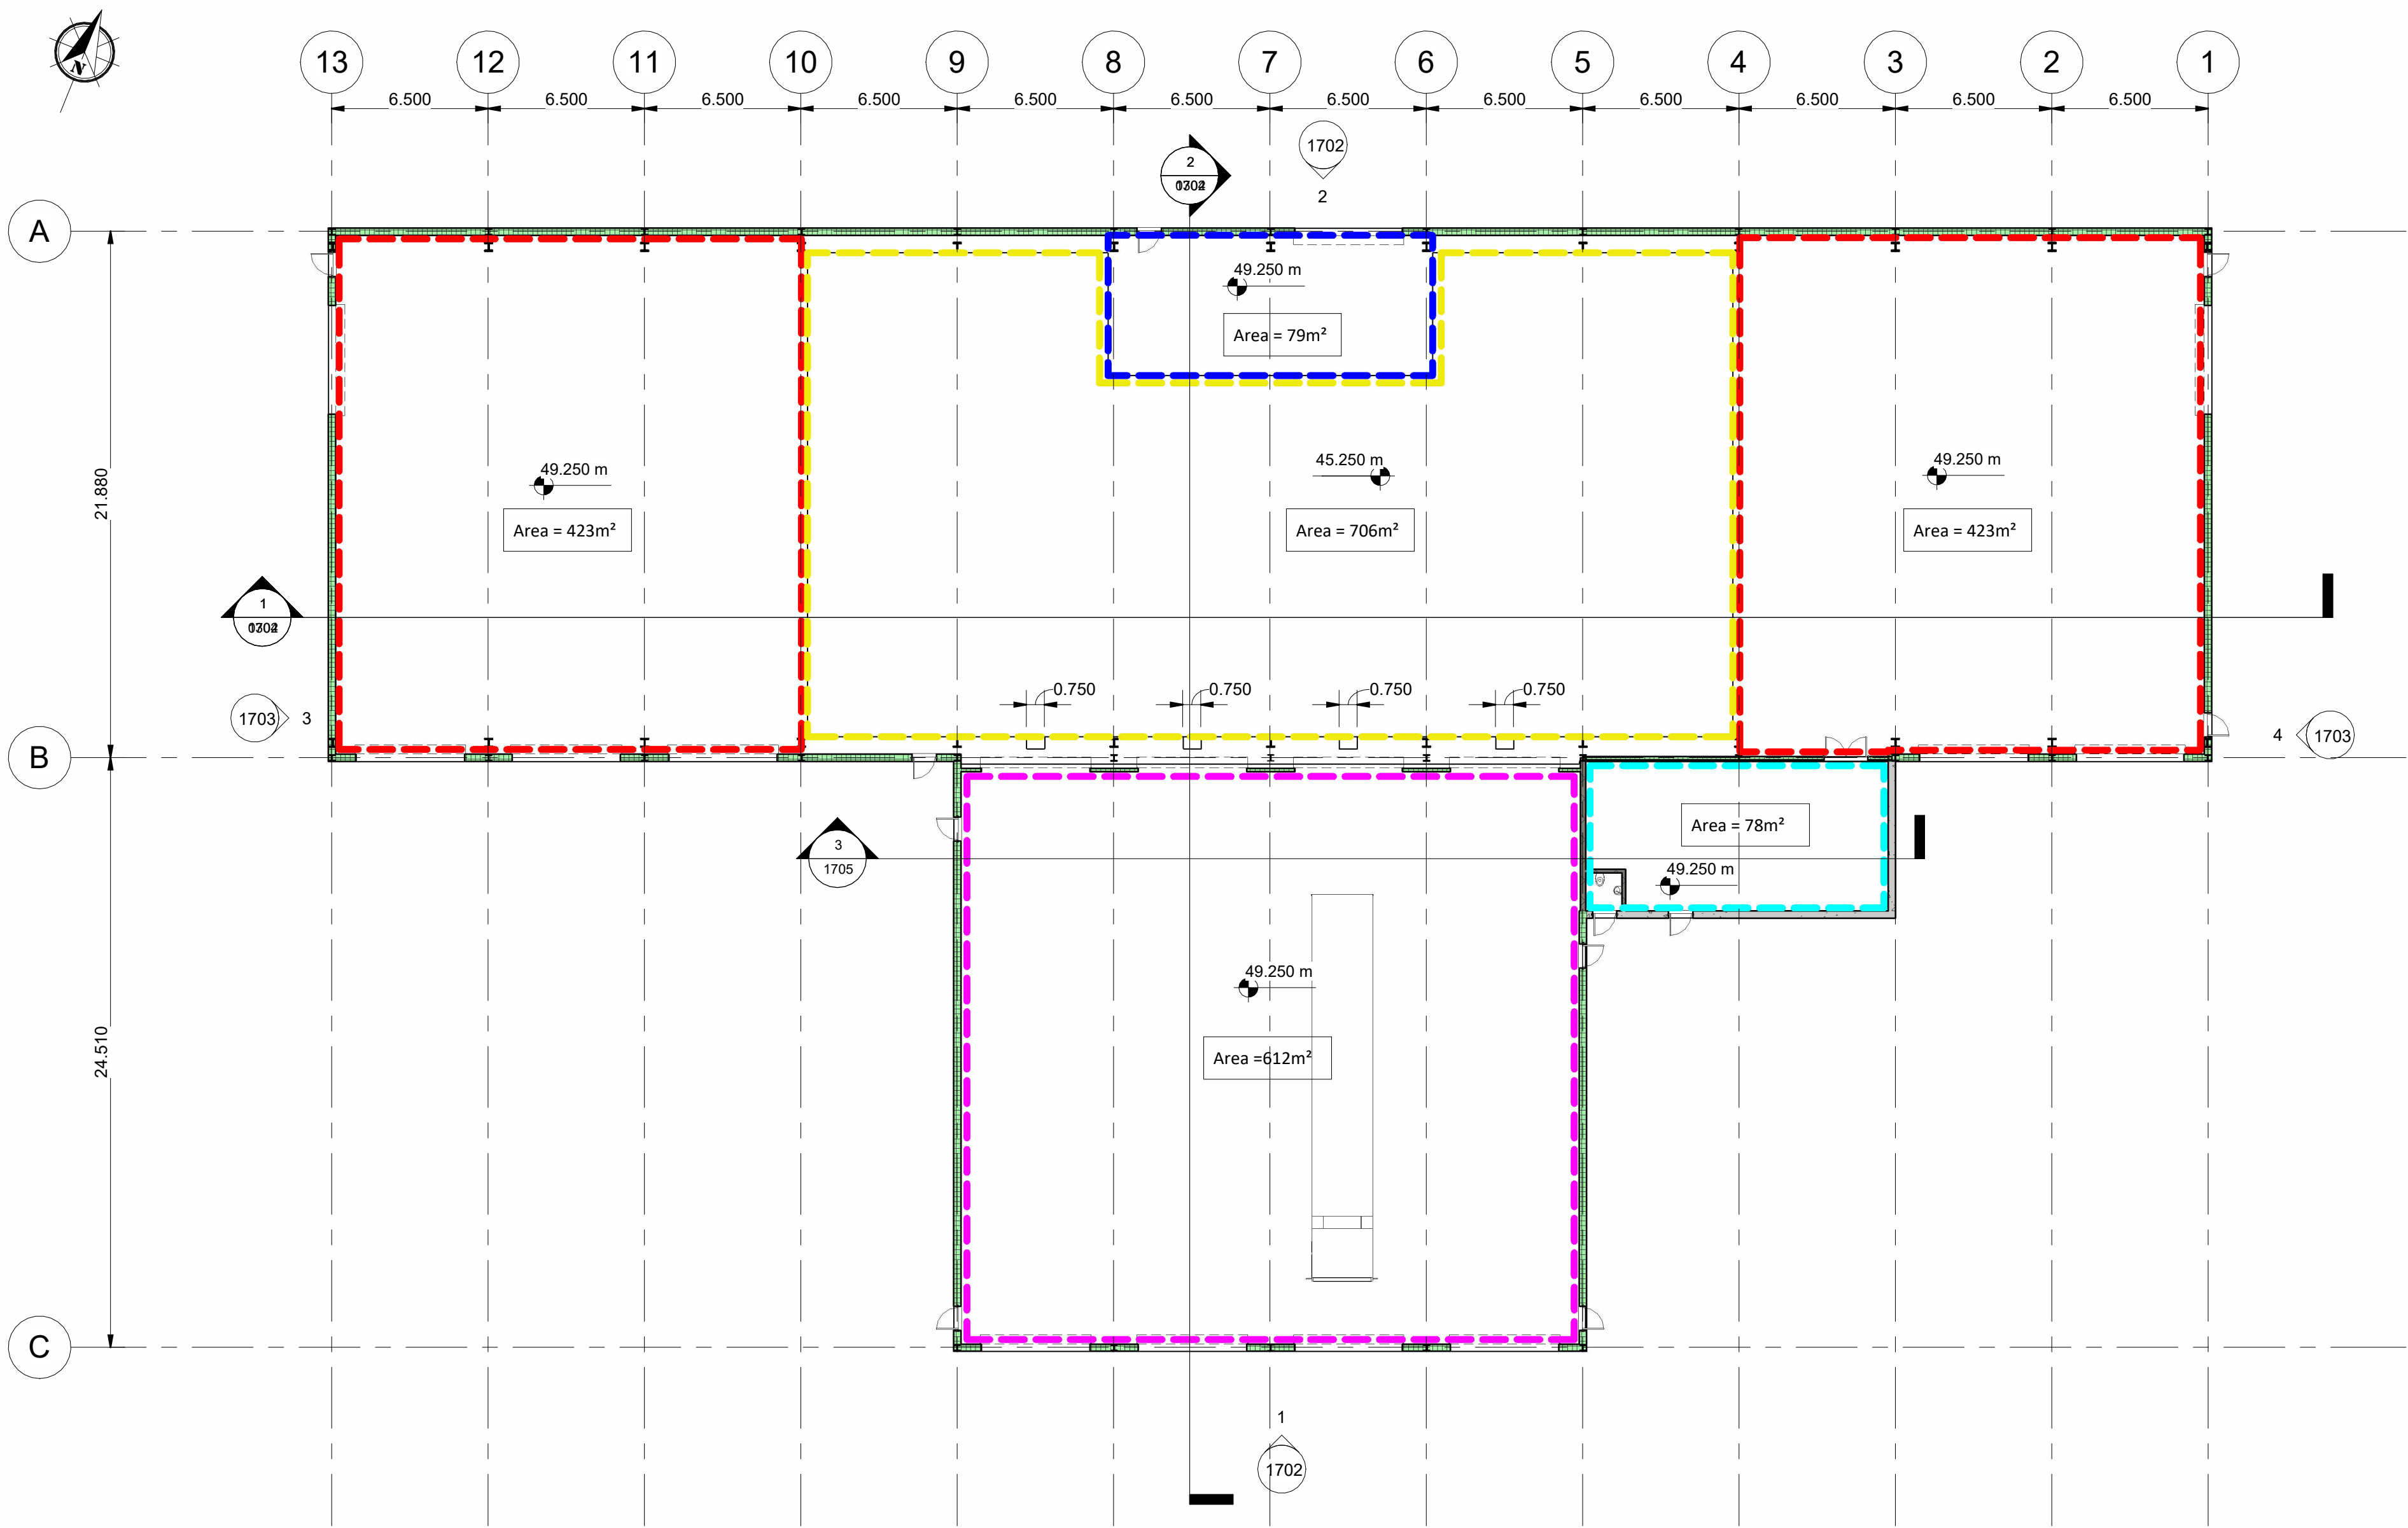

SOLIDS RECEPTION FLOOR PLAN
Scale 1 : 200

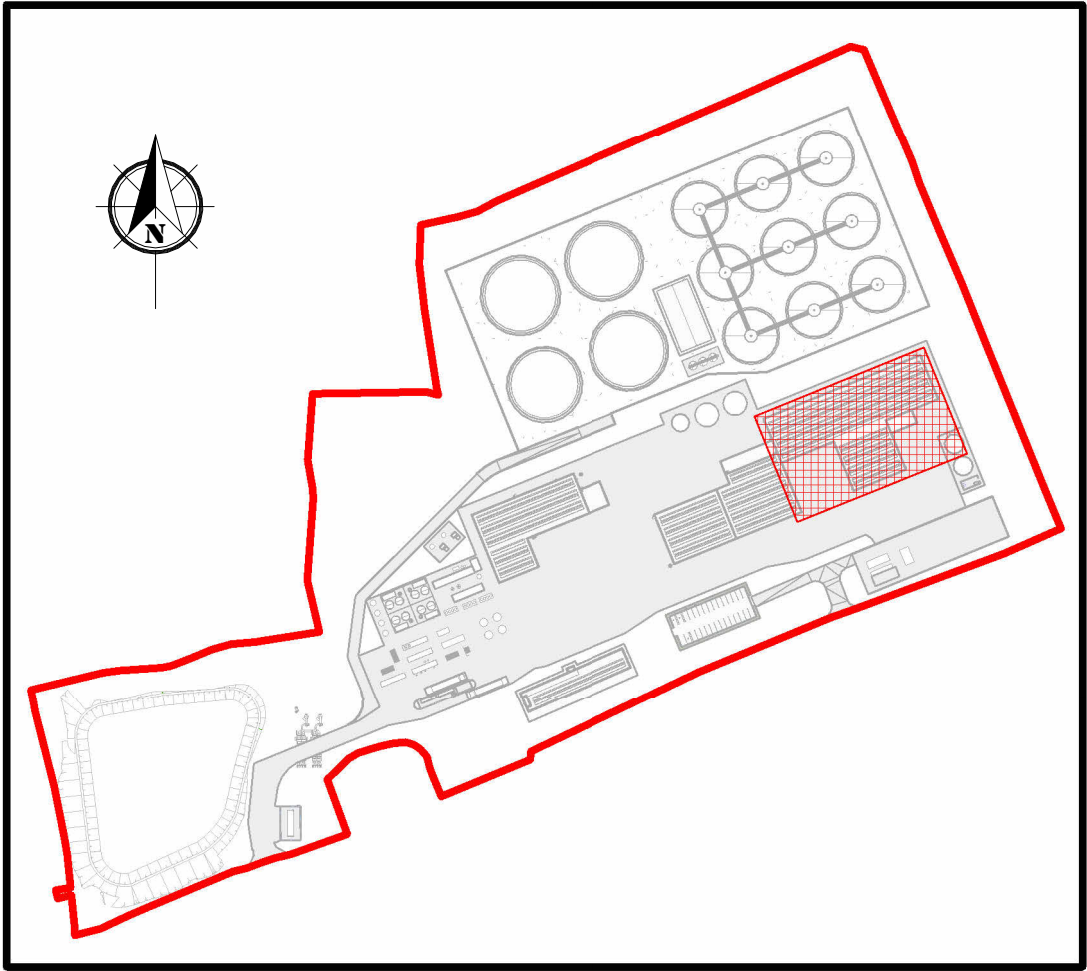

KEYPLAN
Scale 1 : 3500

Rev.	Description	App By	Date
P01	ISSUE FOR PLANNING	JON	18.06.26

PROJECT		CLIENT		
POWERSTOWN BIOENERGY				
SHEET	Date		Project Number	Scale (at A1)
	18.08.25		P24188	As indicated
	Drawn by	NW	Drawing Number	Rev
Checked by		JON	P24188-FT-XX-XX-DR-CE-1700	P01