



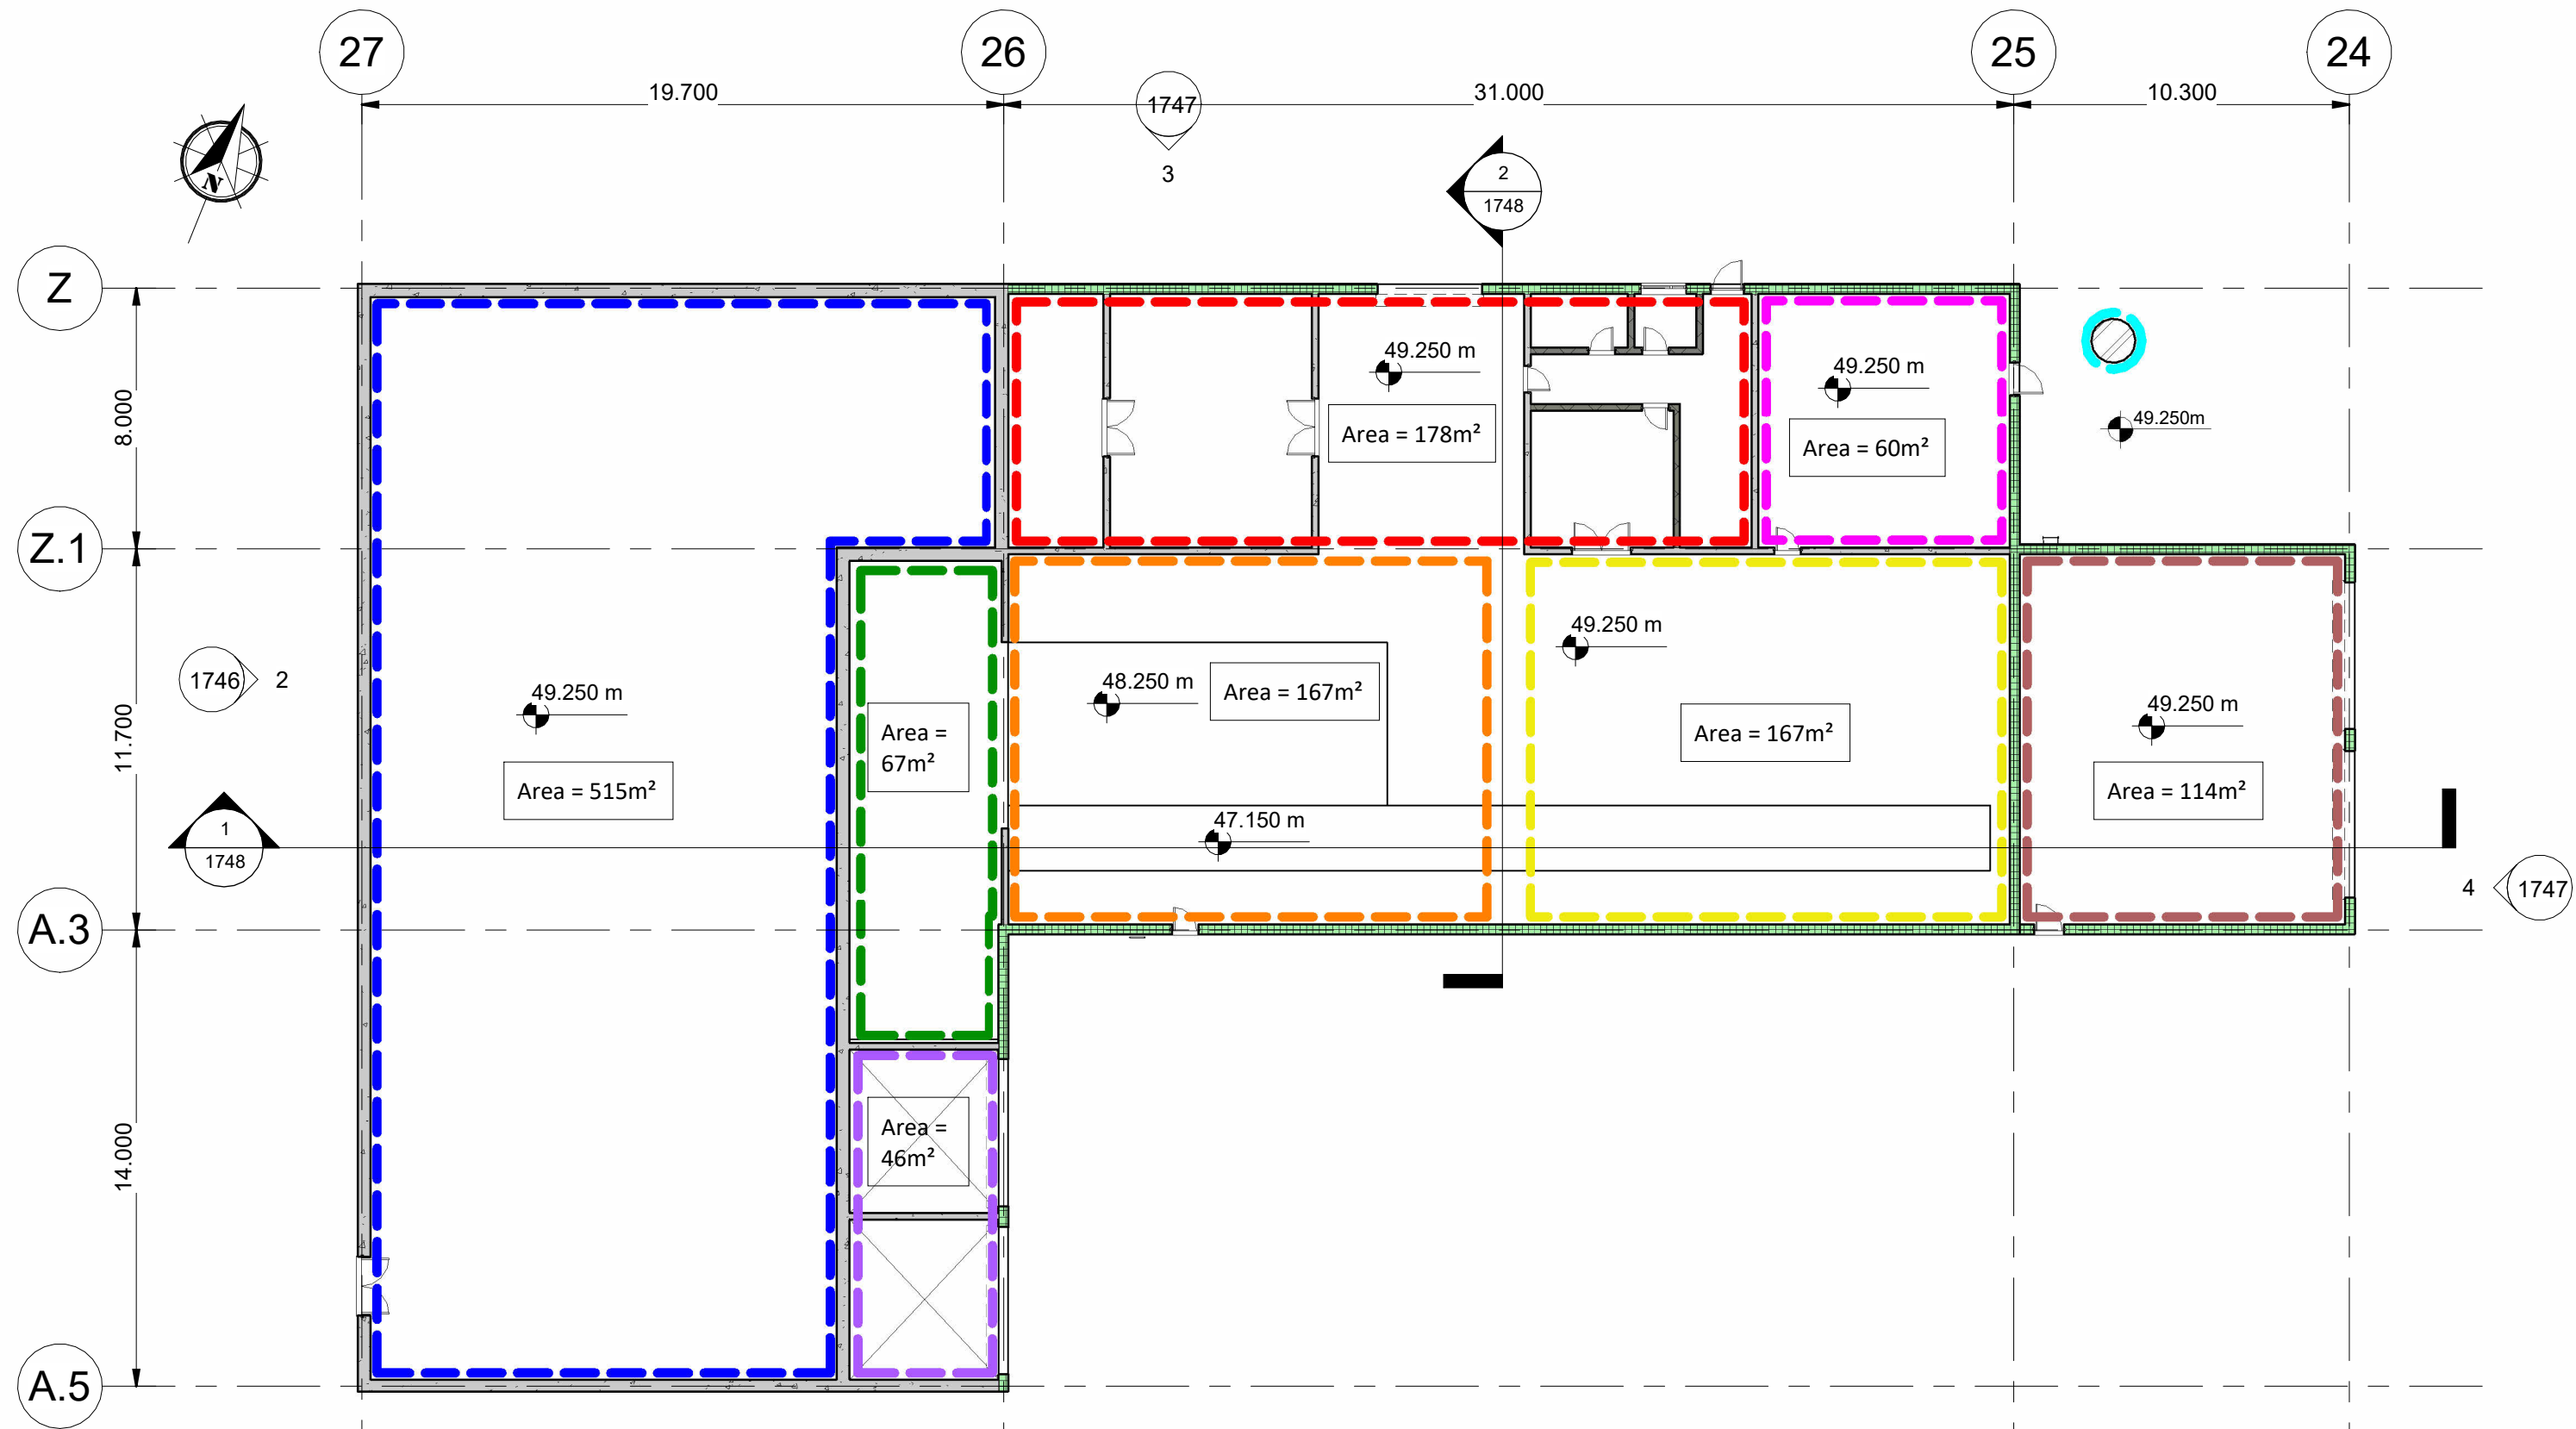

HEATING CENTRE FLOOR PLAN
Scale 1 : 200

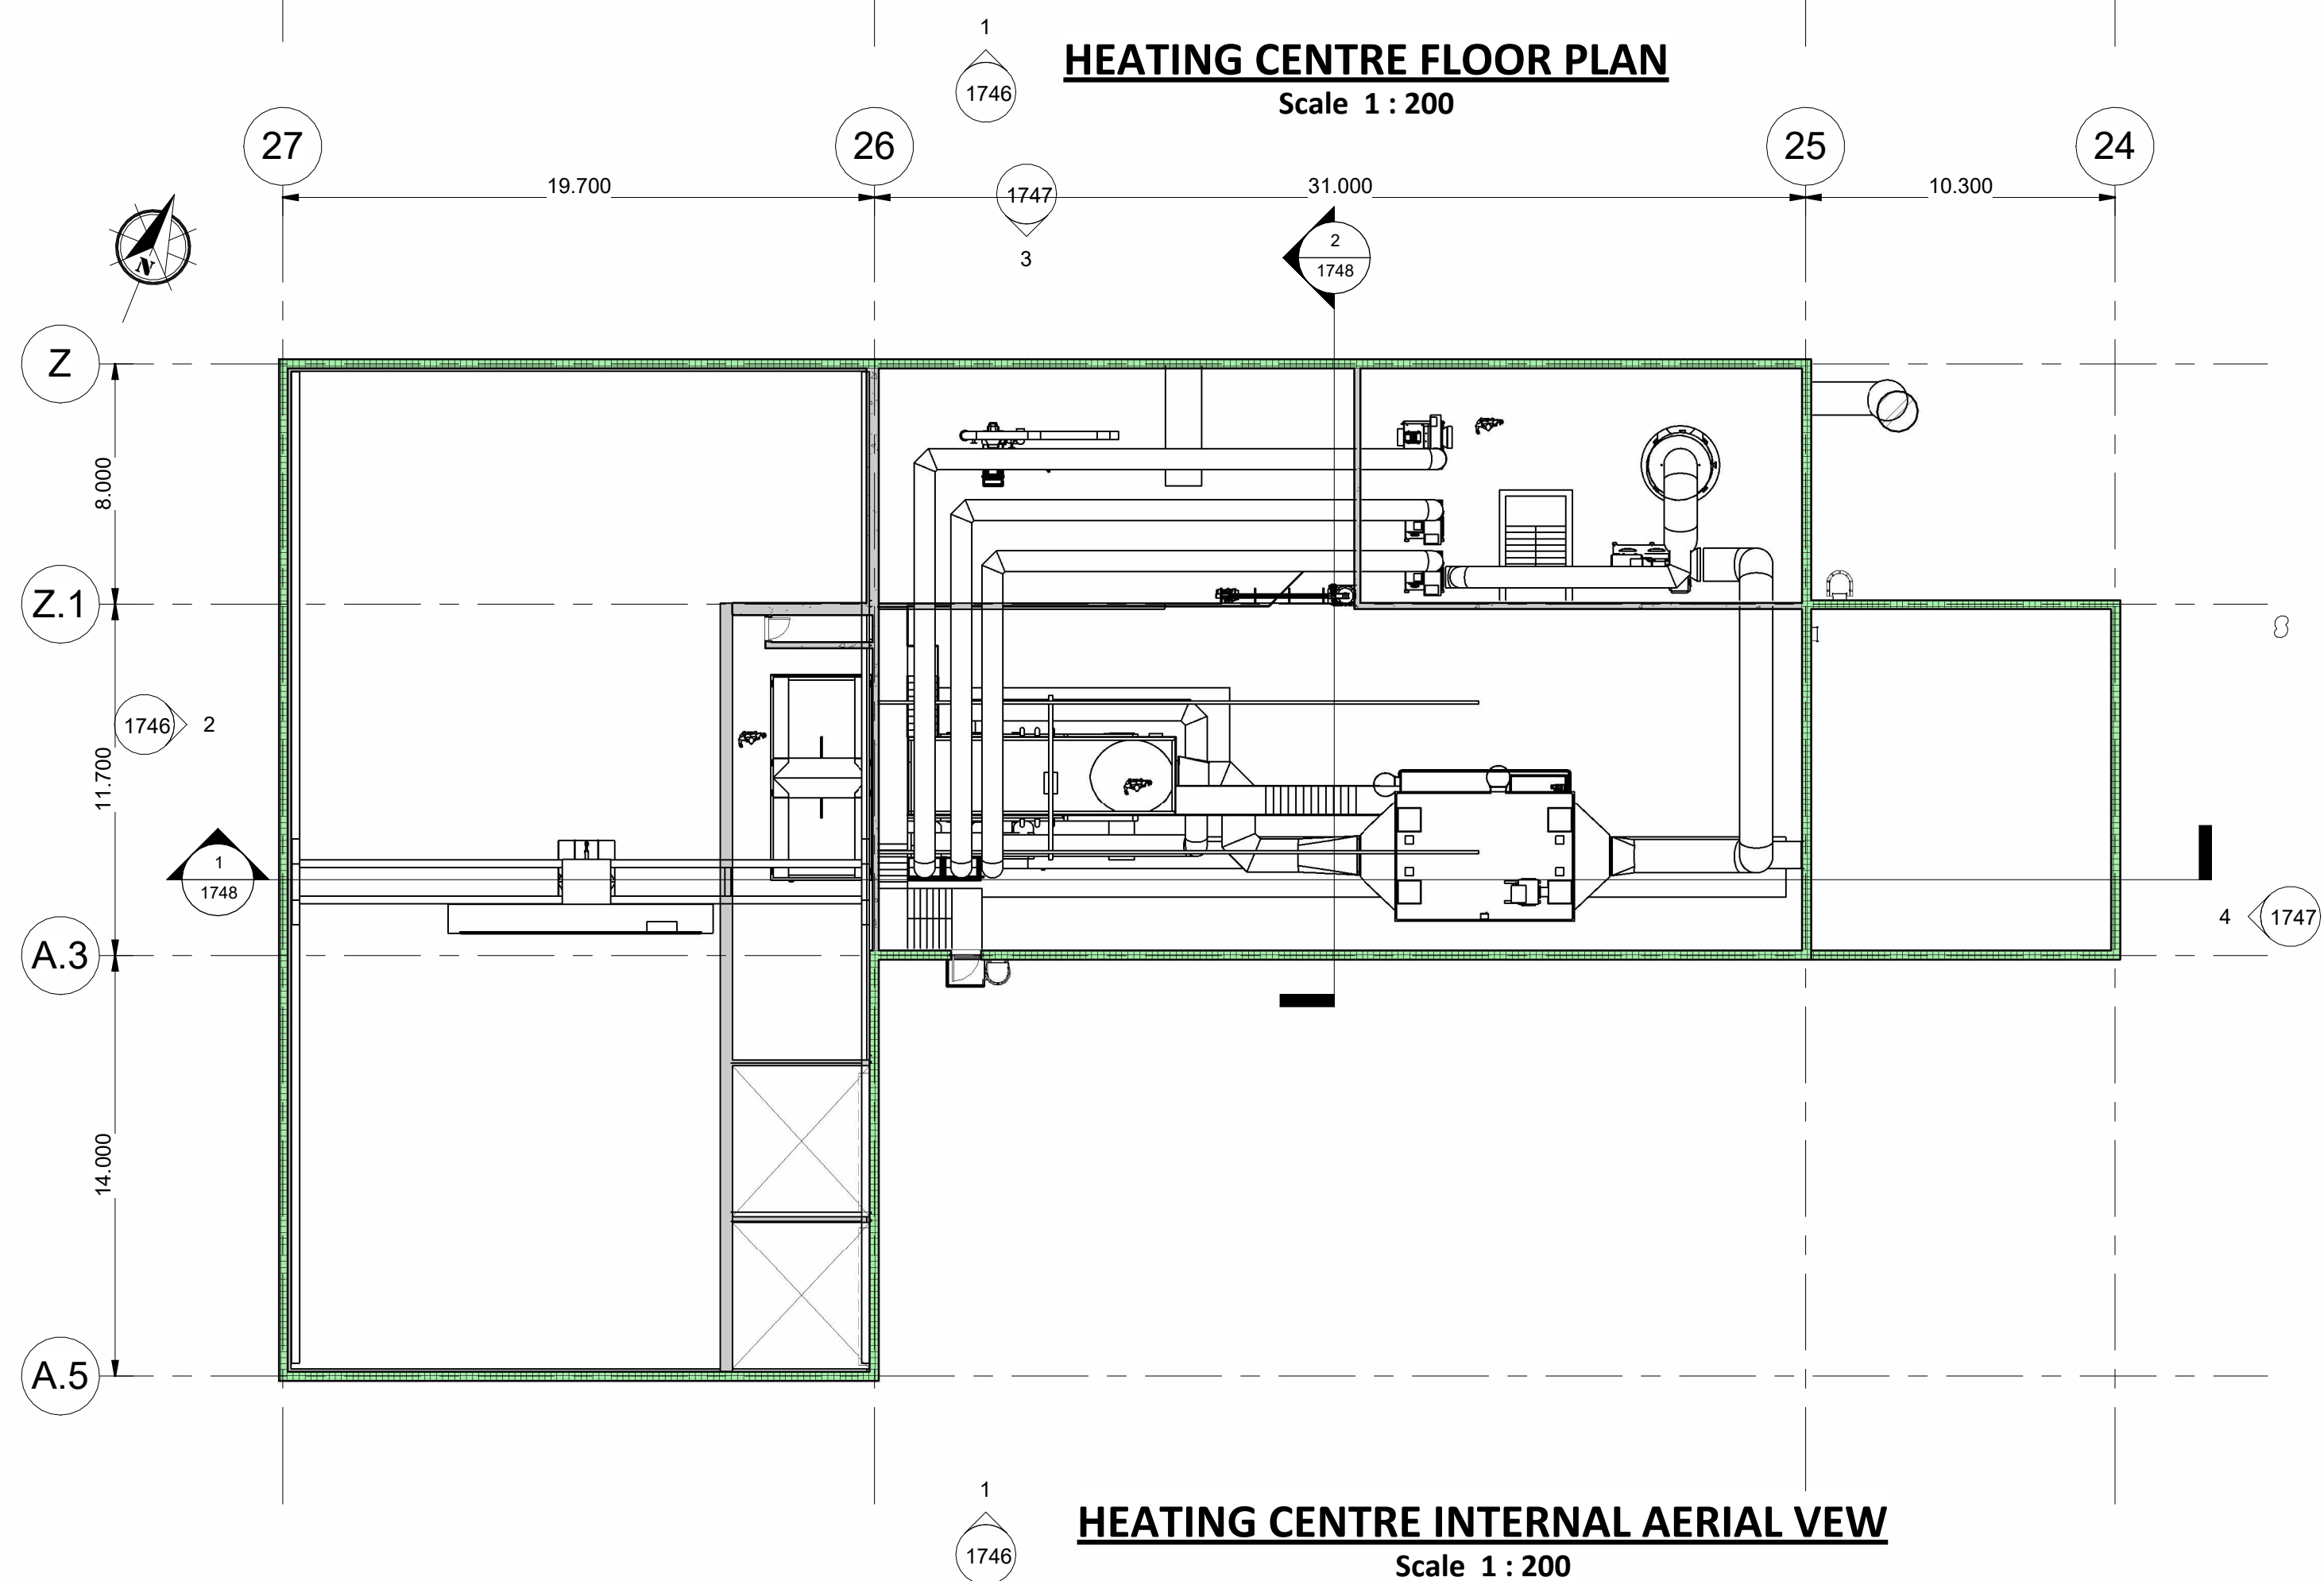

HEATING CENTRE INTERNAL AERIAL VIEW
Scale 1 : 200

NOTES
Drawings for planning purposes only.

Solar panel layout for illustrative purposes only, subject to detailed design.

Internal Mechanical and Electrical Plant shown for illustrative purposes only, subject to detailed mechanical and electrical design.

Access

Permanent Access Walkways

Permanent Access Walkways to be provided to roof areas for solar panel service and maintenance.

Roof Access Ladders

Permanent Roof Access Ladders to be provided. Roof Access Ladders the requirements of DIN 18799-1&3 Fixed ladders for construction works; Fire Escape Ladders to the requirements of DIN 14094-1, Fixed fire-escape ladders as applicable.


Safety

Parapet edge protection provided, provision of additional protective measures subject to detailed design.


Gross Floor Area = 1,314 m2

Legend

- Proposed RC Wall
- Proposed Kingspan Cladding
- Biomass Reception Pit
- Biomass Storage Bunker
- Biomass Infeed
- Biomass Boiler
- Exhaust Air Treatment System Filter
- Exhaust Air Treatment System Scrubber
- Exhaust Stack
- Operations, Access M&E and Welfare
- Ash Container Hall
- Ash Conveyor System

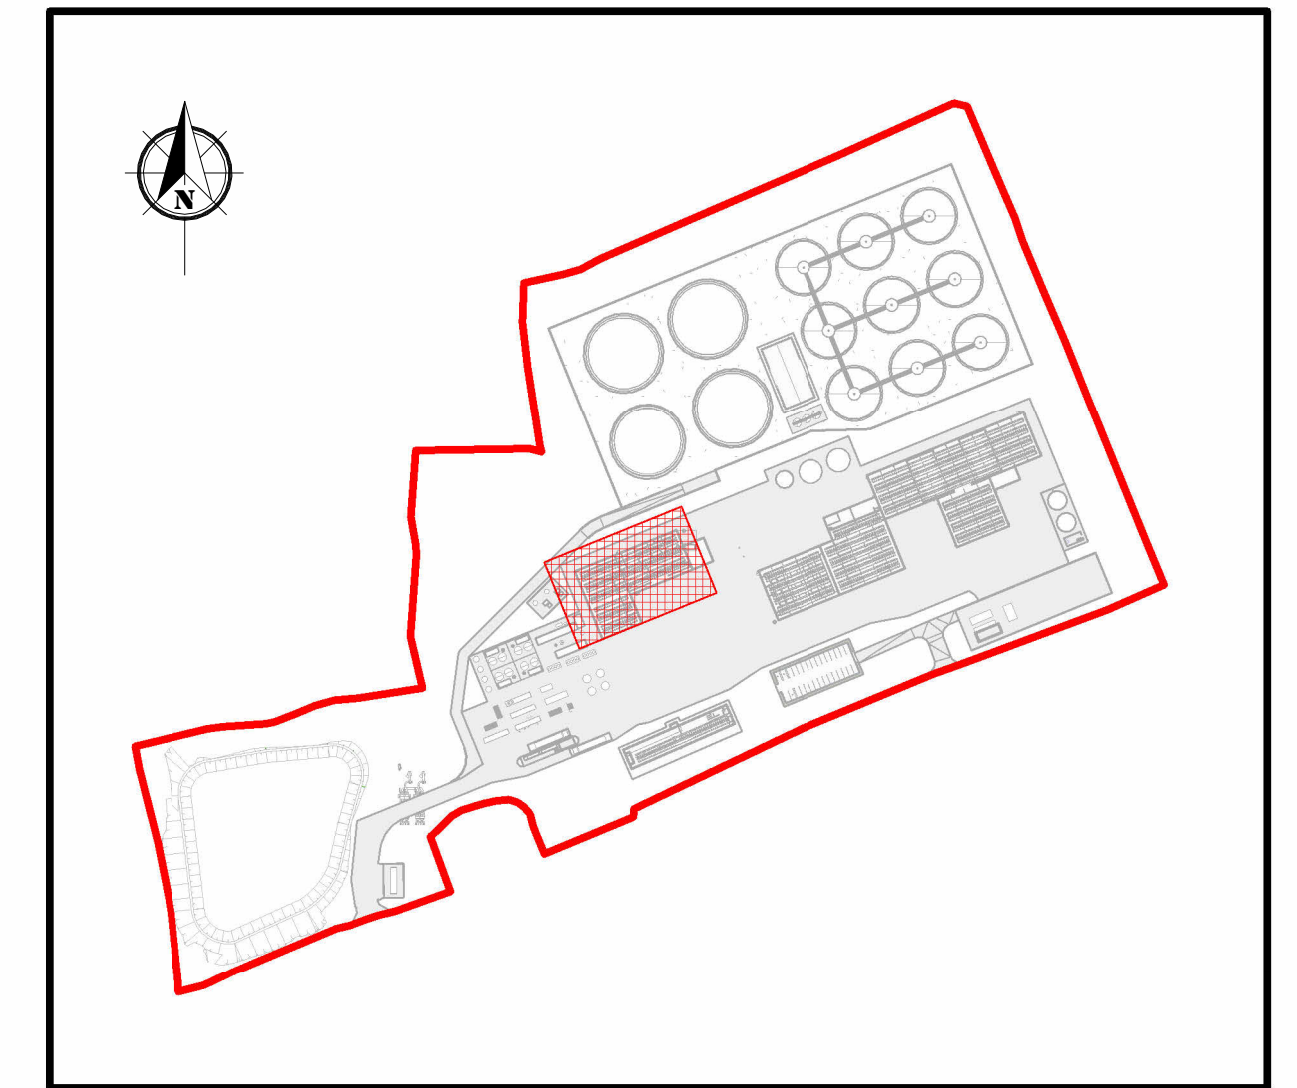

KEYPLAN
Scale 1 : 3500

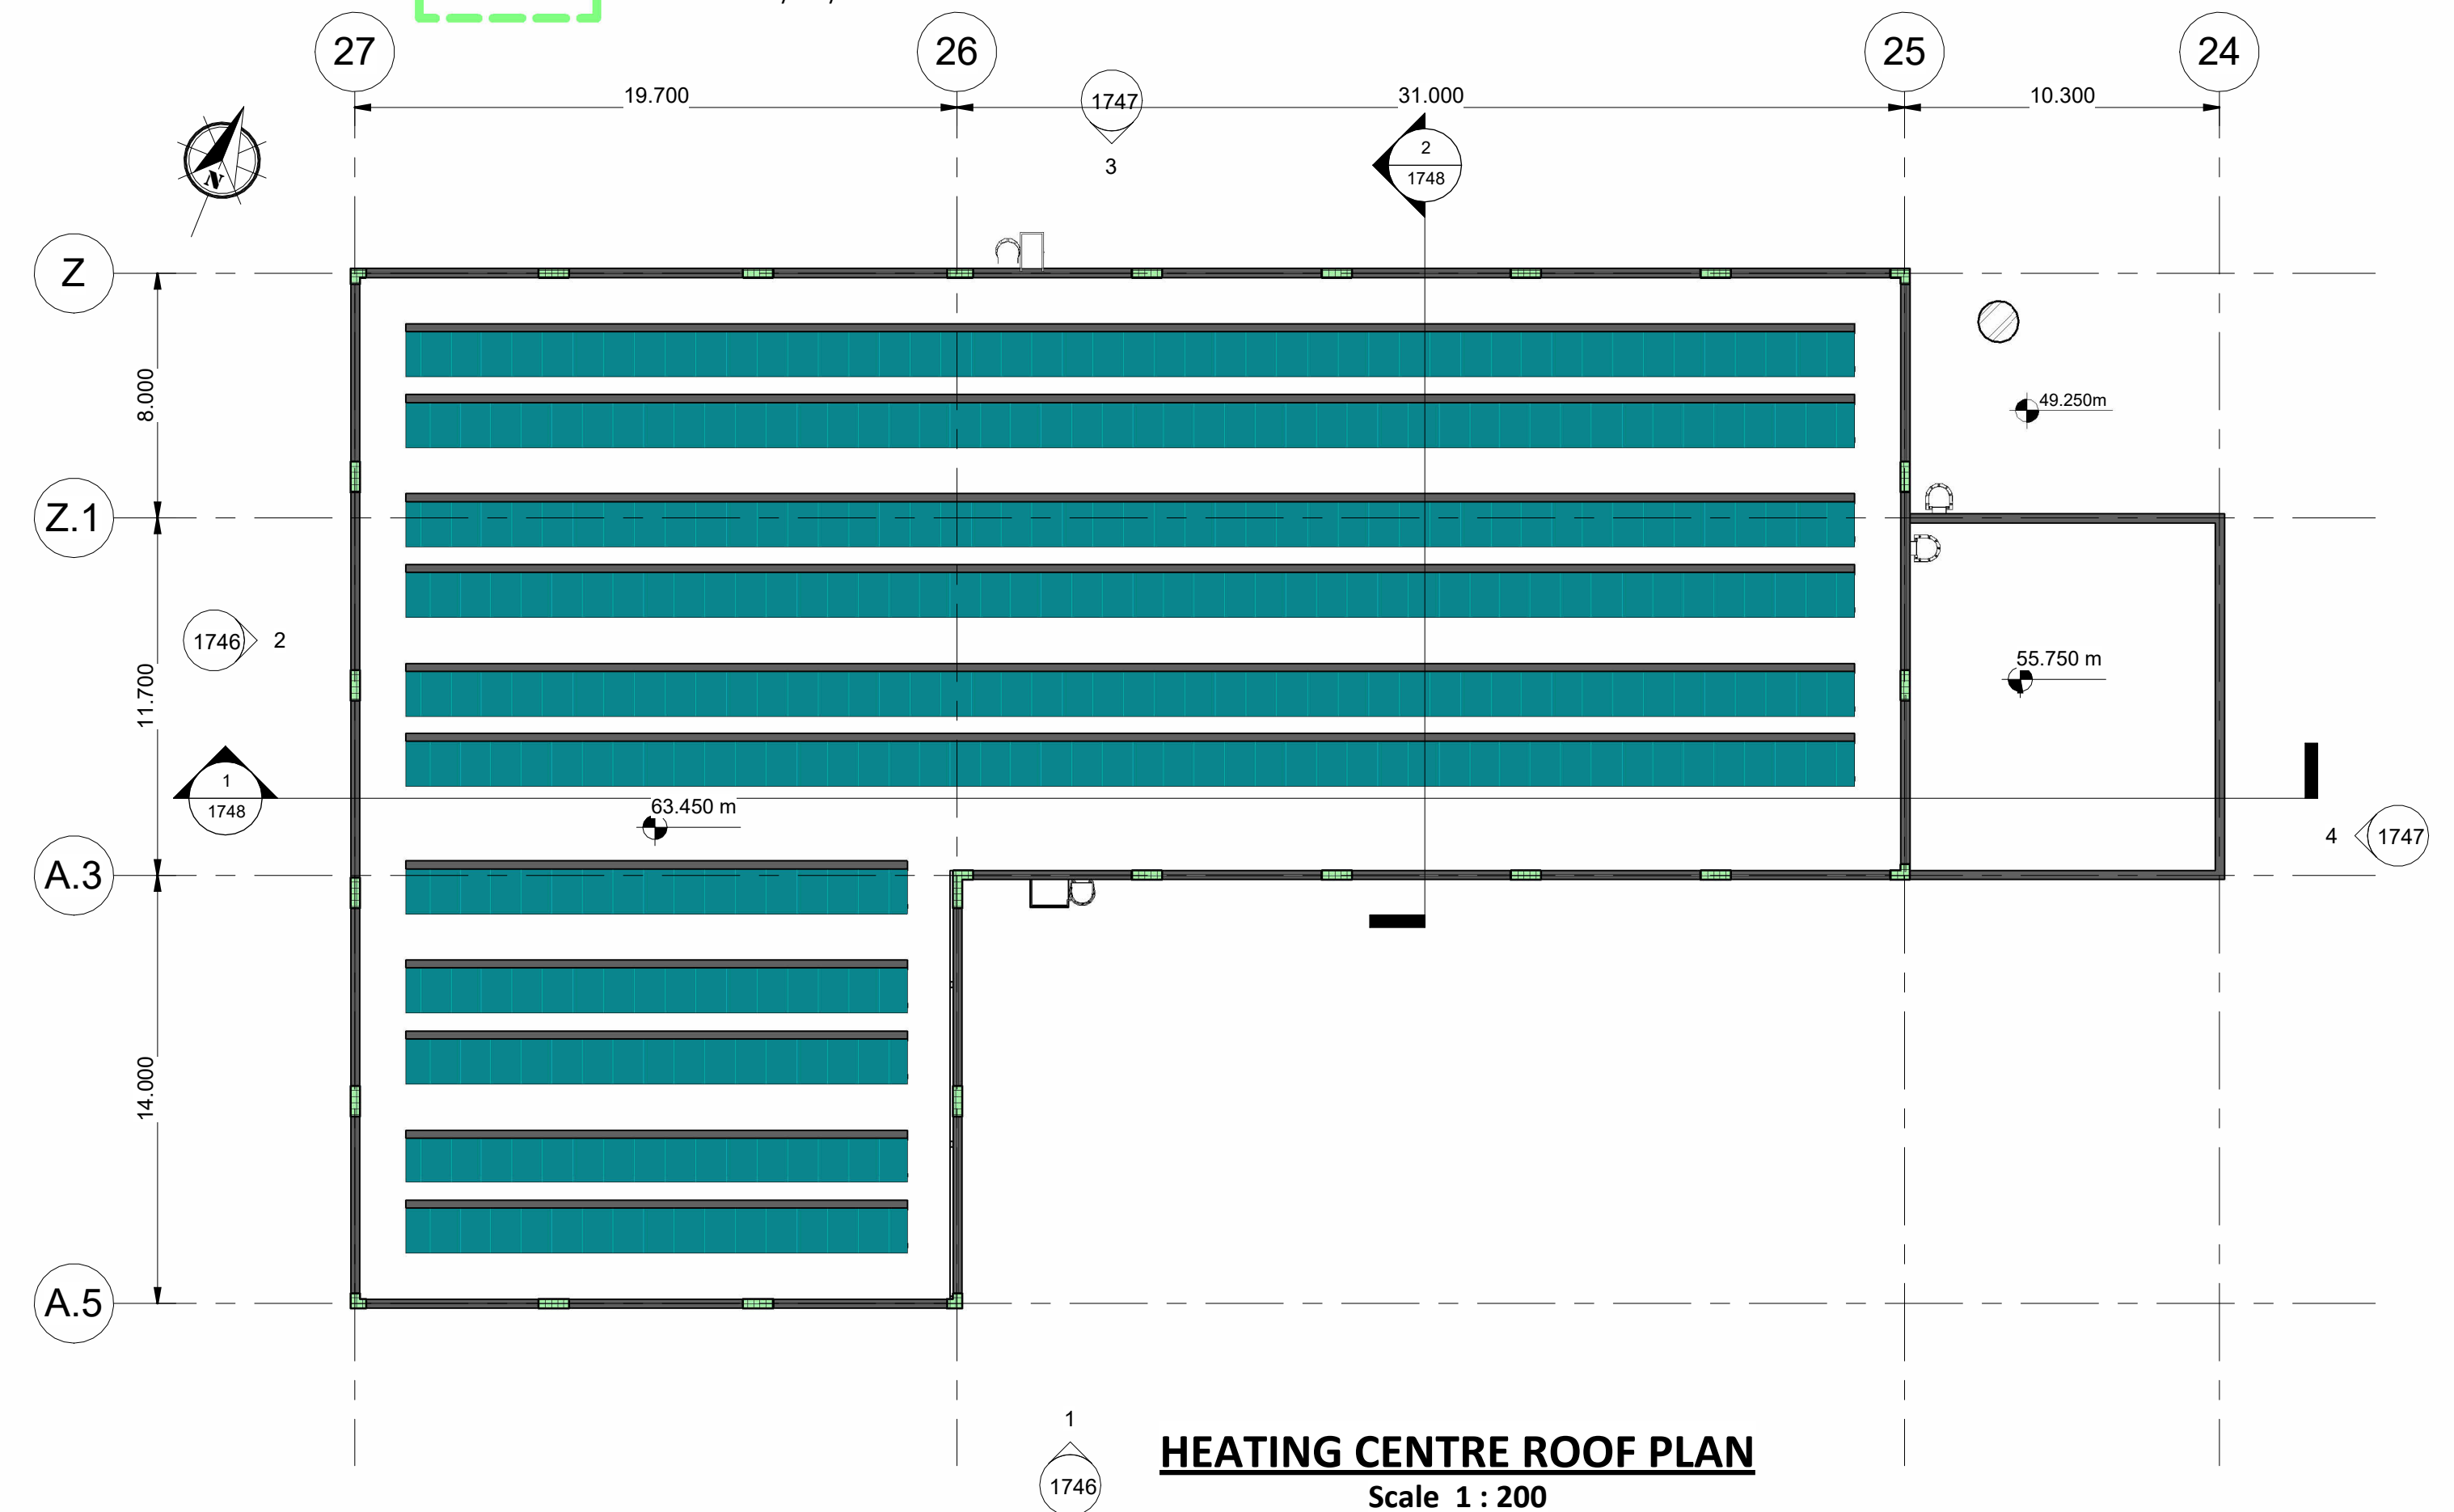

HEATING CENTRE ROOF PLAN
Scale 1 : 200

Rev.	Description	App By	Date
P01	ISSUE FOR PLANNING	JON	18.06.26

PROJECT	CLIENT		
POWERSTOWN BIOENERGY	Greengate Biogas		
SHEET	Date	Project Number	Scale (at A1)
HEATING CENTRE PLANS	18.06.26	P24188	As indicated
	Drawn by	Drawing Number	Rev
	NW	P24188-FT-XX-XX-DR-CE-1745	P01
	Checked by	Checker	