




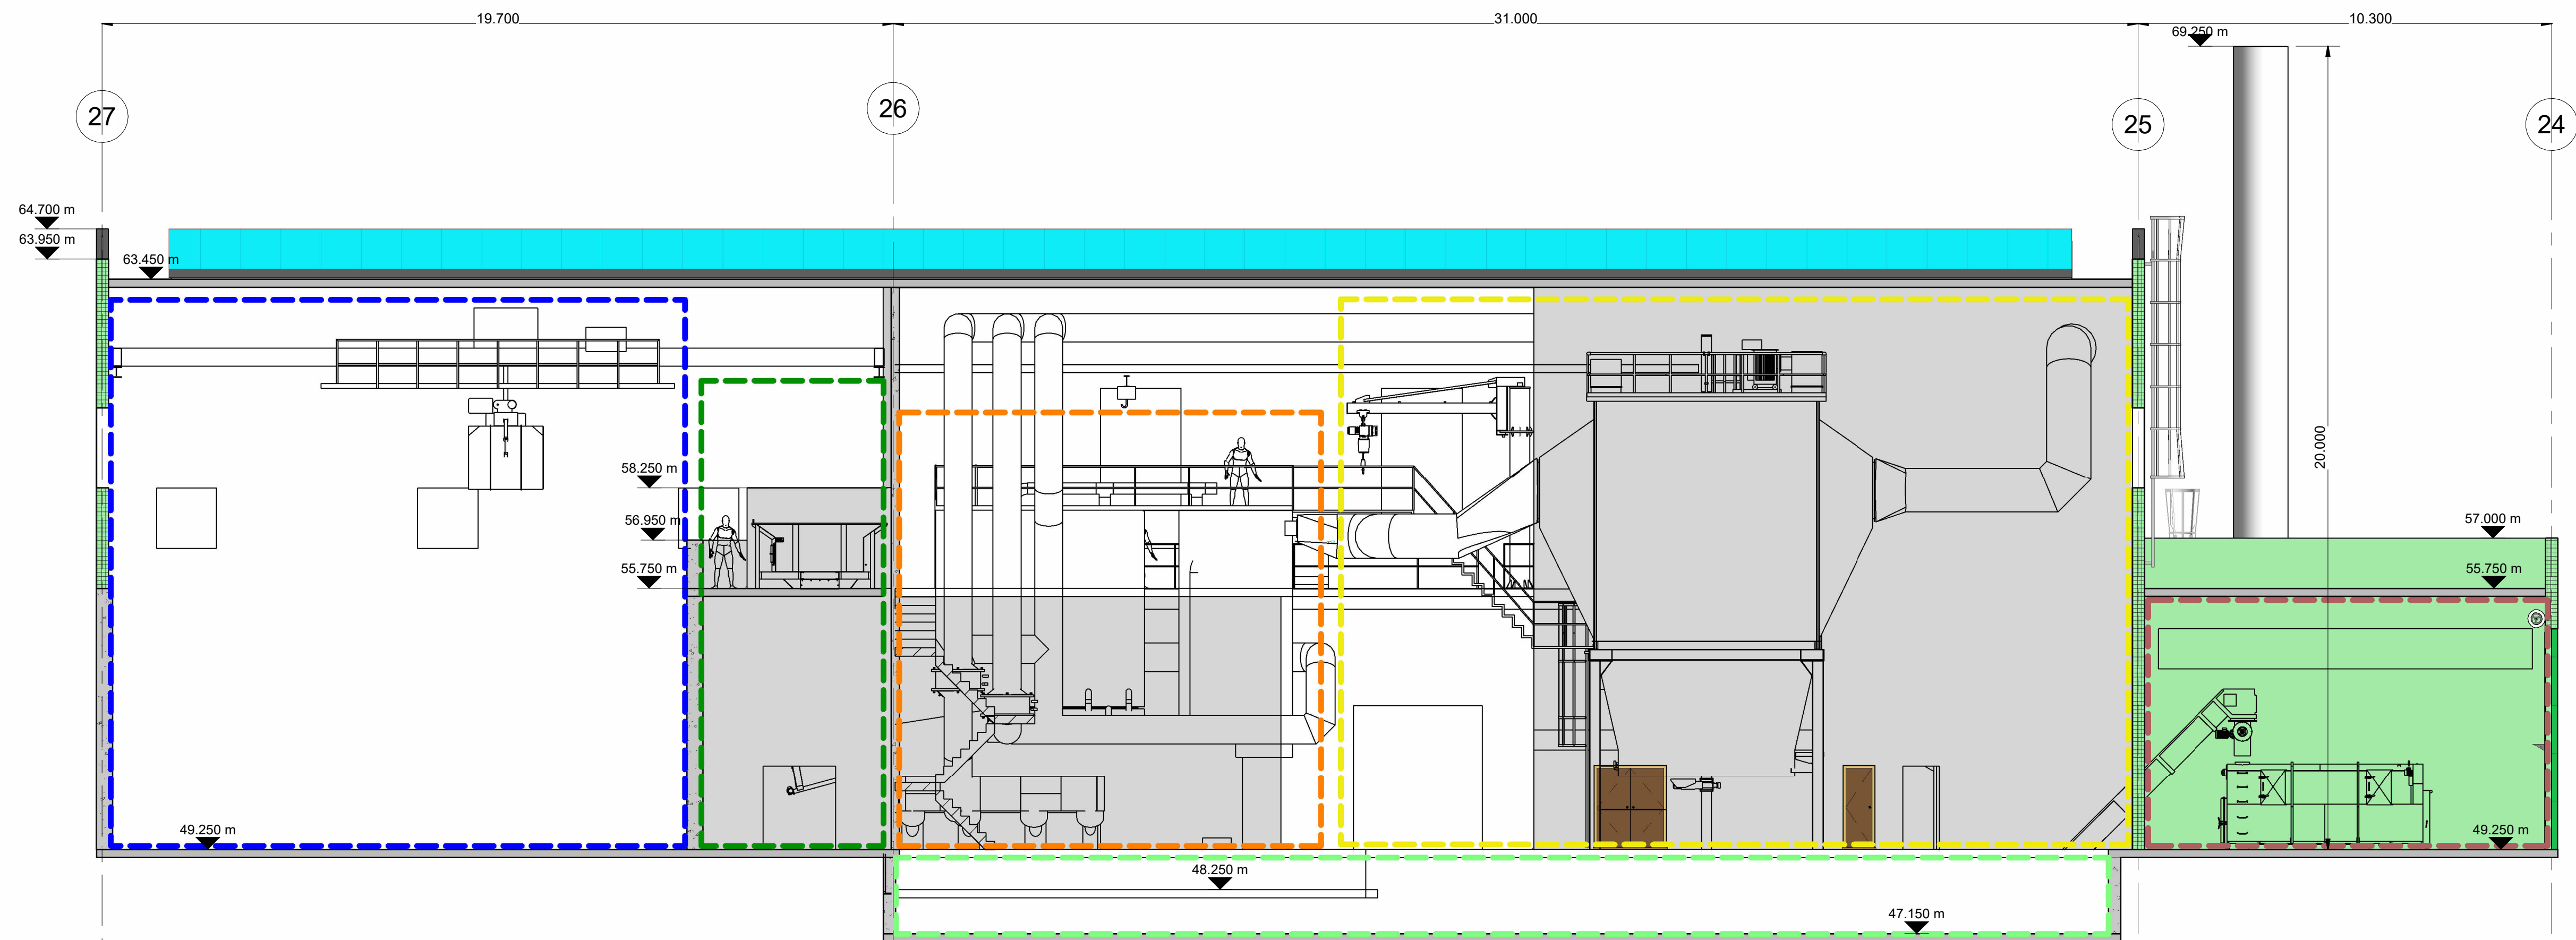

SECTION 1
Scale 1 : 100

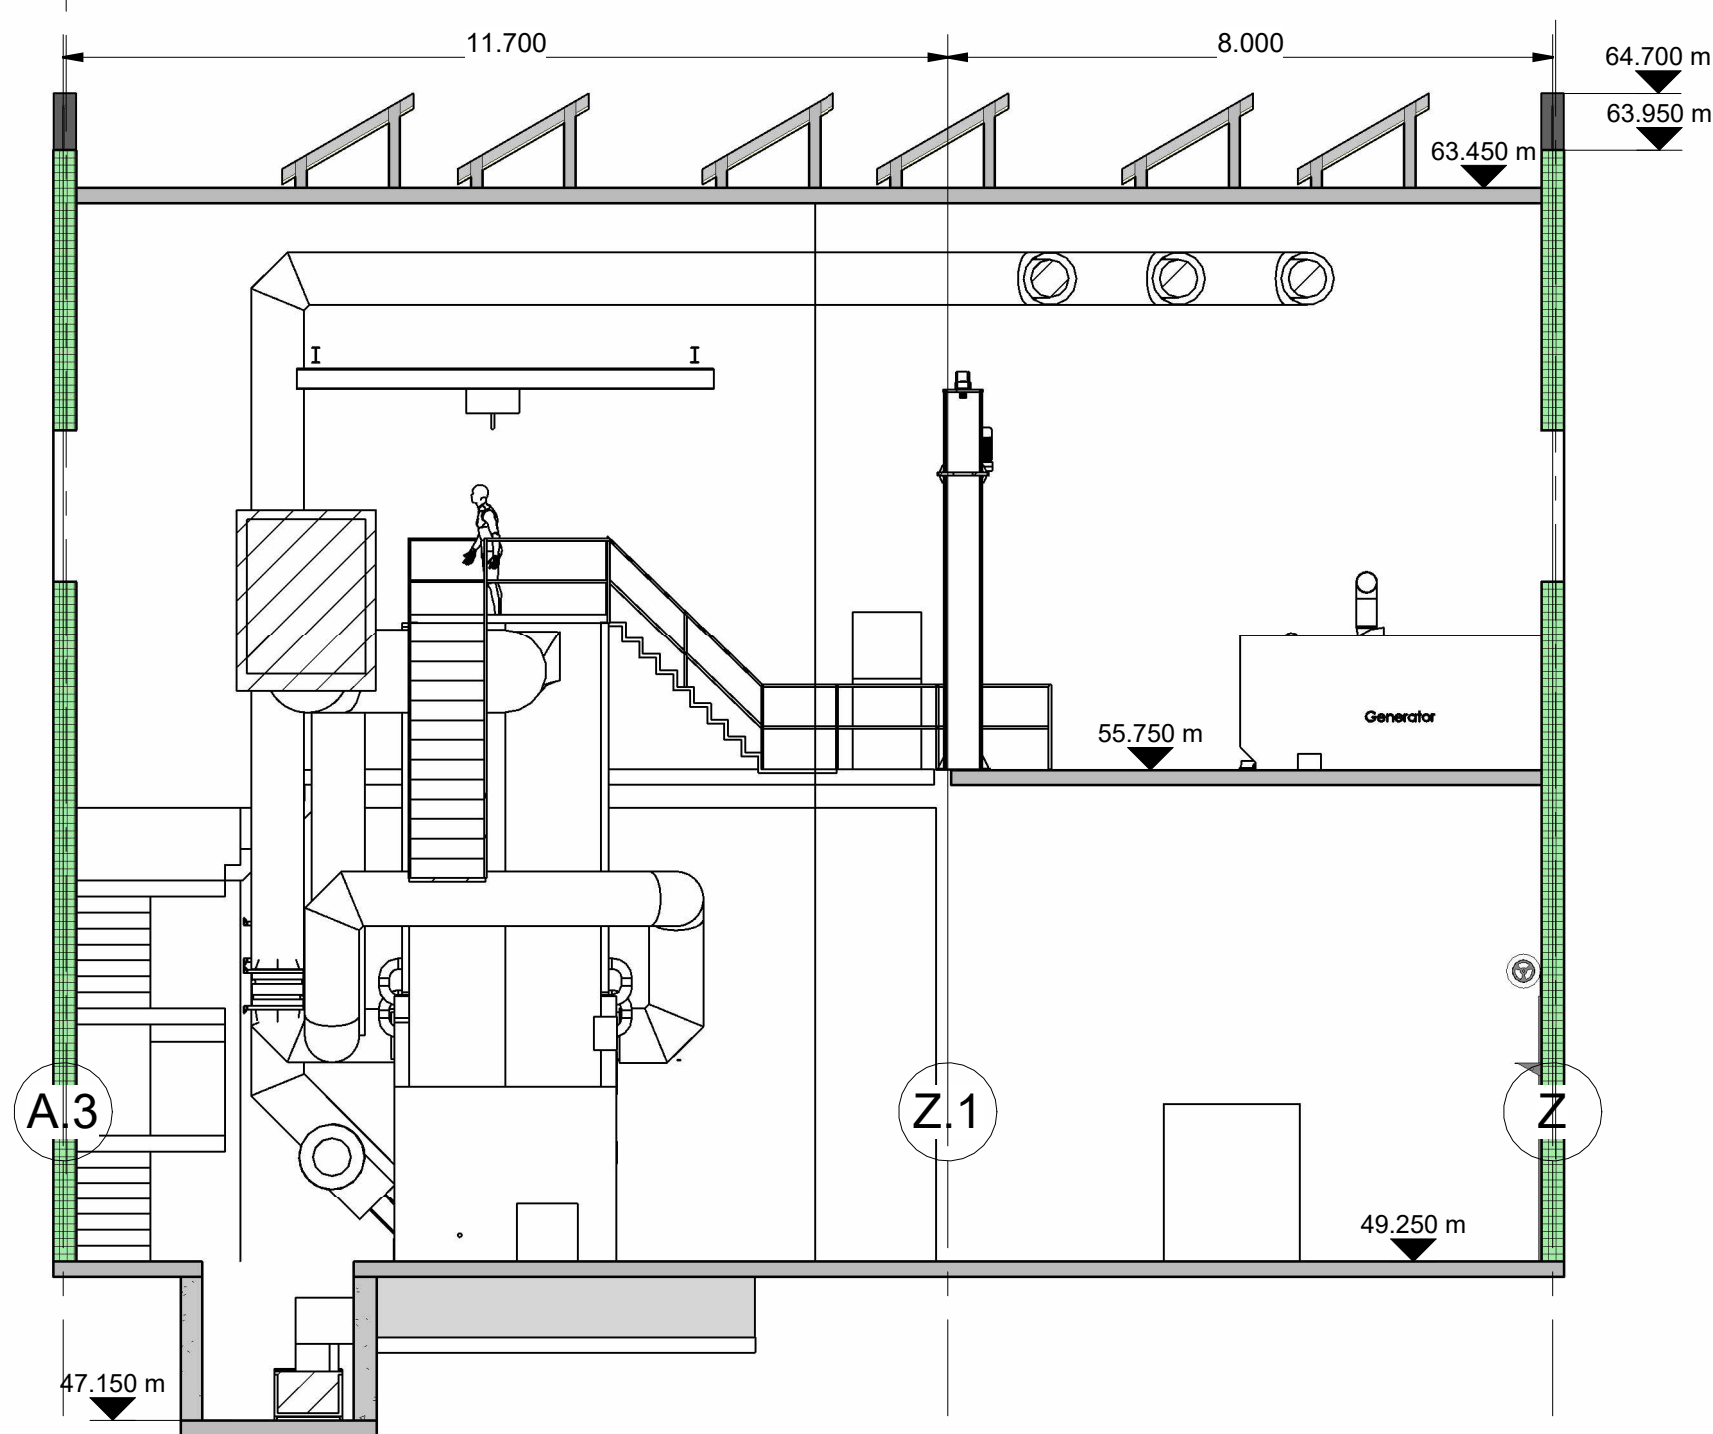

SECTION 2
Scale 1 : 100

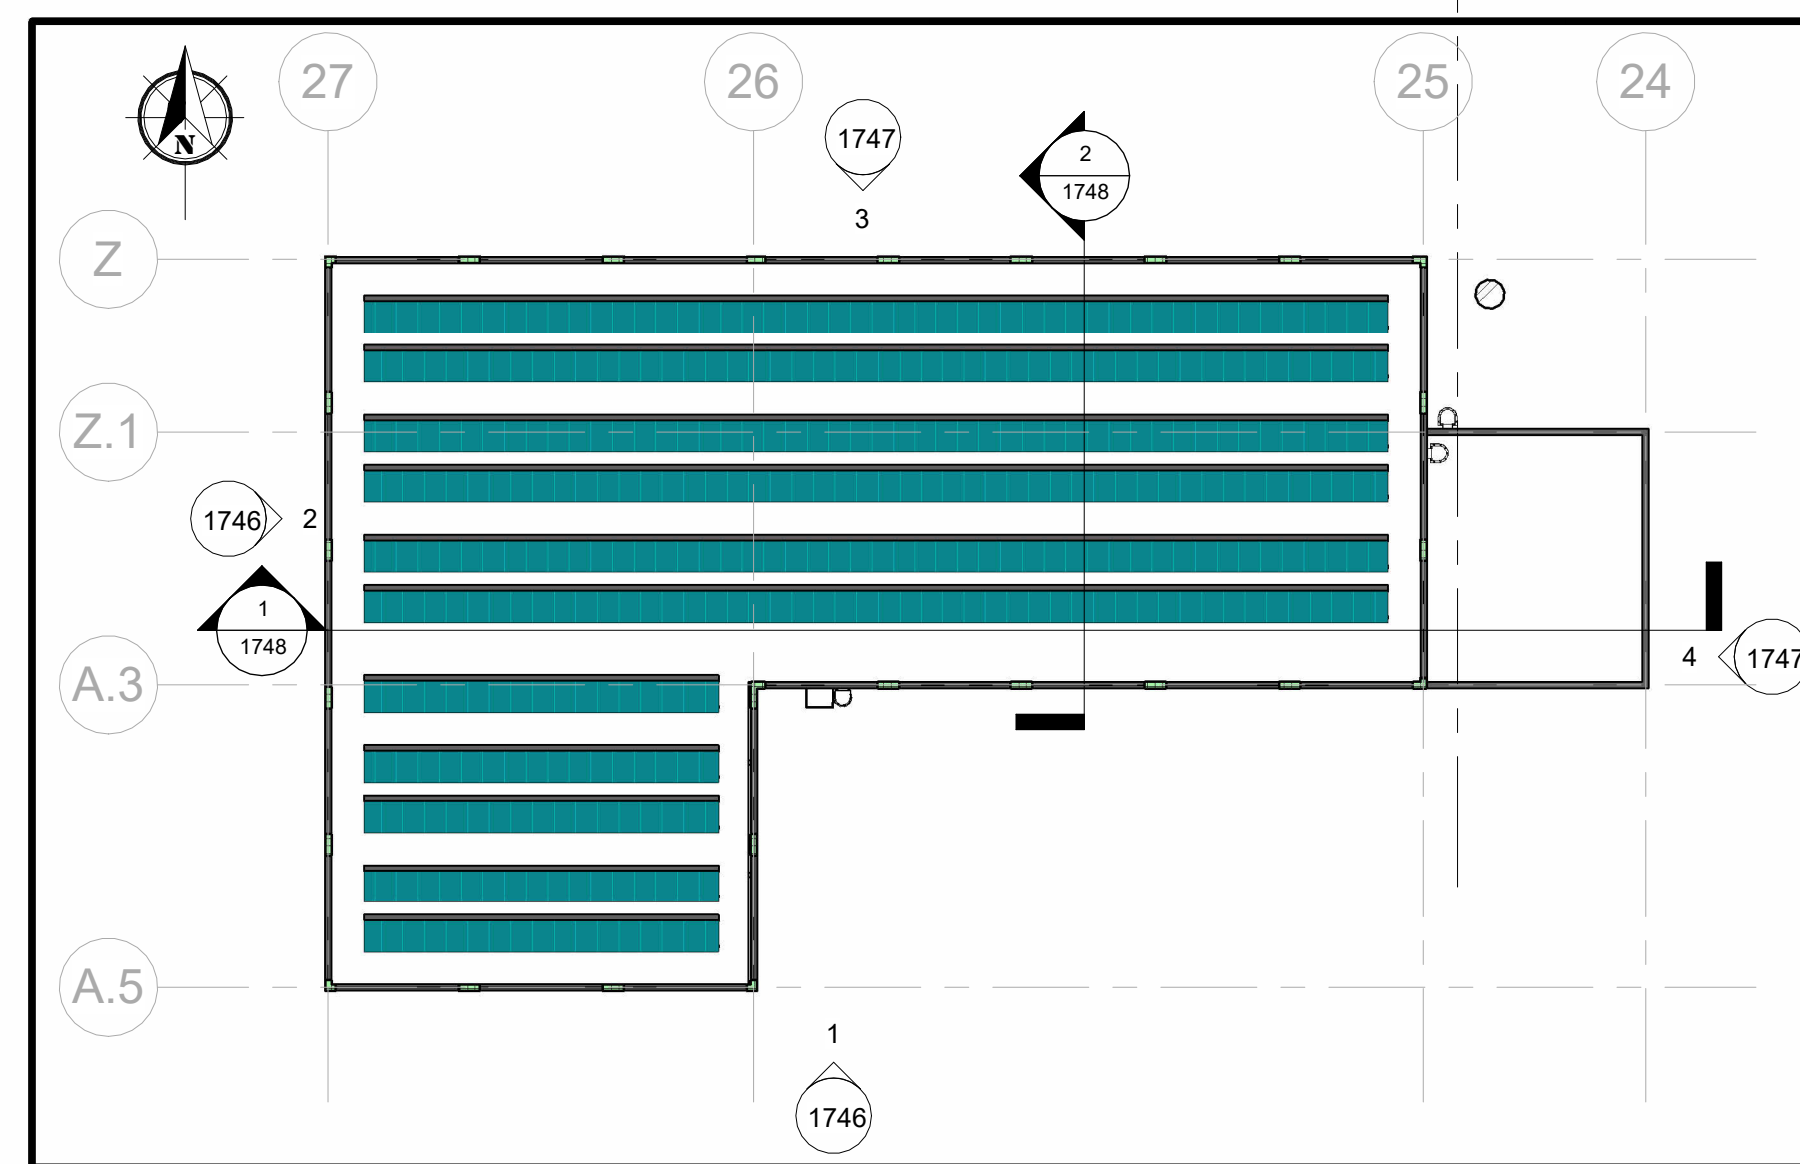

KEYPLAN
Scale 1 : 350

Legend

- Proposed RC Wall
- Proposed Kingspan Cladding
- Biomass Reception Pit
- Biomass Storage Bunker
- Biomass Infeed
- Biomass Boiler
- Exhaust Air Treatment System Filter
- Exhaust Air Treatment System Scrubber
- Exhaust Stack
- Operations, Access M&E and Welfare
- Ash Container Hall
- Ash Conveyor System

NOTES

- Drawings for planning purposes only.
- Internal Mechanical and Electrical Plant for illustrative purposes only, subject to detailed design and specification.
- Levels are relative to Malin Head Datum.

Rev.	Description	App By	Date
P01	ISSUE FOR PLANNING	JON	18.06.26

PROJECT	CLIENT			
SHEET	POWERSTOWN BIOENERGY			
	Greengate Biogas			
	Date	18.08.25	Project Number	P24188
	Drawn by	NW	Drawing Number	P24188-FT-XX-XX-DR-CE-1748
Checked by			JON	Rev P01