




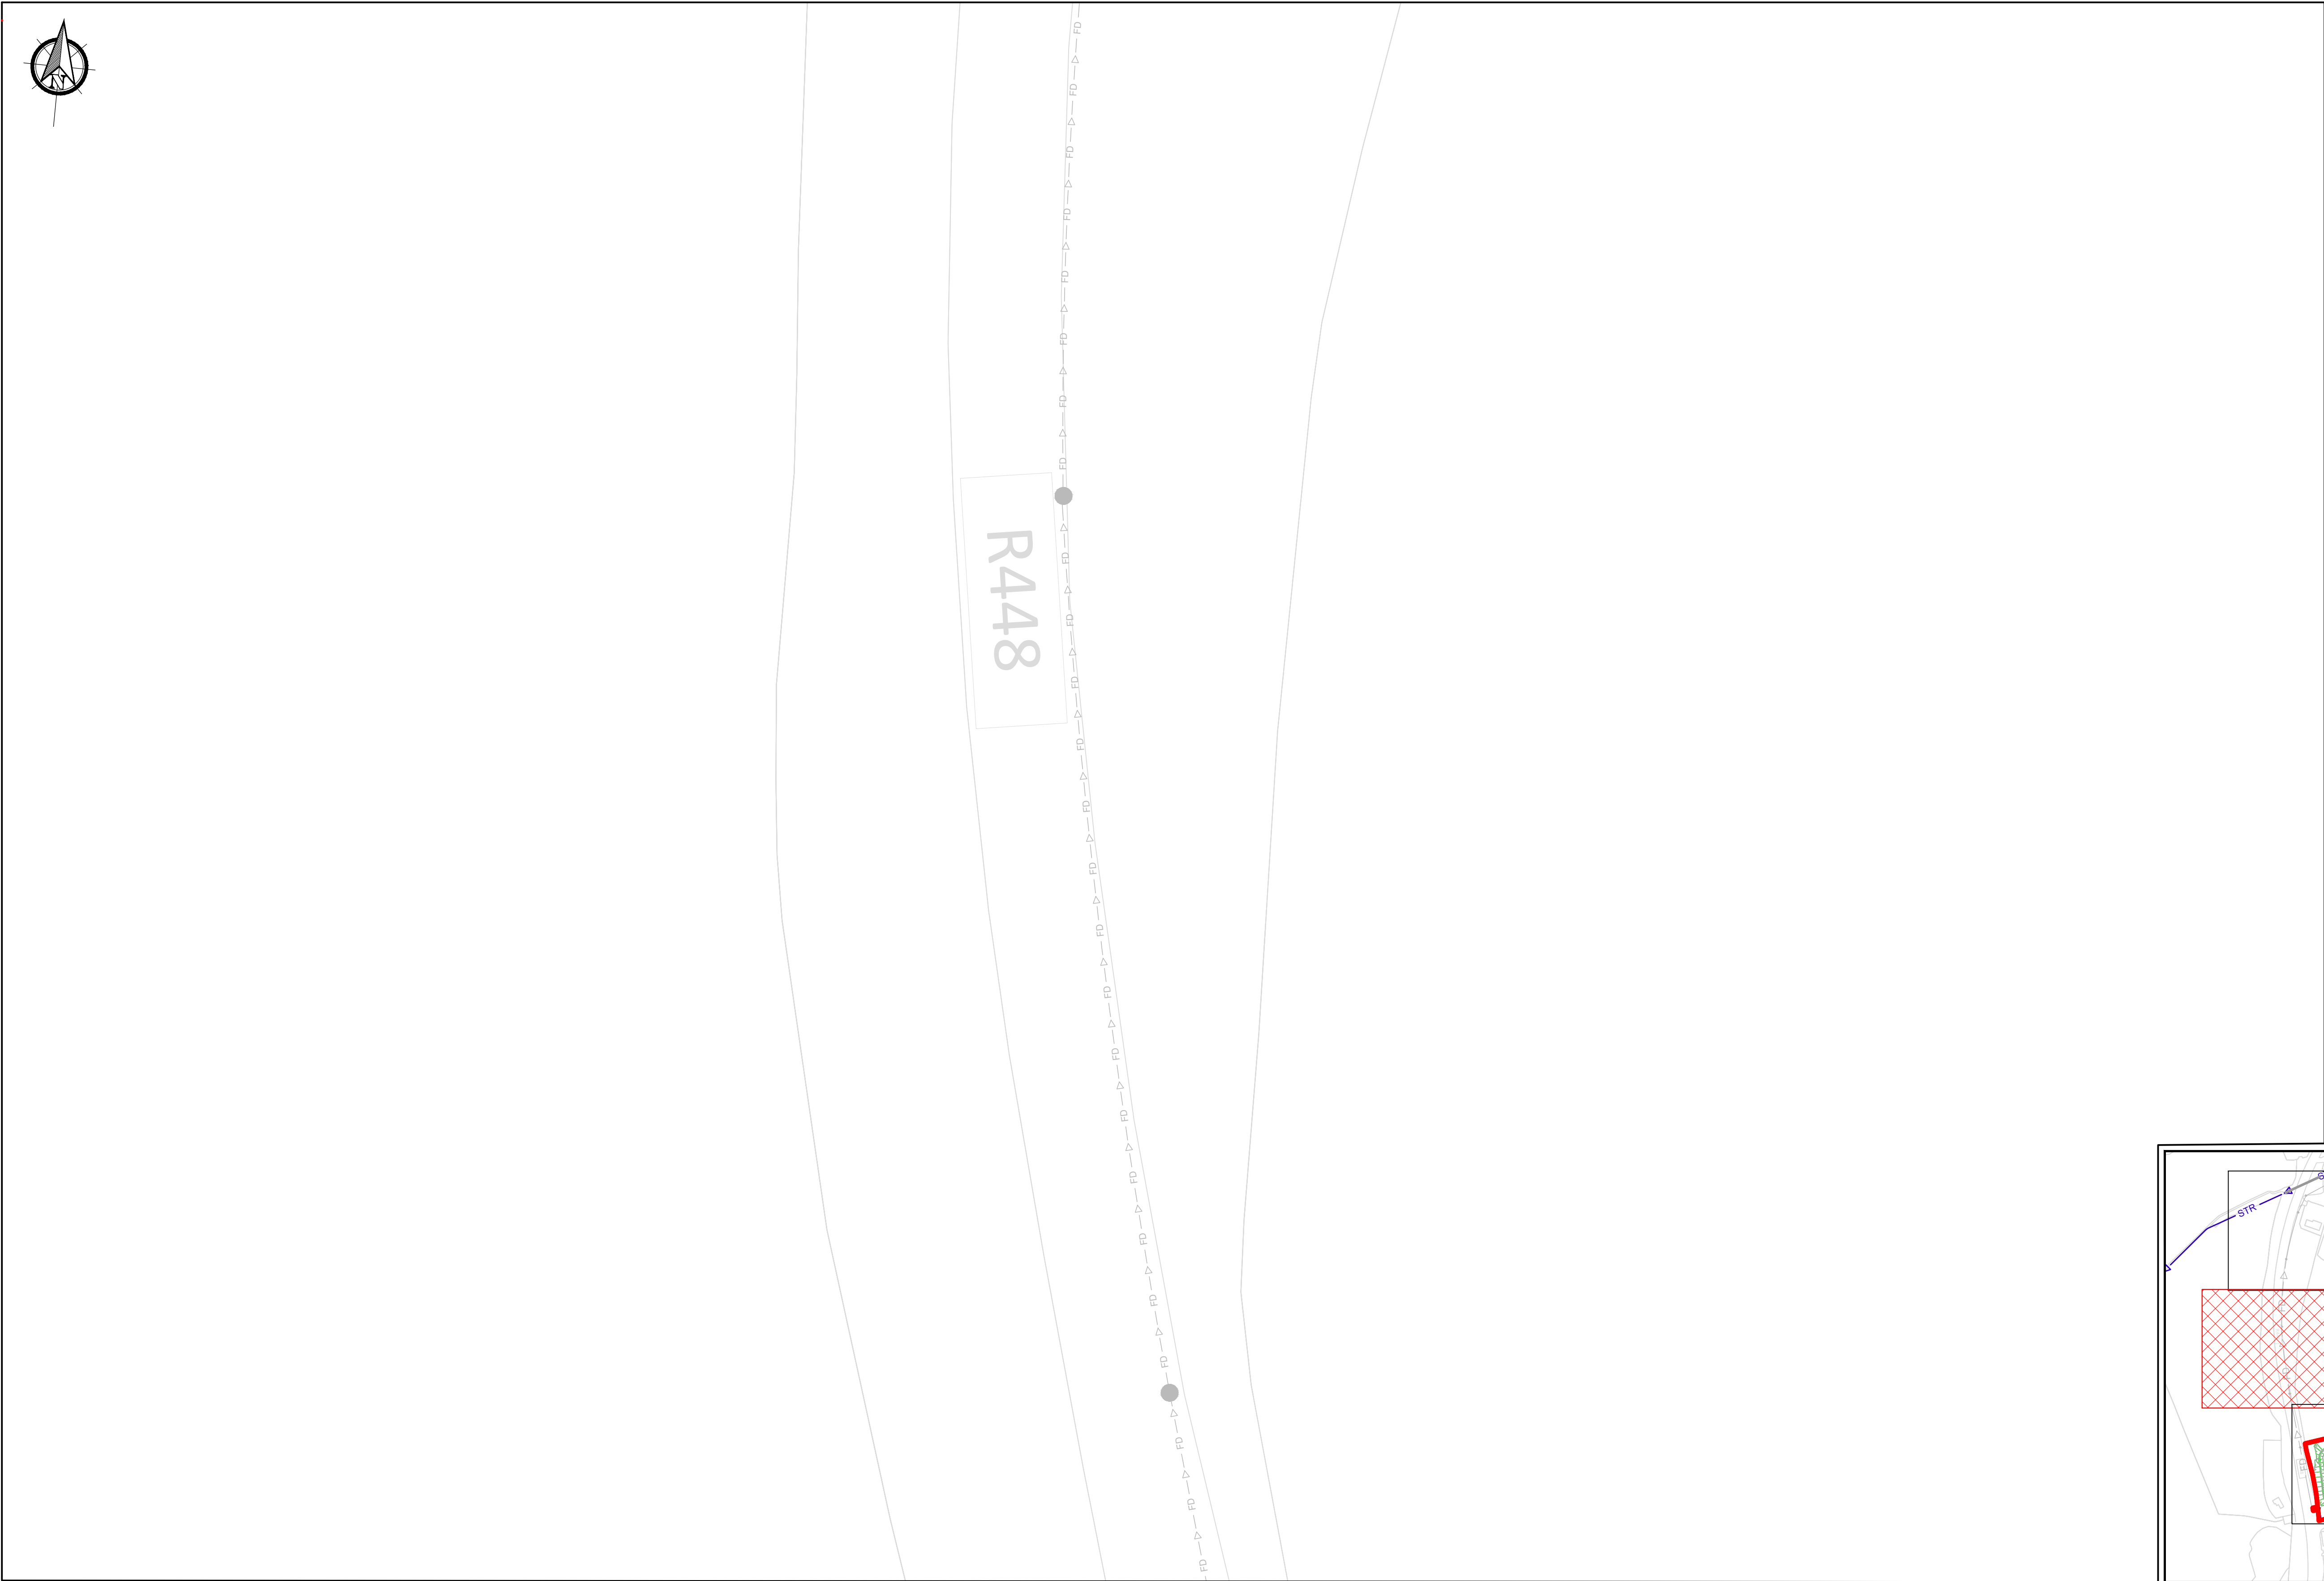

- Legend**
- Site Boundary
 - Interceptor Drains
 - Cross Drains
 - Powerstown Stream
 - Filter Drains
 - Carrier Drains
 - Linear Drainage Channel
 - Linear Drainage Outlet
 - Proposed Gully
 - Rainwater Drainage Collector
 - Rainwater Roof Drainage
 - Manhole
 - Process Water Rising Mains
 - Stormwater Lagoon Rising Mains
 - Rising Mains between Tank Bund to Stormwater Lagoon (both directions)
 - Valve
 - Pump
 - Petrol/Oil Interceptor
 - Foul Water Network
 - Foul Water Tank
 - Existing Filter Drain (Indicative)
 - Existing Carrier Drain (Indicative)
 - Existing Manhole (Indicative)
 - Infiltration Areas
 - Yard & Circulation Areas

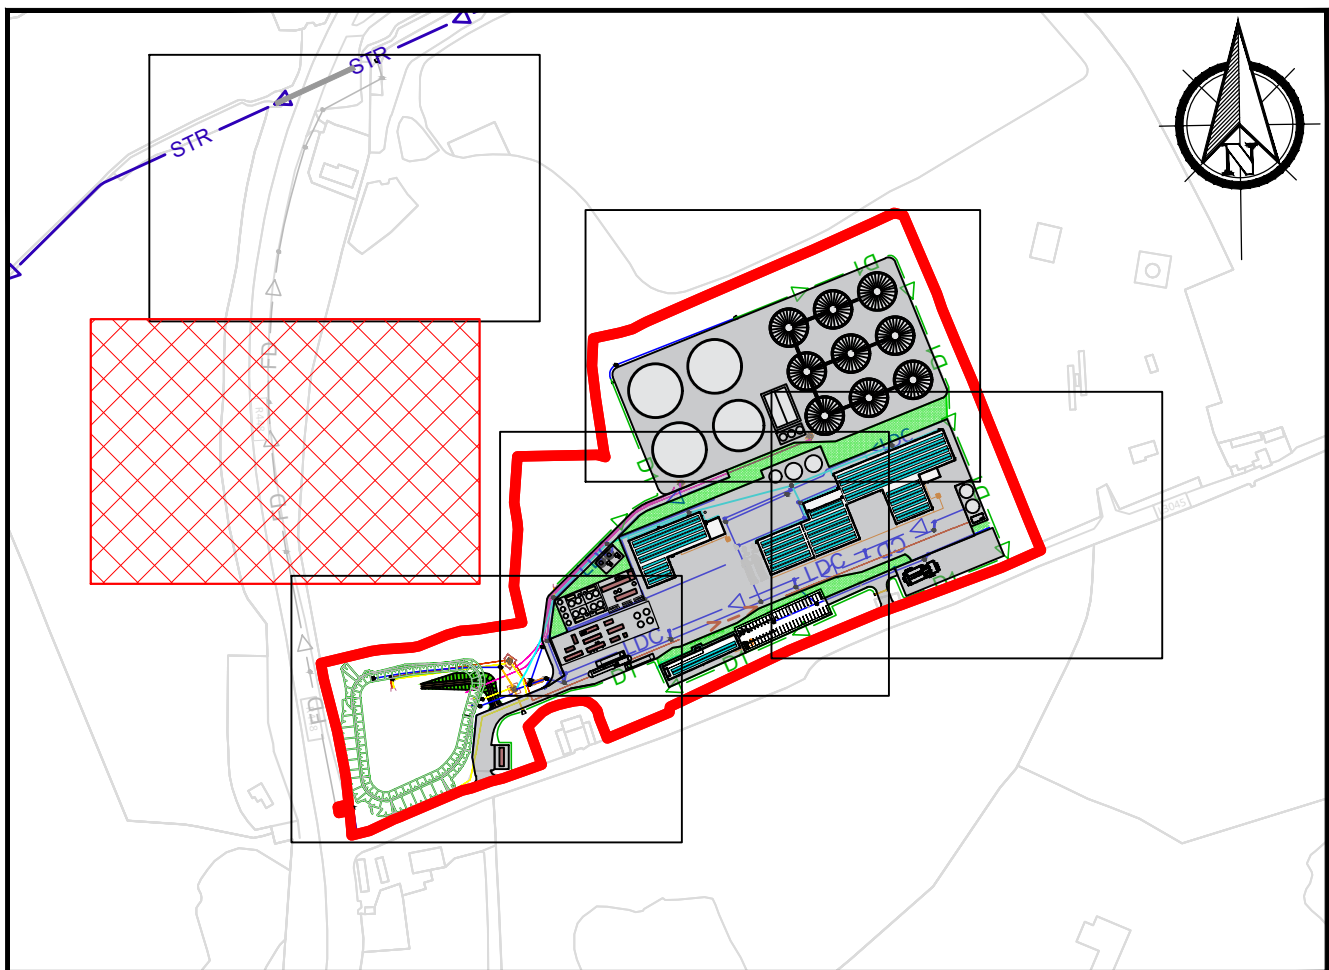

PLAN
1:375
0001

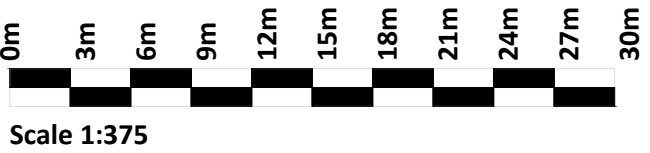

KEY PLAN
1:5000
0002

If Applicable : Tailte Éireann Licence No. CYAL50368274 © Ordnance Survey Ireland and Government of Ireland 4531-B



Cork | Dublin | Carlow

www.fehilytimoney.ie

No part of this document may be reproduced or transmitted in any form or stored in any retrieval system of any nature without the written permission of Fehily Timoney & Company as copyright holder except as agreed for use on the project for which the document was originally issued. Do not scale. Use figured dimensions only. If in doubt - Ask!

Rev.	Description	App By	Date
P01	ISSUE FOR PLANNING	JON	24.06.26

PROJECT		CLIENT						
POWERSTOWN BIOENERGY								
SHEET	PROPOSED SITE DRAINAGE PLAN - SHEET 2 OF 6 -		Date	24.06.26	Project number	P24-188	Scale (@ A1)	Rev
					Drawn by	EB	Drawing Number	
					Checked by	JON	P24188-FT-XX-XX-DR-CE-0502	
				(Sheet not subject to DCD)		P01		

O:\ACAD\2024\P24-188\P24188-FT-XX-XX-DR-CE-0502

24 June 2026 (O:\ACAD\2024\P24-188\P24188-FT-XX-XX-DR-CE-0502)