



ISO A1 594mm x 841mm


Project Management Initials: Designer: LP Checked: ER Approved: AC

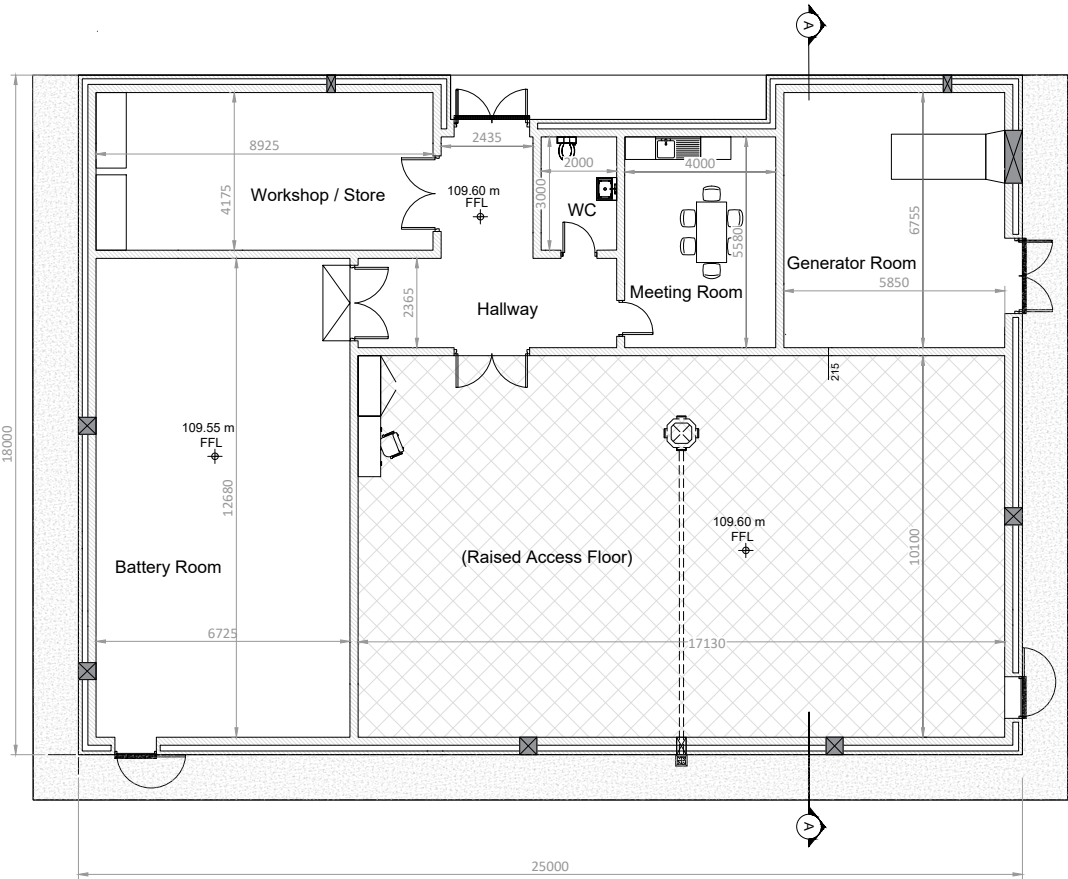


PLAN - CONTROL BUILDING
Scale : 1:100

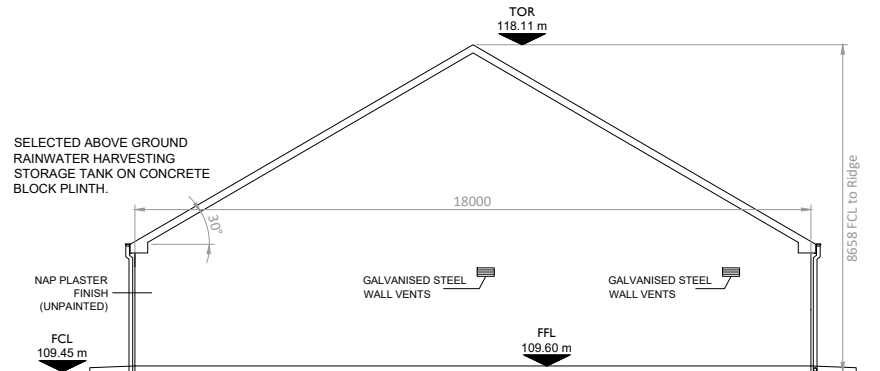


LEFT SIDE ELEVATION
Scale : 1:100

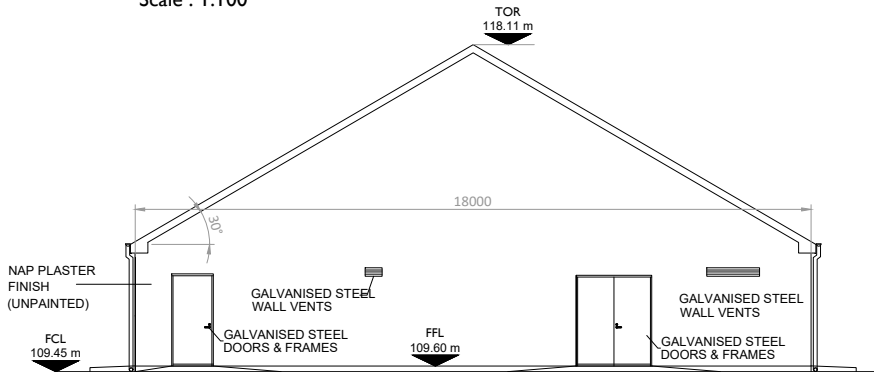


RIGHT SIDE ELEVATION
Scale : 1:100

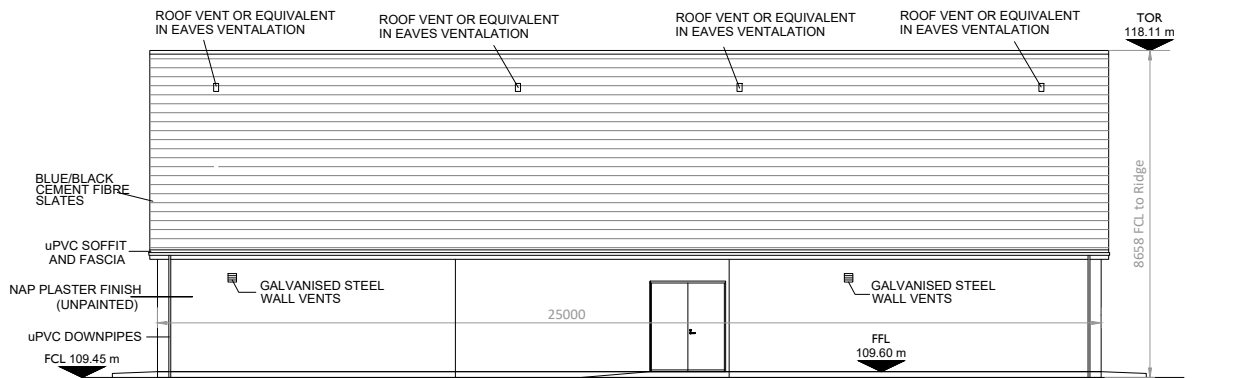

FRONT ELEVATION
Scale : 1:100

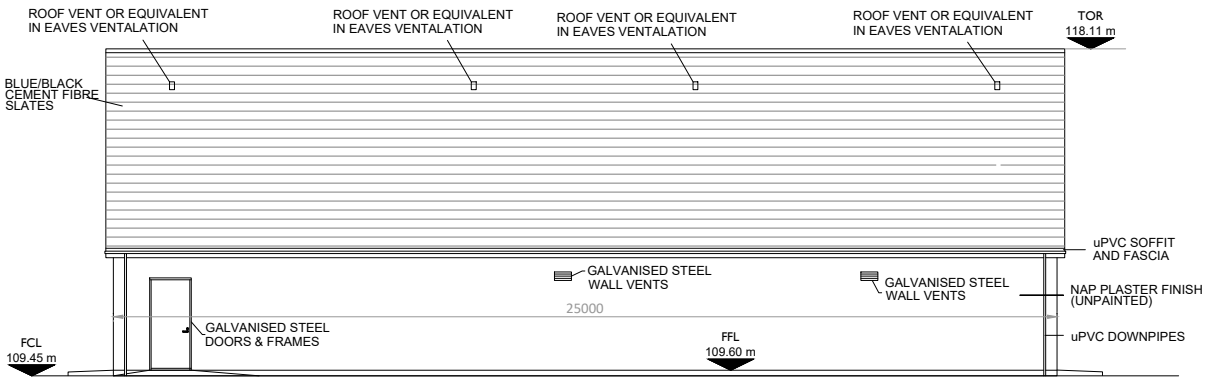

REAR ELEVATION
Scale : 1:100

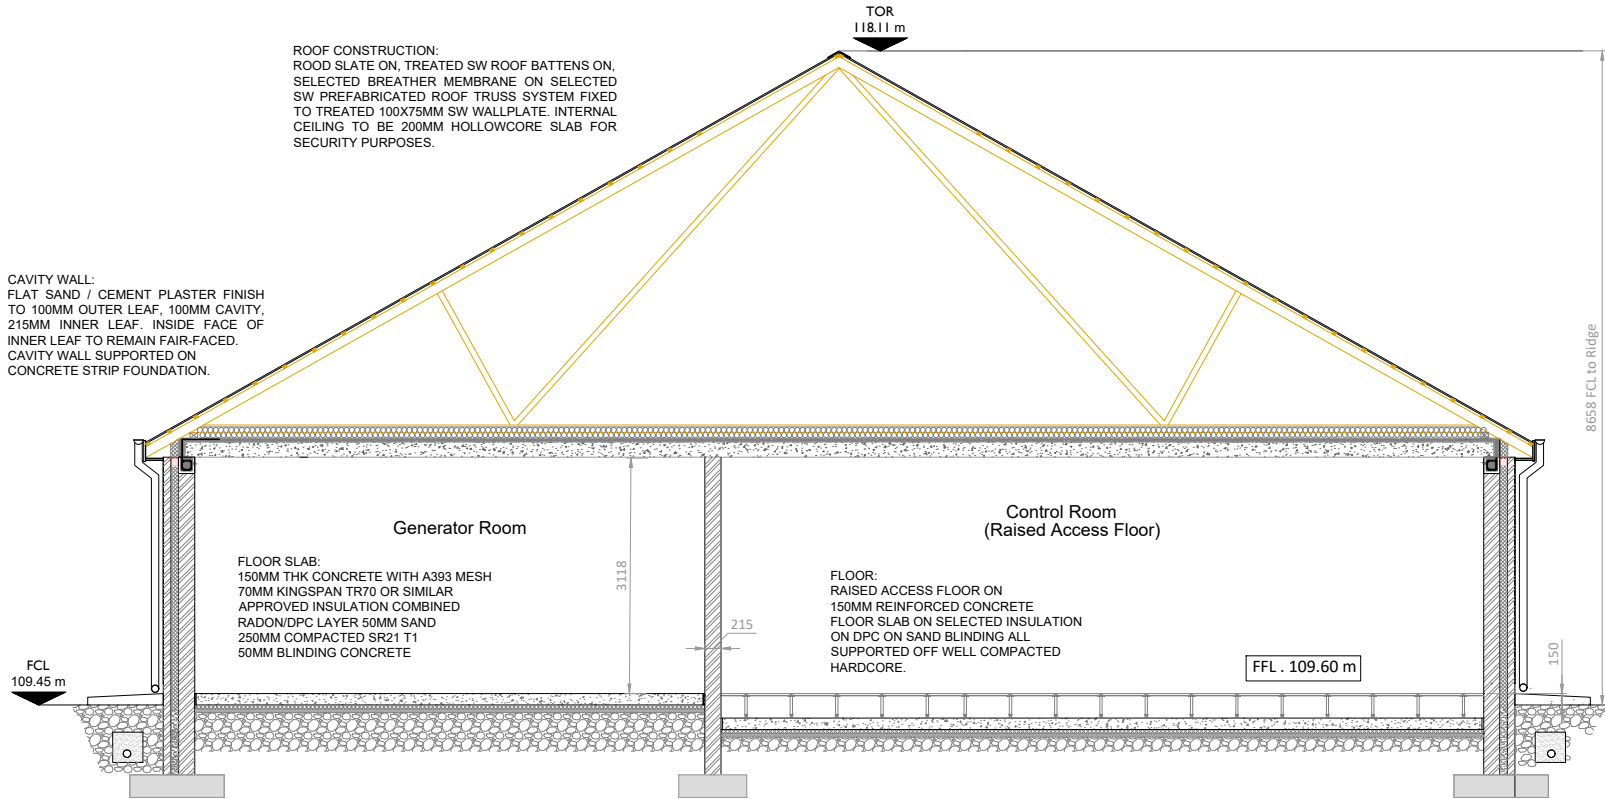

SECTION A-A
Scale : 1:50



Head Office
Beenleigh,
Abbeydorney,
Tralee, Co. Kerry
Ireland
Tel: 00353 66 7135710

Regional Office
Basepoint Business Centre
Stroudley Road, Basingstoke,
Hampshire,
RG24 8UP, UK
Tel: 00 44 1256406664

PROJECT

Greenhills Renewable Energy Park 220 kV Substation

CLIENT



CONSULTANTS

- NOTES: -
- Layout and Arrangements of Substation Building and Electrical Equipment is shown indicatively and for illustration purposes only.
 - Dimensions shown are as per current EirGrid Specifications at the time of submission. Dimensions may vary at time of construction to reflect any revisions to EirGrid Specifications.
 - Final Specifications of Buildings and Electrical Equipment is to be as per Eirgrid and ESB Specifications.
 - The Elevation of the Compound will be depicted by localized Topography such that Cut/Fill Earthworks associated with the construction of the Compound are balanced.

LEGEND: -

Final Compound Level	FCL 109.45 m
Final Floor Level	FFL 109.60 m
Top of Roof	TOR 118.11 m
Concrete Footpath	

ISSUE/REVISION		
P2	02.06.2026	Issued for Planning
I/R	DATE	DESCRIPTION

PROJECT NUMBER
300-101185

SHEET TITLE
Control Building - Plan, Elevations
& Section

SHEET NUMBER
300101185-DR-207