



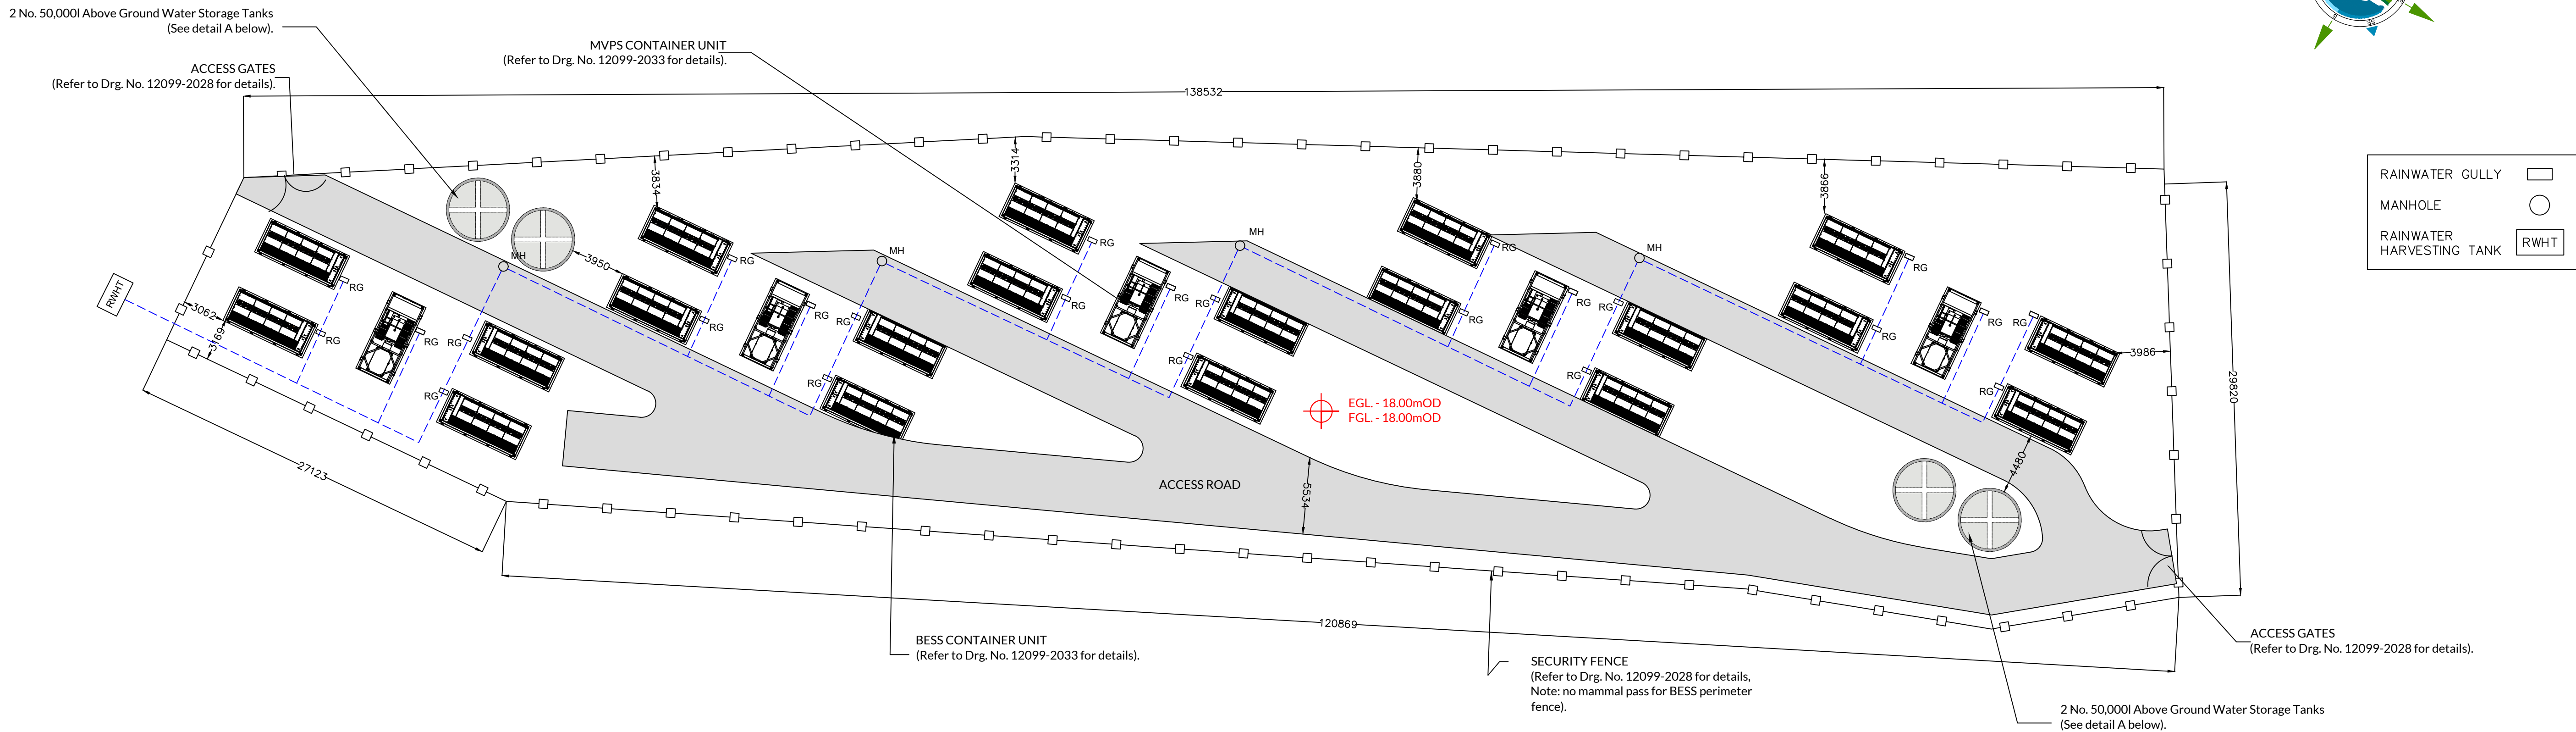

A	20.05.26	PLANNING	JR	DH
Rev	Date	Description	By	Chkd.

Client:

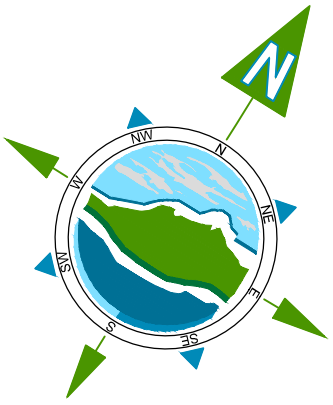

Project:

BALLYCUNNEEN SOLAR FARM
PLANNING APPLICATION

Title:

BATTERY ENERGY STORAGE SYSTEM
DRAINAGE LAYOUT

Scale @ A1:

1:250

Prepared by:

Checked by:

Date:

J. Ryan

D. Hobbs

May 2026

Drawing Status:

Planning





Tel: +353 (0)91 565 211
Email: info@tobin.ie
www.tobin.ie

TOBIN will not be liable for any use of this document for any purpose other than that for which it was originally prepared and provided.
Design where used/fully and explicitly stated is written by TOBIN, its copyright holder, as part of this document may be reproduced or
transmitted in any form and this document shall not be relied upon by any third party for any purpose.

Drawing No.:

Revision:

12099-2049

B

DETAIL A - ABOVE GROUND WATER STORAGE TANKS
Scale 1:50