



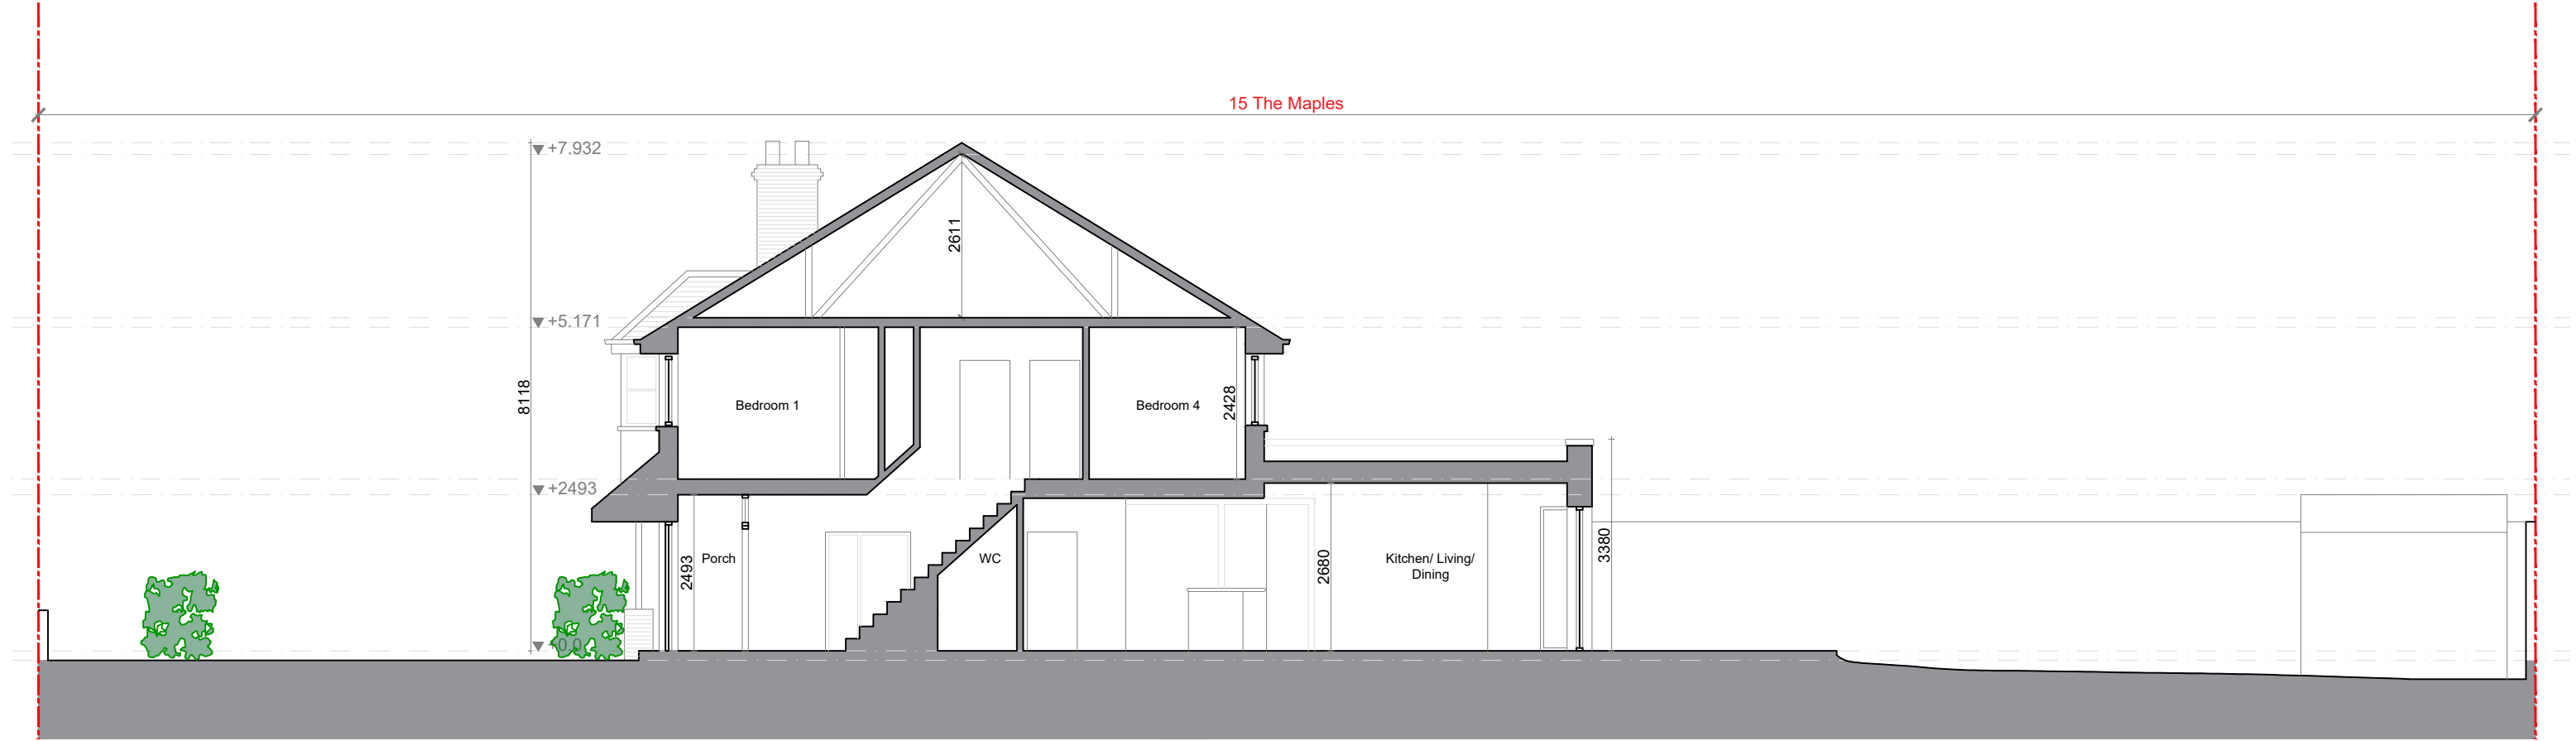

Existing Section AA

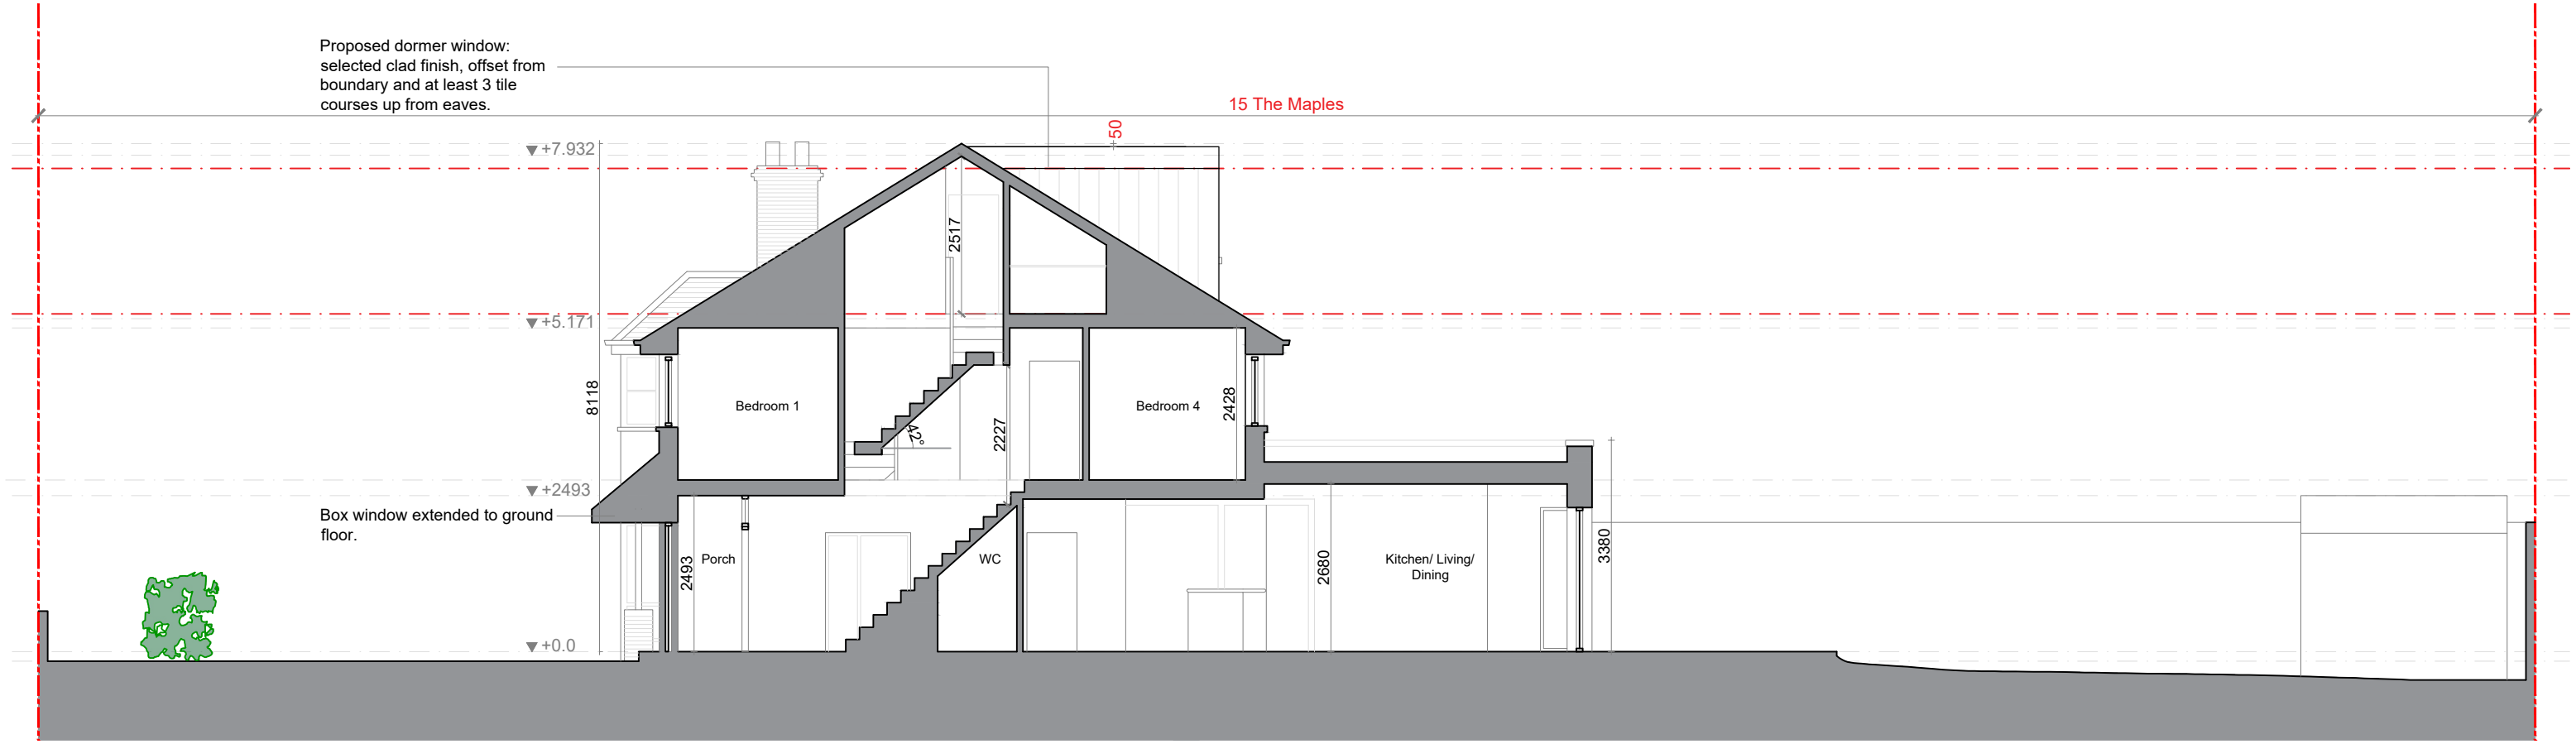

Proposed Section AA

- NOTES:
1. Copyright reserved.
  2. All dimensions to be checked on site by main contractor prior to construction.
  3. Main contractor responsible for set-out.
  4. Do not scale drawing. Use figured dimensions only.
  5. All discrepancies to be reported to FHA consultants immediately.
  6. All drawings to be read in conjunction with Structural Engineers & Mechanical Engineers drawings and specification.
  7. Refer to Civil Engineers drawings for all external drainage layouts.
  8. Refer to M&E drawings for all internal drainage layouts.

APPEAL

Legend

Existing Structure  
Demolition  
Site Boundary  
Proposed Development Area

—  
- - -  
—  
—

FHA  
ARCHITECTURE & DESIGN

The Masonry Iconic Offices, 151 Thomas St.  
The Liberties, Dublin 8, D08PYSE  
e: info@fha.ie w: www.fha.ie

|                |         |                                   |        |             |         |  |
|----------------|---------|-----------------------------------|--------|-------------|---------|--|
| DWG NO:        |         | 26121-FHA-ACP-3000                |        |             |         |  |
| PROJECT TITLE: |         | 15 The Maples                     |        |             |         |  |
| DRAWING NAME:  |         | Existing & Proposed Section A-A   |        |             |         |  |
| CLIENT:        |         | Kate O Donohoe + Cillian McCarthy |        |             |         |  |
| JOB NO:        | STATUS: | REV:                              | SCALE: | ORIGINATOR: | DATE:   |  |
| 26121          | S02     | 00                                | 1:100  | KK          | May 26' |  |