



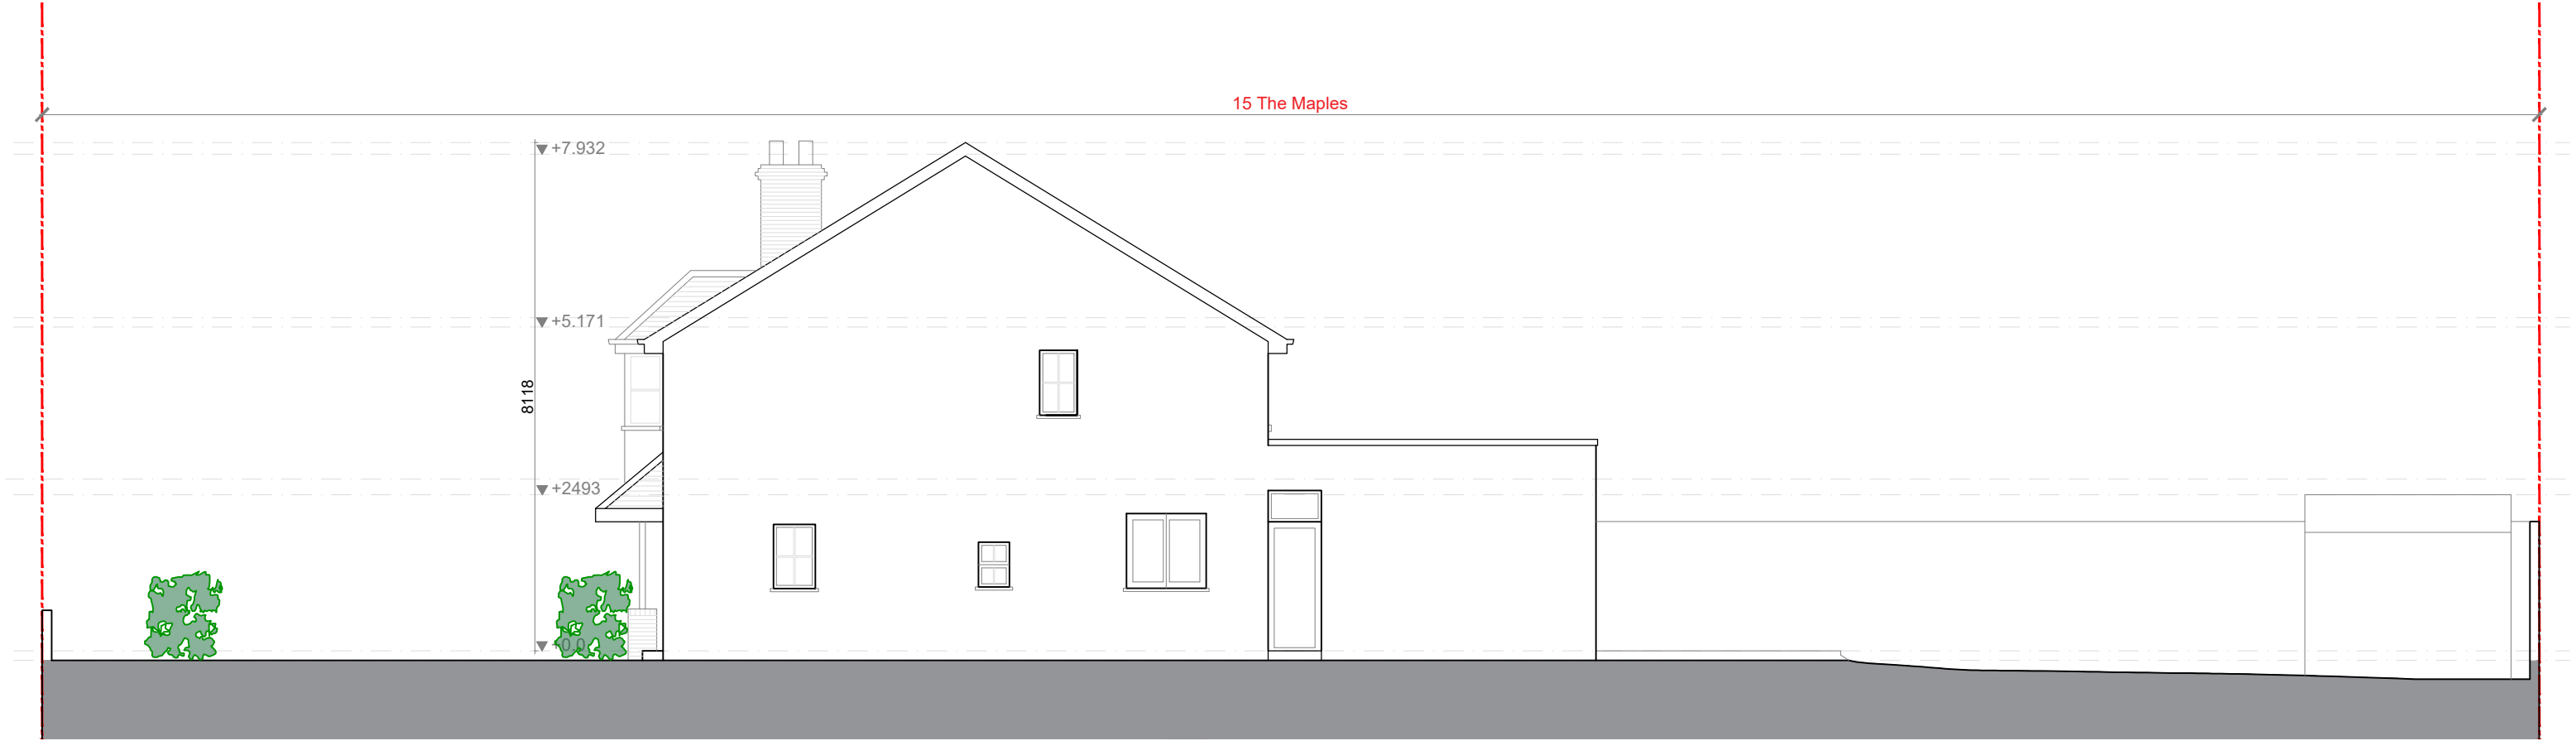

Existing North Elevation

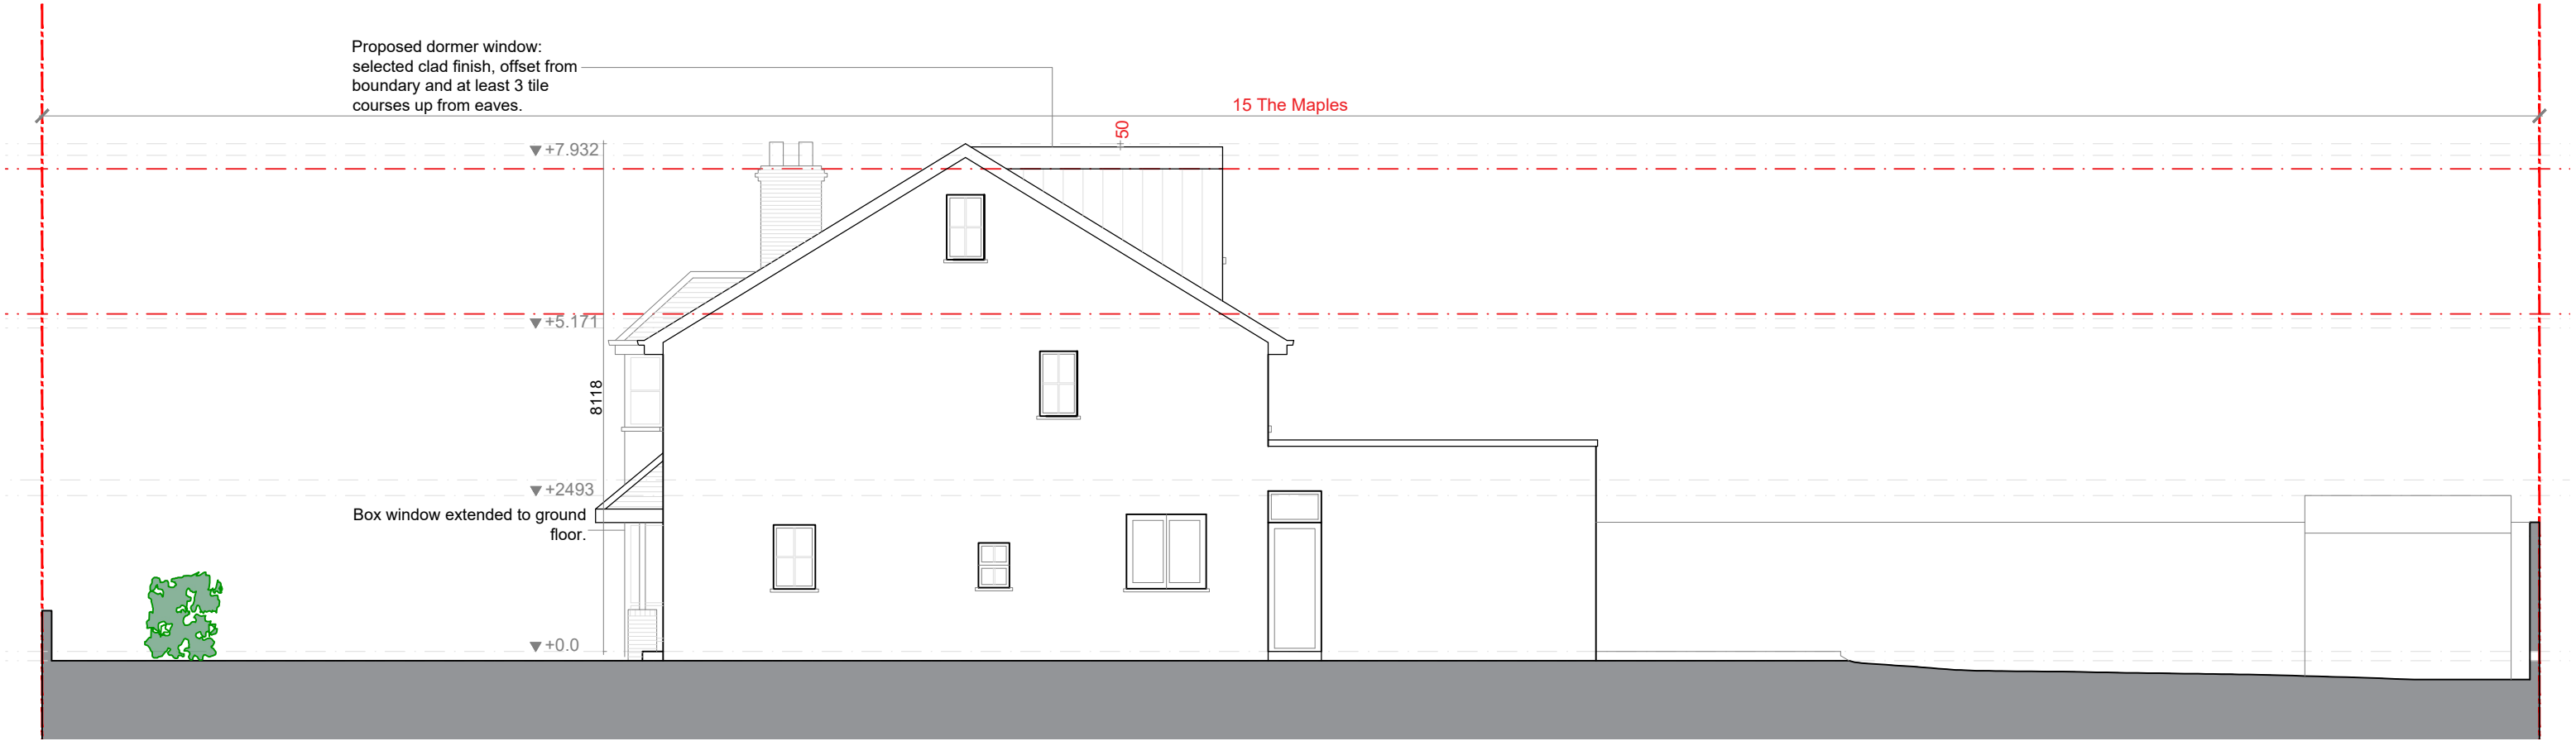

Proposed North Elevation

NOTES:

- Copyright reserved.
- All dimensions to be checked on site by main contractor prior to construction.
- Main contractor responsible for set-out.
- Do not scale drawing. Use figured dimensions only.
- All discrepancies to be reported to FHA consultants immediately.
- All drawings to be read in conjunction with Structural Engineers & Mechanical Engineers drawings and specification.
- Refer to Civil Engineers drawings for all external drainage layouts.
- Refer to M&E drawings for all internal drainage layouts.

APPEAL

Legend

Boundary Line

Existing Structure

FHA

ARCHITECTURE & DESIGN

The Masonry Iconic Offices, 151 Thomas St.
The Liberties, Dublin 8, D08PYSE
e: info@fha.ie w: www.fha.ie

DWG NO:		26121-FHA-ACP-4001				
PROJECT TITLE:		15 The Maples				
DRAWING NAME:		Existing & Proposed North Elevation				
CLIENT:		Kate O Donohoe + Cillian McCarthy				
JOB NO:	STATUS:	REV:	SCALE:	ORIGINATOR:	DATE:	
26121	S02	00	1:100	KK	May 26'	