


Appendix A.15.1

NUIG Sports Facilities Mitigation Proposals

A.15.1

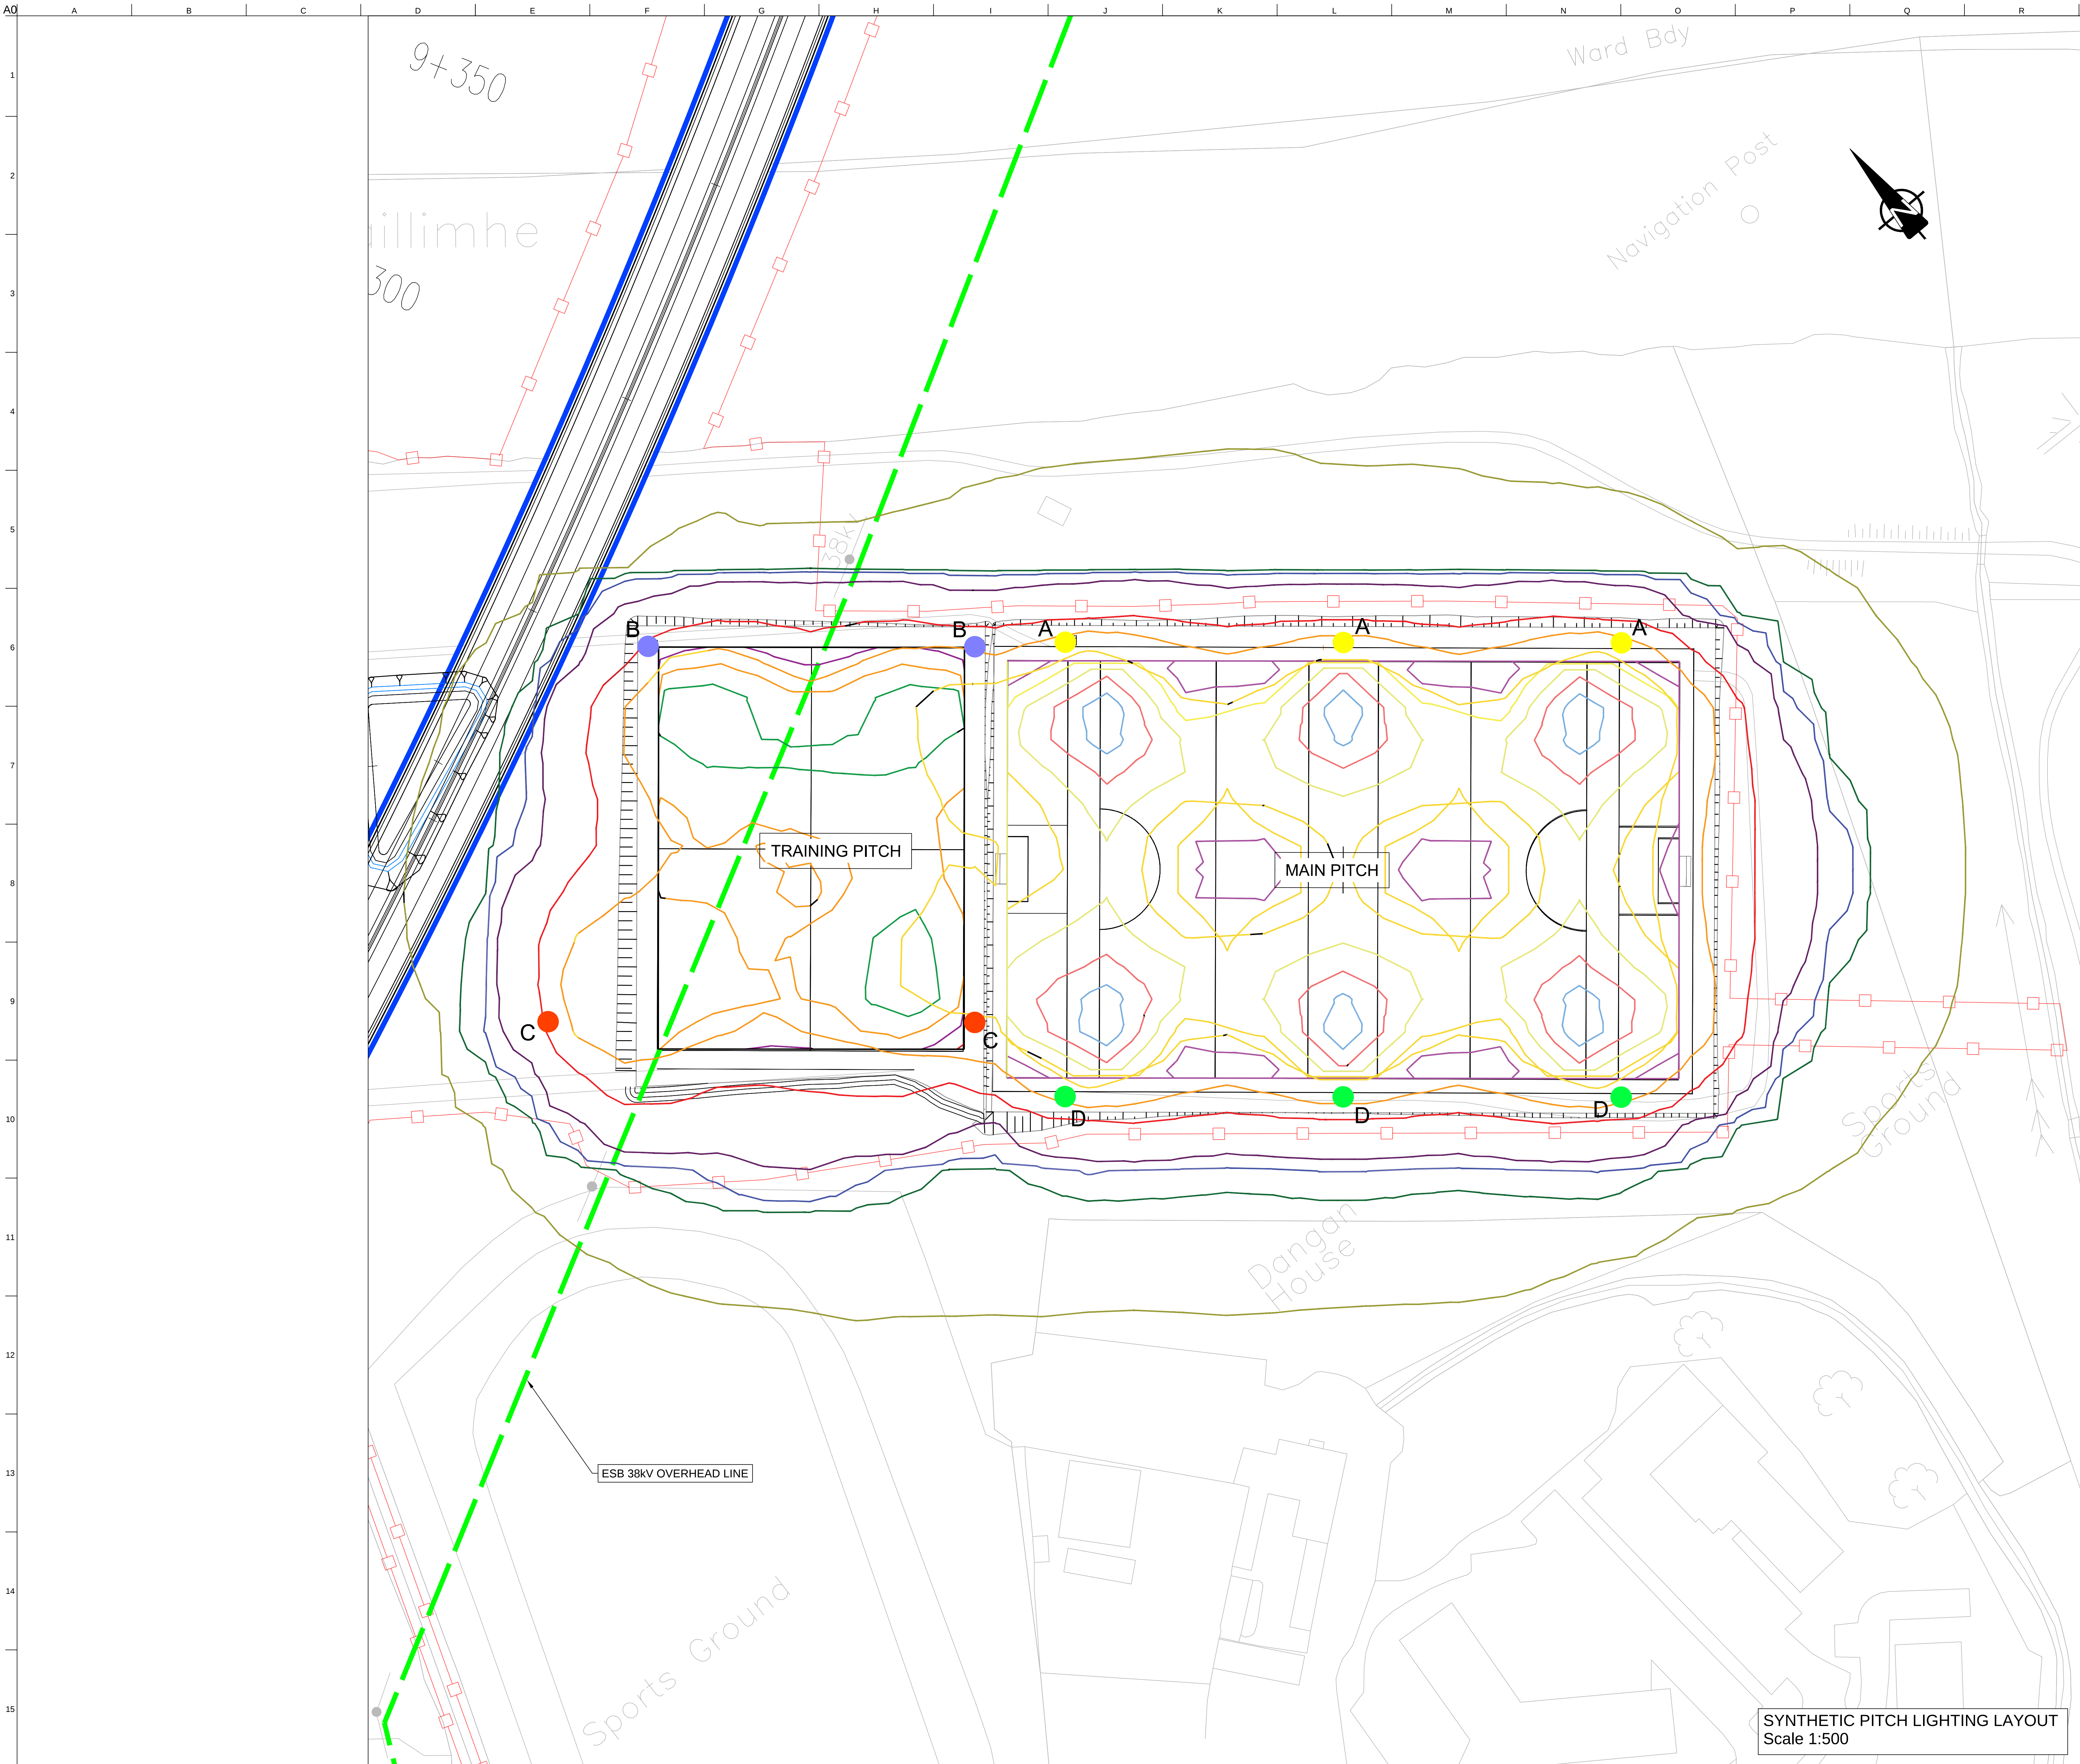

SYNTHETIC PITCH LIGHTING LAYOUT
Scale 1:500

FOR INFORMATION

Legend:

- Proposed Development Boundary
- Proposed Road Development
- Proposed Attenuation Pond / Infiltration Basin/ Wetlands
- Structure

Light Spill Isolines

- 1 lux
- 5 lux
- 10 lux
- 25 lux
- 50 lux
- 100 lux
- 150 lux
- 200 lux
- 250 lux
- 300 lux
- 350 lux
- 400 lux
- 450 lux
- 500 lux

Luminaries

- 18m lighting columns c/w 8No. LED luminaires with asymmetric wide beam, glare prevention louvers and custom hood, Type A
- 18m lighting columns c/w 4No. LED luminaires with asymmetric wide beam, glare prevention louvers and custom hood, Type B
- 18m lighting columns c/w 4No. LED luminaires with asymmetric wide beam, glare prevention louvers, Type C
- 18m lighting columns c/w 8No. LED luminaires with asymmetric wide beam, glare prevention louvers, Type D

Sua áiríonnadh tá sonraíocht Shaothairíochtaí Ordánáil Éireann arís aistriúcháil fíon Chéadlínas OSI (fíon, 2010) / SCMA / Comhairle Contae na Gaillimhe. Sárú na n-áiríonnadh nómhádaireilte cúlpeachtaí Shaothairíochtaí Ordánáil Éireann agus Rialtas na hÉireann. © Shaothairíochtaí Ordánáil Éireann, 2010.

© Shaothairíochtaí Ordánáil Éireann. Gach ceart ar chaitiúnas. Uiníleir chéadlínas 2010 / SCMA / Comhairle Contae na Gaillimhe.

Includes Ordnance Survey Ireland data reproduced under OSI Licence number 2010/SCMA/Galway County Council. Unauthorised reproduction infringes Ordnance Survey Ireland and Government of Ireland copyright. © Ordnance Survey Ireland, 2010.

© Ordnance Survey Ireland. All rights reserved. Licence number 2010/SCMA/Galway County Council.

Clients

Comhairle Chontae na Gaillimhe
Galway County Council

Galway City Transport Project

An Roinn Iompair
Turasairíochta agus Sport
Department of Transport, Tourism and Sport

Key Plan

Consultant

ARUP

Corporate House
City East Business Park
Ballycork, Galway, Ireland.

Tel +353 (0)91 460675
www.arup.ie

Job Title

N6 Galway City Ring Road

Scale

As Shown @ A0

Date

February 2018

12	23/03/2018	AG	JD	MH
11	22/02/2018	AG	JD	MH
Issue	Date	By	Crkd	Appd

Drawing Title

Proposed Mitigation Lighting Plan
National University of Ireland, Galway

Drawing Status

For Information

Job No



233985


Drawing No

GCOB-3000-D-102

Issue

12

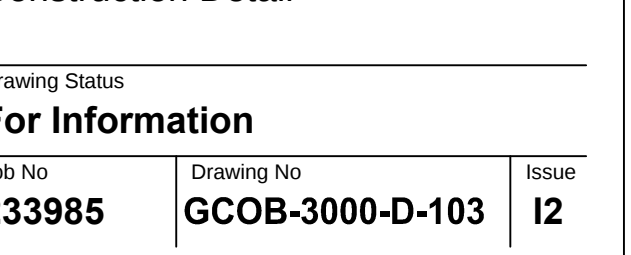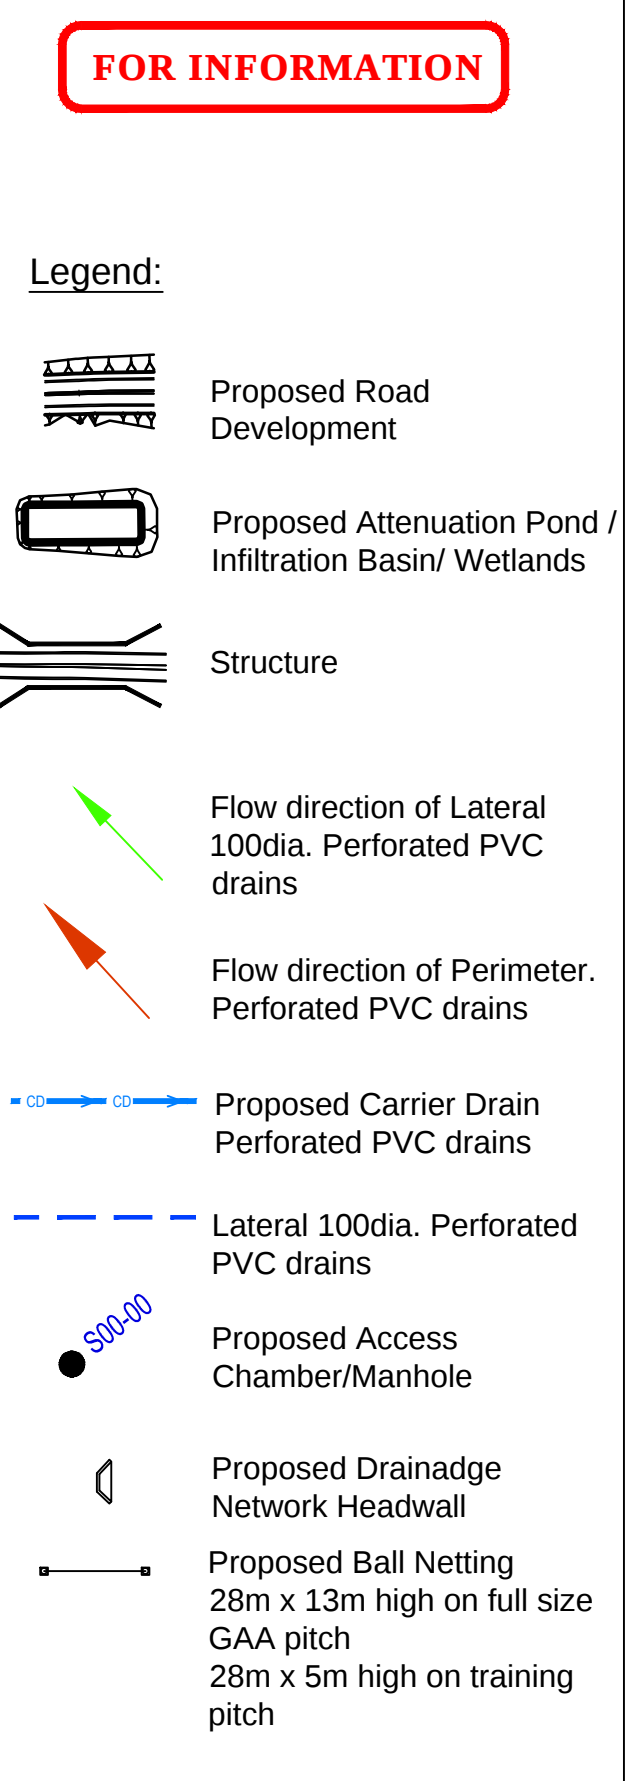

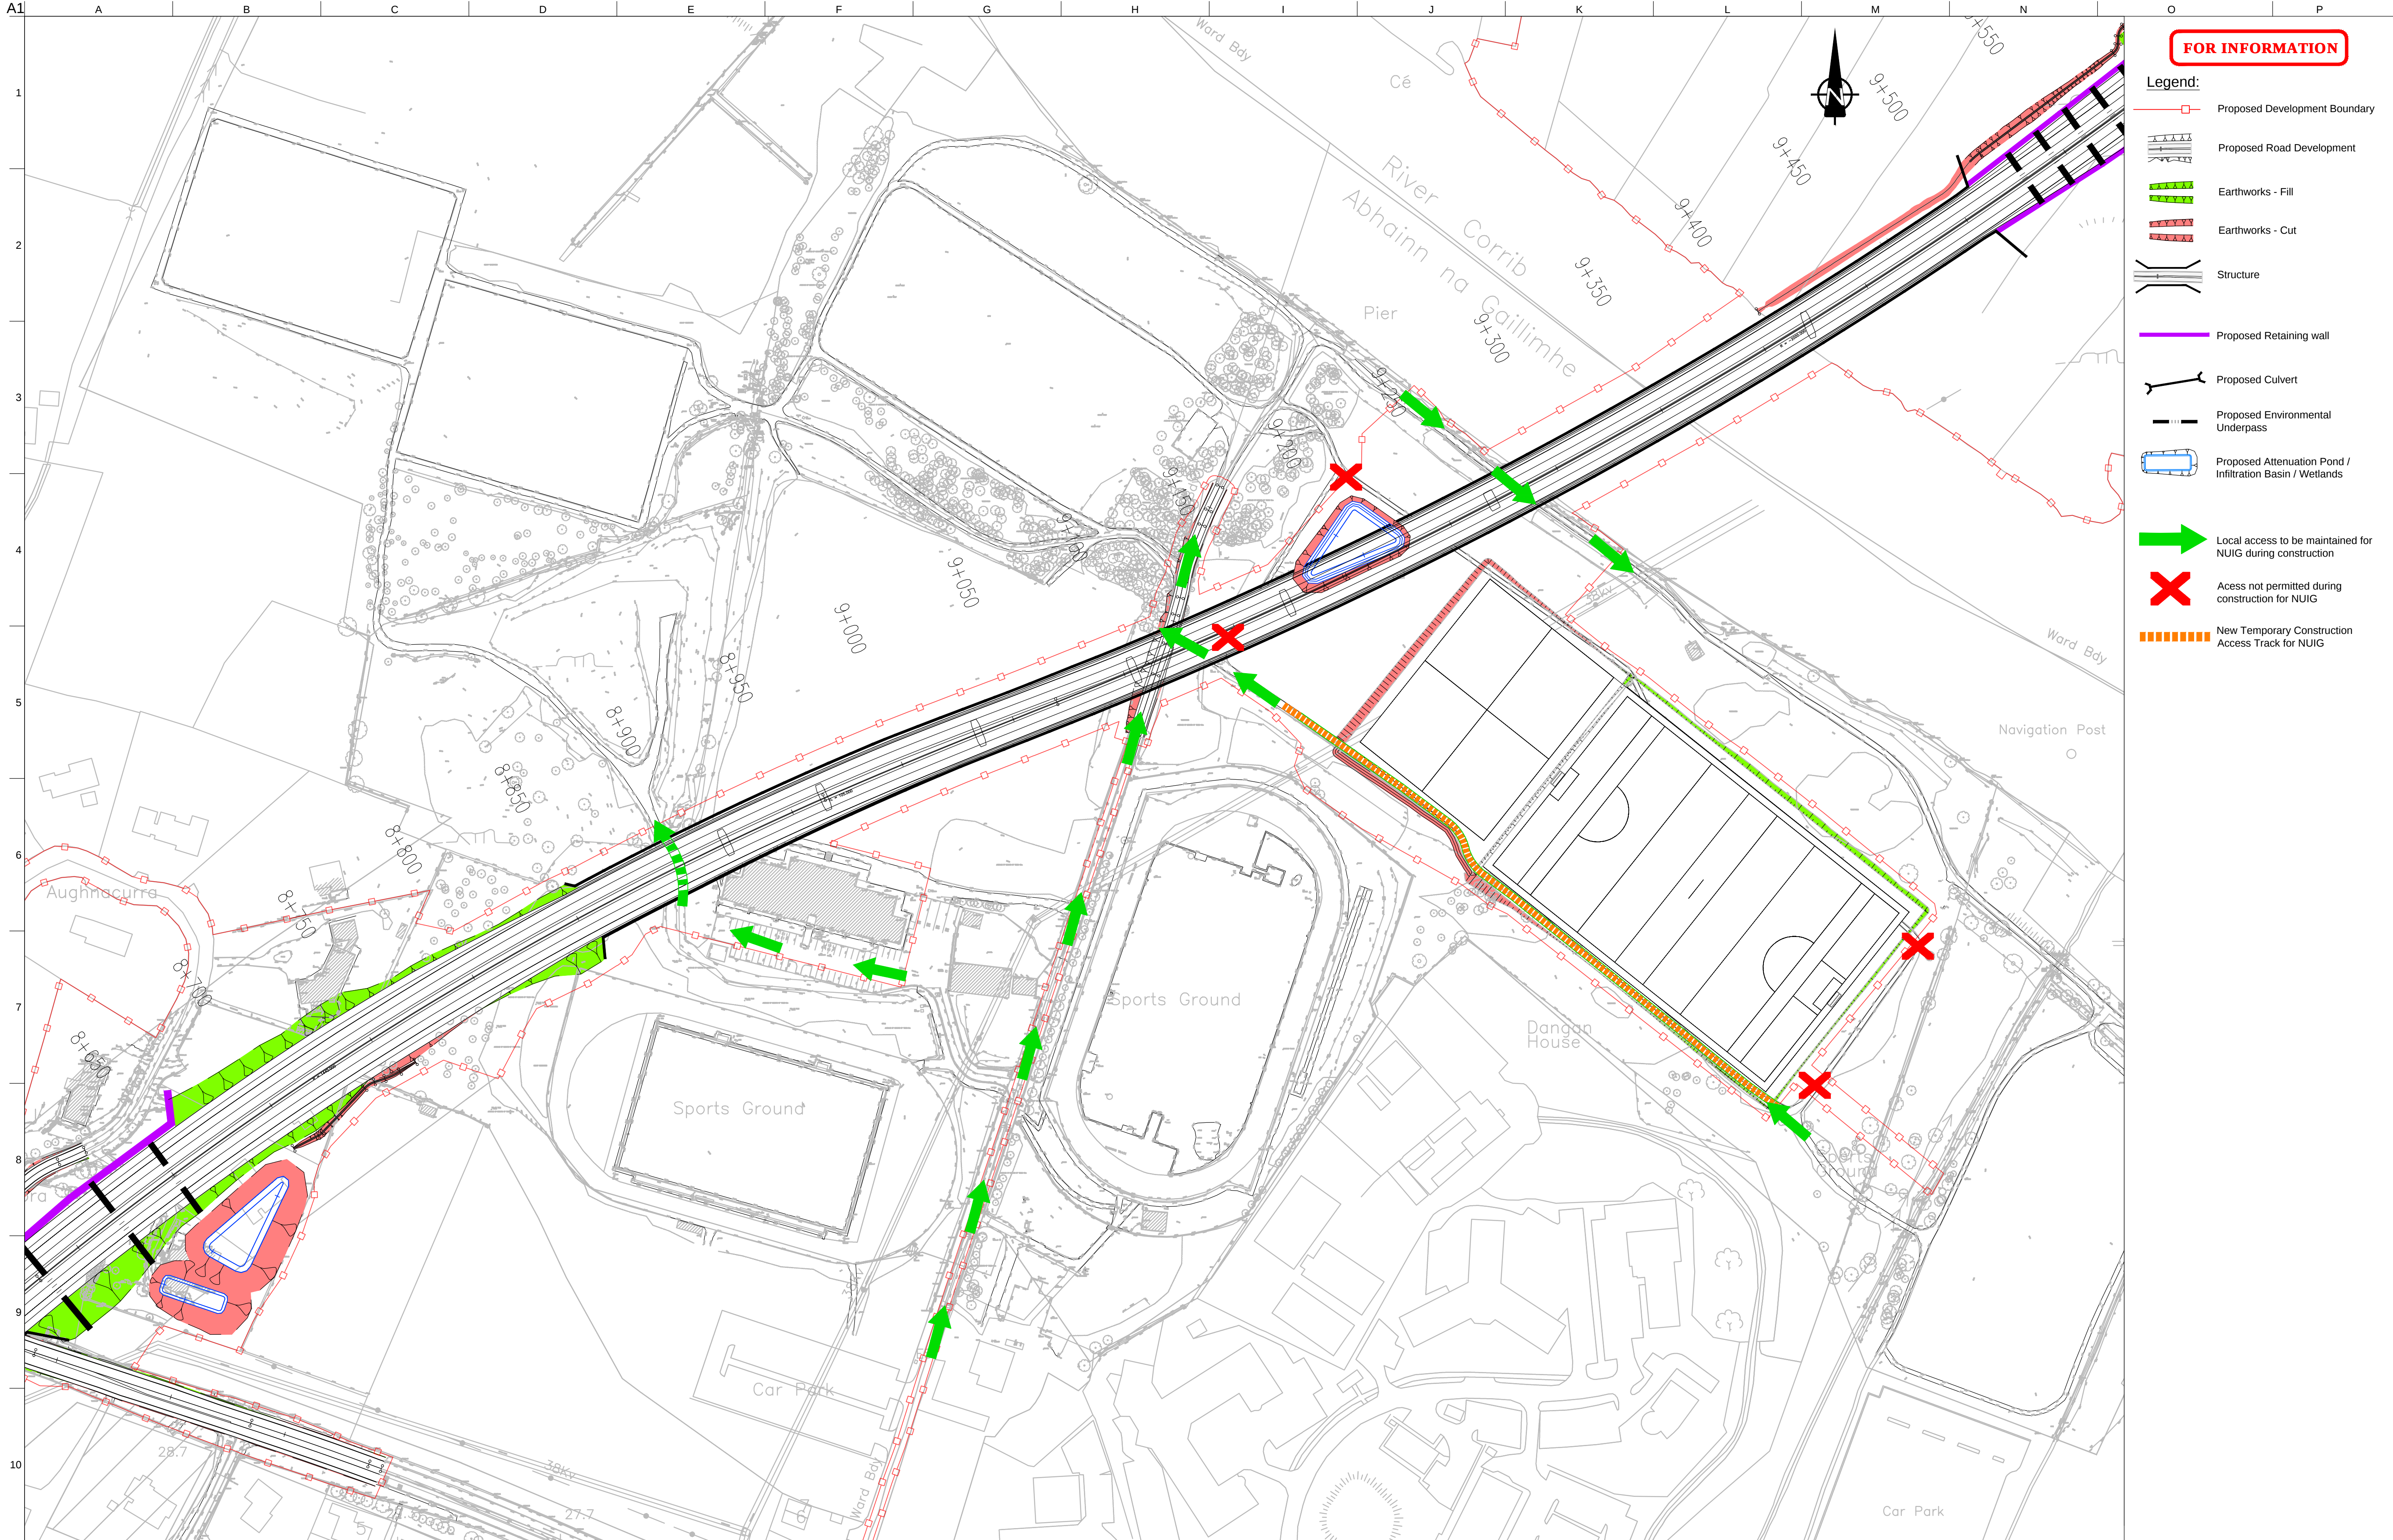

FOR INFORMATION

Legend:

- Proposed Development Boundary
- Proposed Road Development
- Earthworks - Fill
- Earthworks - Cut
- Structure
- Proposed Retaining wall
- Proposed Culvert
- Proposed Environmental Underpass
- Proposed Attenuation Pond / Infiltration Basin / Wetlands
- Local access to be maintained for NUIG during construction
- Access not permitted during construction for NUIG
- New Temporary Construction Access Track for NUIG

San áireamh tá sonraíocht Shuirbhíreachaí Ordánais Éireann arna áitirgeadh faoi Cheadúnas OSI Umh. 2010/18CCMA/Comhairle Contae na Gaillimhe. Sárúinn áitirgeadh neamhúdaraithe cóipeacht Shuirbhíreachaí Ordánais Éireann agus Rialtas na hÉireann. © Suirbhíreachaí Ordánais Éireann, 2010.

© Suirbhíreachaí Ordánais Éireann. Gach ceart ar chosaint.
Umhír cheadúnais 2010/18CCMA/Comhairle Contae na Gaillimhe.

Includes Ordnance Survey Ireland data reproduced under OSI Licence number 2010/18CCMA/Galway County Council.
Unauthorised reproduction infringes Ordnance Survey Ireland and Government of Ireland copyright. © Ordnance Survey Ireland, 2010.

© Ordnance Survey Ireland. All rights reserved. Licence number 2010/18CCMA/Galway County Council.

Clients

Comhairle Chontae na Gaillimhe
Galway County Council

N6
Galway City Transport Project

An Roinn Iompair
Turasóireachta agus Spóirt
Department Transport, Tourism and Sport

TII
Bonneagair Iompair Éireann
Transport Infrastructure Ireland

Consultant

ARUP

Corporate House
City East Business Park
Ballybrit, Galway, Ireland.

Tel +353 (0)91 460675
www.N6GalwayCity.ie
www.arup.ie

Job Title

N6 Galway City Ring Road

Scale

1:2500 @ A3

Date:

March 2018

11	23/03/2018	KJ	HK	MH
Issue	Date	By	Chkd	Appd

Drawing Title

NUIG Construction Phase Accessibility Plan

Drawing Status






For Information

Job No	Drawing No	Issue
233985-00	GCOB-3000-D-104	11



A1
1
2
3
4
5
6
7
8
9
10

FOR INFORMATION

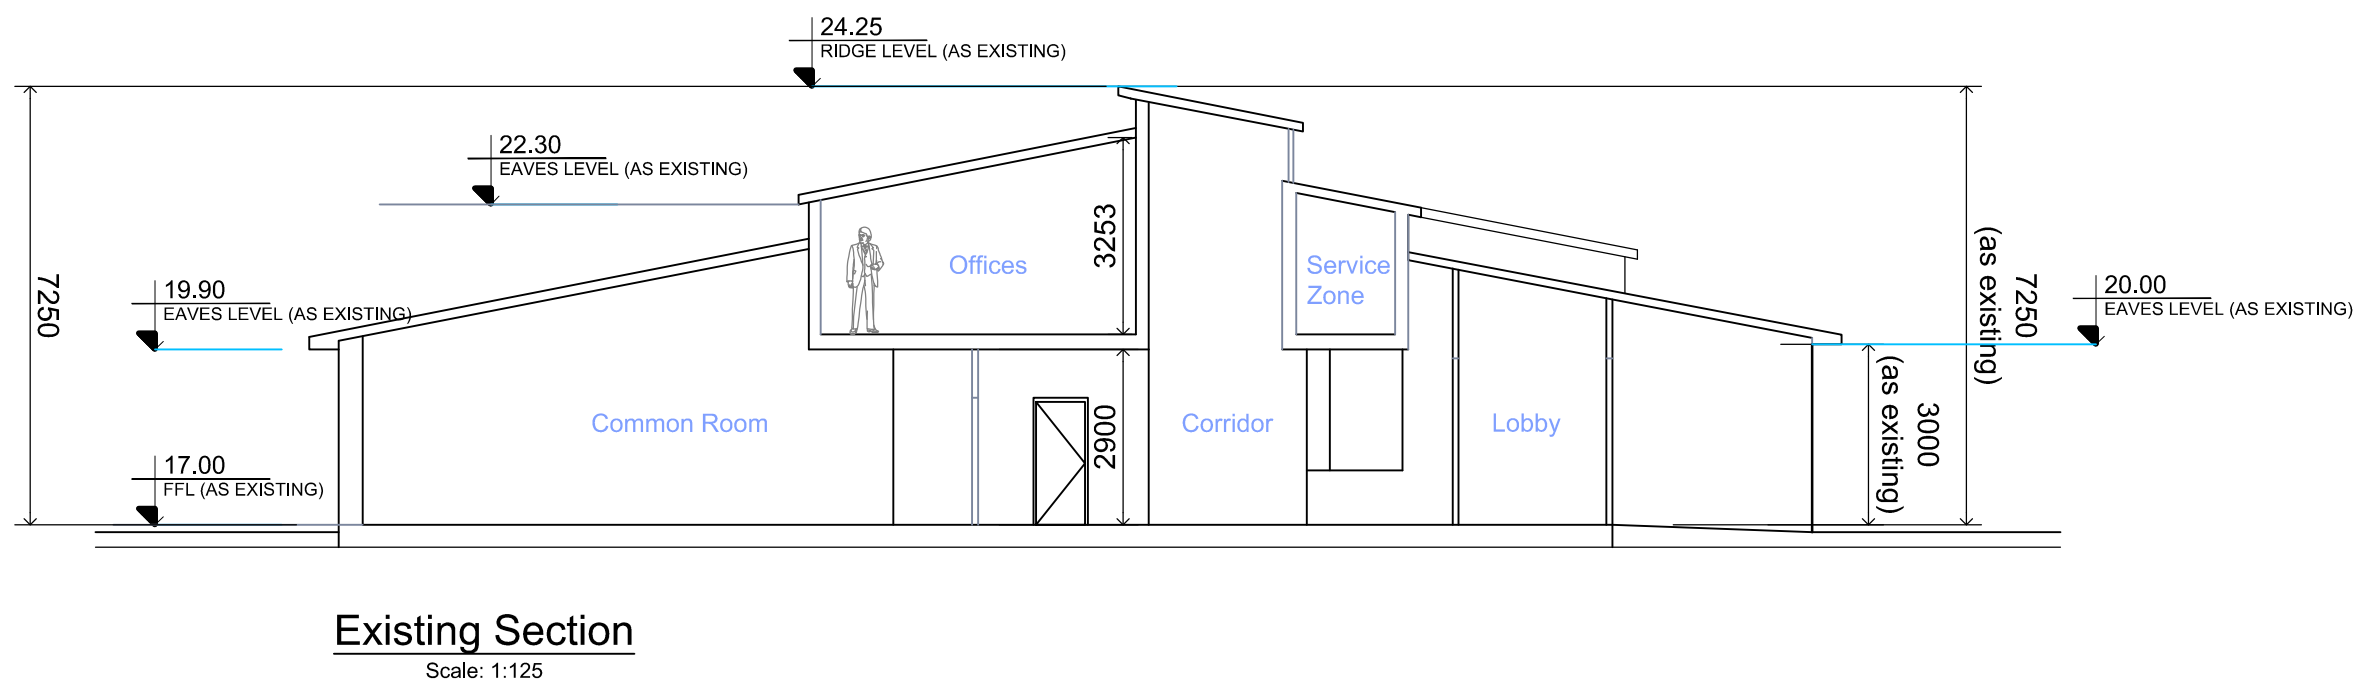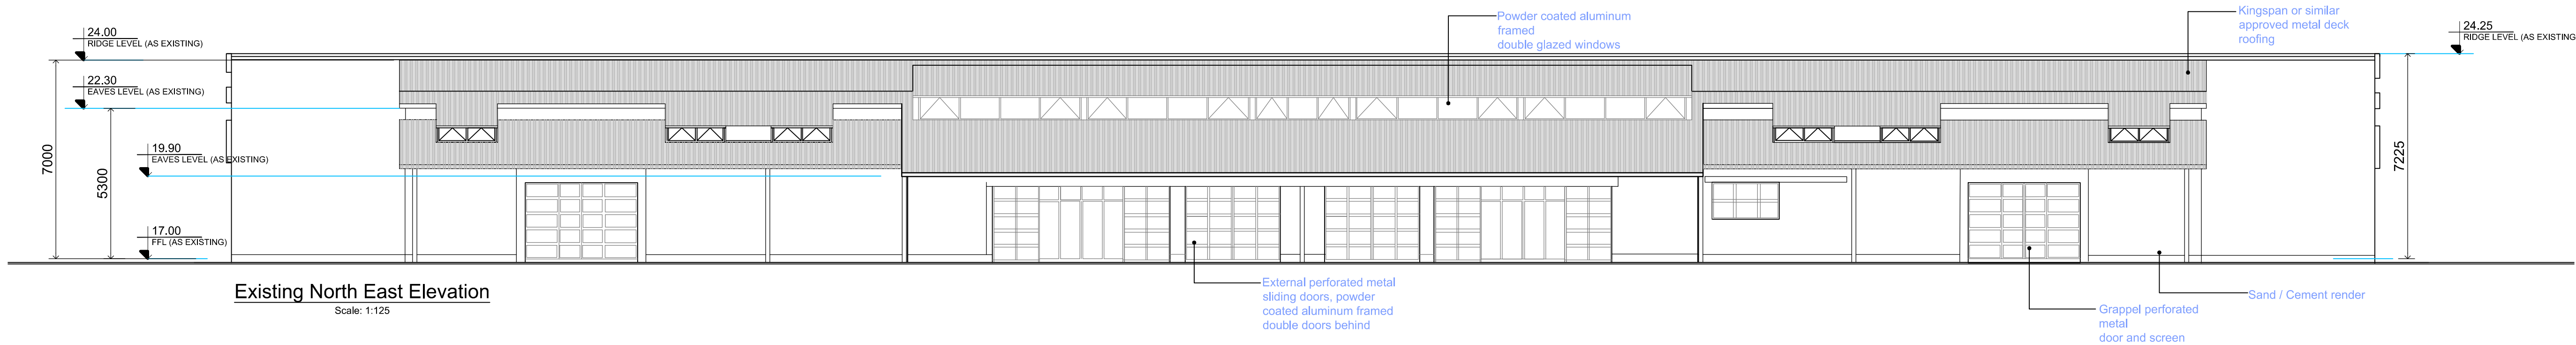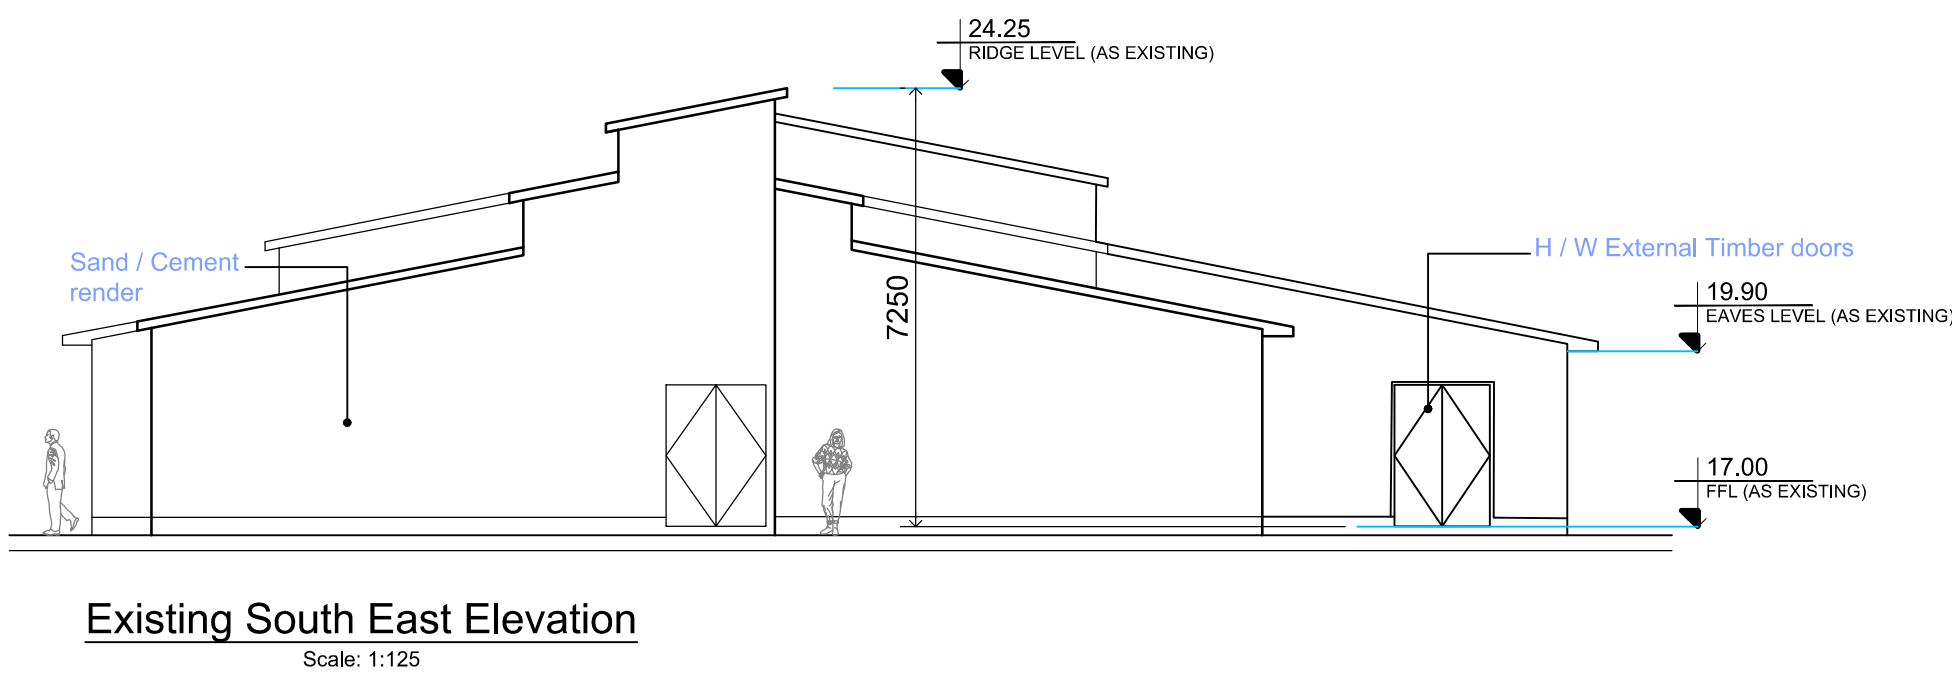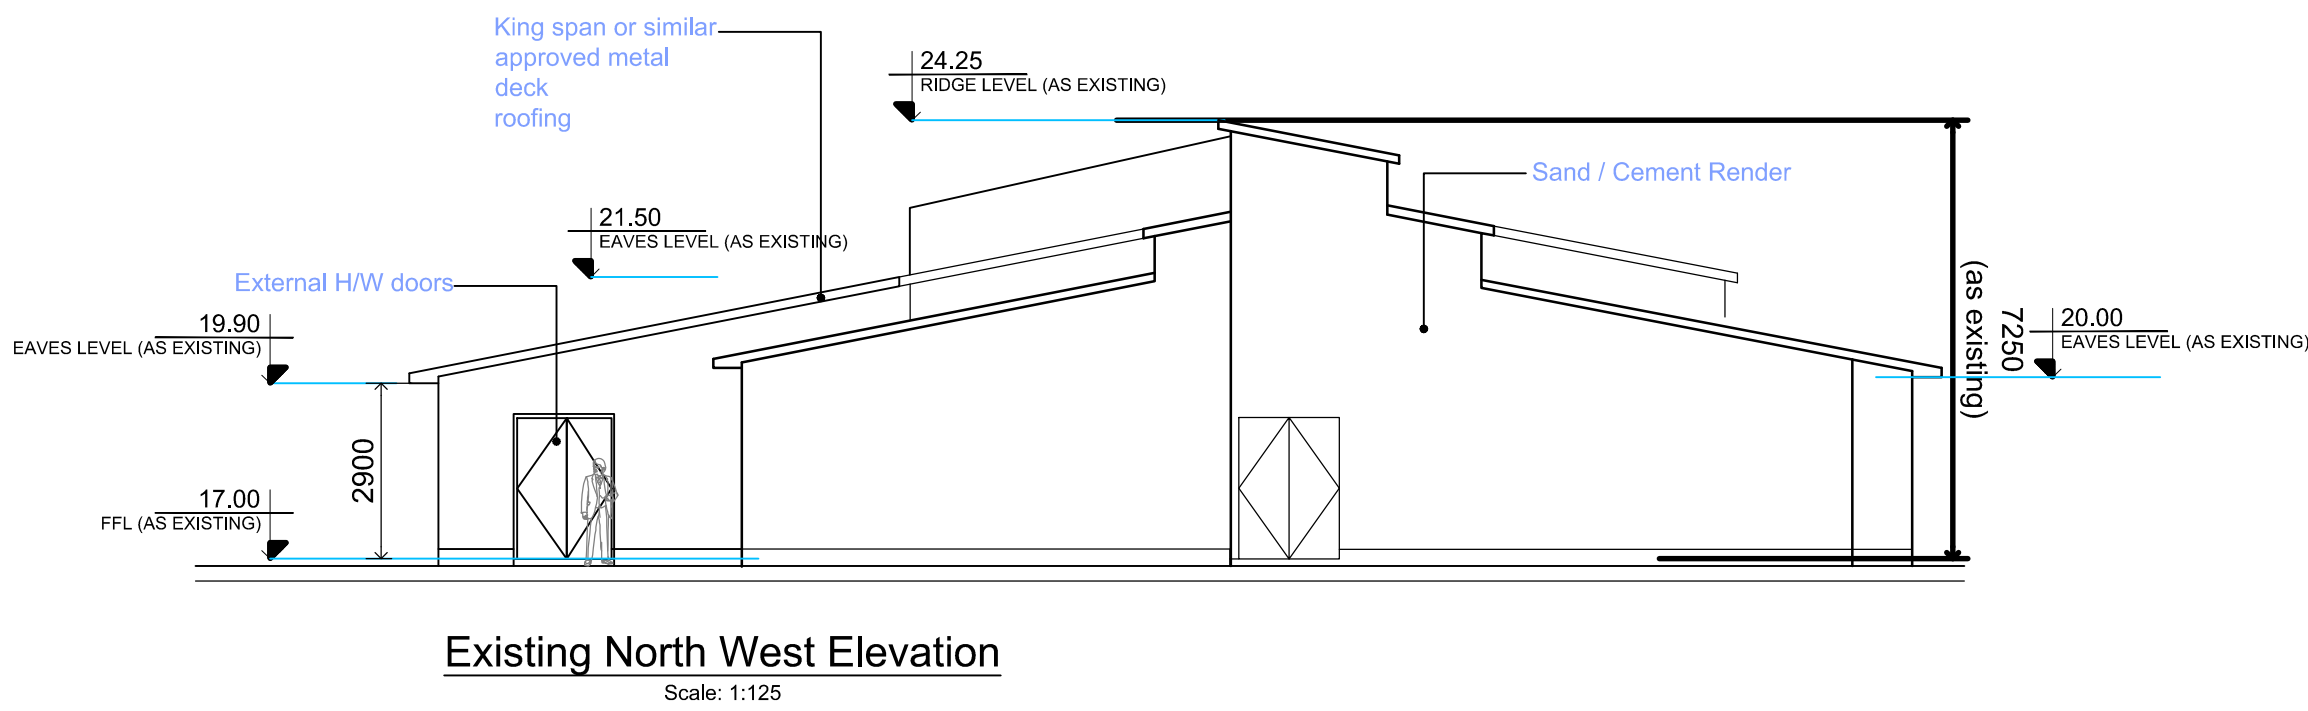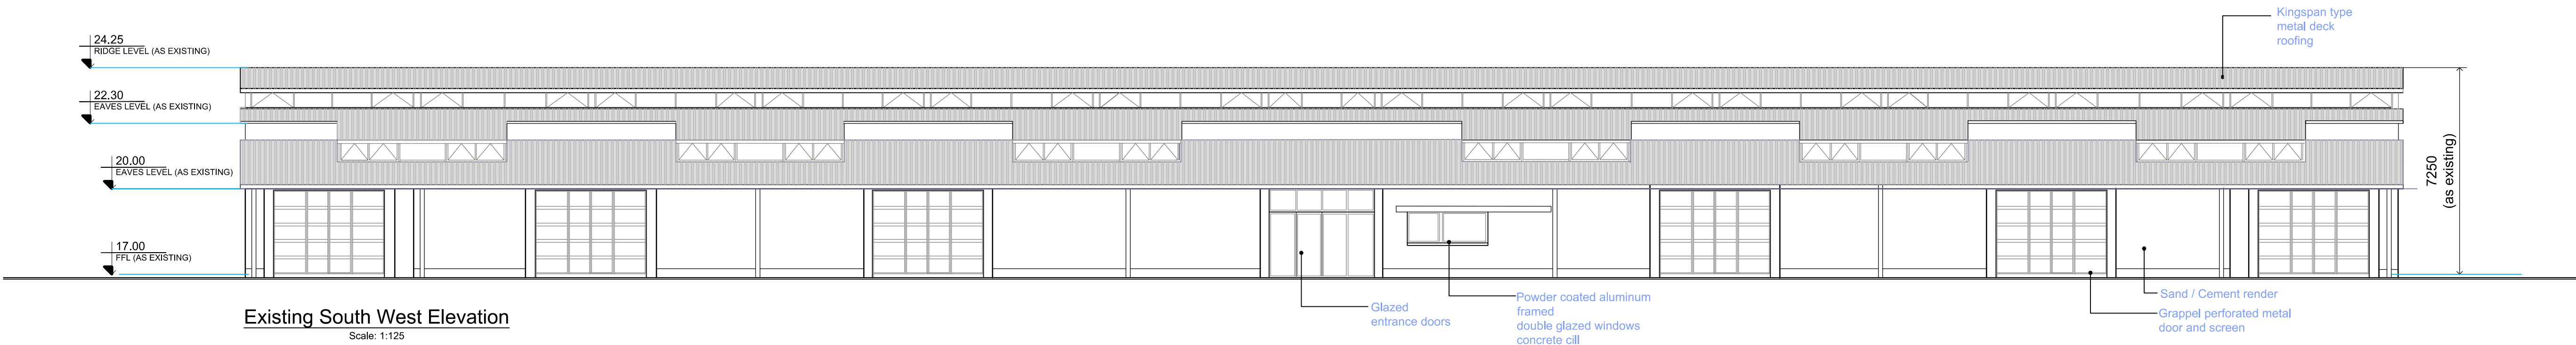

Clients

Comhairle Chontae na Gaillimhe
Galway County Council

Galway City
Transport Project

An Roinn Iompair
Turasóireachta agus Spóirt
Department Transport, Tourism and Sport

TII
Transport Infrastructure Ireland

Consultant

ARUP

Corporate House
City East Business Park
Ballybrit, Galway, Ireland.

Tel +353 (0)91 460675
www.N6GalwayCity.ie
www.arup.ie

Job Title

N6 Galway City Ring Road

Scale

1:125 @ A1

Date:

February 2018

I2	23/03/2018	AG	HK	EMC
I1	22/02/2018	KJ	HK	EMC
Issue	Date	By	Chkd	Appd

Drawing Title

NUIG Sports Pavilion Remediation Works
Existing Elevations and Section
Sheet 3 of 7

Drawing Status

For Information

Job No


233985

Drawing No

GCOB-3000-D-223

Issue

12

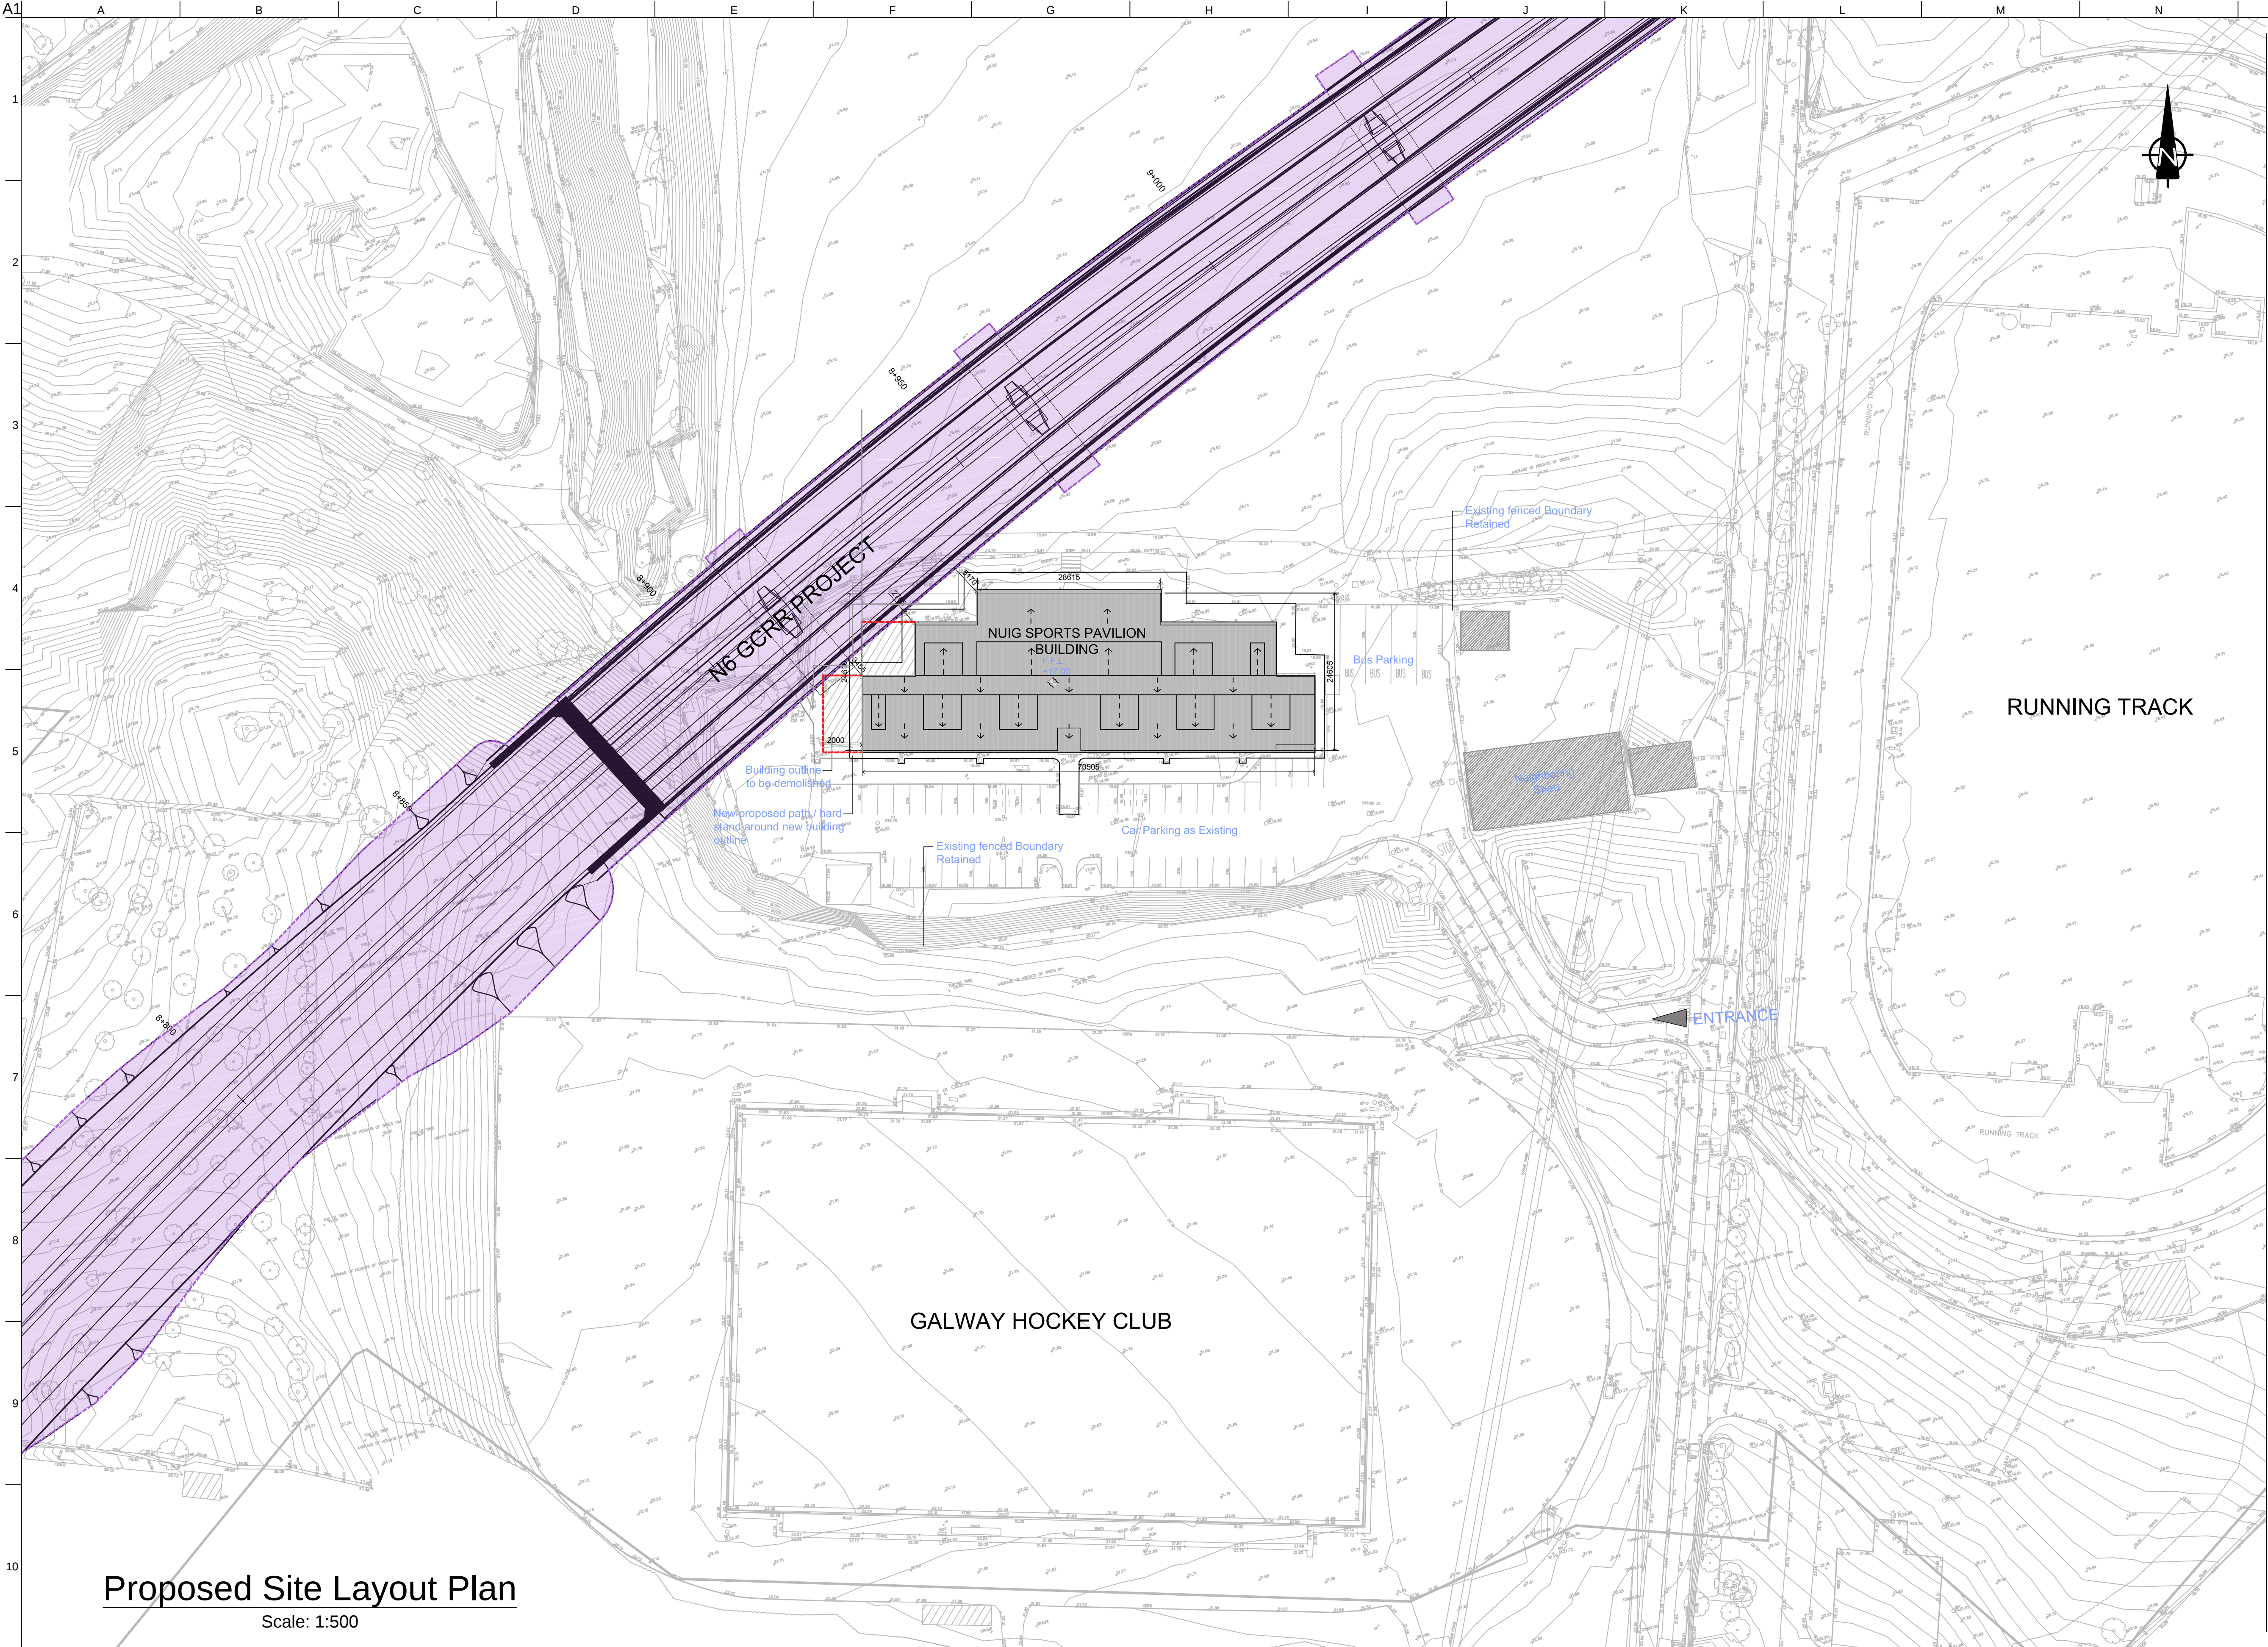

FOR INFORMATION

- Legend:
- Proposed Road Development
 - Site Area
 - Adjoining Lands in Ownership of Applicant.
 - Outline of Proposed N6 GCRR Project
 - Outline of Building to be demolished

Proposed Site Layout Plan
Scale: 1:500

Clients



Comhairle Chontae na Gaillimhe
Galway County Council



N6
Galway City
Transport Project



An Roinn Iompair
Turasóireachta agus Spóirt
Department Transport, Tourism and Sport



TII
Transport Infrastructure Ireland

Consultant



ARUP

Corporate House
City East Business Park
Ballybrit, Galway, Ireland.

Tel +353 (0)91 460675
www.N6GalwayCity.ie
www.arup.ie

Job Title
N6 Galway City Ring Road


Scale
1:500 @ A1
Date
February 2018

I2	23/03/2018	AG	HK	EMC
I1	22/02/2018	KJ	HK	EMC
Issue	Date	By	Chkd	Appd

Drawing Title
NUIG Sports Pavilion
Proposed Site Layout
Sheet 4 of 7

Drawing Status
For Information

Job No 233985	Drawing No GCOB-3000-D-224	Issue 12
------------------	-------------------------------	-------------

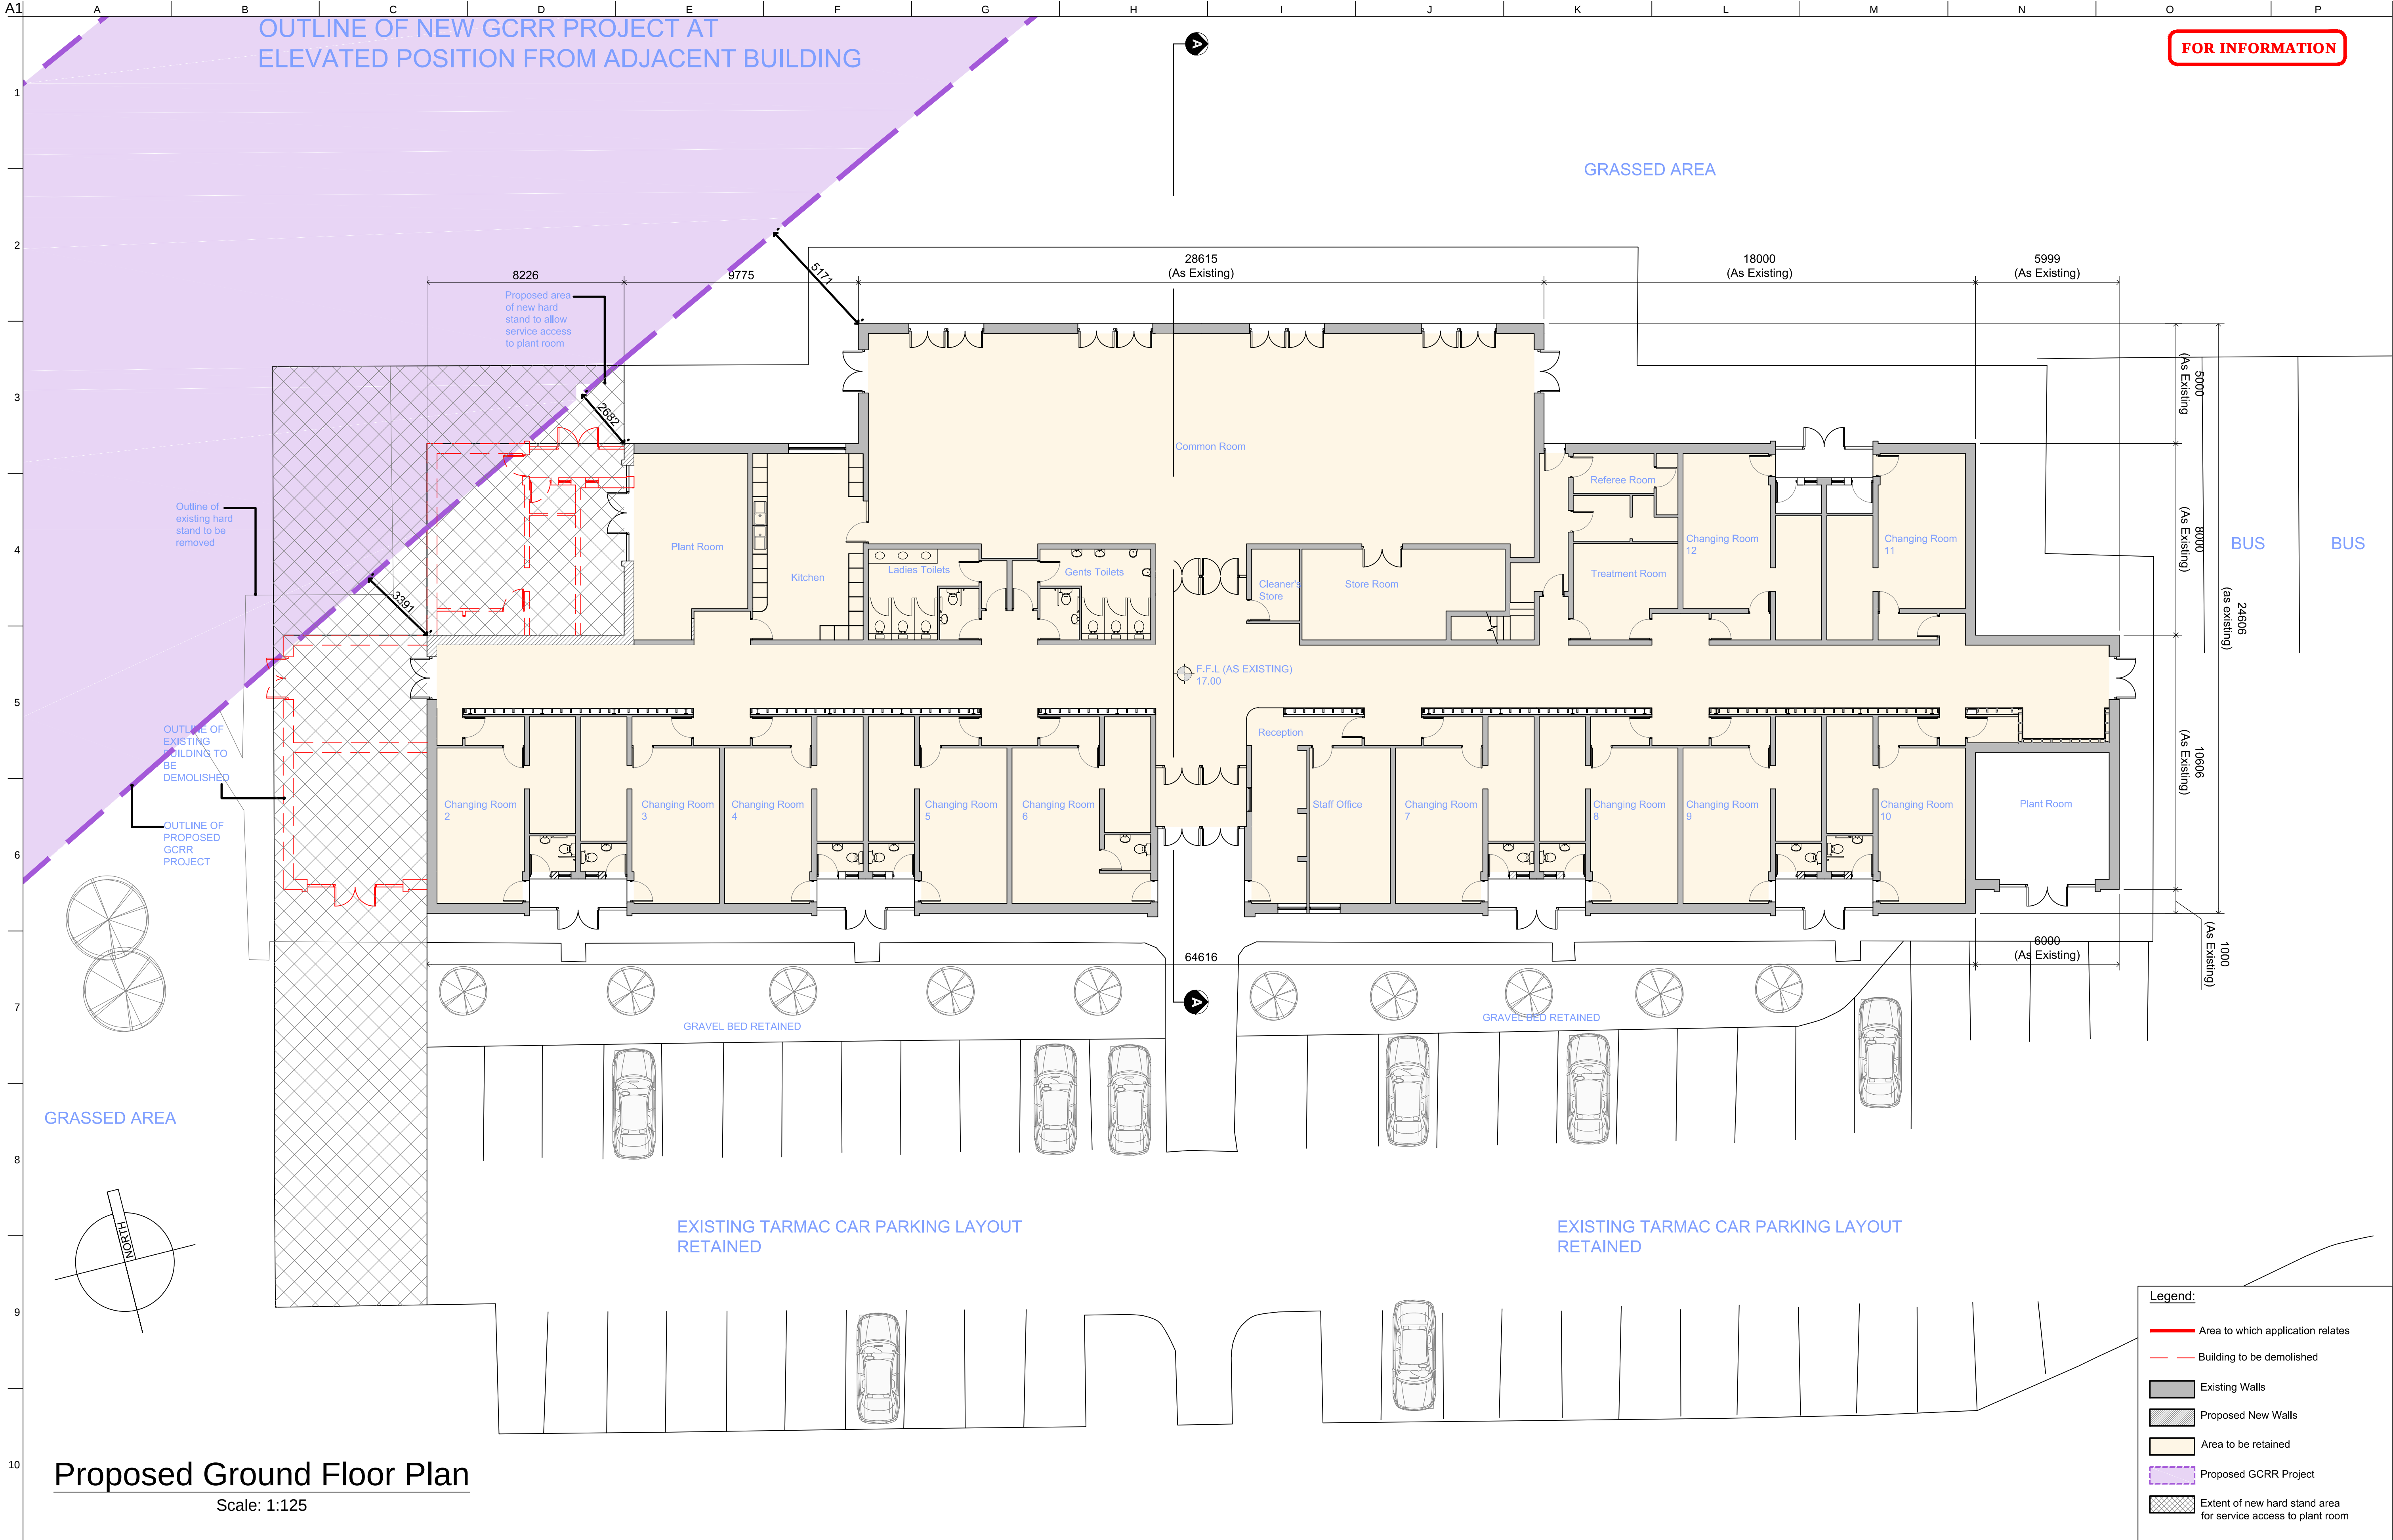

Proposed Ground Floor Plan
Scale: 1:125

- Legend:**
- Area to which application relates
 - Building to be demolished
 - Existing Walls
 - Proposed New Walls
 - Area to be retained
 - Proposed GCRR Project
 - Extent of new hard stand area for service access to plant room

Clients



Comhairle Chontae na Gaillimhe
Galway County Council



N6
Galway City
Transport Project



An Roinn Iompair
Turasóireachta agus Spóirt



TIIP
Bonneagair Iompair Éireann
Transport Infrastructure Ireland

Consultant

ARUP

Corporate House
City East Business Park
Ballybrit, Galway, Ireland.

Tel +353 (0)91 460675
www.N6GalwayCity.ie
www.arup.ie

Job Title
N6 Galway City Ring Road

Scale
1:125 @ A1

Date
February 2018




I2	23/03/2018	AG	HK	EMC
I1	22/02/2018	KJ	HK	EMC
Issue	Date	By	Chkd	Appd

Drawing Title
NUIG Sports Pavilion Remediation Works
Proposed Ground Floor Plan
Sheet 5 of 7

Drawing Status
For Information

Job No 233985	Drawing No GCOB-3000-D-225	Issue 12
-------------------------	--------------------------------------	--------------------

FOR INFORMATION

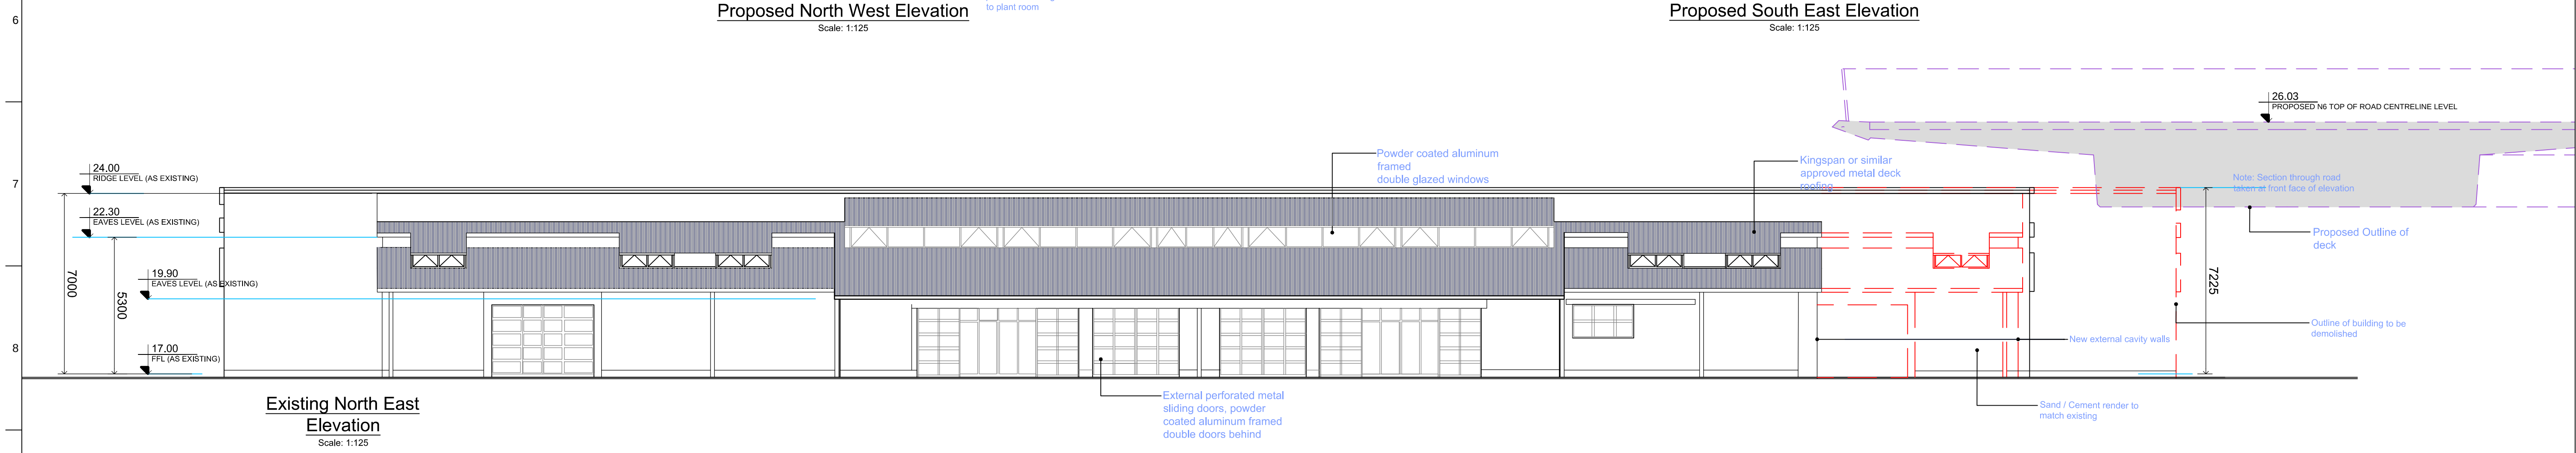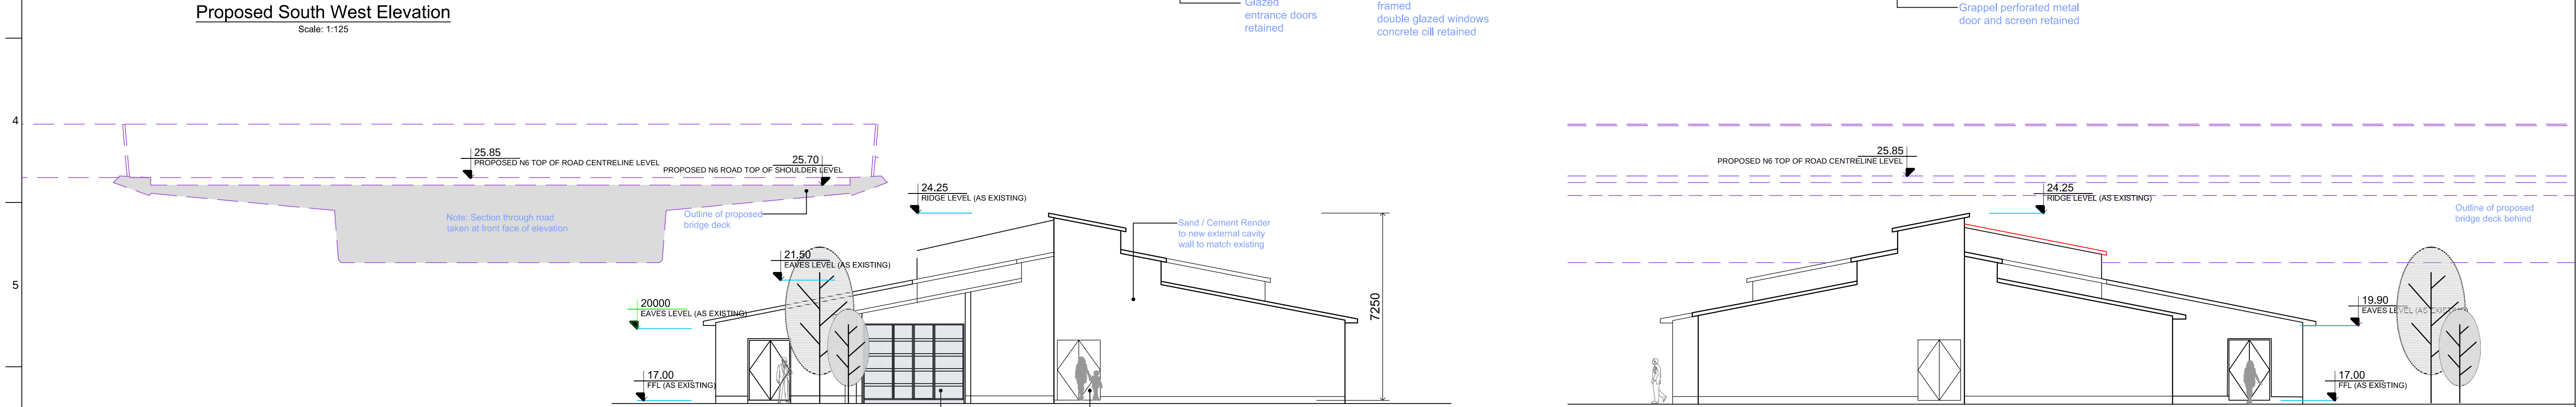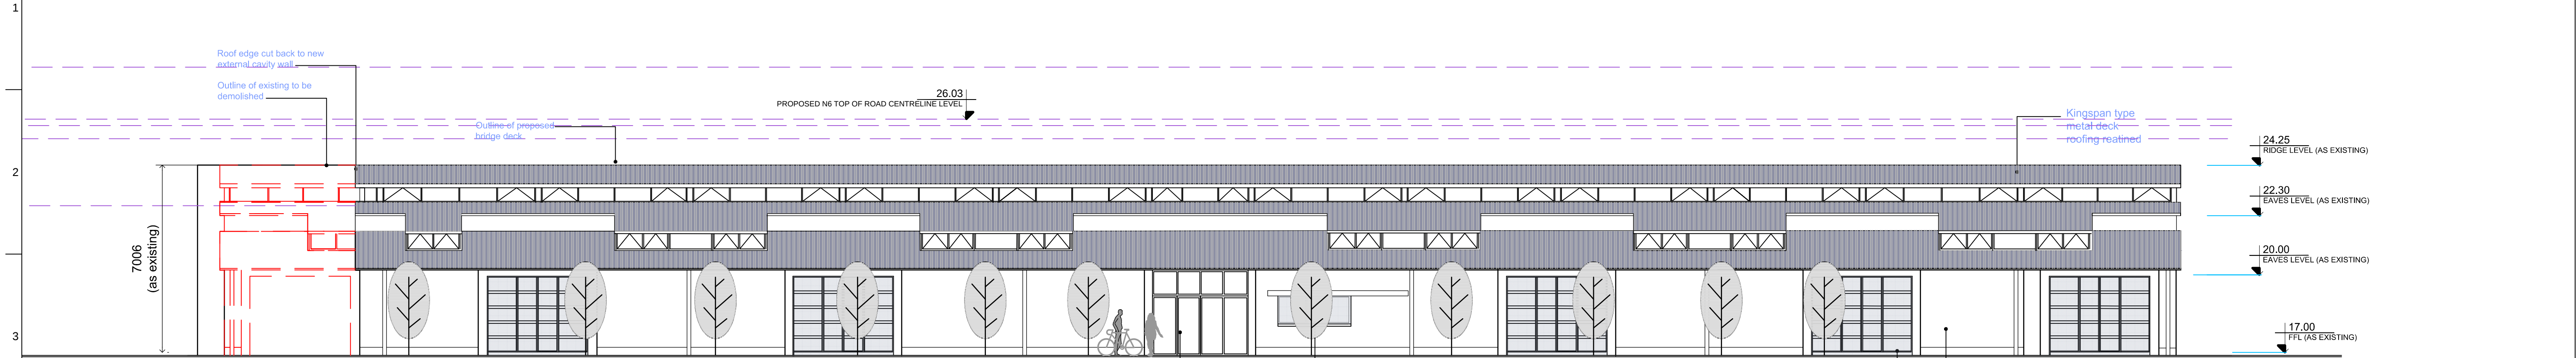

- Legend:
- Area to which application relates
 - Building to be demolished
 - Existing Walls
 - Proposed New Walls
 - Area to be retained
 - Proposed GCRR Project
 - Extent of new hard stand area for service access to plant room

Clients

Comhairle Chontae na Gaillimhe
Galway County Council

An Roinn Iompair
Turasóireacht agus Spóirt
Department Transport, Tourism and Sport

N6
Galway City
Transport Project

TII
Bonneagair Iompair Éireann
Transport Infrastructure Ireland

Consultant

ARUP

Corporate House
City East Business Park
Ballybrit, Galway, Ireland.

Tel +353 (0)91 460675
www.N6GalwayCity.ie
www.arup.ie

Job Title

N6 Galway City Ring Road

Scale 1:125 @ A1

Date: February 2018

I2	23/03/2018	AG	HK	EMC
I1	22/02/2018	KJ	HK	EMC
Issue	Date	By	Chkd	Appd

Drawing Title

NUIG Sports Pavilion Remediation Works
Proposed Elevations and Section
Sheet 7 of 7

Drawing Status

For Information

Job No	Drawing No	Issue
233985	GCOB-3000-D-227	12