

Luminaire Schedule			
Symbol	Qty	Label	Lum. Lumens
	18	A15	19500
			LLF 0.90



Description	Filename
AkraLED 150w LED 4K, Asymmetric	5SF150LBA.IES

NOTES:
 1. THIS DRAWING IS FOR PLANNING APPLICATION PURPOSES ONLY.
 2. DRAWING NOT TO BE SCALED. FIGURED DIMENSIONS ONLY TO BE USED.
 3. ALL LEVELS TO METRES MALIN HEAD ABOVE ORDNANCE DATUM

NOTE:
 PLANS AND LAYOUT DRAWINGS SHOW PRINCIPLE FEATURES AND STRUCTURES OF THE SITE. AS WITH ALL INDUSTRIAL SITES, ON-GOING OPERATIONS AND MAINTENANCE OCCASIONALLY NECESSITATE THE TEMPORARY USE OF MODULAR UNITS SUCH AS PORTACABINS FOR WELFARE FACILITIES, STORAGE ETC. THEIR USE IS TYPICALLY SHORT-TERM, RELATED TO PARTICULAR ACTIVITIES AND DOES NOT CHANGE THE NATURE OR INTENSITY OF ACTIVITIES ON THE SITE.

LEGEND:

PLANNING APPLICATION BOUNDARY:		+44.50
EXISTING GROUND LEVEL (MOD):		
EXISTING TREES:		
EXISTING FENCE:		
EXISTING LAMP POST:		
PROPOSED LAMP POST:		
PROPOSED DEVELOPMENT:		
PROPOSED CONCRETE SLAB:		
EXISTING BUILDING:		
AREA EXCLUDED FROM APPLICATION:		

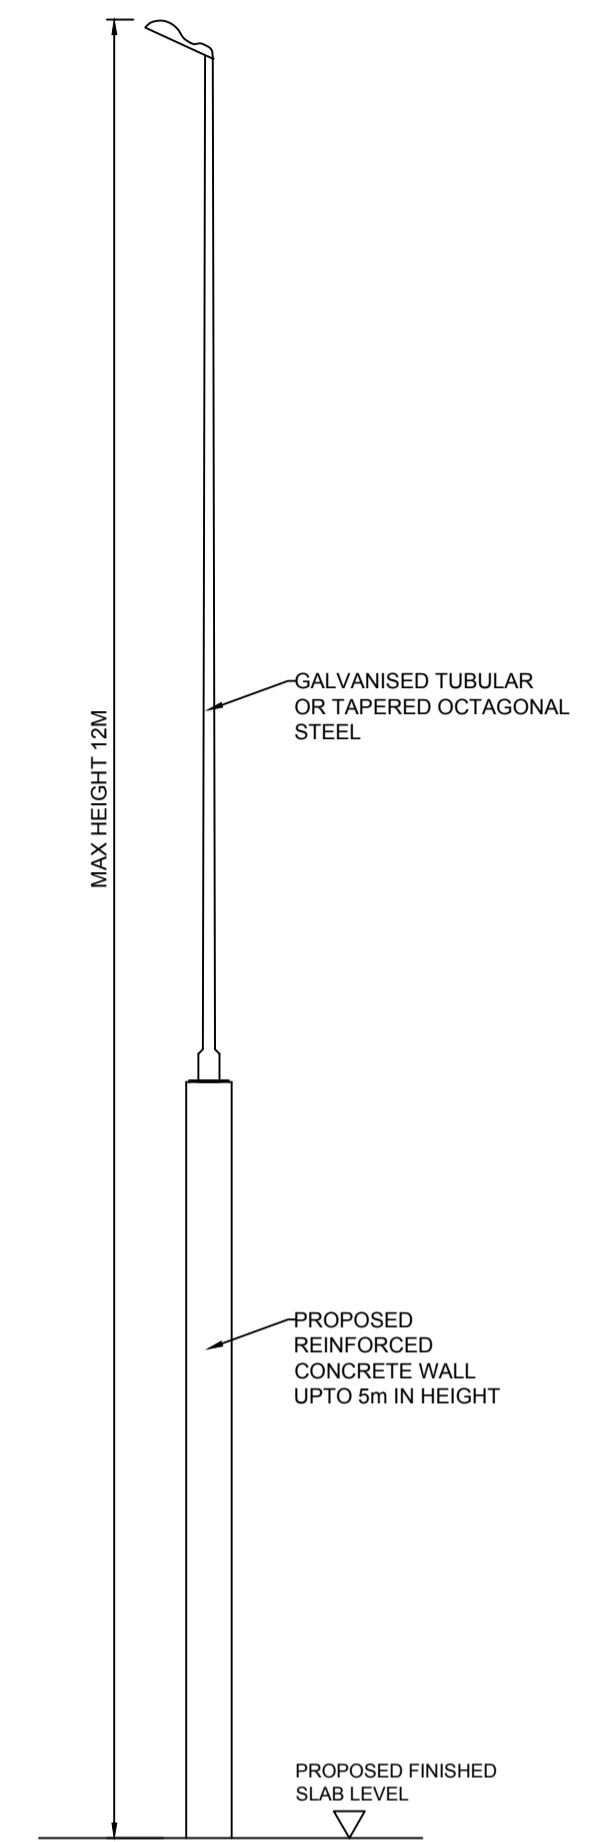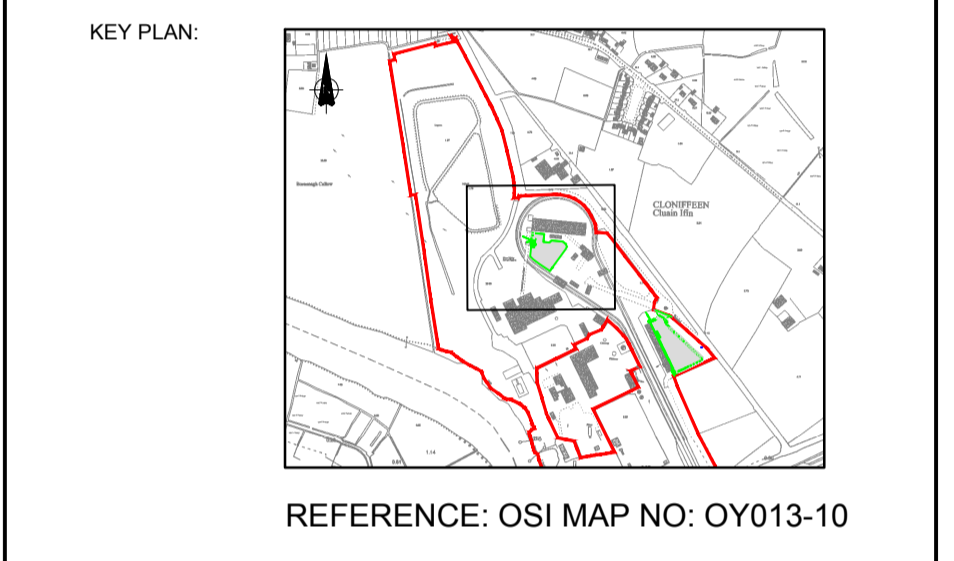

LAMP POST TYPICAL DETAIL SCALE 1:50

REV	DATE	REVISION DESCRIPTION	DRN	VER	APP	DRN	VER	APP
0	18.10.18	ISSUED FOR PLANNING	KMG	JH	DMcK	PN	BH	

COPYRIGHT © ESB INTERNATIONAL LIMITED
 ALL RIGHTS RESERVED. NO PART OF THIS WORK MAY BE MODIFIED, REPRODUCED OR COPIED IN ANY FORM OR BY ANY MEANS - GRAPHIC, ELECTRONIC OR MECHANICAL, INCLUDING PHOTOCOPYING, RECORDING, TAPING OR USED FOR ANY PURPOSE OTHER THAN ITS DESIGNATED PURPOSE, WITHOUT THE WRITTEN PERMISSION OF ESB INTERNATIONAL ENGINEERING & FACILITY MANAGEMENT LTD., TRADING AS ESB INTERNATIONAL.

PURPOSE OF ISSUE - PRELIMINARY UNLESS INDICATED
 CLIENT APPROVAL PLANNING TENDER CONSTRUCTION AS-BUILT

CLIENT: ESB

PROJECT: WEST OFFALY POWER TRANSITION TO BIOMASS

ENGINEER DESIGN: **BORDOMONA** Naturally Driven
 Engineering Department, Leabeg, Tullamore, Co. Offaly Tel: 057 9345900

CONTRACT: WOP - TRANSITION TO BIOMASS

DRAWING TITLE: BIOMASS STORAGE SLAB A PROPOSED LIGHTING LAYOUT PLAN

PRODUCTION UNIT: CIVIL & ENVIRONMENTAL ENGINEERING

ESB INTERNATIONAL
 One Dublin Airport Central, Dublin Airport, Cloughran, Co. Dublin
 Tel: 353 1 703 8000 Email: marketing@esbi.ie
 Web: www.esbinternational.ie
 ESB International is a trading name of ESB International Engineering & Facility Management Ltd. Registered Office: as above Registered in Ireland No. 155249

DRAWN	VERIFIED	APPROVED	APPROVAL DATE
KMG	JH	DMcK	18.10.18
CLIENT REF	NO. OF SHTS	SIZE	SCALE
	1	A1	1:500

DRAWING NUMBER: QS-00206-01-D460-038
 REV: 0

Luminaire Location Summary			
LumNo	Z	Orientation	Tilt
1	12	237	10
2	12	283	10
3	12	7	10
4	12	353	10
5	12	240	10
6	12	286	10
7	12	126	10
8	12	157	10
9	12	10	10
10	12	353	10
11	12	118	10
12	12	170	10
13	12	124	10
14	12	168	10
15	12	86	10
16	12	22	10
17	12	86	10
18	12	22	10
Total Quantity: 18			