




- NOTES:
1. THIS DRAWING IS FOR PLANNING APPLICATION PURPOSES ONLY.
 2. REFER TO DRAWING NO. QS-000206-01-D460-035 FOR BIOMASS SLAB B DRAINAGE LAYOUT PLAN.
 3. DRAWING NOT TO BE SCALED. FIGURED DIMENSIONS ONLY TO BE USED.
 4. ALL LEVELS TO MALIN HEAD METRES ABOVE DATUM

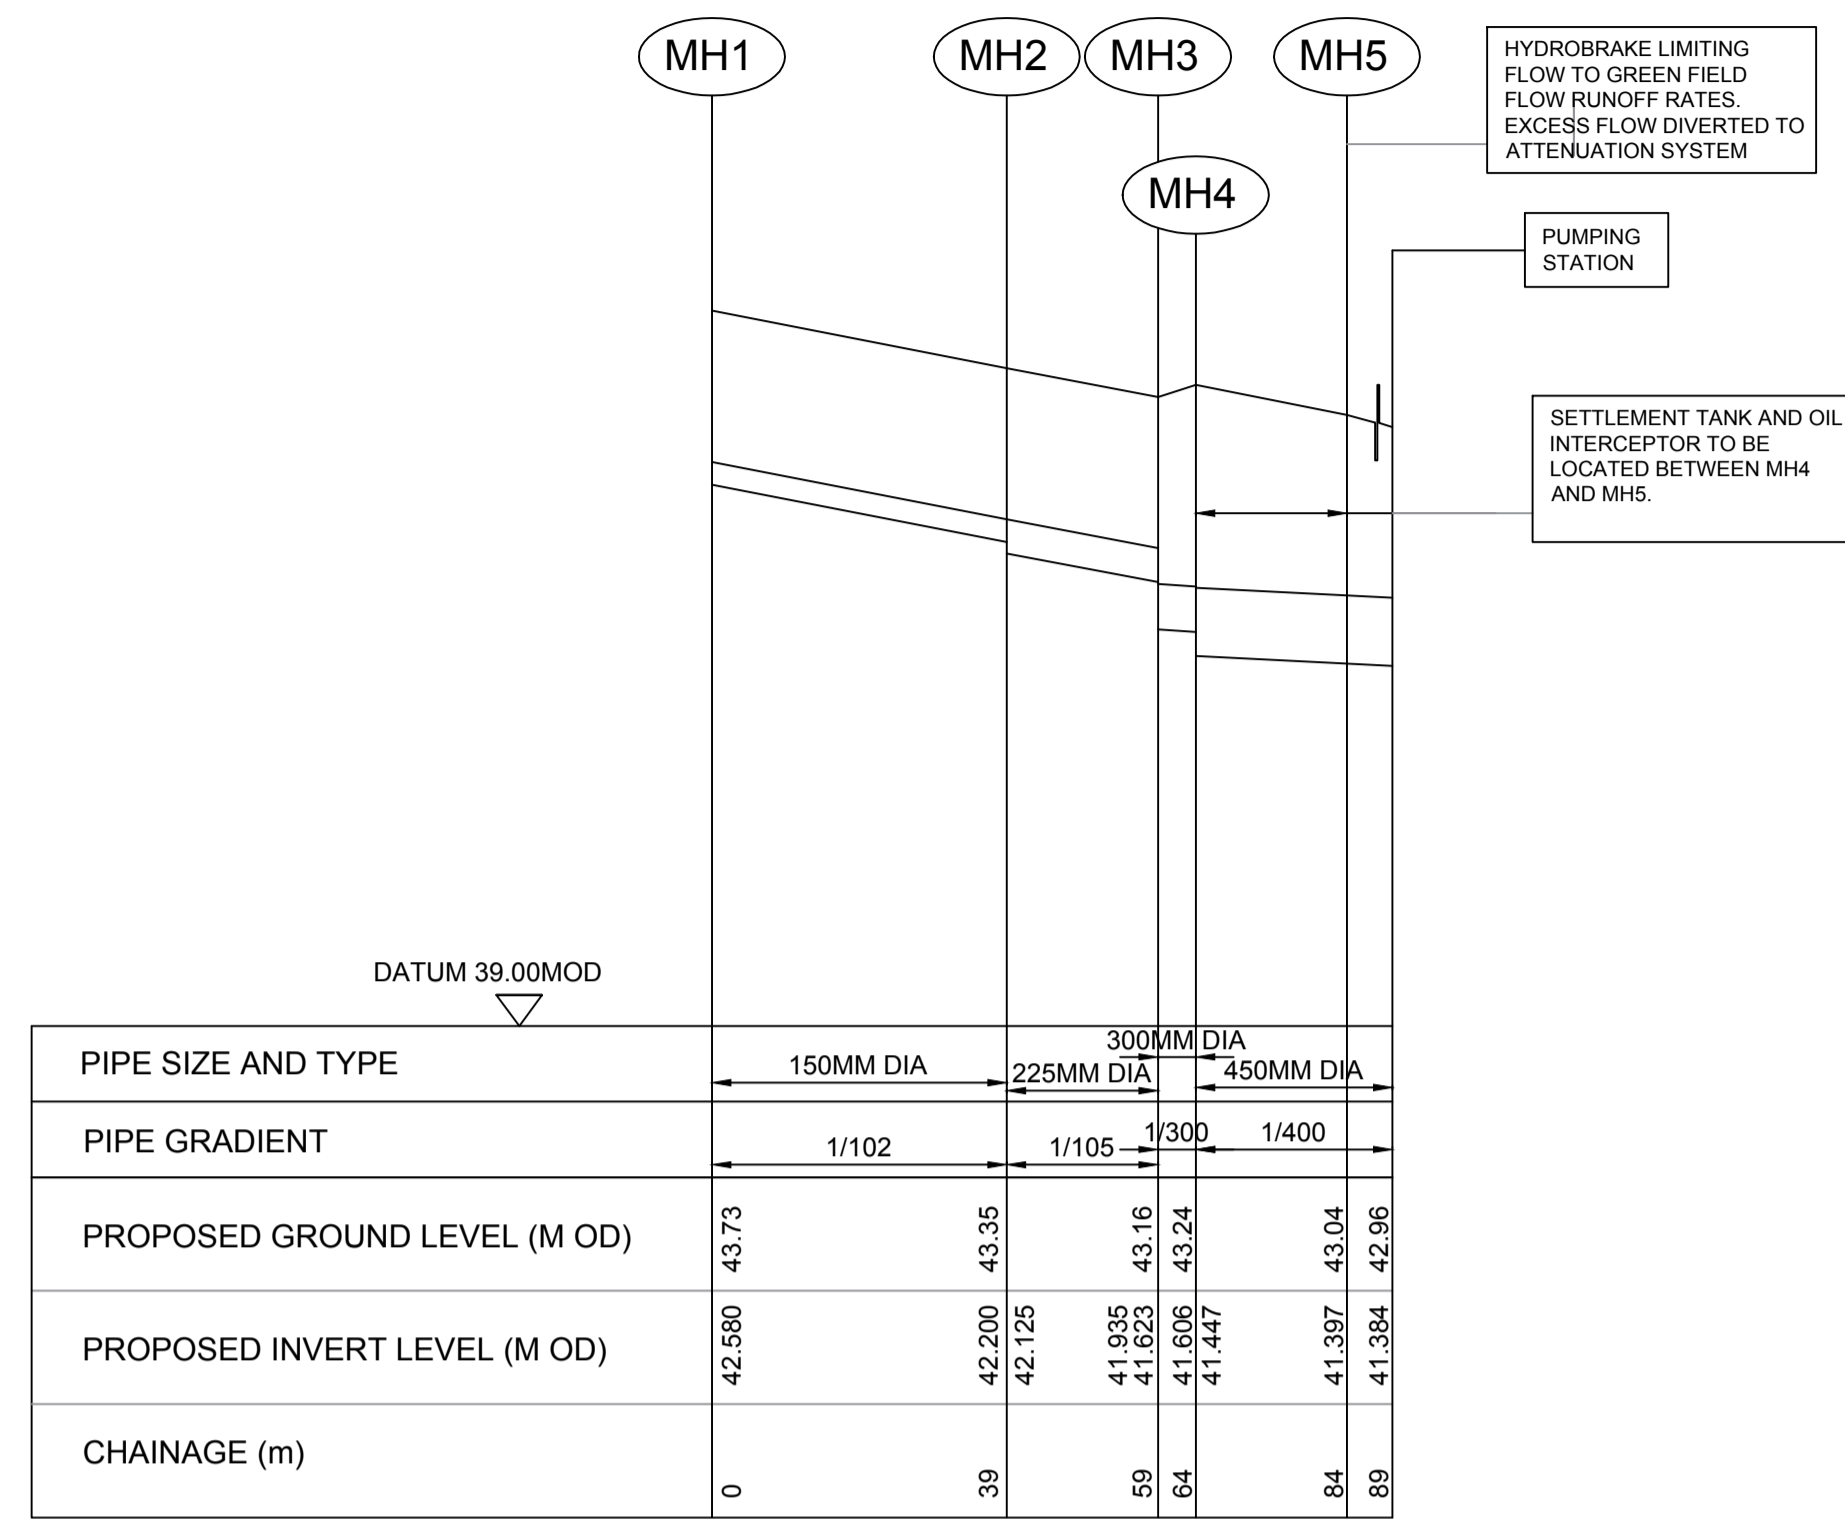


BIOMASS SLAB B: PIPE SECTION - CH 00 TO CH 89 (MH1 TO PUMPING STATION)
SCALE: HORIZONTAL 1/1000, VERTICAL 1/50

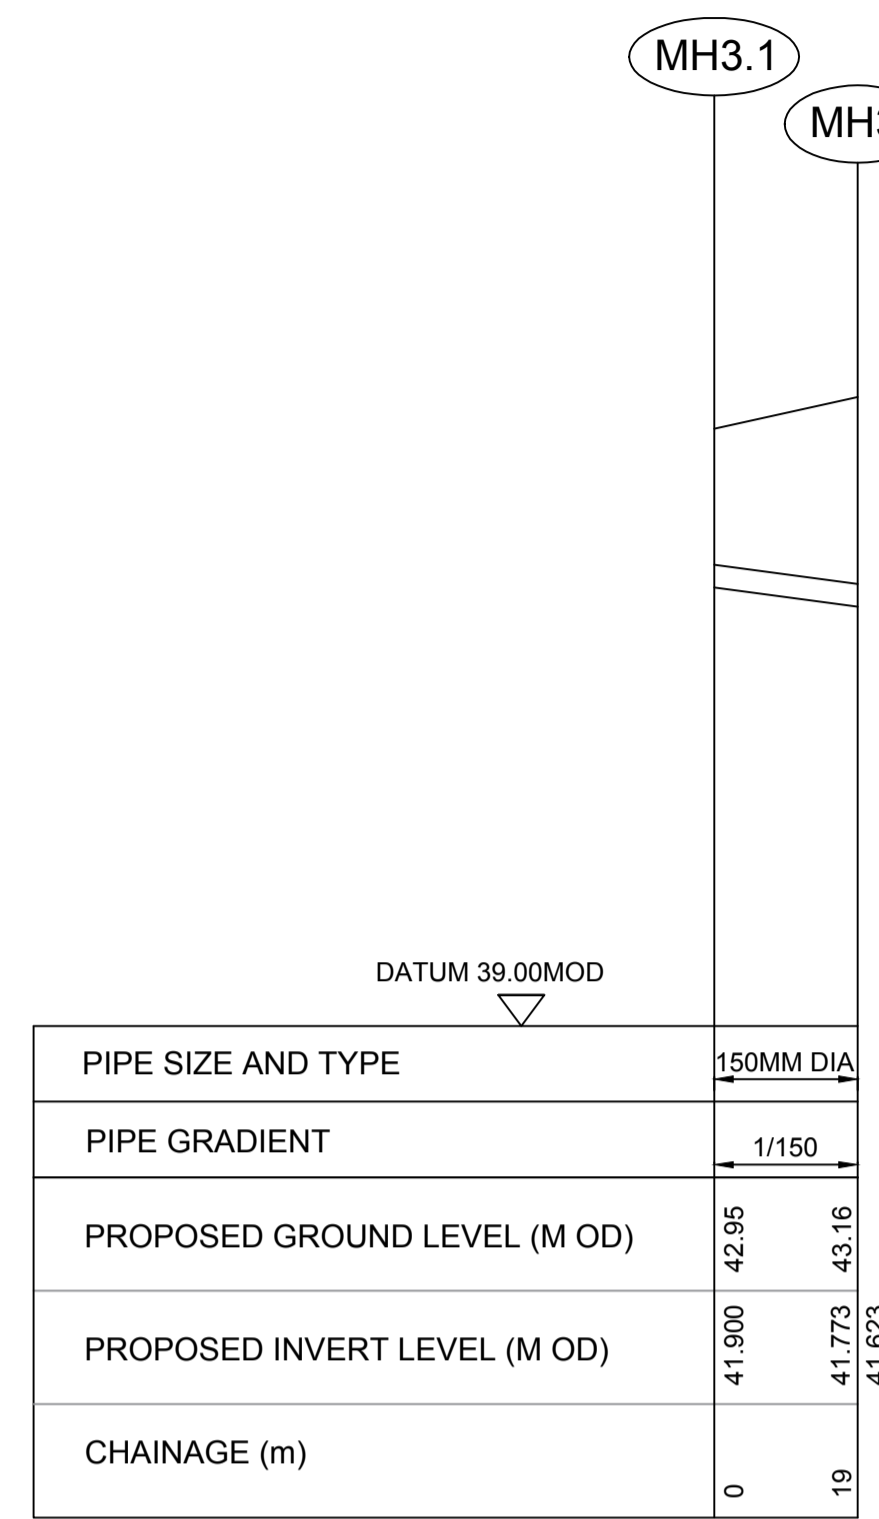

BIOMASS SLAB B: PIPE SECTION - MH3.1 TO MH3
SCALE: HORIZONTAL 1/1000, VERTICAL 1/50

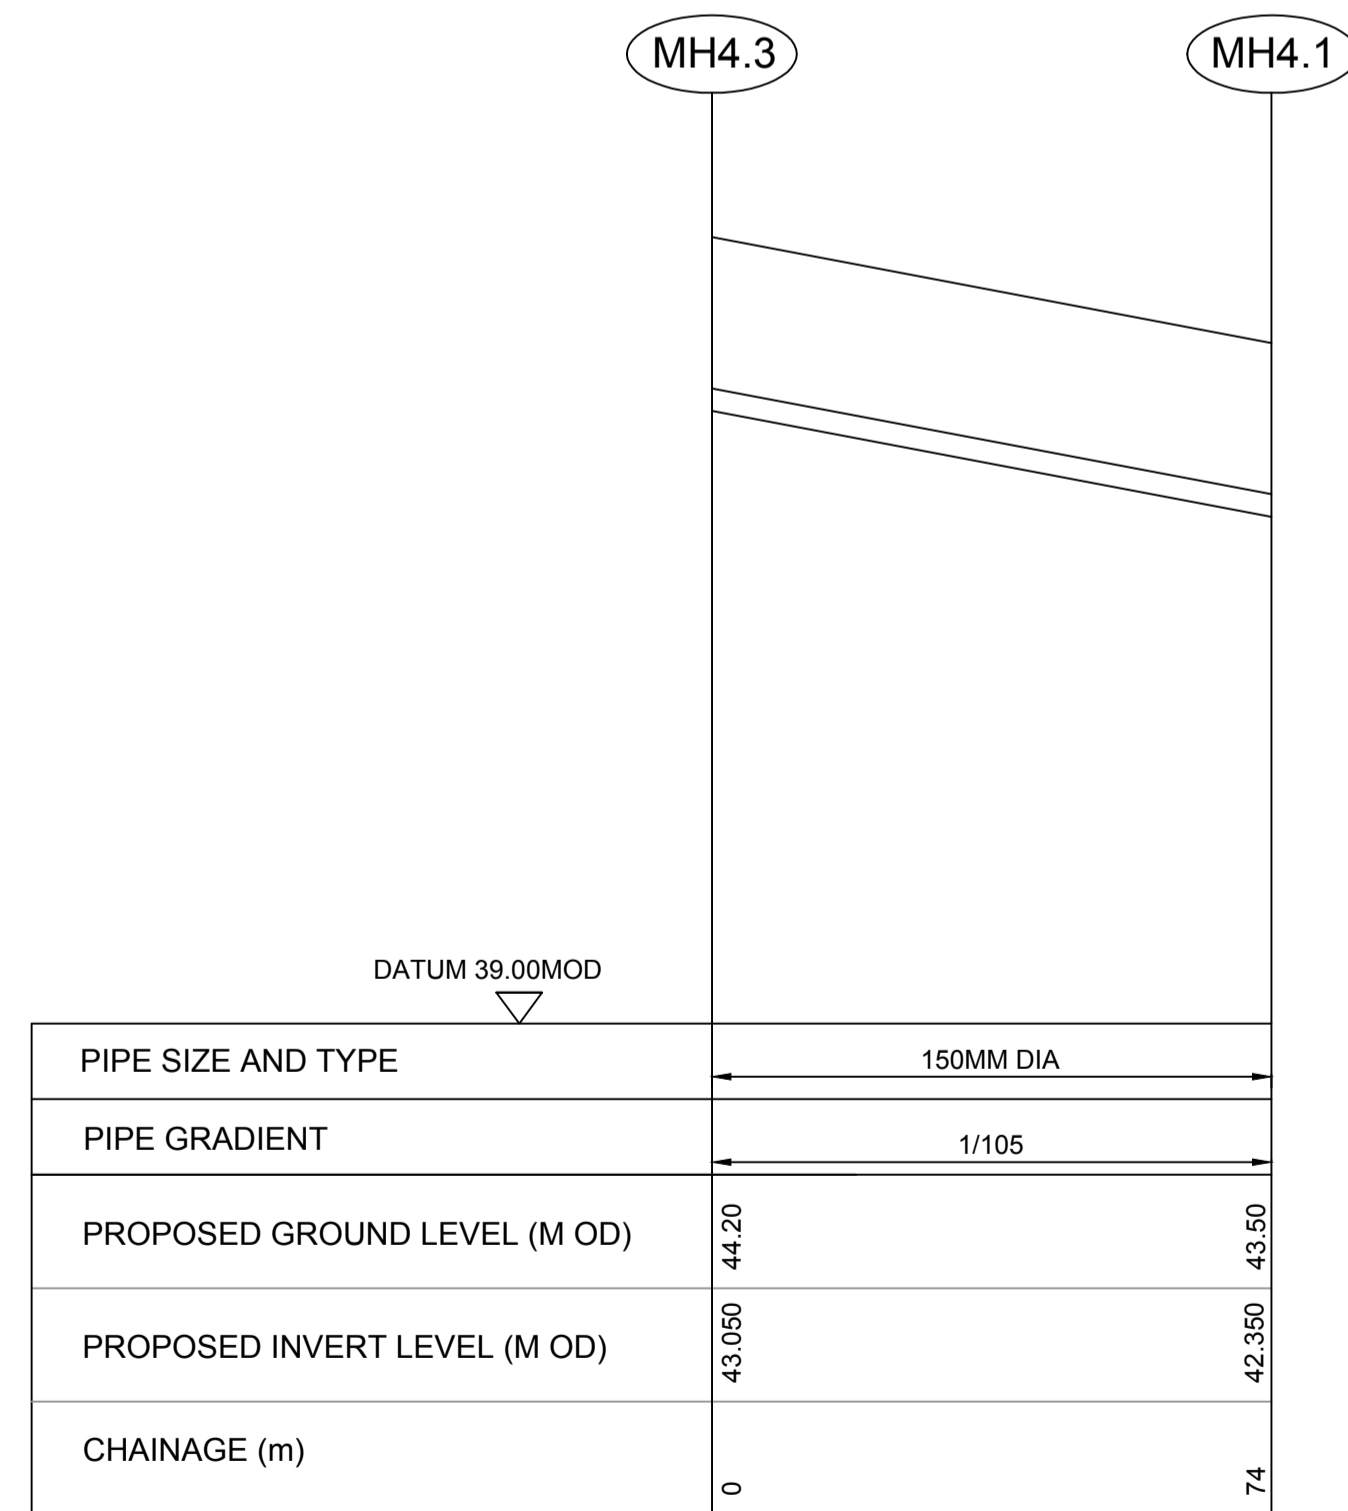

BIOMASS SLAB B: PIPE SECTION - MH4.3 TO MH4.1
SCALE: HORIZONTAL 1/1000, VERTICAL 1/50

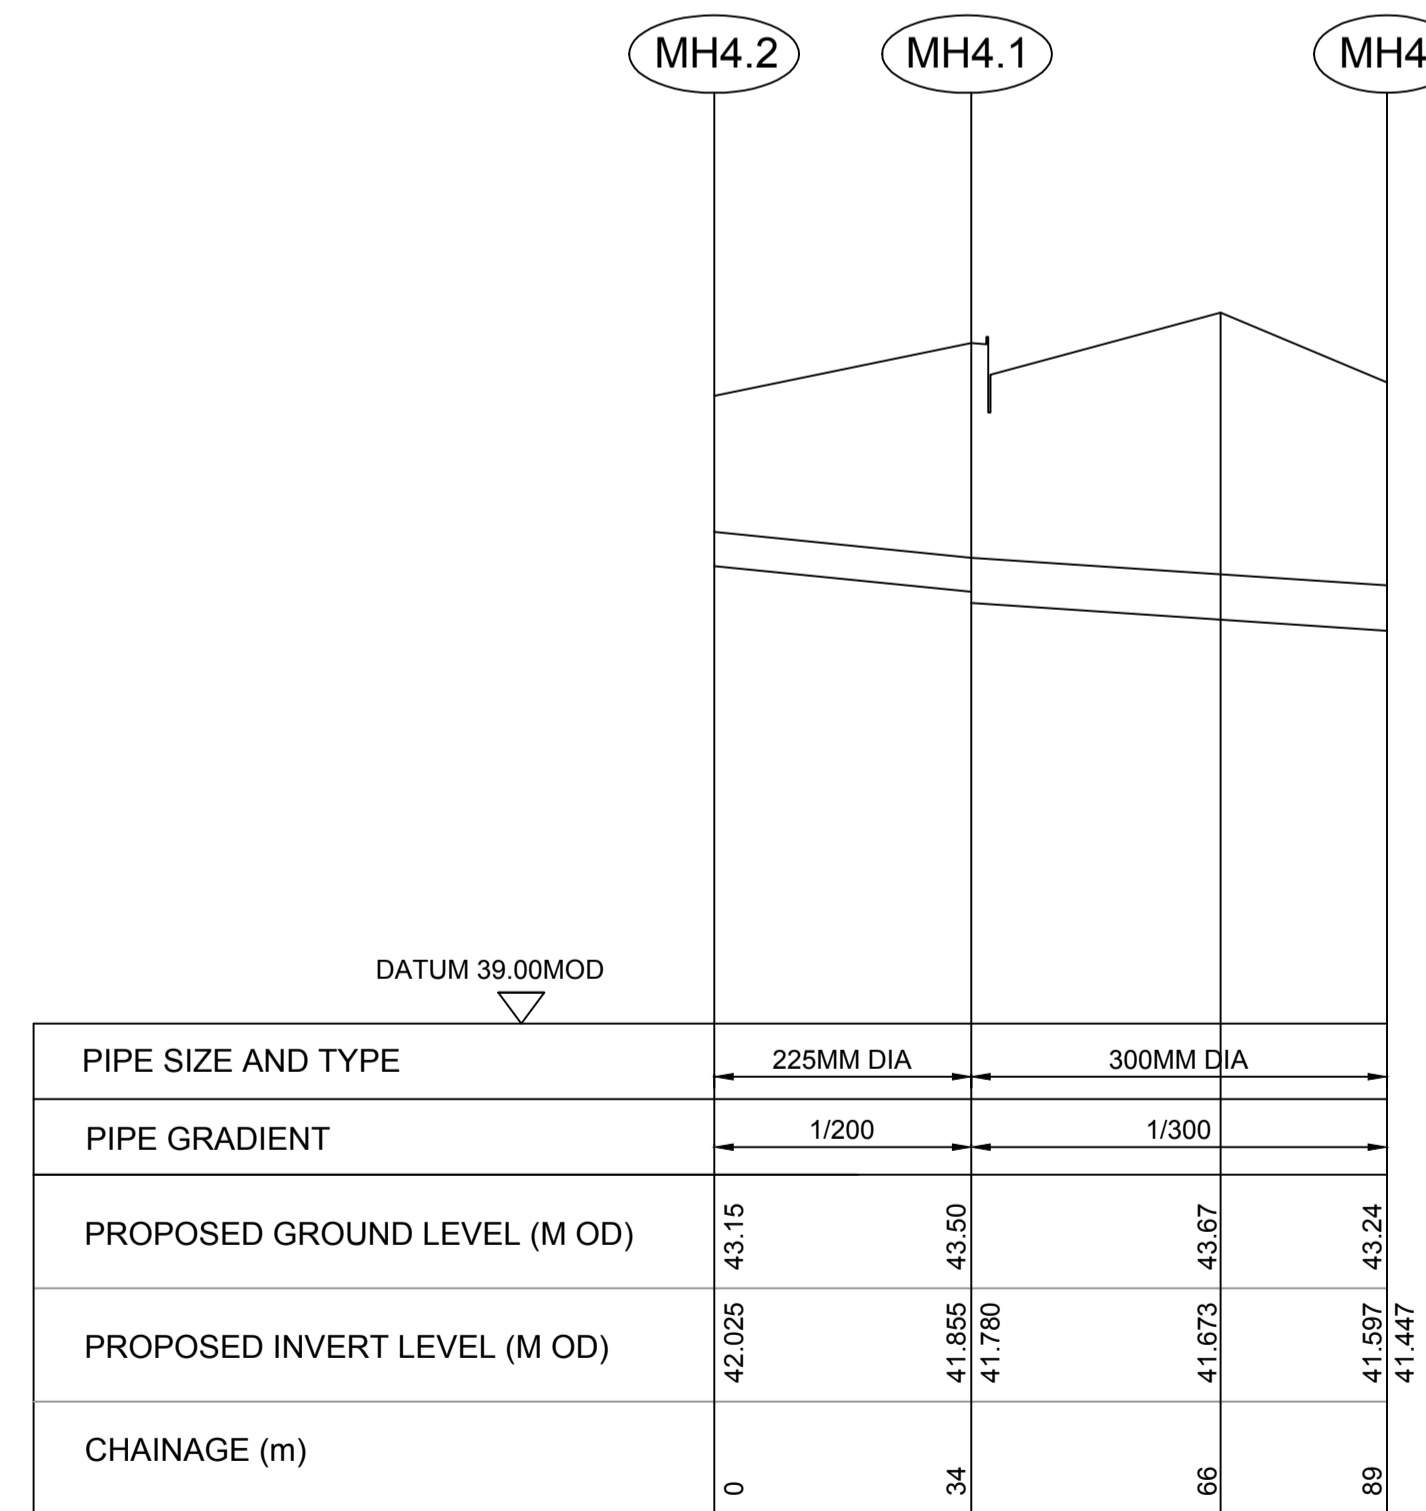

BIOMASS SLAB B: PIPE SECTION - MH4.2 TO MH4
SCALE: HORIZONTAL 1/1000, VERTICAL 1/50

		ESBI		BNM	
0	18.10.18	ISSUED FOR PLANNING			
REV	DATE	REVISION DESCRIPTION	DRN	VER	APP
<small>COPYRIGHT © ESB INTERNATIONAL LIMITED ALL RIGHTS RESERVED. NO PART OF THIS WORK MAY BE MODIFIED, REPRODUCED OR COPIED IN ANY FORM OR BY ANY MEANS - GRAPHIC, ELECTRONIC OR MECHANICAL, INCLUDING PHOTOCOPYING, RECORDING, TAPING OR USED FOR ANY PURPOSE OTHER THAN ITS DESIGNATED PURPOSE, WITHOUT THE WRITTEN PERMISSION OF ESB ENGINEERING & FACILITY MANAGEMENT LTD., TRADING AS ESB INTERNATIONAL.</small>					
PURPOSE OF ISSUE - PRELIMINARY UNLESS INDICATED					
CLIENT APPROVAL	<input type="checkbox"/>	PLANNING	<input checked="" type="checkbox"/>	TENDER	<input type="checkbox"/>
				CONSTRUCTION	<input type="checkbox"/>
				AS-BUILT	<input type="checkbox"/>
CLIENT: ESB					
PROJECT: WEST OFFFALY POWER TRANSITION TO BIOMASS					
<small>ENGINEER DESIGN</small> 			<small>ENGINEER DESIGN</small> 		
CONTRACT: WOP - TRANSITION TO BIOMASS					
DRAWING TITLE: BIOMASS STORAGE SLAB B PROPOSED PIPE SECTIONS					
PRODUCTION UNIT: CIVIL & ENVIRONMENTAL ENGINEERING					
<small>One Dublin Airport Central, Dublin Airport, Cloughran, Co. Dublin Tel: 353 1 703 9000 Email: marketing@esbi.ie Web: www.esbiinternational.ie ESB International is a trading name of ESB Engineering & Facility Management Ltd. Registered Office: as above Registered in Ireland No. 155249</small>					
DRAWN	VERIFIED	APPROVED	APPROVAL DATE		
DK	H. OK	PK	18.10.18		
CLIENT REF	NO. OF SHTS	SIZE	SCALE		
	1	A1	AS SHOWN		
DRAWING NUMBER: QS-000206-01-D460-075					REV: 0