


ORDNANCE SURVEY IRELAND SITE LOCATION MAP
SCALE 1:2500

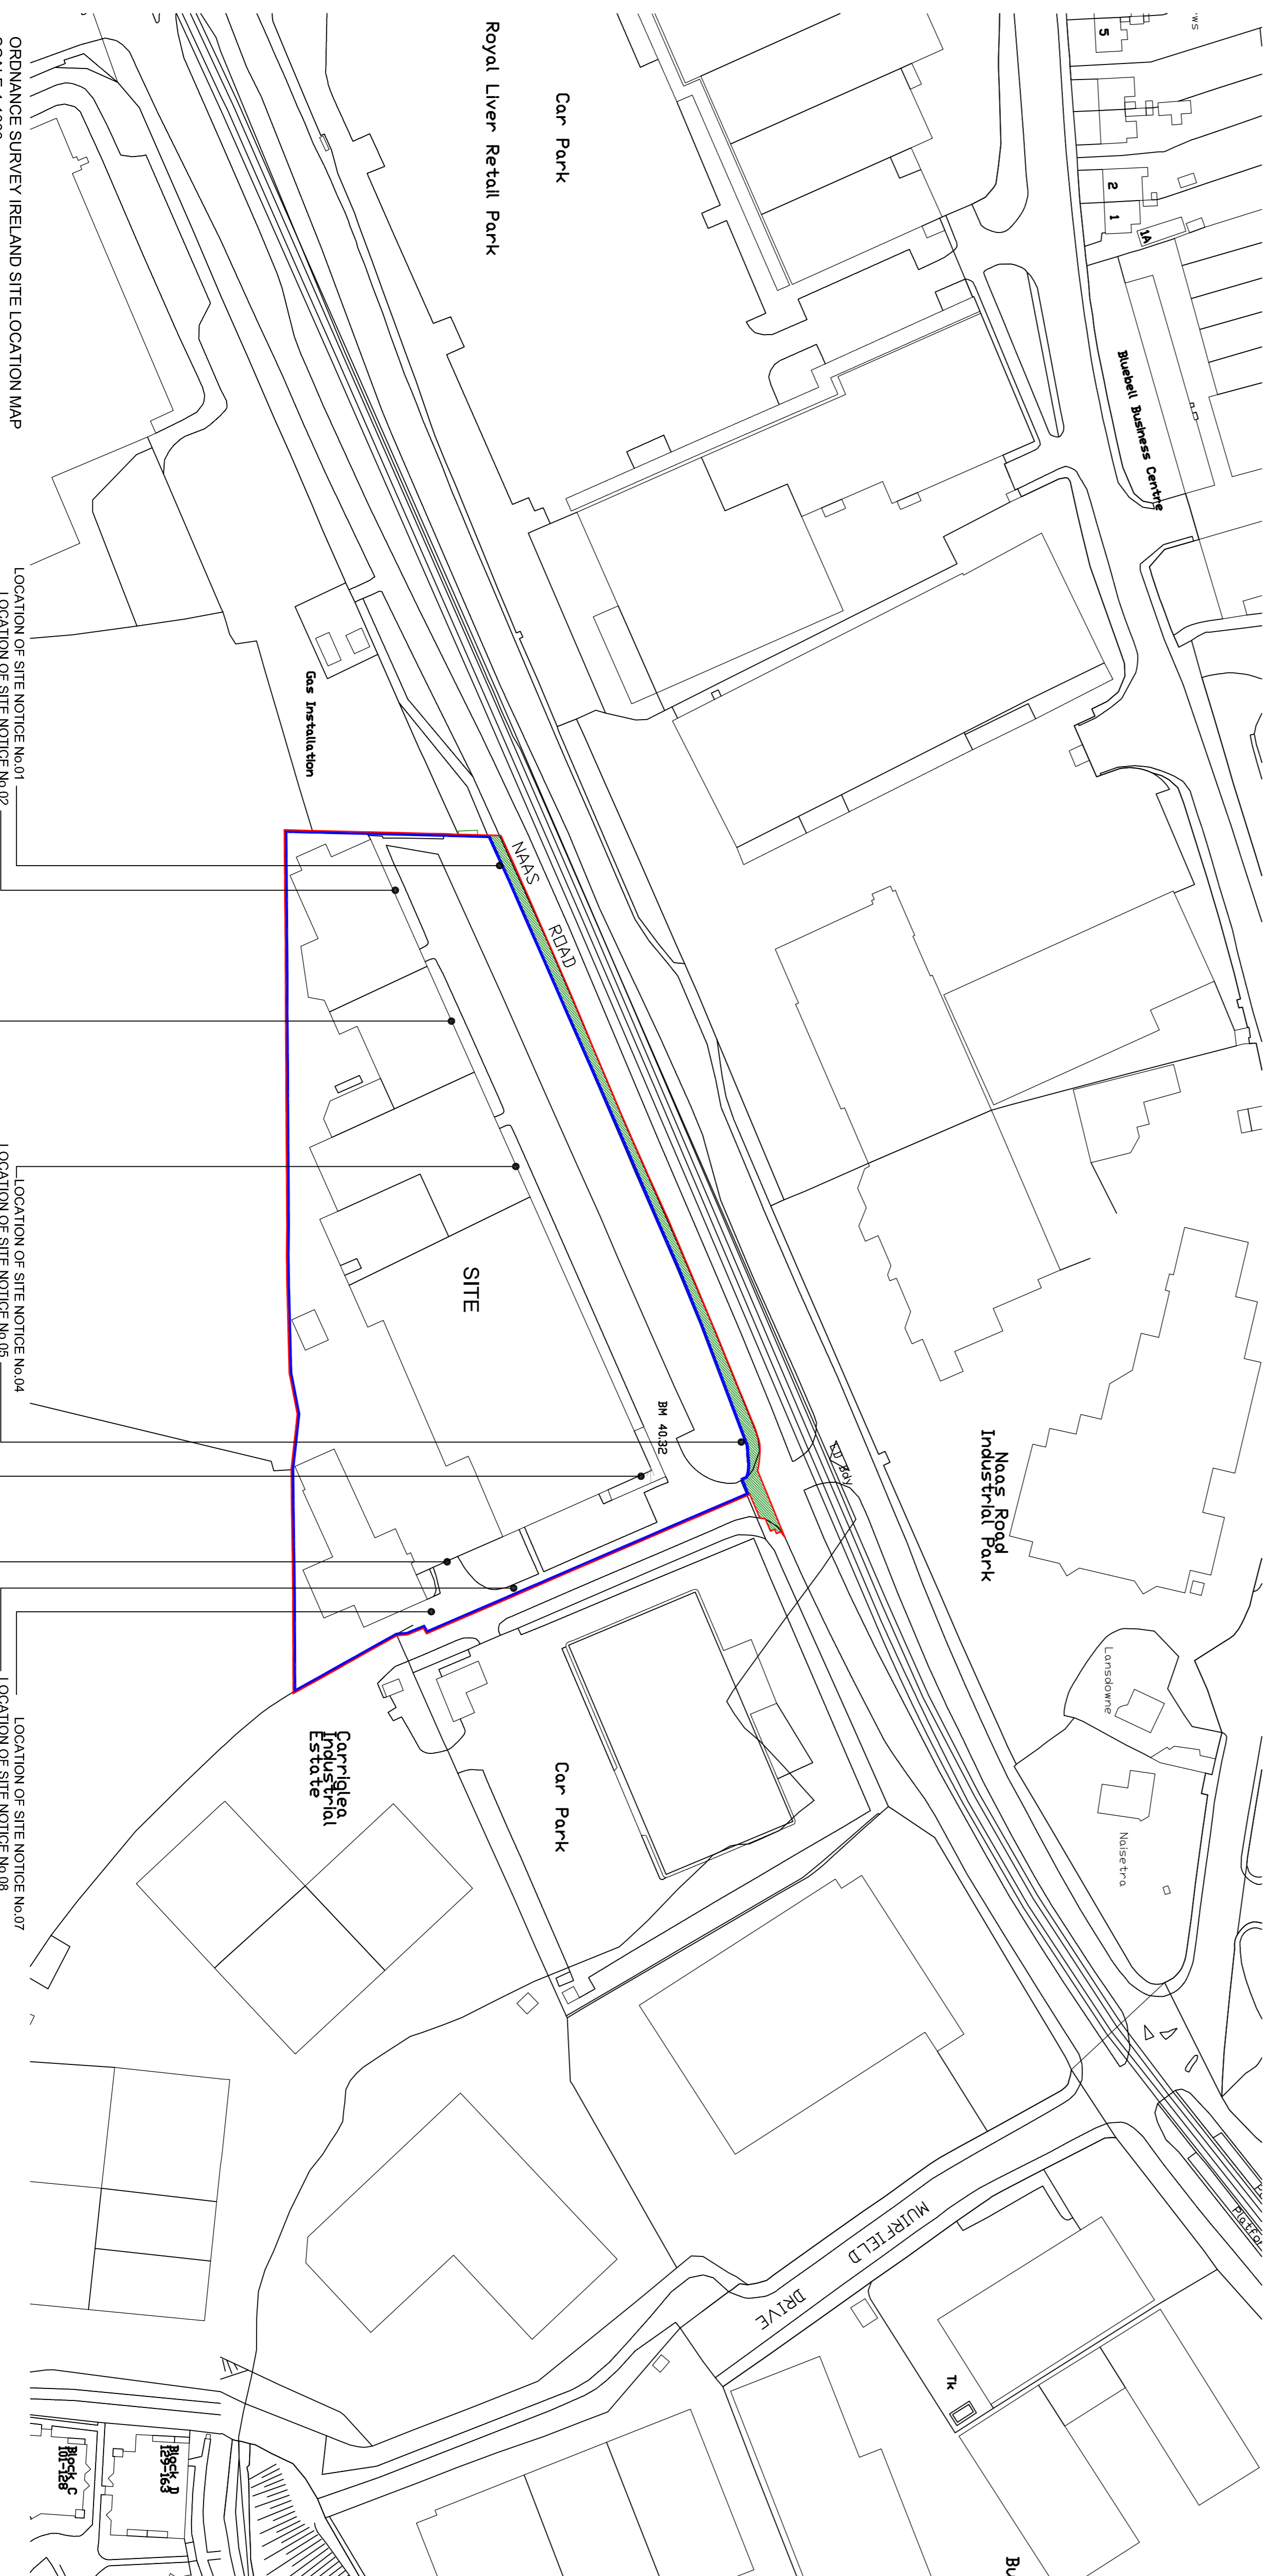

ORDNANCE SURVEY IRELAND SITE LOCATION MAP
SCALE 1:1000

LOCATION OF SITE NOTICE No.01
LOCATION OF SITE NOTICE No.02
LOCATION OF SITE NOTICE No.03
LOCATION OF SITE NOTICE No.04
LOCATION OF SITE NOTICE No.05
LOCATION OF SITE NOTICE No.06
LOCATION OF SITE NOTICE No.07
LOCATION OF SITE NOTICE No.08
LOCATION OF SITE NOTICE No.09

DO NOT SCALE FROM THIS DRAWING. USE FIGURED DIMENSIONS IN ALL CASES. VERIFY DIMENSIONS ON SITE AND REPORT ANY DISCREPANCIES TO THE ARCHITECT. THIS DRAWING IS COPYRIGHT AND MAY ONLY BE REPRODUCED WITH THE ARCHITECTS PERMISSION.

0.S. Data from O.S Sheet Numbers 11-1000:
3327-00327-408208-233208-240208-250327-49-18 hct
DN1710N18N217N22
Ordnance Survey Ireland. Licence No. AP-0052/18
Copyright © 2018 Ordnance Survey of Great Britain
All levels are given in metres and are referred to
O.S. datum (Mean High Co. Doregal) (1970 Adjustment)

LEGEND

PROPOSED DEVELOPMENT BOUNDARY	
PROPOSED DEVELOPMENT FOOTPRINT	
EXISTING DEVELOPMENT BOUNDARY	
EXISTING DEVELOPMENT FOOTPRINT	
PROPOSED ROAD BOUNDARY	
PROPOSED ROAD FOOTPRINT	
PROPOSED SIDEWALK BOUNDARY	
PROPOSED SIDEWALK FOOTPRINT	

PLANNING

REV	DATE	BY	ISSUE
002	2017.03.14	AM	PRELIMINARY SUBMITTAL TO ADP
001	2017.01.18	AM	PRELIMINARY SUBMITTAL TO DDC



red dy architecture+urbanism
 Design Architects + Urbanism
 Darryl Hill, Darryl Road, Dublin 4
 T: +353 (0)1 4867000
 E: dhill@redarchitecture.com
 R: hill@redarchitecture.com

3.1 PLANNING

JOB
MIXED USE RESIDENTIAL & COMMERCIAL DEVELOPMENT CONCORDE INDUSTRIAL ESTATE NAAS RD DUBLIN 12

CLIENT
DEVELOPMENT OCHT LIMITED

DRAWING
SITE LOCATION MAP

DATE: 07/11/2018
 SCALE: 1:1000 / 1:2500
 DRN: A.Mulphy
 CHECKED: K.Kaplanjannis
 JOB NO.: DWG NO.
P18 - 0622D-RAU-ZZ-ZZ-DR-A-MPL-31001