




01 Storm Drainage Long Sect
SCALE 1:1000

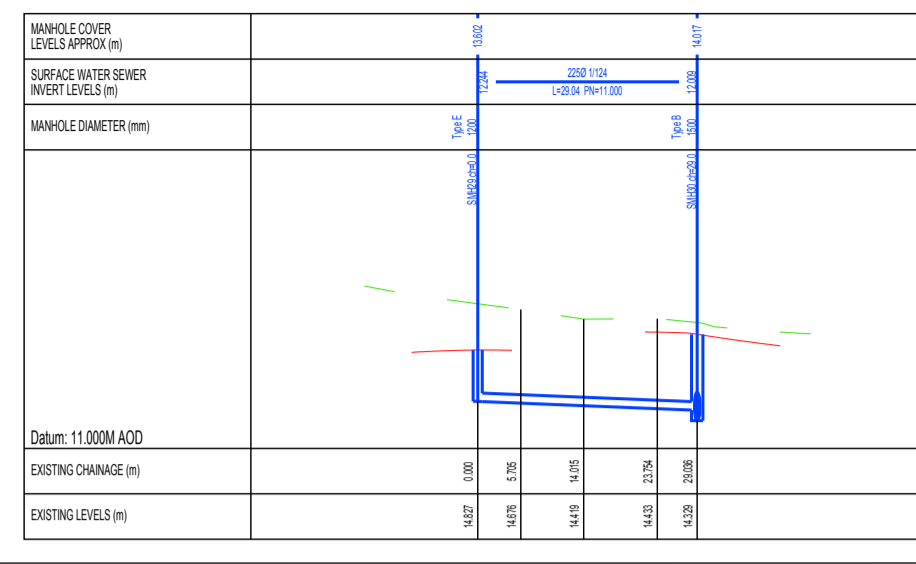


02 Storm Drainage Long Sect
SCALE 1:1000

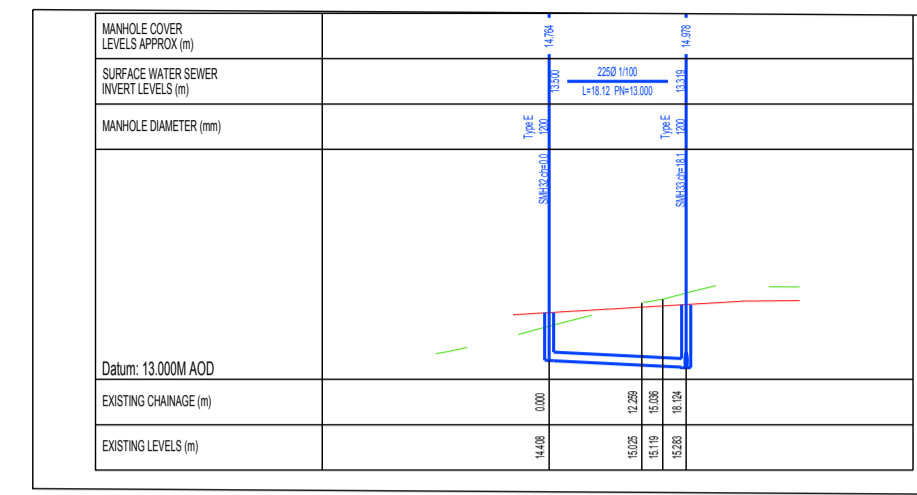


03 Storm Drainage Long Sect
SCALE 1:1000

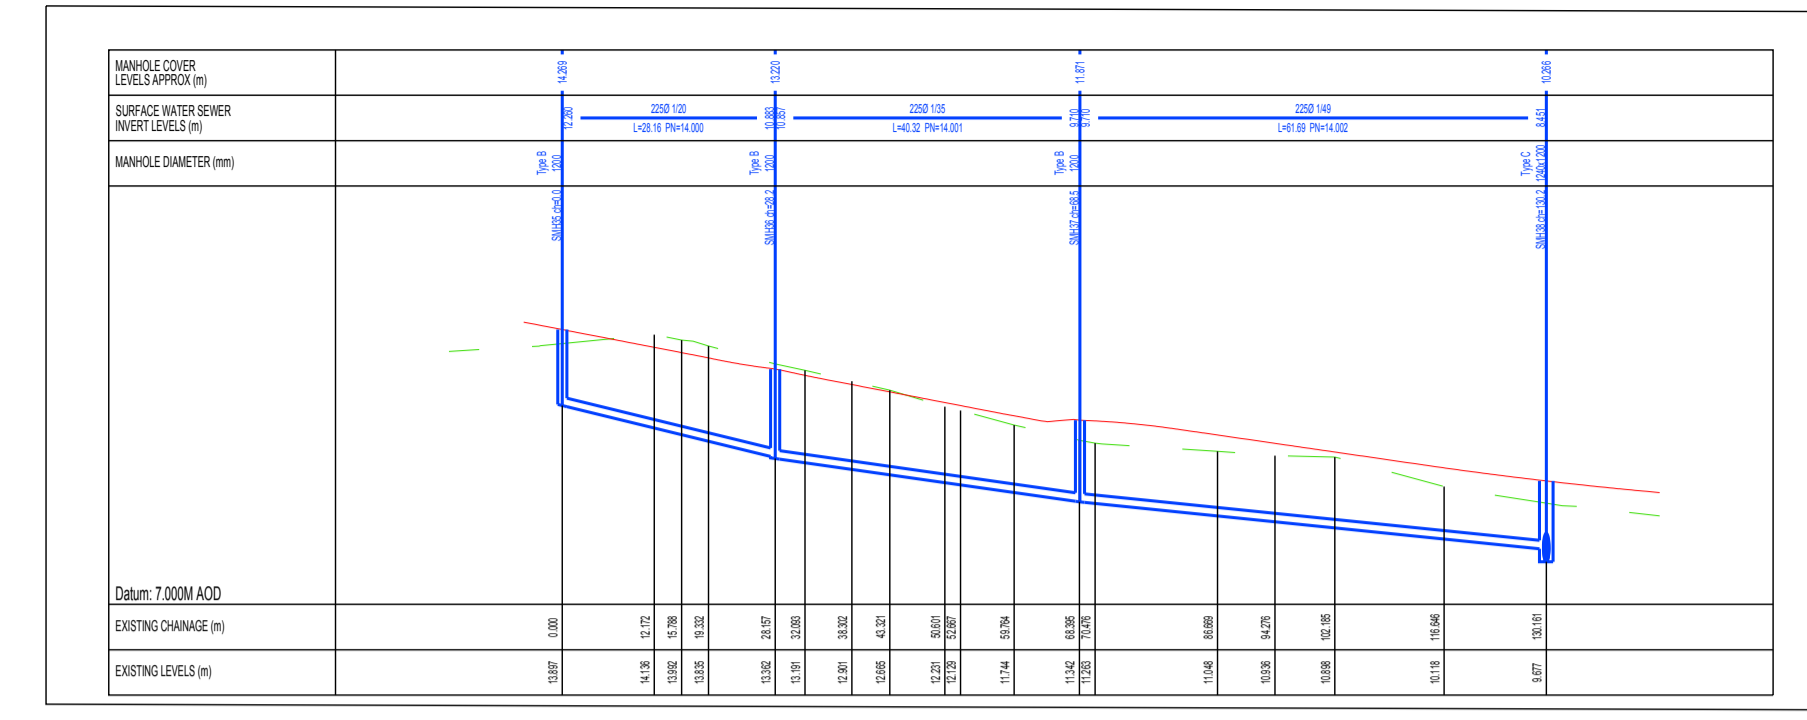


04 Storm Drainage Long Sect
SCALE 1:1000

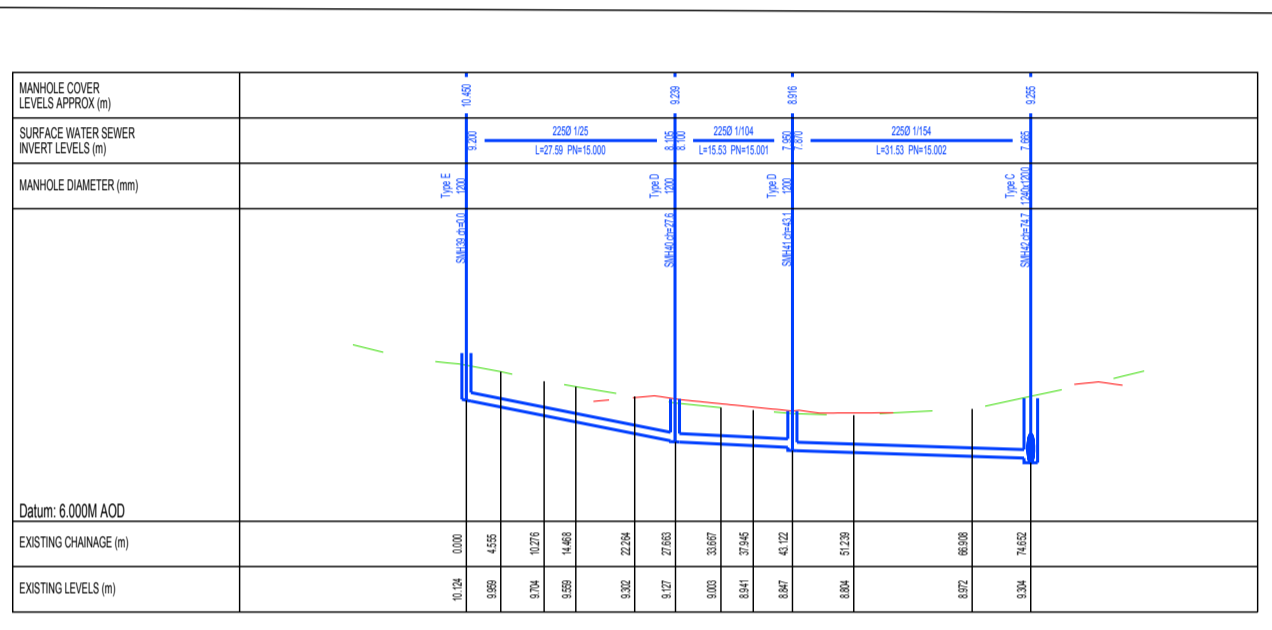


05 Storm Drainage Long Sect
SCALE 1:1000

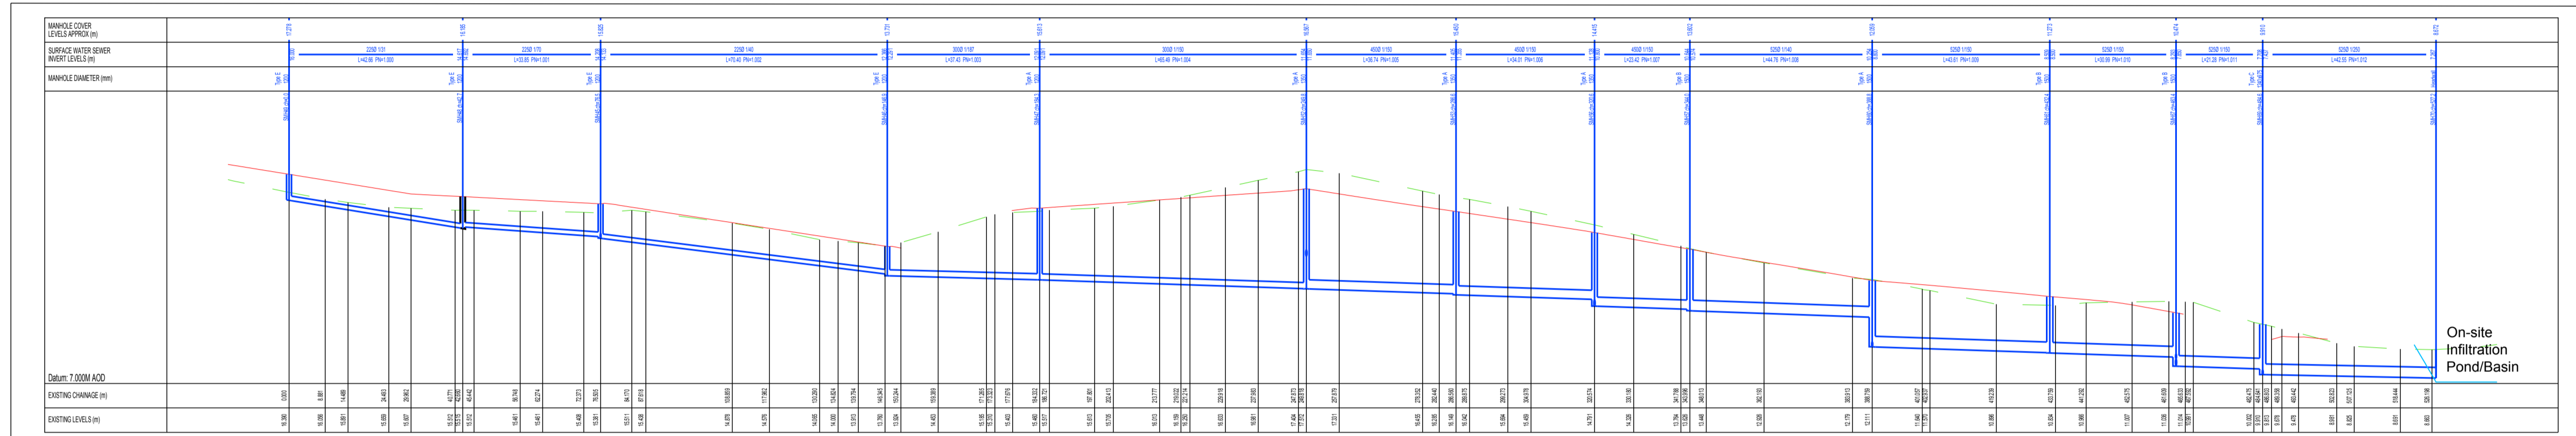


06 Storm Drainage Long Sect
SCALE 1:1000

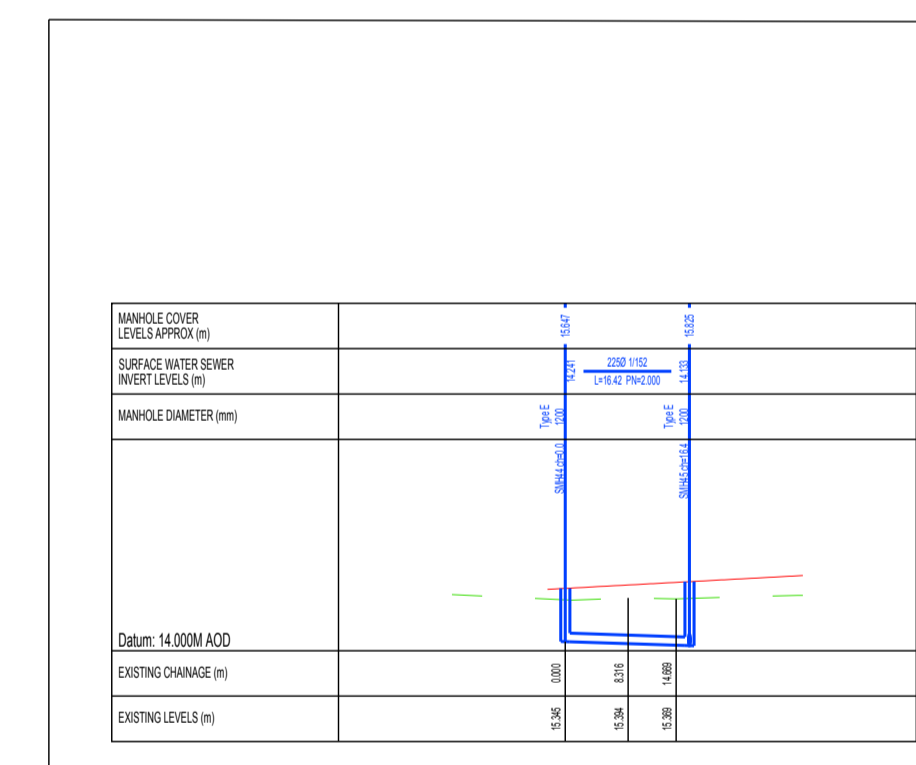


07 Storm Drainage Long Sect
SCALE 1:1000

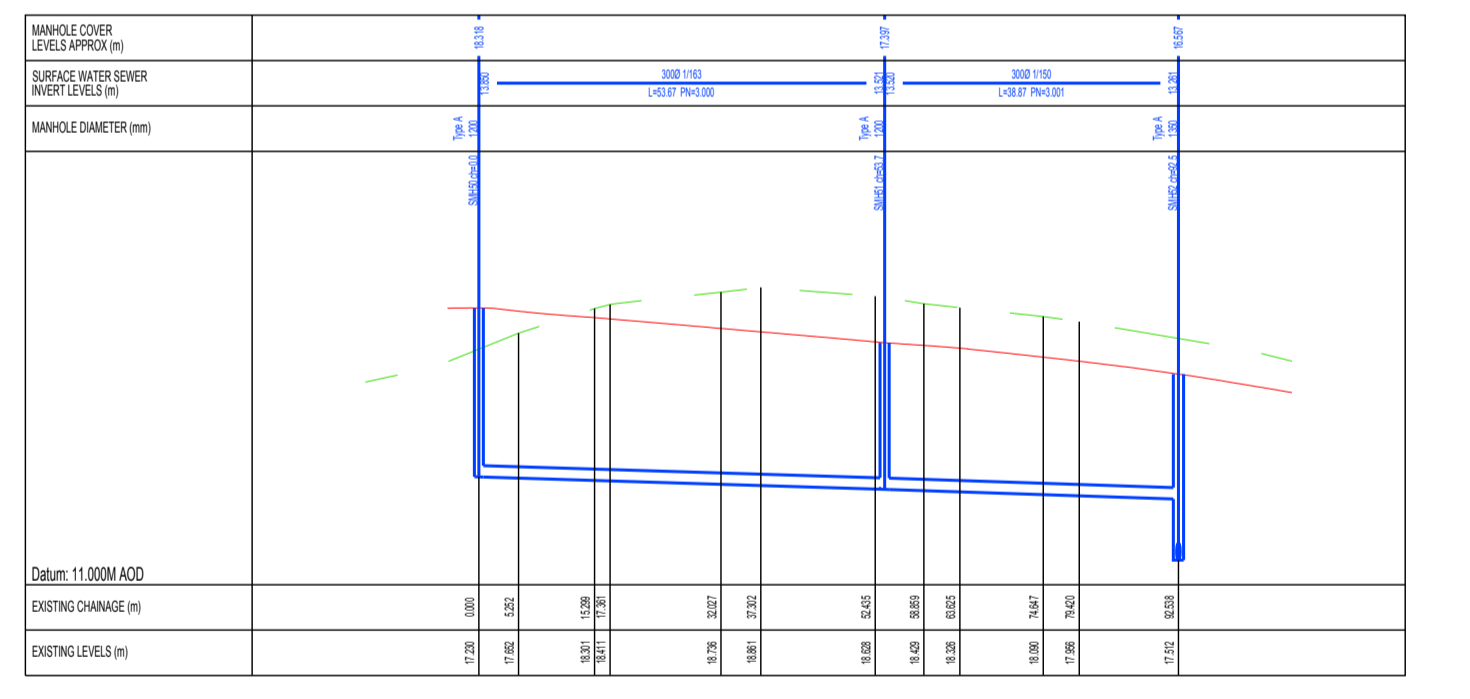


08 Storm Drainage Long Sect
SCALE 1:1000

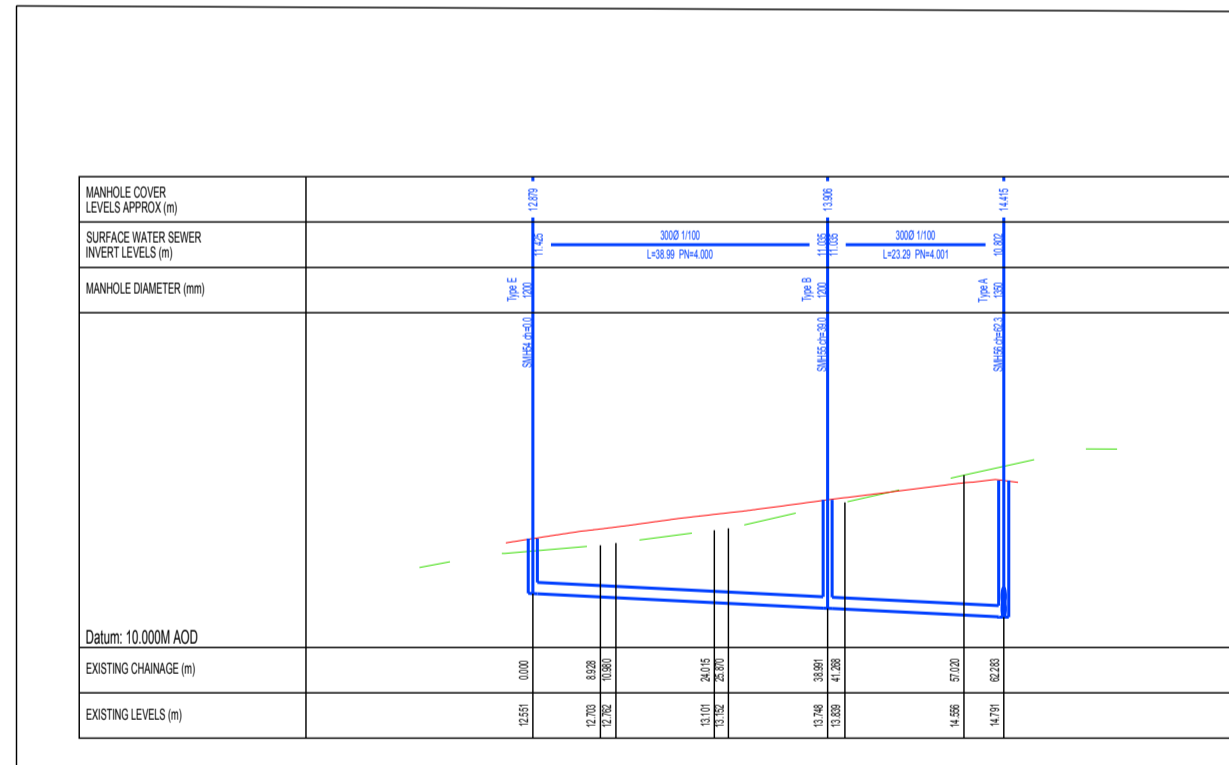


09 Storm Drainage Long Sect
SCALE 1:1000

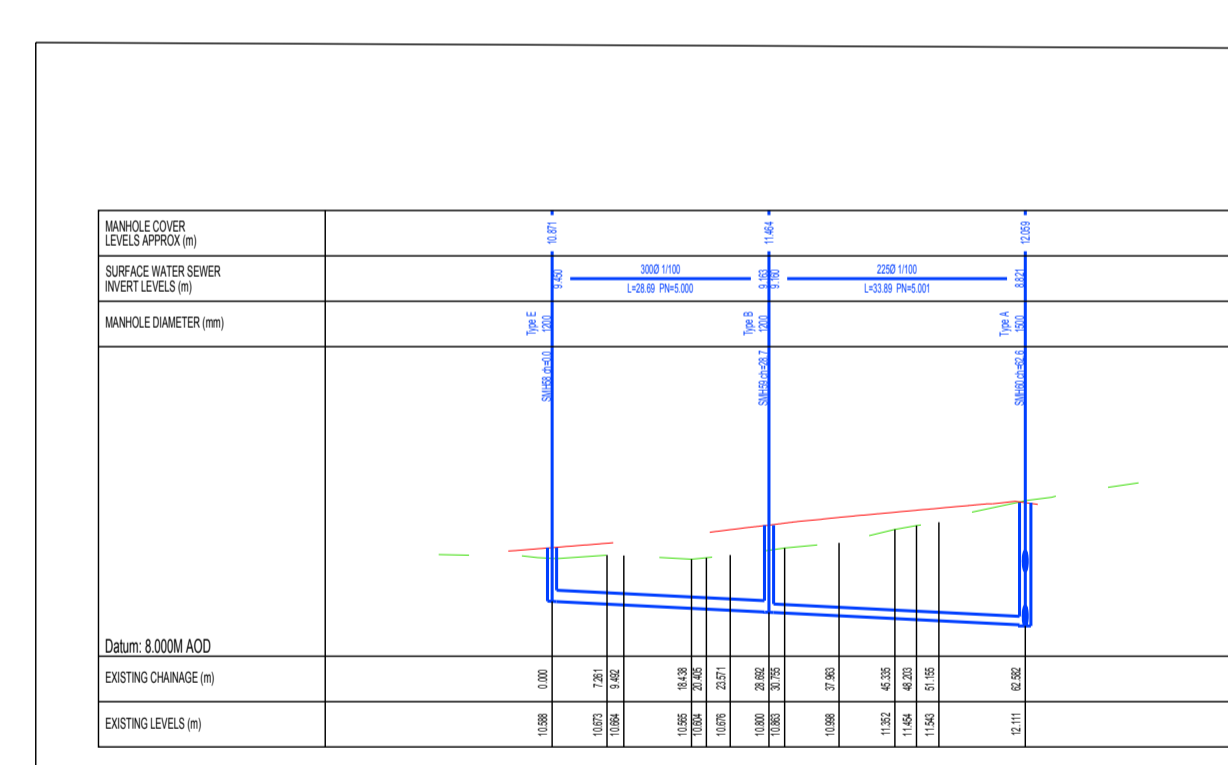


10 Storm Drainage Long Sect
SCALE 1:1000

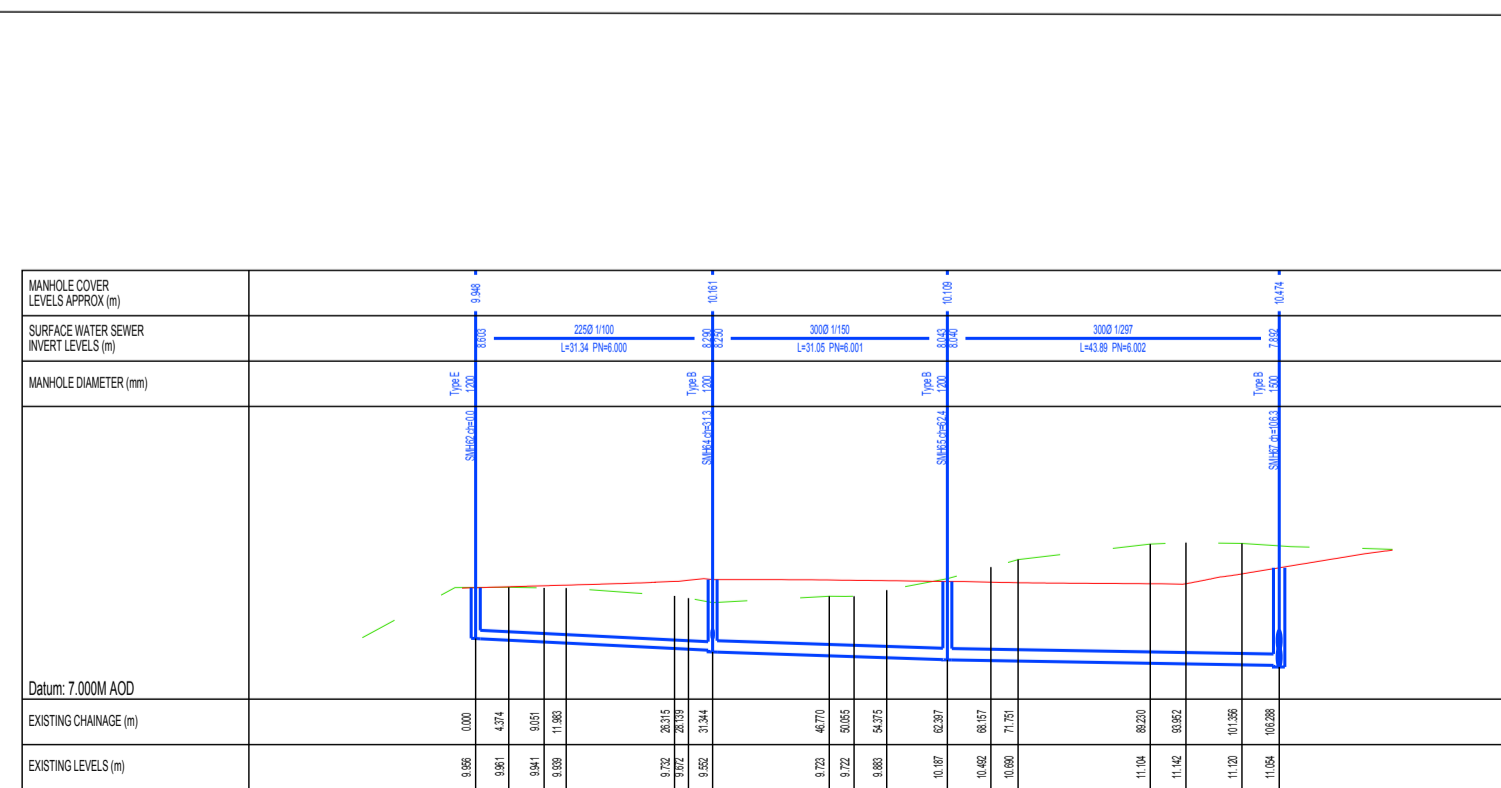


11 Storm Drainage Long Sect
SCALE 1:1000

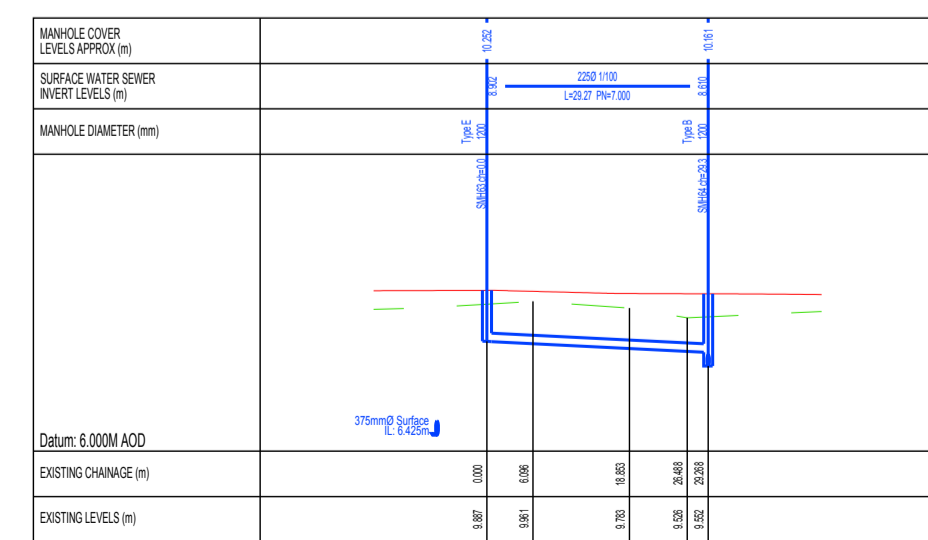

12 Storm Drainage Long Sect
SCALE 1:1000

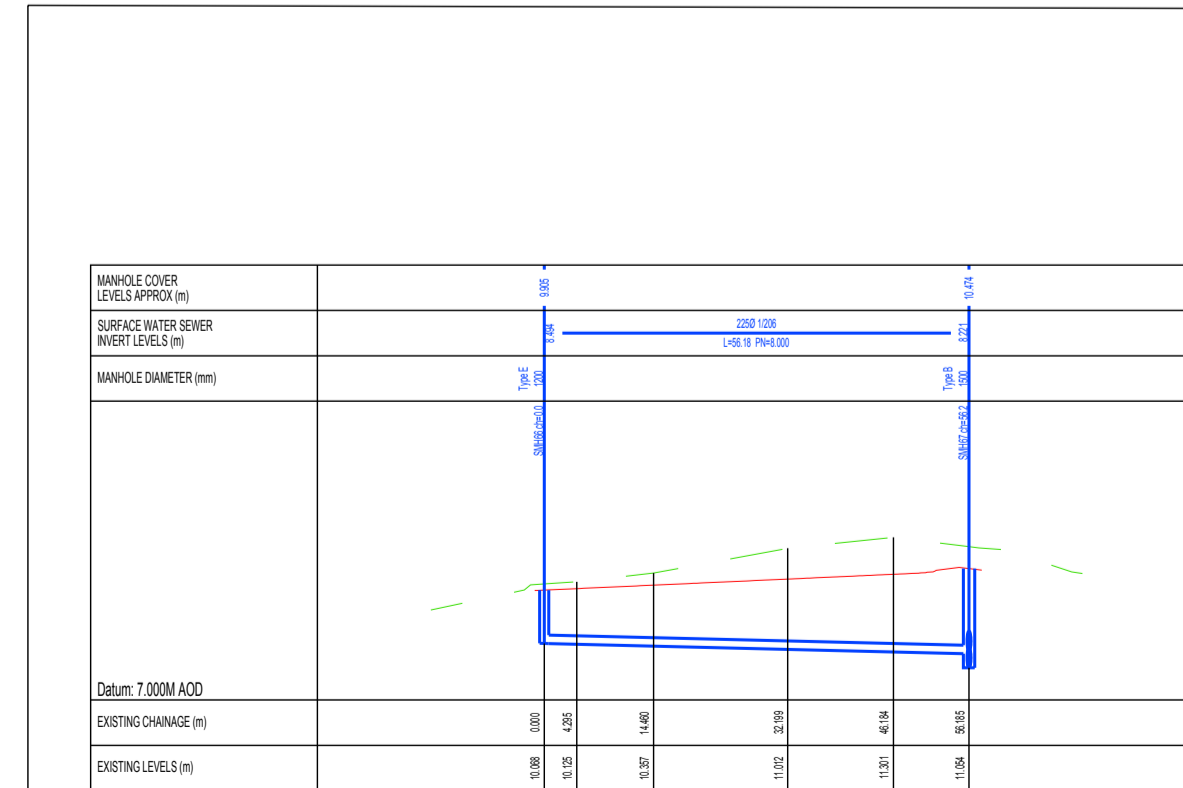

13 Storm Drainage Long Sect
SCALE 1:1000

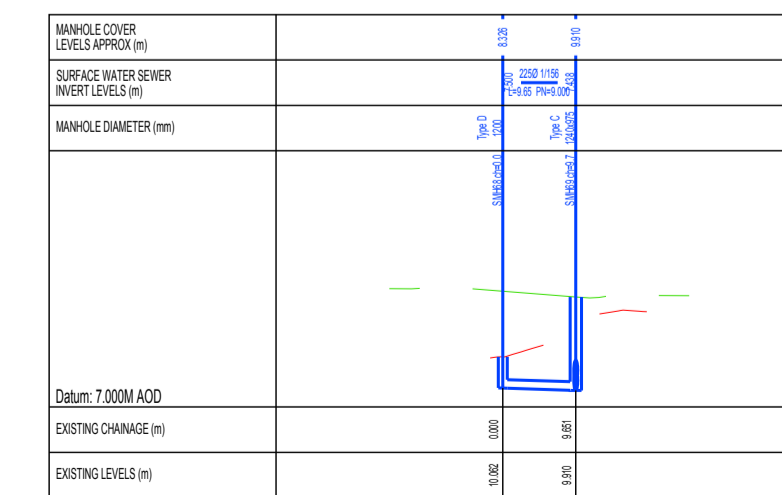

14 Storm Drainage Long Sect
SCALE 1:1000

A	Issued for Planning	May 2019	T. Finn
REV. NO.	DESCRIPTION	DATE	INITIALS

finn
DESIGN PARTNERSHIP
CREATIVE • INNOVATIVE

Blakestown, Ardee, Co. Louth, Ireland
t 041 6857200 f 041 6857201 e info@finn.ie w www.finn.ie

DRAWING NO: **118** REV. NO: **A**

TITLE: Storm Drainage
Longitudinal Sections (Sheet 2 of 3)

PROJECT: Residential Development @
Haggardstown, Blackrock, Dundalk

CLIENT: Kingsbridge Consultancy Ltd
1st Floor Quayside Business Park
Mill Street, Dundalk, Co Louth.

SCALE: 1:1000 @ A1 DRAWN: A. Armstrong

DATE: November 2018 CHECKED: -

STATUS: **Planning Permission**

JOB NO: **1703**

NOTES:
1. Copyright Reserved 2003 ©
2. Work to figure dimensions only. Do not scale drawing.
3. The contractor is responsible for checking all levels and dimensions on site and shall refer all discrepancies to the Architect.
4. Where appropriate, for details of c. structure, or mechanical and electrical details, see Engineers drawings.
5. Proprietary items shall be fixed in place accordance with manufacturers instructions.
6. Scale of preliminary items shall be checked with manufacturer.
7. The contractor shall be responsible for the coordination of structure, finishes and services.

CIVIL STRUCTURAL ENGINEERING PROJECT MANAGEMENT