




01 Foul Drainage Long Sect
128 SCALE 1:1000

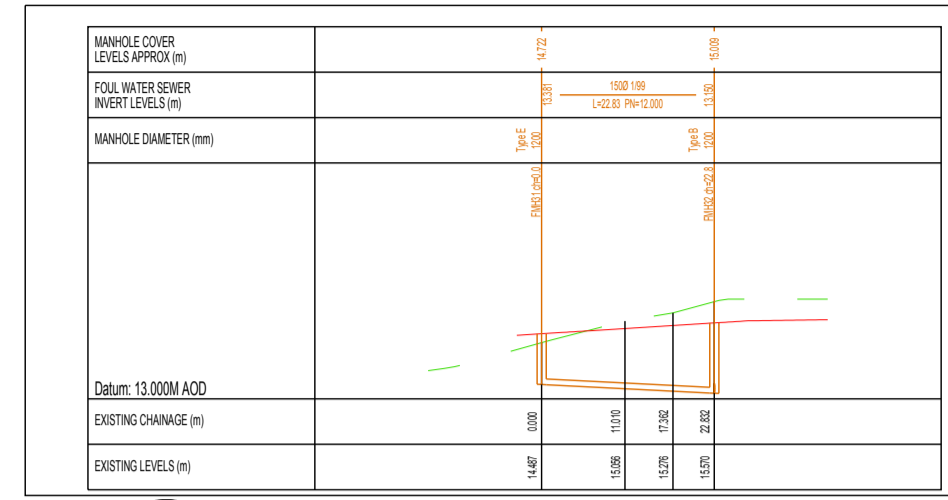


02 Foul Drainage Long Sect
128 SCALE 1:1000

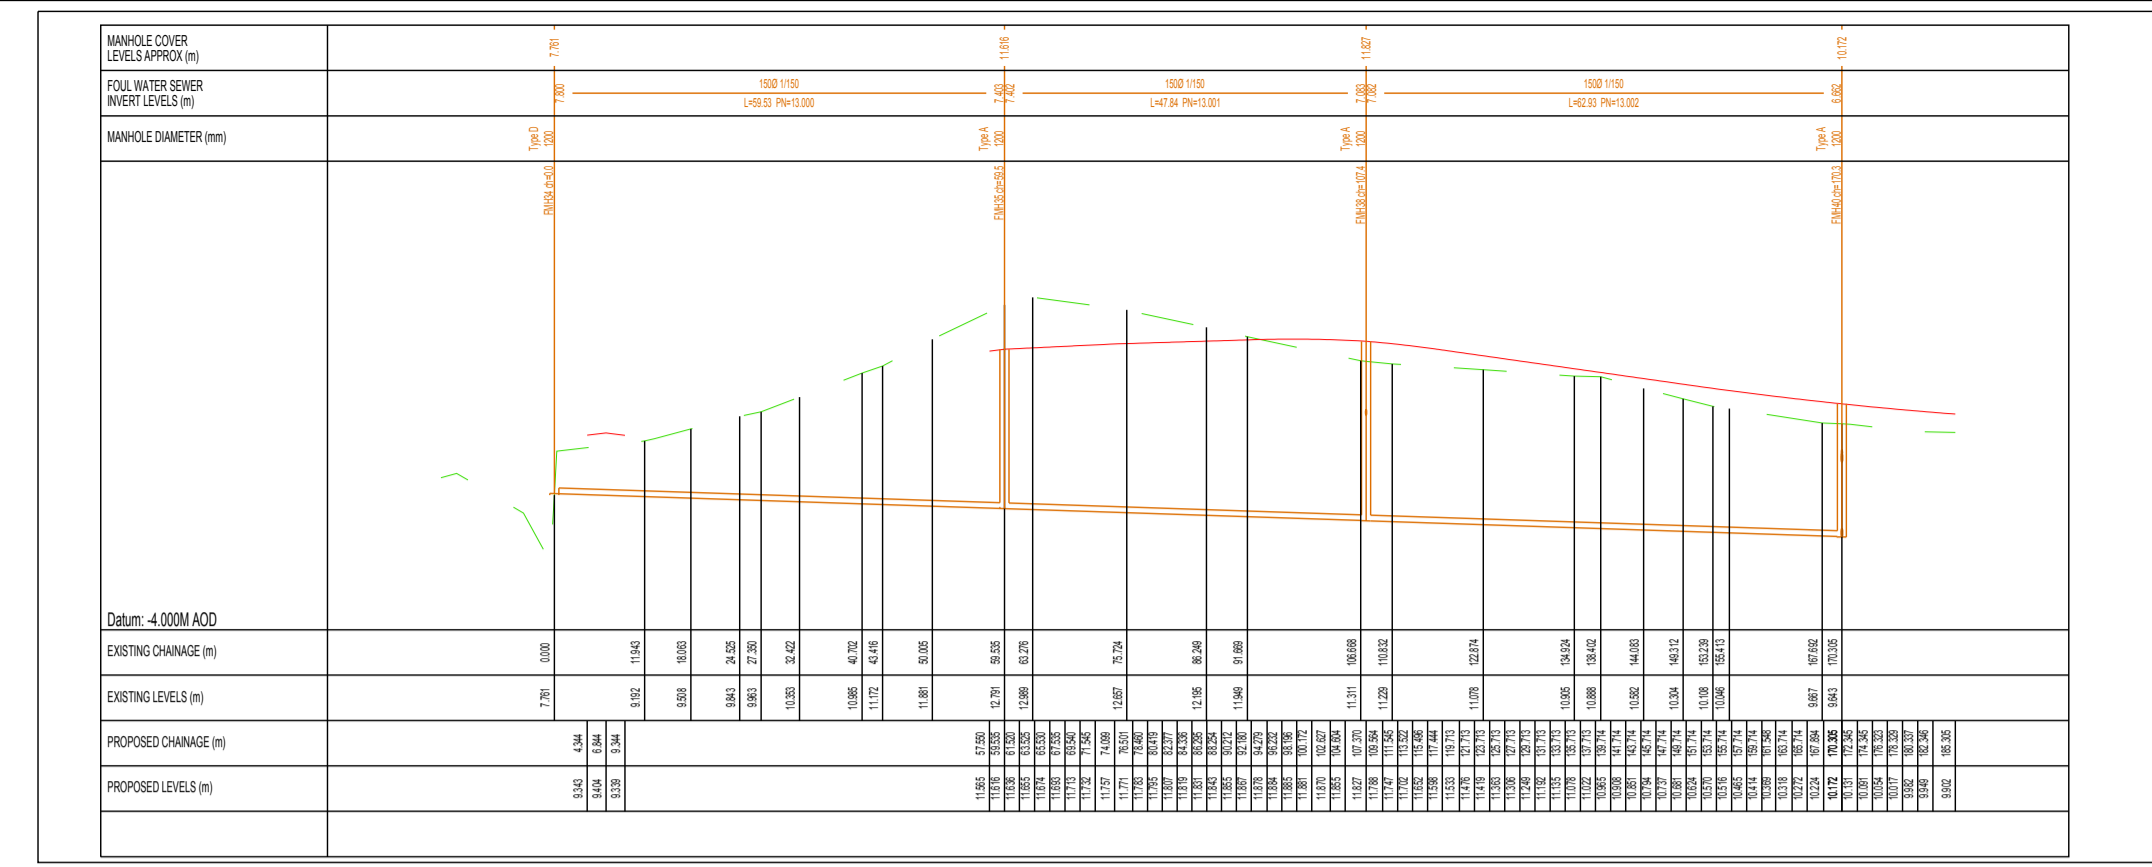


03 Foul Drainage Long Sect
128 SCALE 1:1000

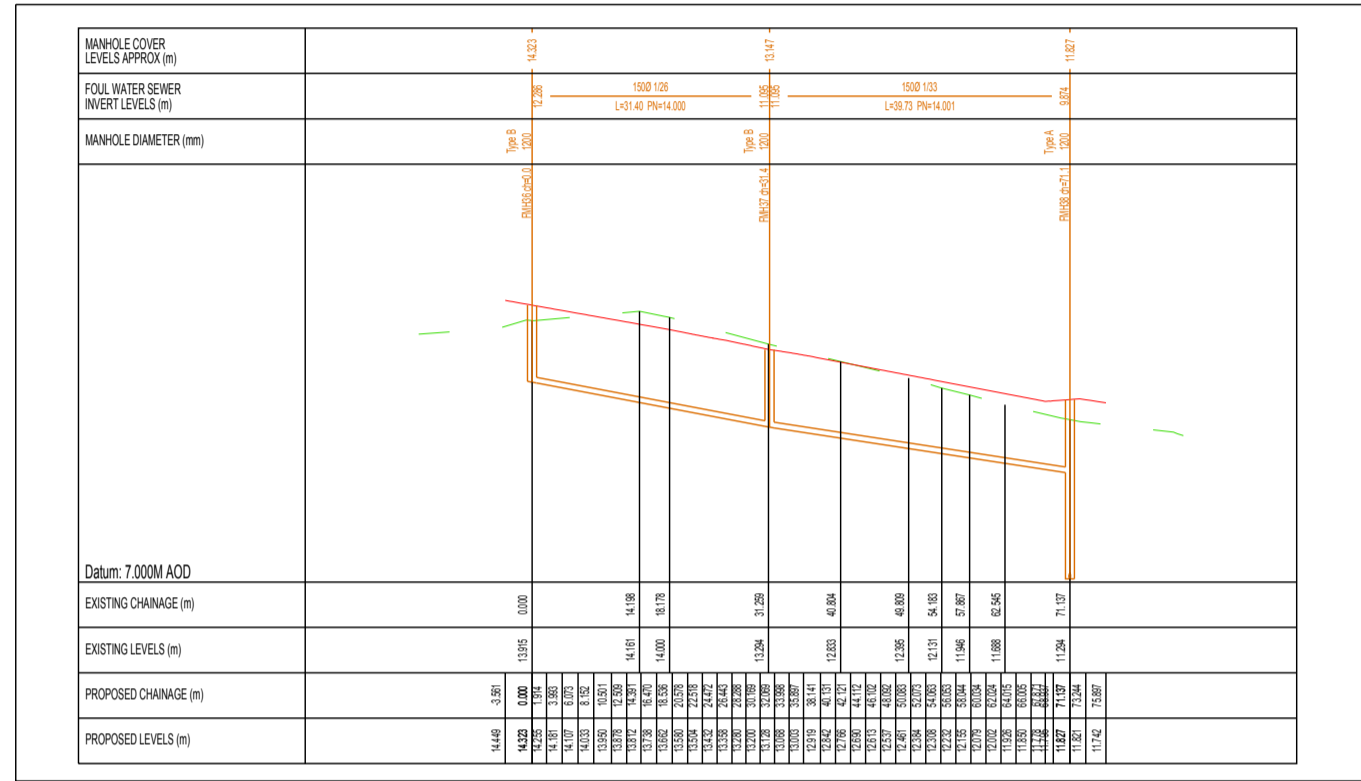


04 Foul Drainage Long Sect
128 SCALE 1:1000

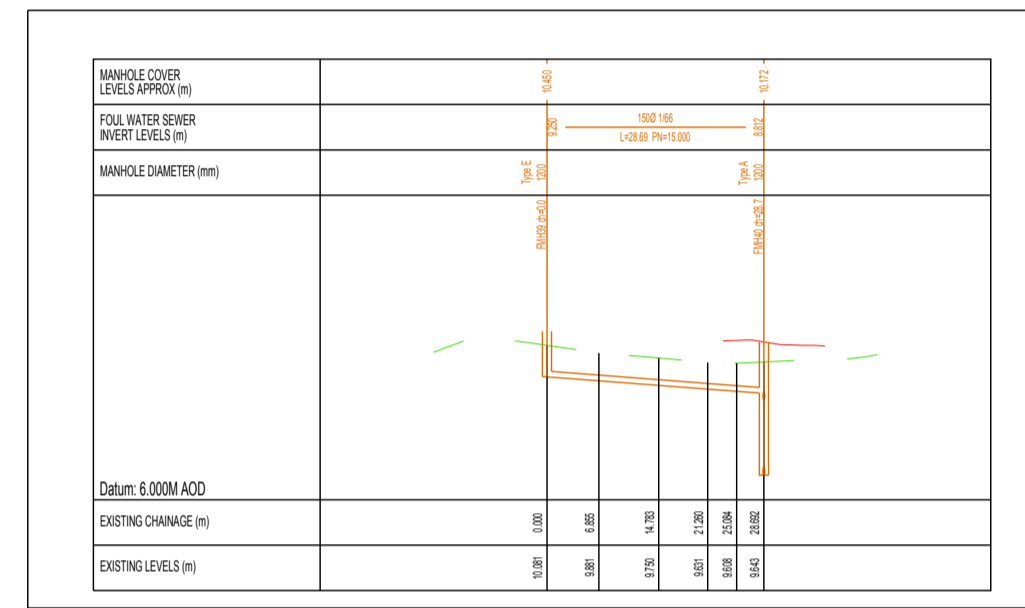

05 Foul Drainage Long Sect
128 SCALE 1:1000

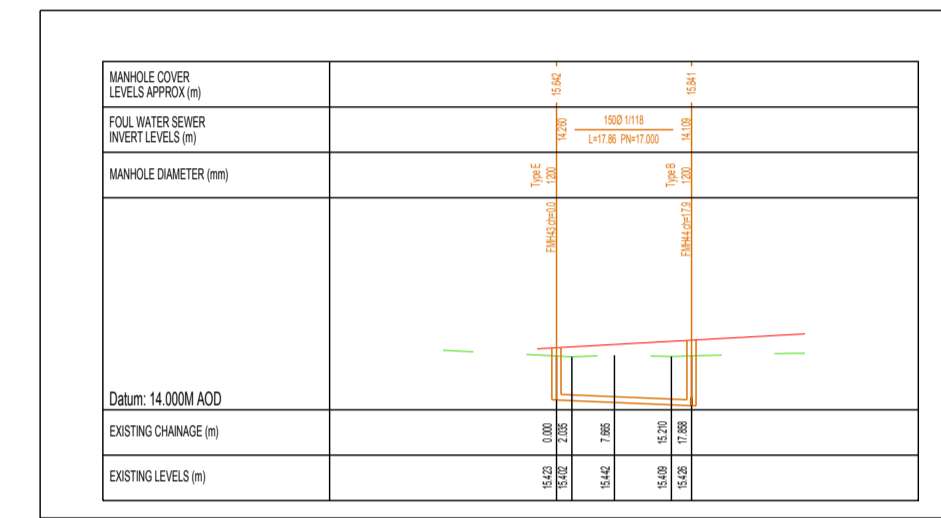


06 Foul Drainage Long Sect
128 SCALE 1:1000

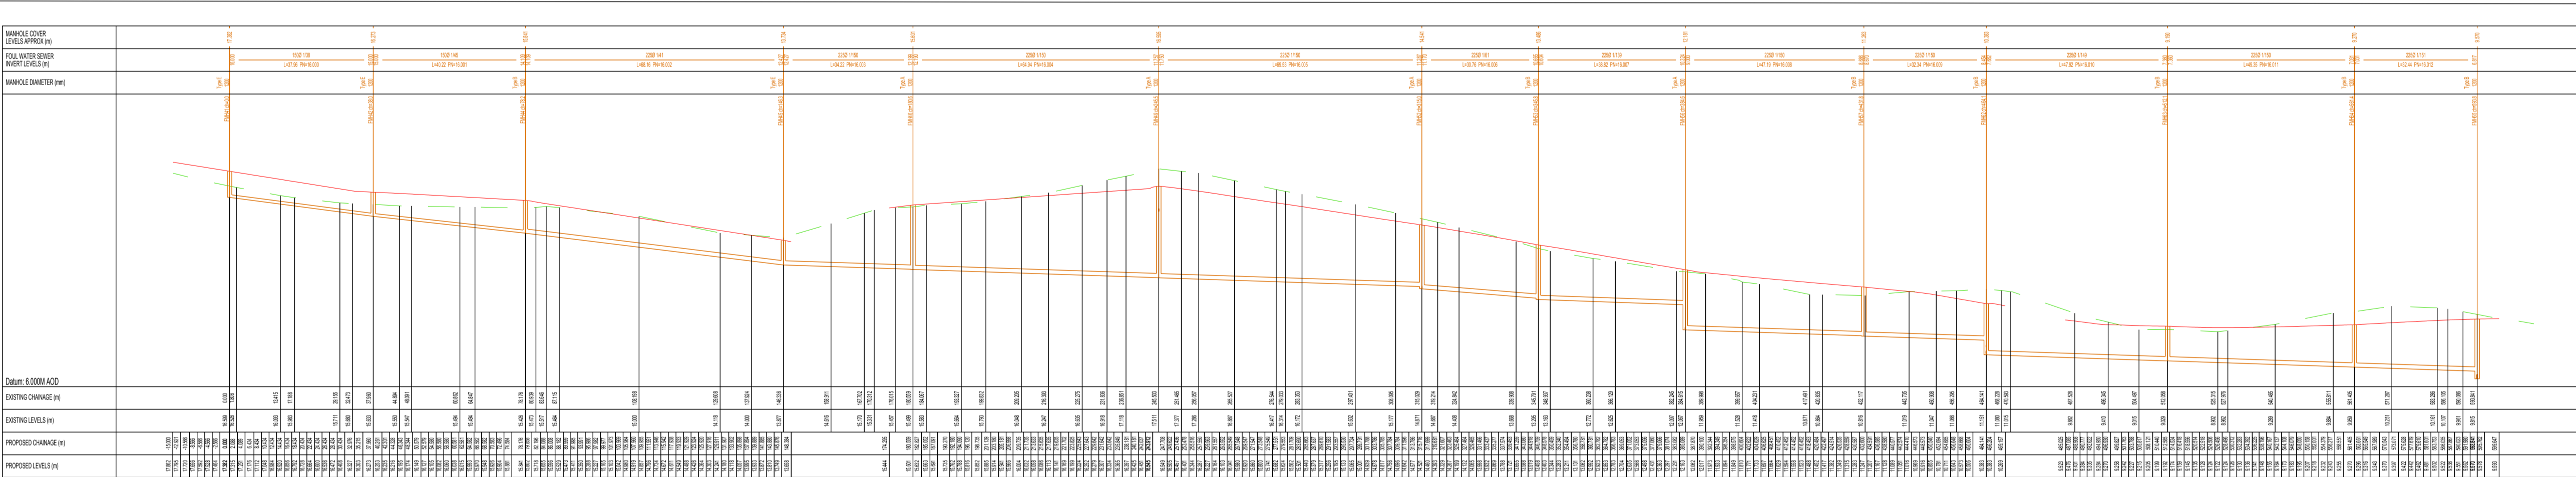


07 Foul Drainage Long Sect
128 SCALE 1:1000


B	Issued for Planning	May 2019	T. Finn
A	Issued to Irish Water for Statement of Acceptance	26th April 2019	T. Finn
REV. NO.	DESCRIPTION	DATE	INITIALS

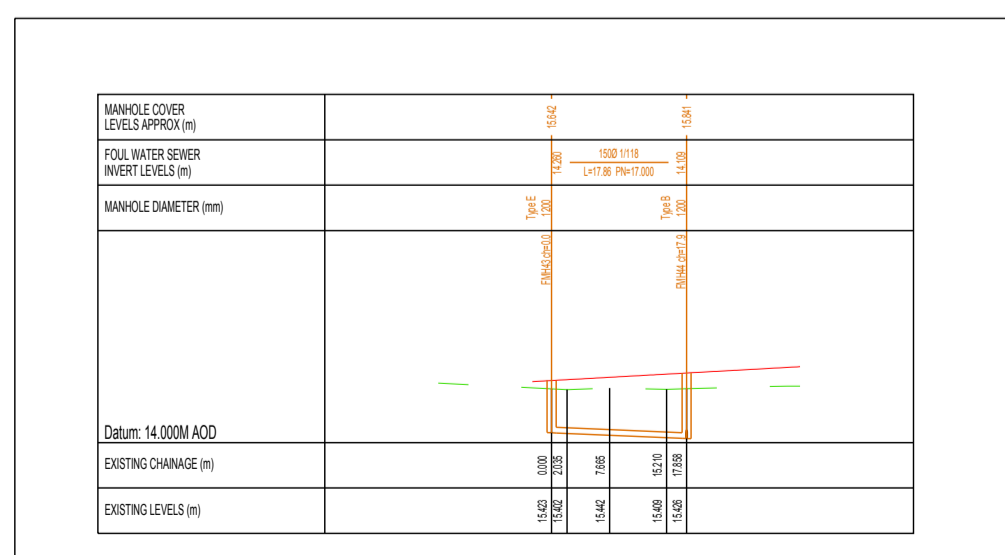

08 Foul Drainage Long Sect
128 SCALE 1:1000

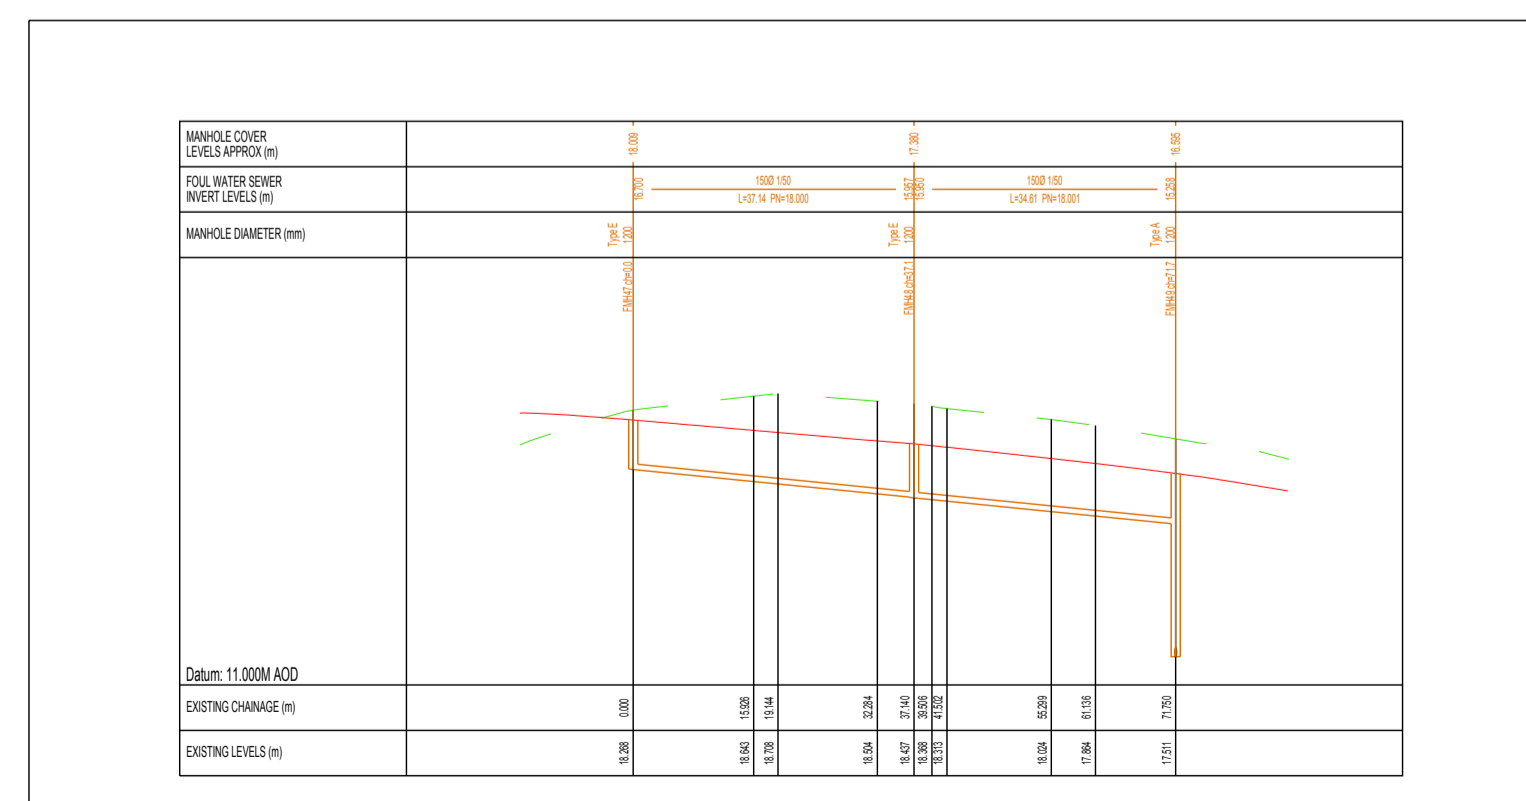

09 Foul Drainage Long Sect
128 SCALE 1:1000

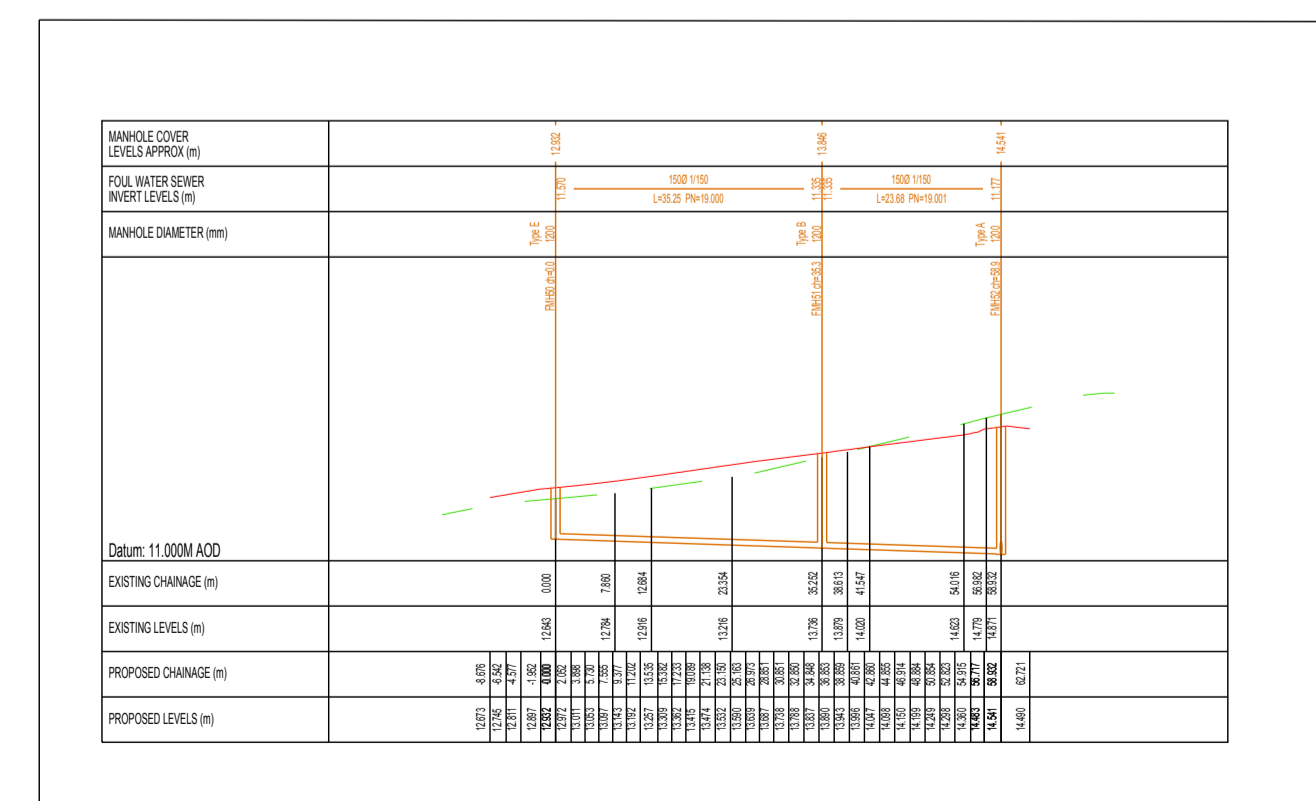

10 Foul Drainage Long Sect
128 SCALE 1:1000

finn
DESIGN PARTNERSHIP
CREATIVE • INNOVATIVE

Blakestown, Ardee, Co. Louth, Ireland
t 041 6857200 f 041 6857201 e info@finn.ie w www.finn.ie

DRAWING NO: **128 B** REV. NO:

TITLE: **Foul Drainage Longitudinal Sections (Sheet 1 of 3)**

PROJECT: Residential Development @ Haggardstown, Blackrock, Dundalk

CLIENT: Kingsbridge Consultancy Ltd
1st Floor Quayside Business Park
Mill Street, Dundalk, Co Louth.

SCALE: 1:1000 @ A1 DRAWN: A. Armstrong
DATE: November 2018 CHECKED: -

STATUS: **Planning Permission**

JOB NO: **1703**

NOTES:
1. Copyright Reserved 2003 ©
2. Work to figure dimensions only. Do not scale drawing.
3. The contractor is responsible for checking all levels and dimensions on site and shall refer all discrepancies to the Architect.
4. Where appropriate, for details of c. structure, or mechanical and electrical details, see Engineers drawings.
5. Proprietary items shall be stated in notes in accordance with manufacturers instructions.
6. Goods of proprietary nature shall be checked with manufacturers.
7. The contractor shall be responsible for the coordination of structure, finishes and services.

• CIVIL • STRUCTURAL ENGINEERING • PROJECT MANAGEMENT