

A	12/08/19	REVISED FOR FINAL SUBMISSION	PJD	MD
REV. DATE		AMENDMENT	DRN	APPD

STATUS **FOR PLANNING**
NOT FOR CONSTRUCTION

Waterman Moylan
Engineering Consultants

BLOCK 5, EASTPOINT BUSINESS PARK, ALFIE BYRNE ROAD,
DUBLIN D03 H3F4 IRELAND.
Tel: (01) 664 8900 Fax: (01) 661 3618
Email: info@waterman-moylan.ie www.waterman-moylan.ie

CLIENT **GERARD GANNON PROPERTIES**

ARCHITECT **CONROY CROWE KELLY**


PROJECT
CLONGRIFFIN SHD APPLICATION 1

TITLE
DRAINAGE LAYOUT GENERAL ARRANGEMENT



DRAWN PJD	DESIGNED PJD	APPROVED MD	DATE NOV 18'
SCALE 1:1000 @ A1	JOB NO. 18-059	DRG. NO. P1200	REVISION A

© 2014. This drawing is copyright. No part of this document may be reproduced or transmitted in any form or stored in any retrieval system of any nature without the written permission of the consulting engineer or copyright holder except as agreed for use on the project for which the document was originally issued.

Ordnance Survey Ireland Licence No. EN 0006019
© Ordnance Survey Ireland/Government of Ireland.

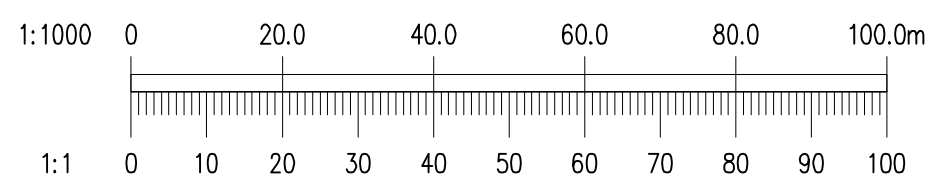

- NOTES:
- DO NOT SCALE. USE FIGURED DIMENSIONS ONLY.
 - THIS DRAWING IS TO BE READ IN CONJUNCTION WITH ALL OTHER RELEVANT ARCHITECTURAL AND ENGINEERING DRAWINGS.

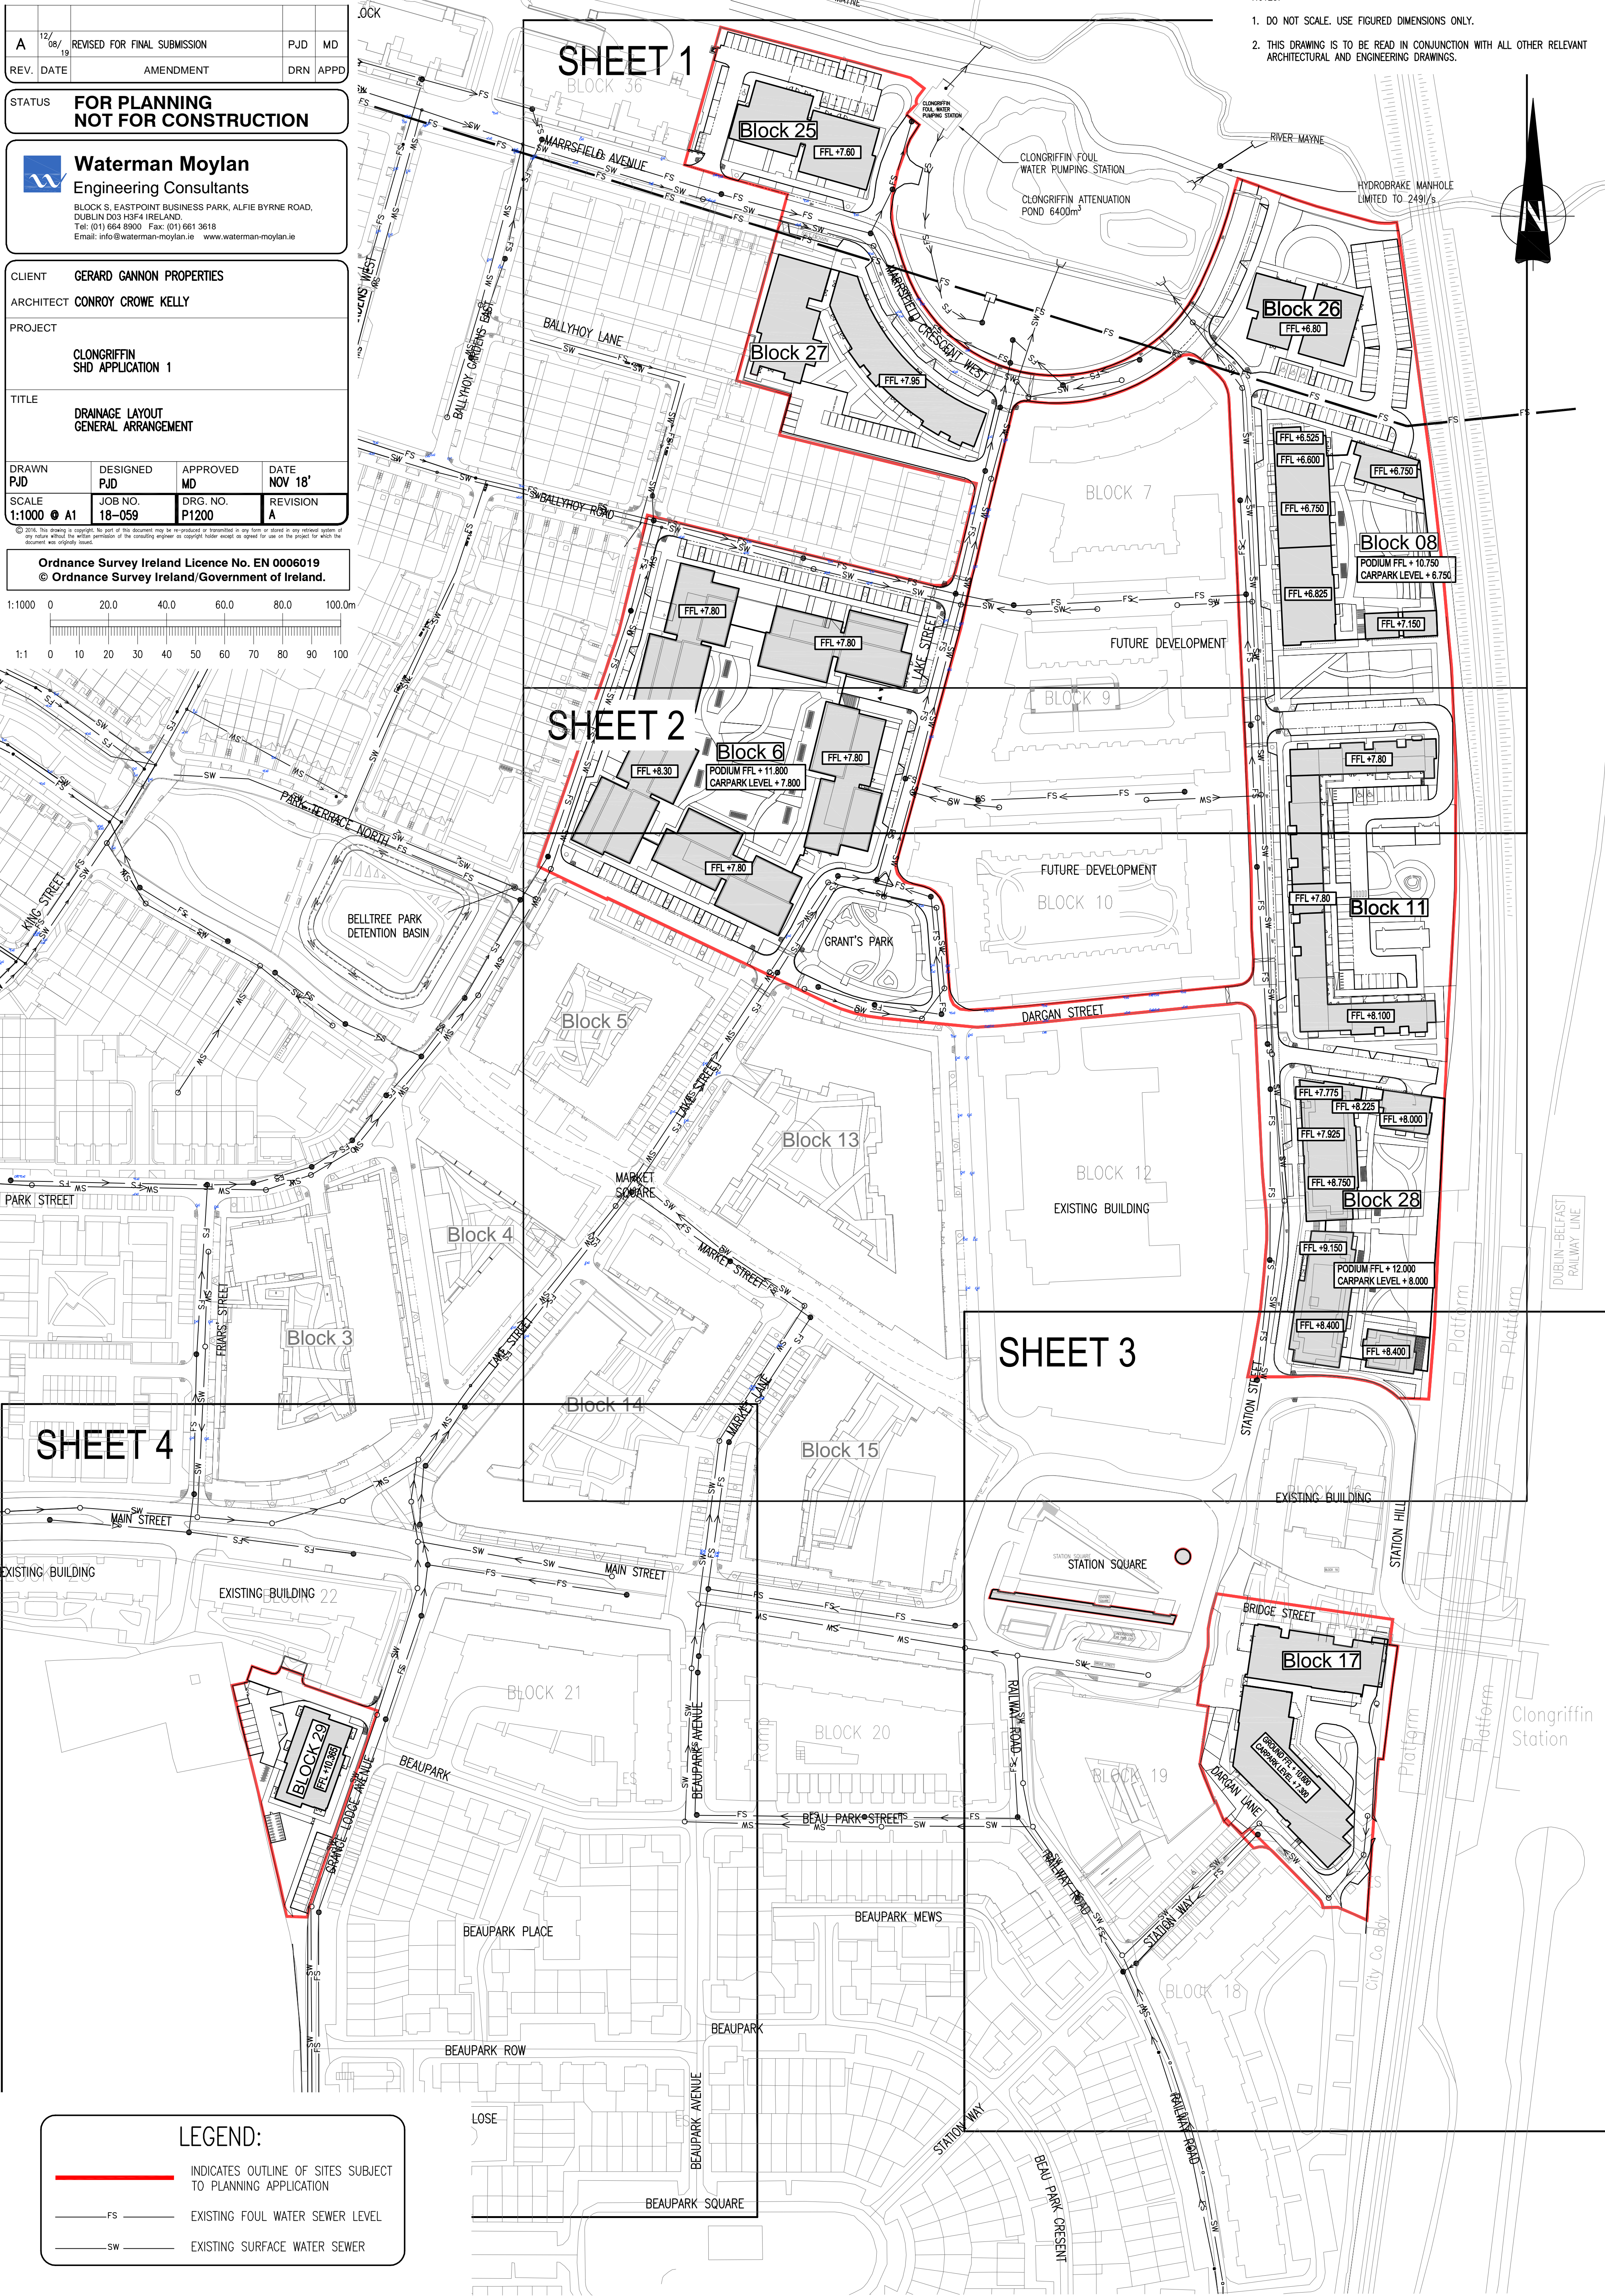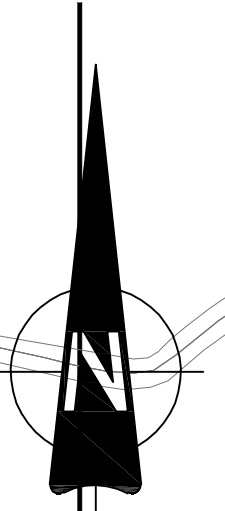

LEGEND:

	INDICATES OUTLINE OF SITES SUBJECT TO PLANNING APPLICATION
	EXISTING FOUL WATER SEWER LEVEL
	EXISTING SURFACE WATER SEWER