

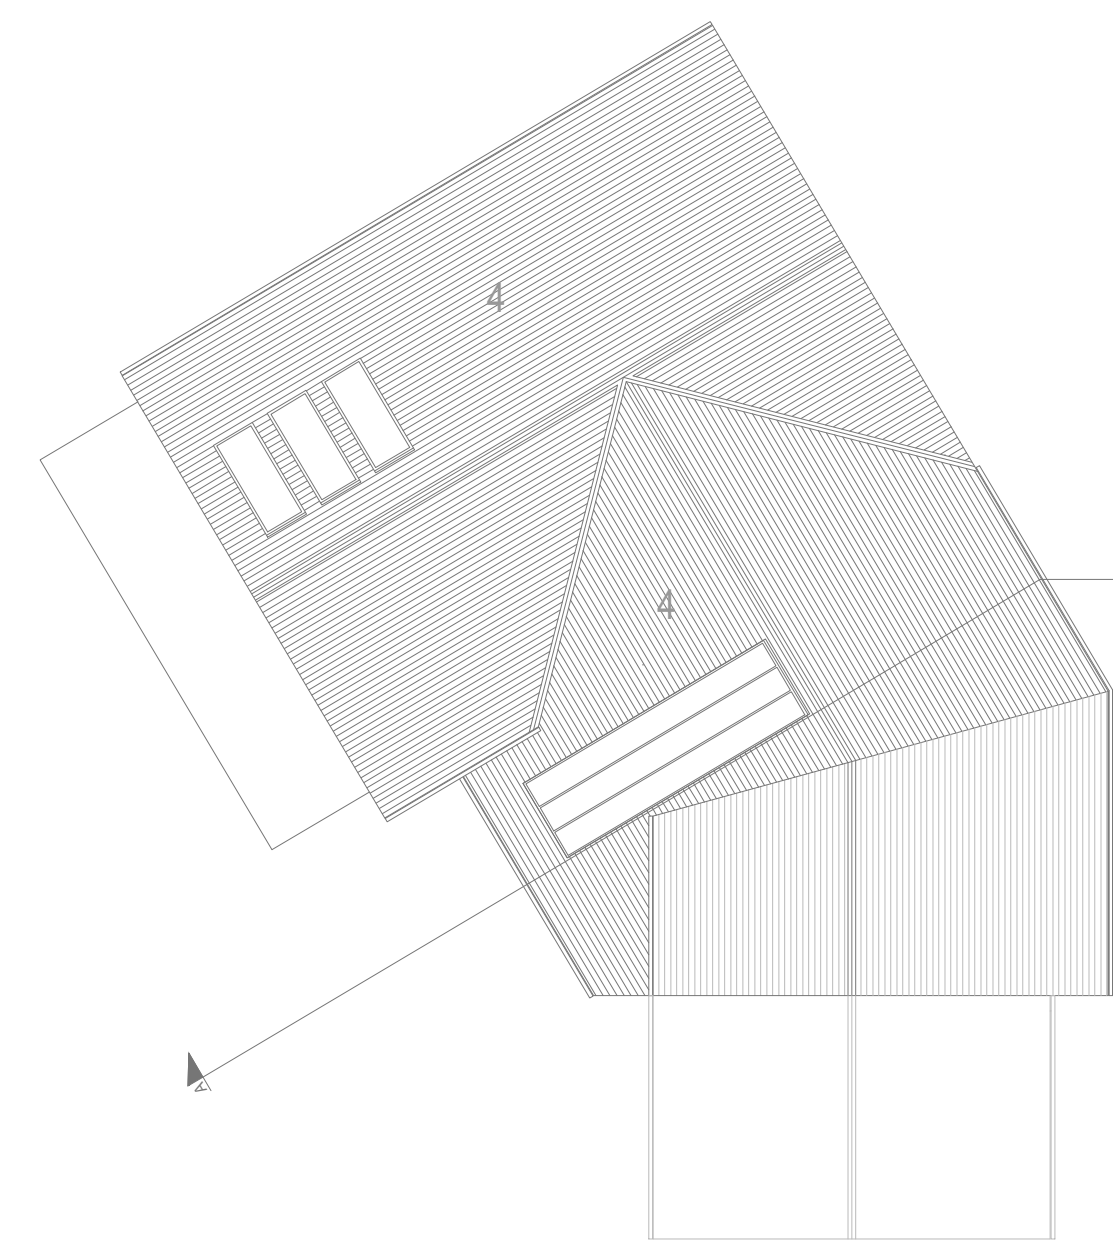
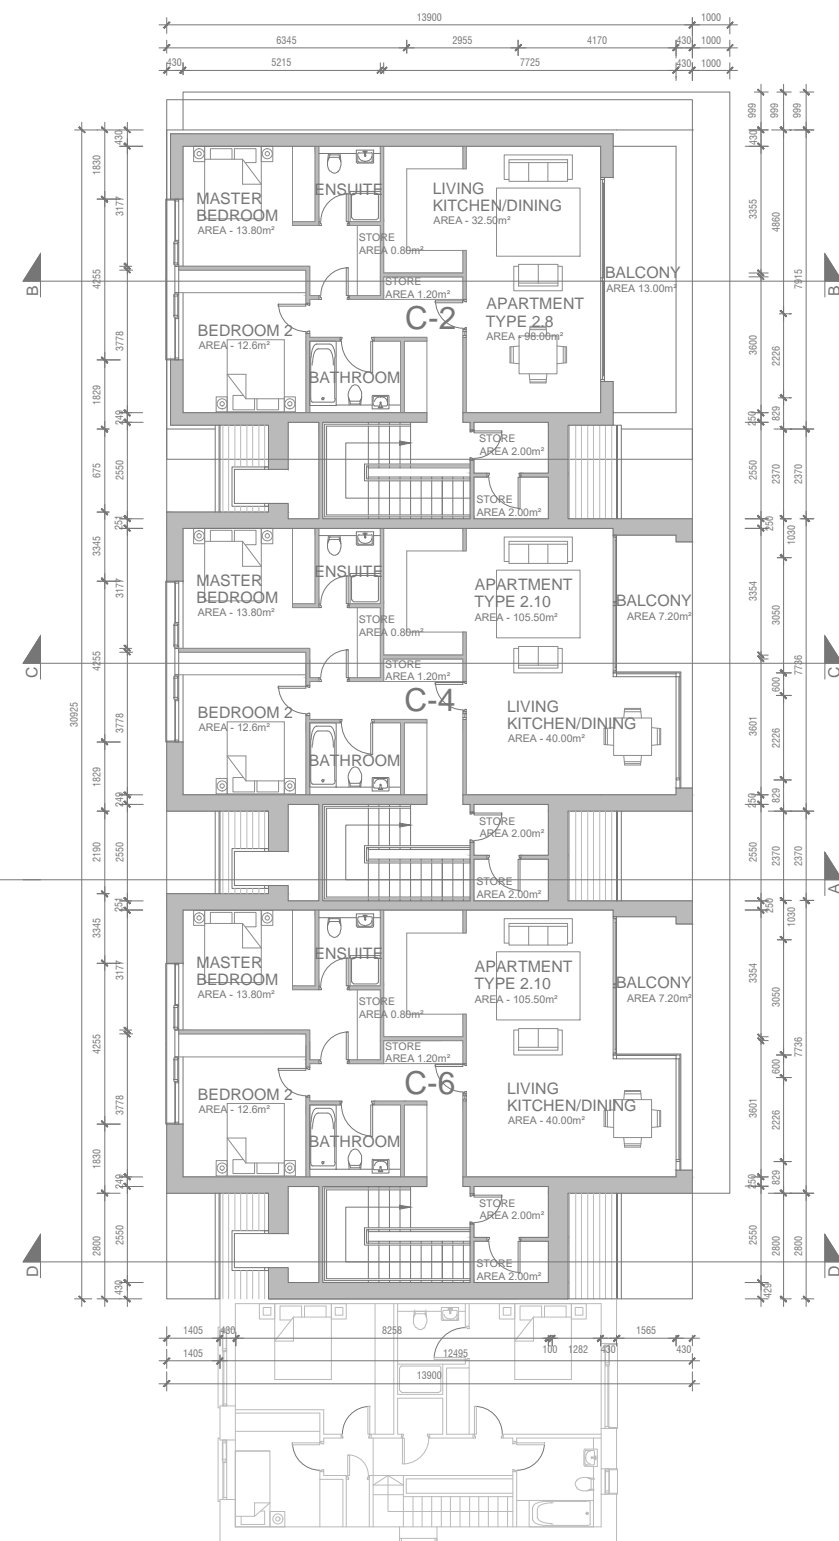


FIRST FLOOR PLAN
SCALE 1:200@A1

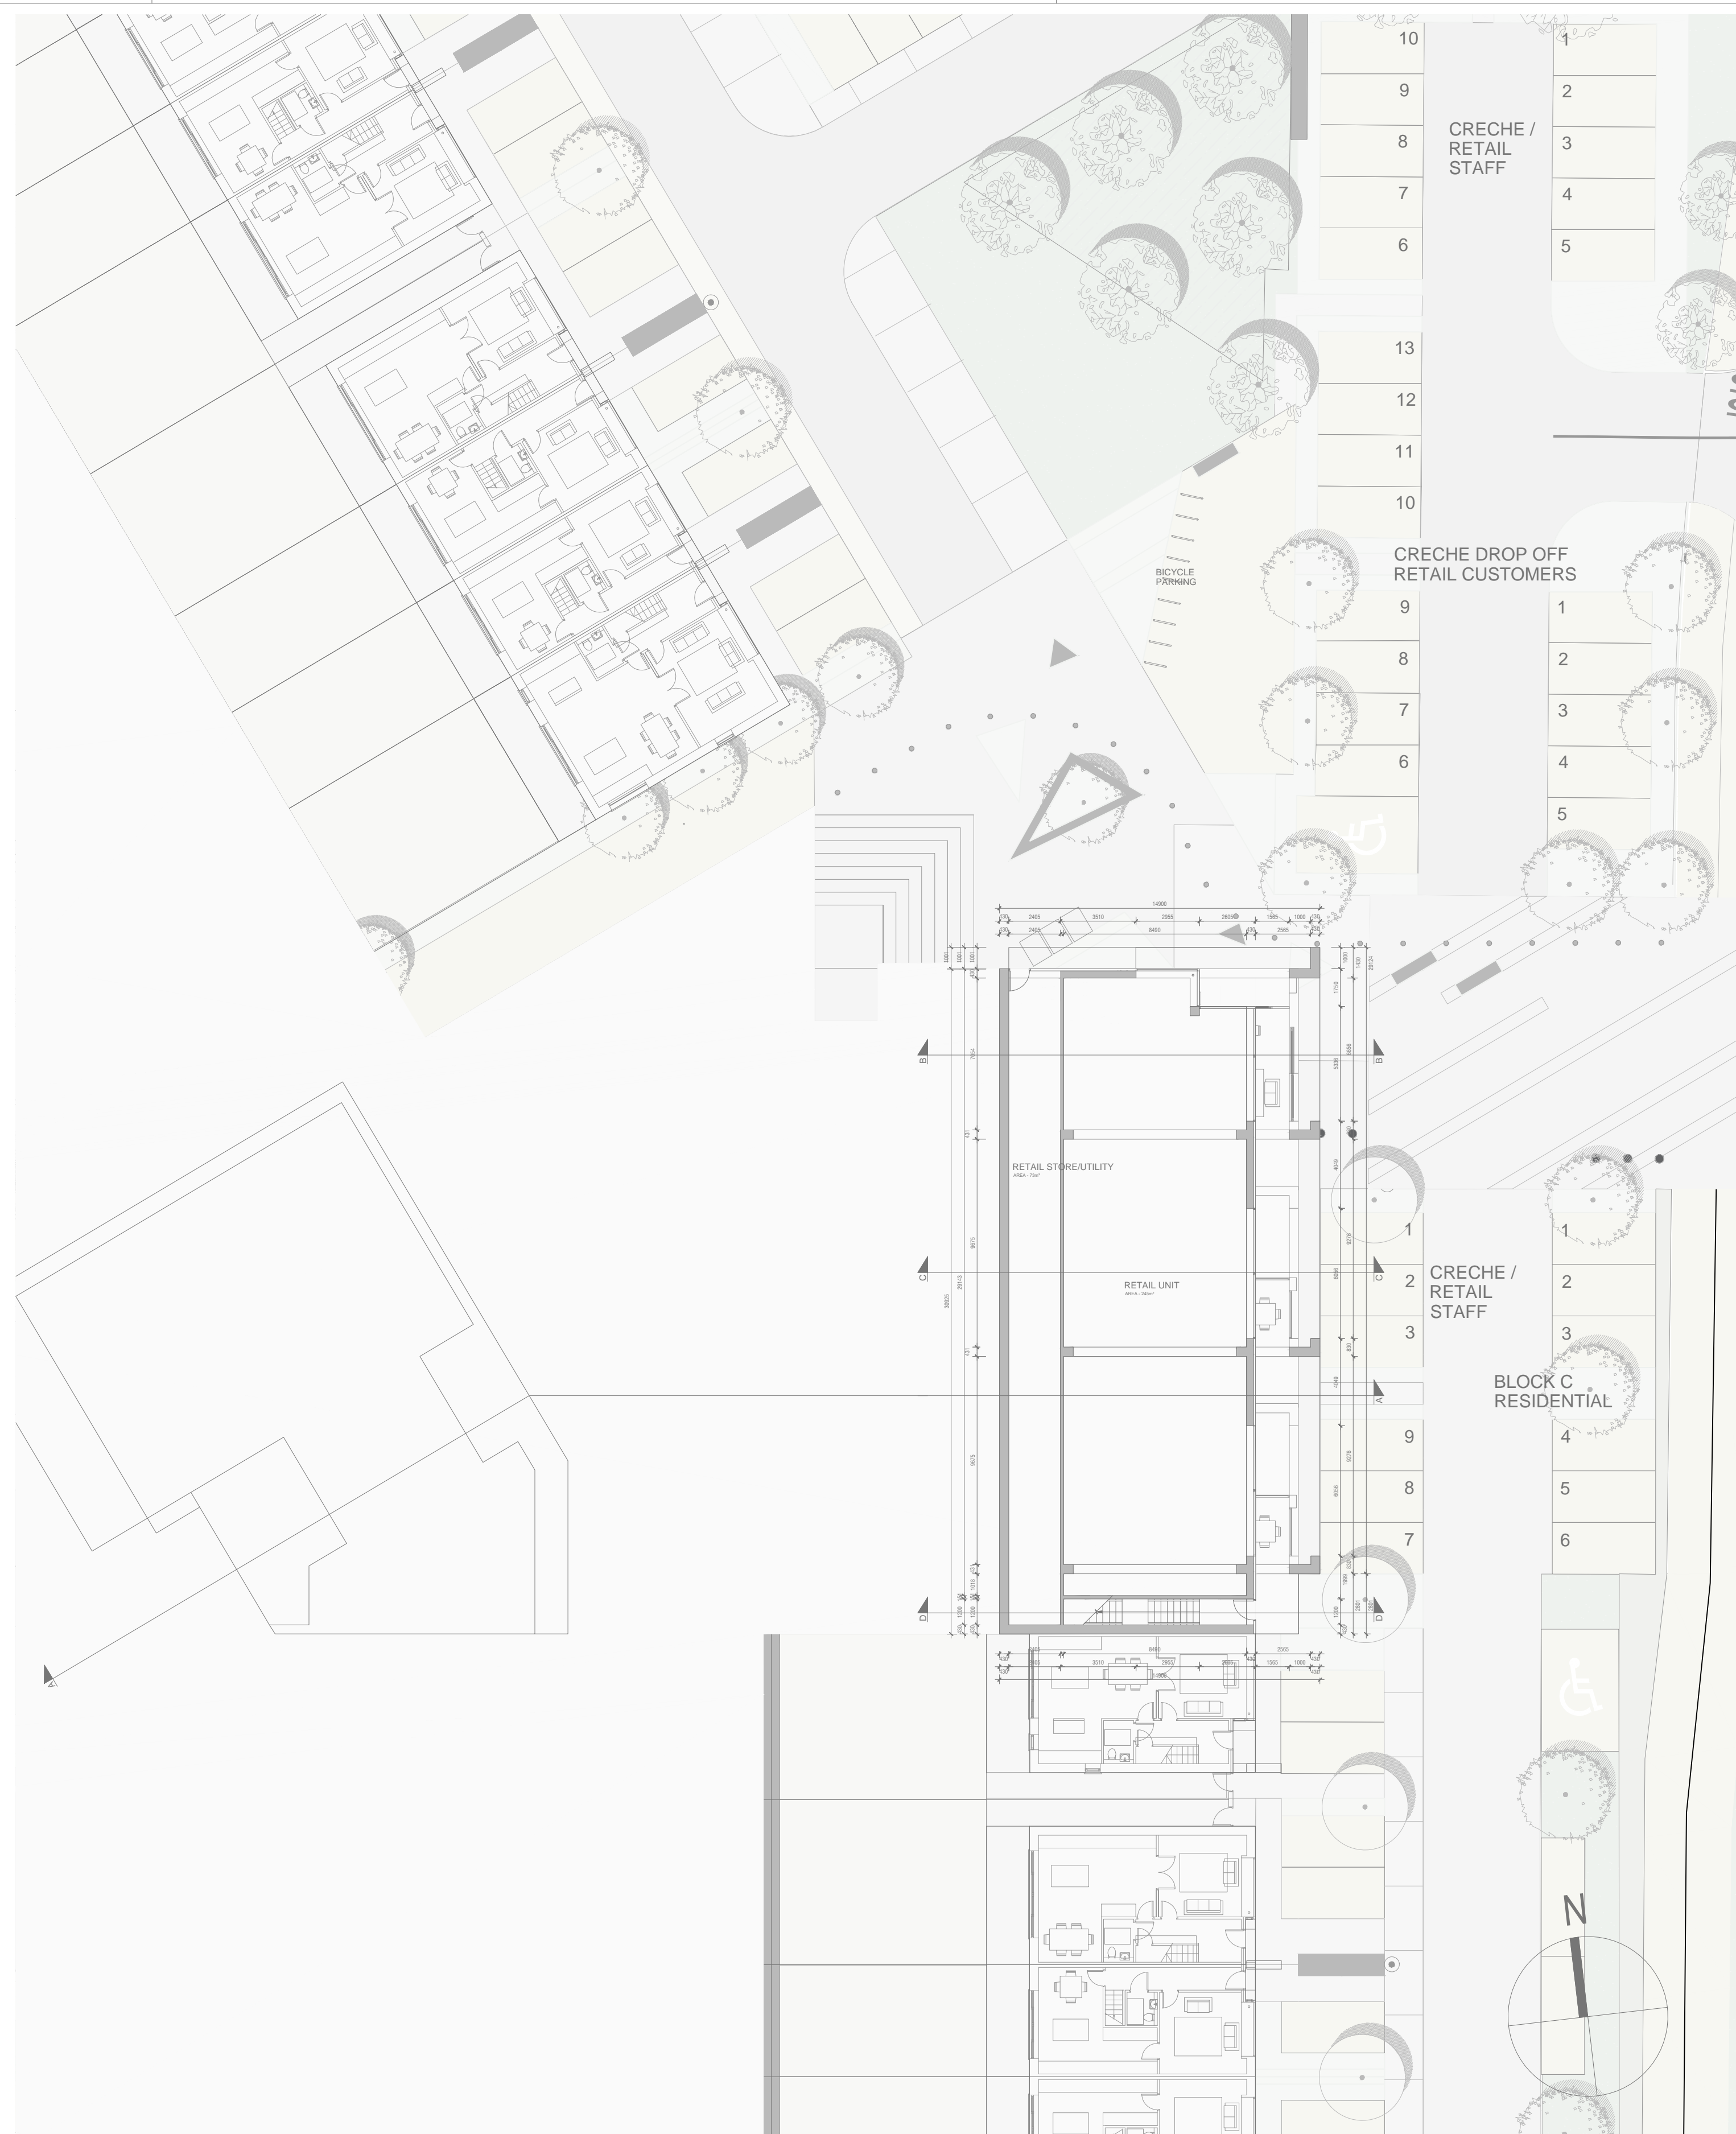

ROOF PLAN
SCALE 1:200@A1

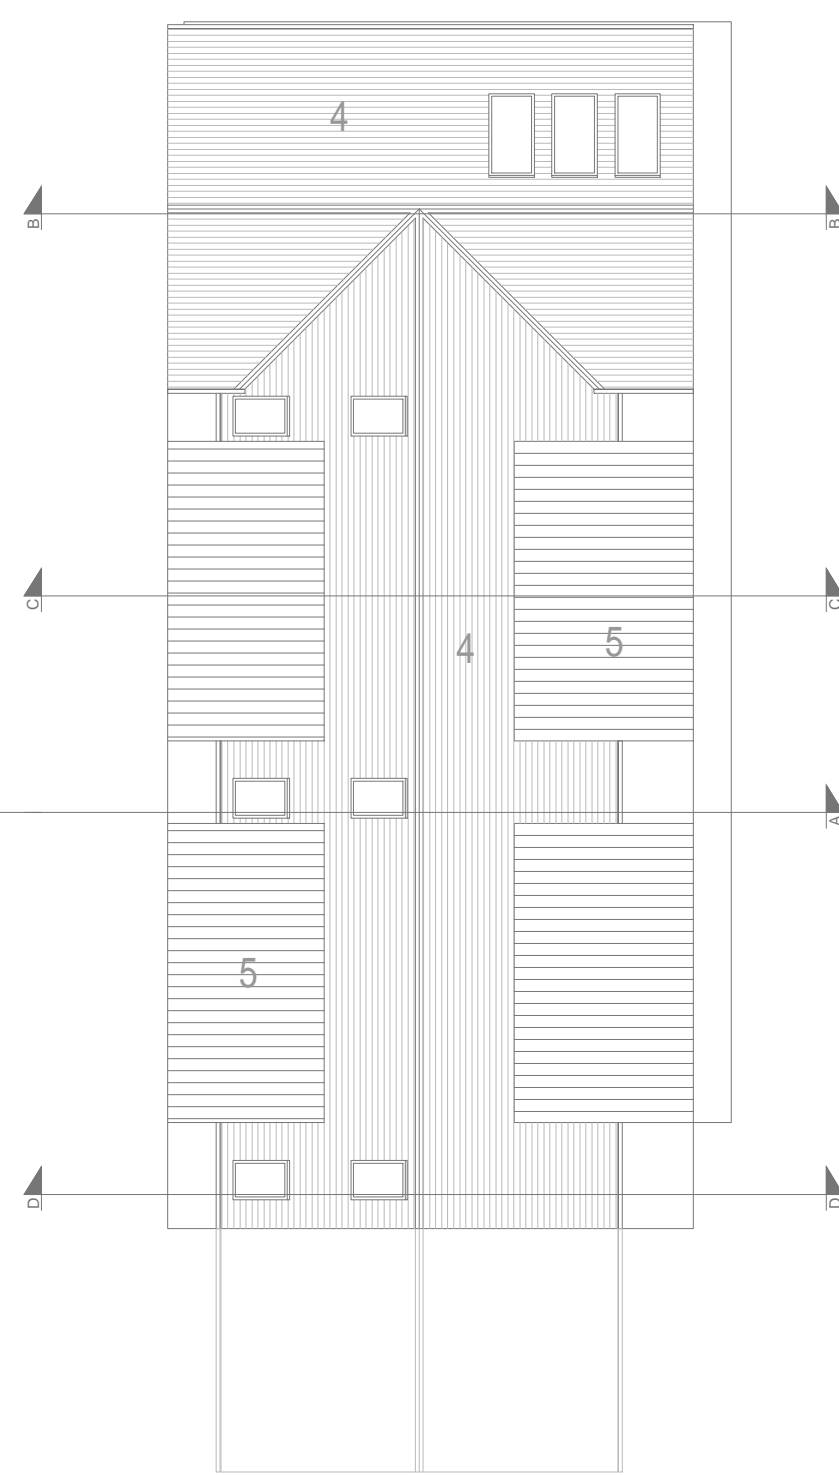

LOWER GROUND FLOOR (RETAIL) PLAN
SCALE 1:200@A1

PROPOSED NEIGHBOURHOOD CENTRE APARTMENT BLOCK - TYPE C PLANS

- NOTES
1. Copyright Reserved.
 2. Work to figured dimensions only. Do not scale drawing.
 3. The contractor is responsible for checking all levels and dimension on site and shall refer all discrepancies to the Architect.
 4. Where appropriate, for details of R.C. structure, or mechanical and electrical details, see Engineers drawings.
 5. Proprietary items shall be fixed in strict accordance with manufacturers instructions.
 6. Sizes of proprietary items shall be checked with manufacturer.
 7. The contractor shall be responsible for the co-ordination of structure, finishes and services.

ISSUE STATUS	No.	Date	Revision	Initials
PROGRESS				
INFORMATION ONLY				
PLANNING APPLICATION				
TENDER				
FIRE CERT				
CONSTRUCTION				
CIAC				
COMPLIANCE				

No.	Date	Revision	Initials

No.	Date	Revision	Initials

No.	Date	Revision	Initials

Project : RATHMULLAN	Client : TRAILFORD LTD	Job No. : 17/094
Drawing Title : PROP. APT. BLK - TYPE C PLANS	Date : Aug 2019	Scale as shown
Drawn by: GZ	Checked by: JOL	Revision No. : B

Niall D. Brennan Associates, 52 Pembroke Road, Ballsbridge, Dublin 4, Ireland
 TEL (353 1) 478 90 09 FAX (353 1) 478 90 10 E-MAIL info@ndba.ie WEB www.ndba.ie

