


FRONT ELEVATION
SCALE 1:200@A3


REAR ELEVATION
SCALE 1:200@A3

SIDE ELEVATION
SCALE 1:200@A3


SECTION A-A
SCALE 1:200@A3

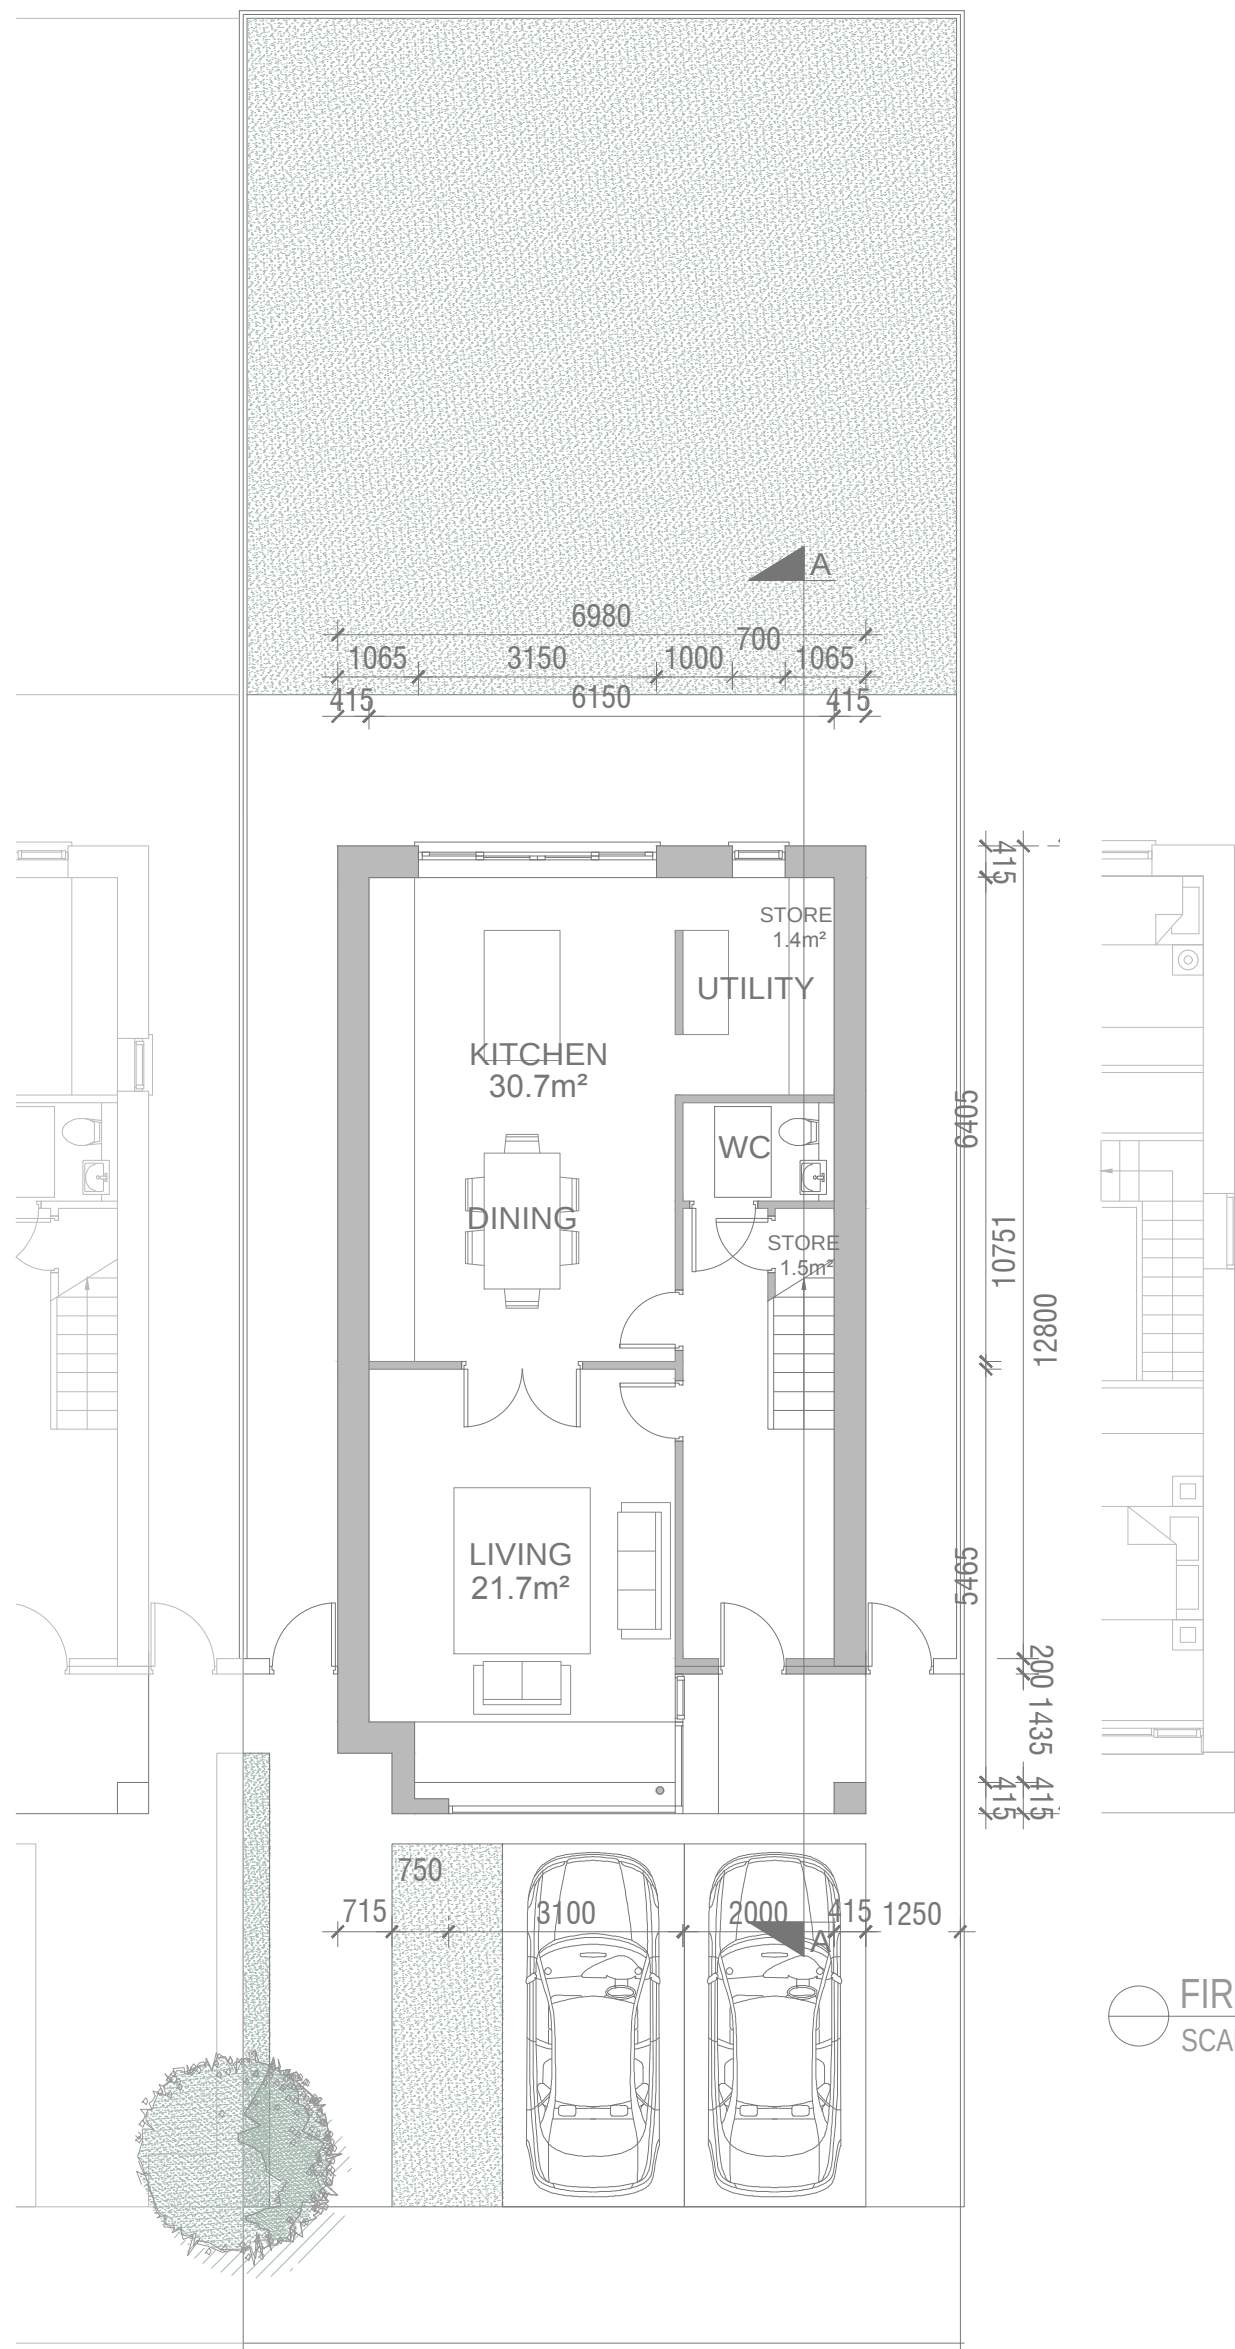

GROUND FLOOR PLAN
SCALE 1:200@A3

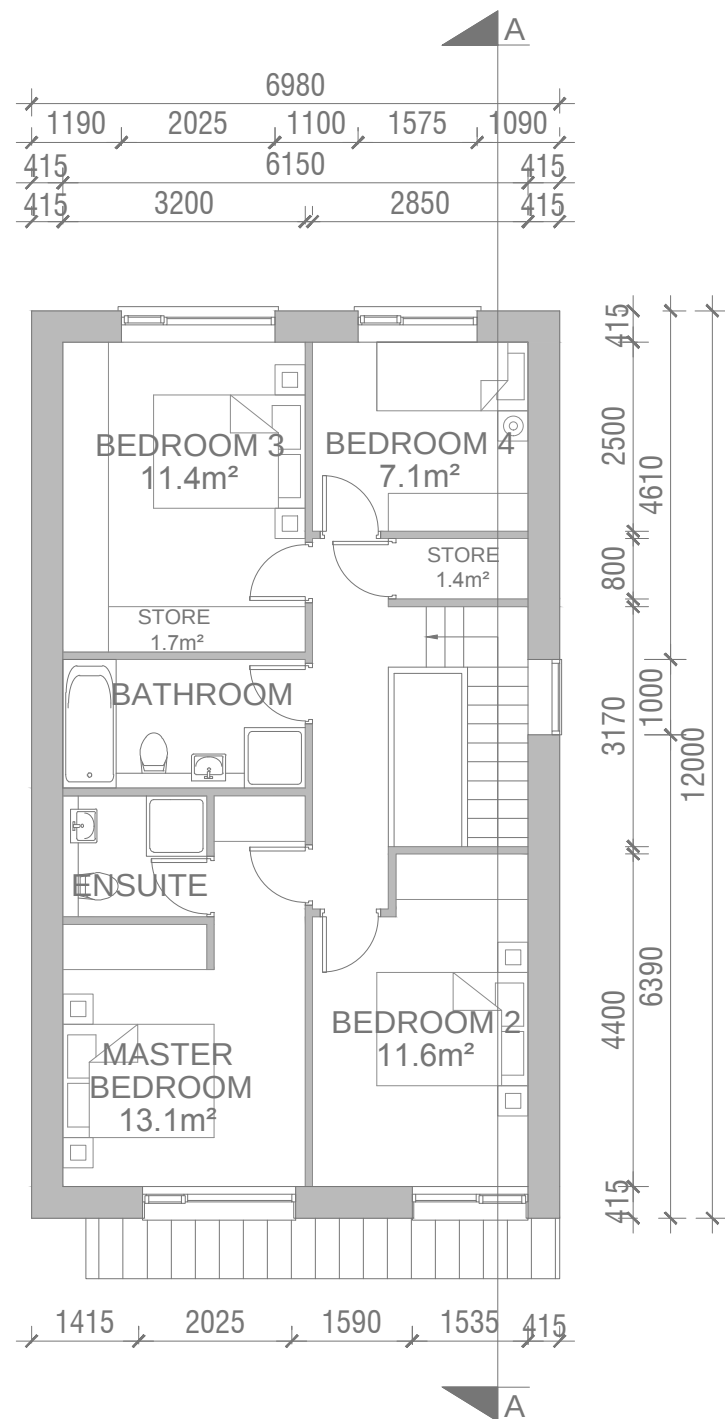

FIRST FLOOR PLAN
SCALE 1:200@A3

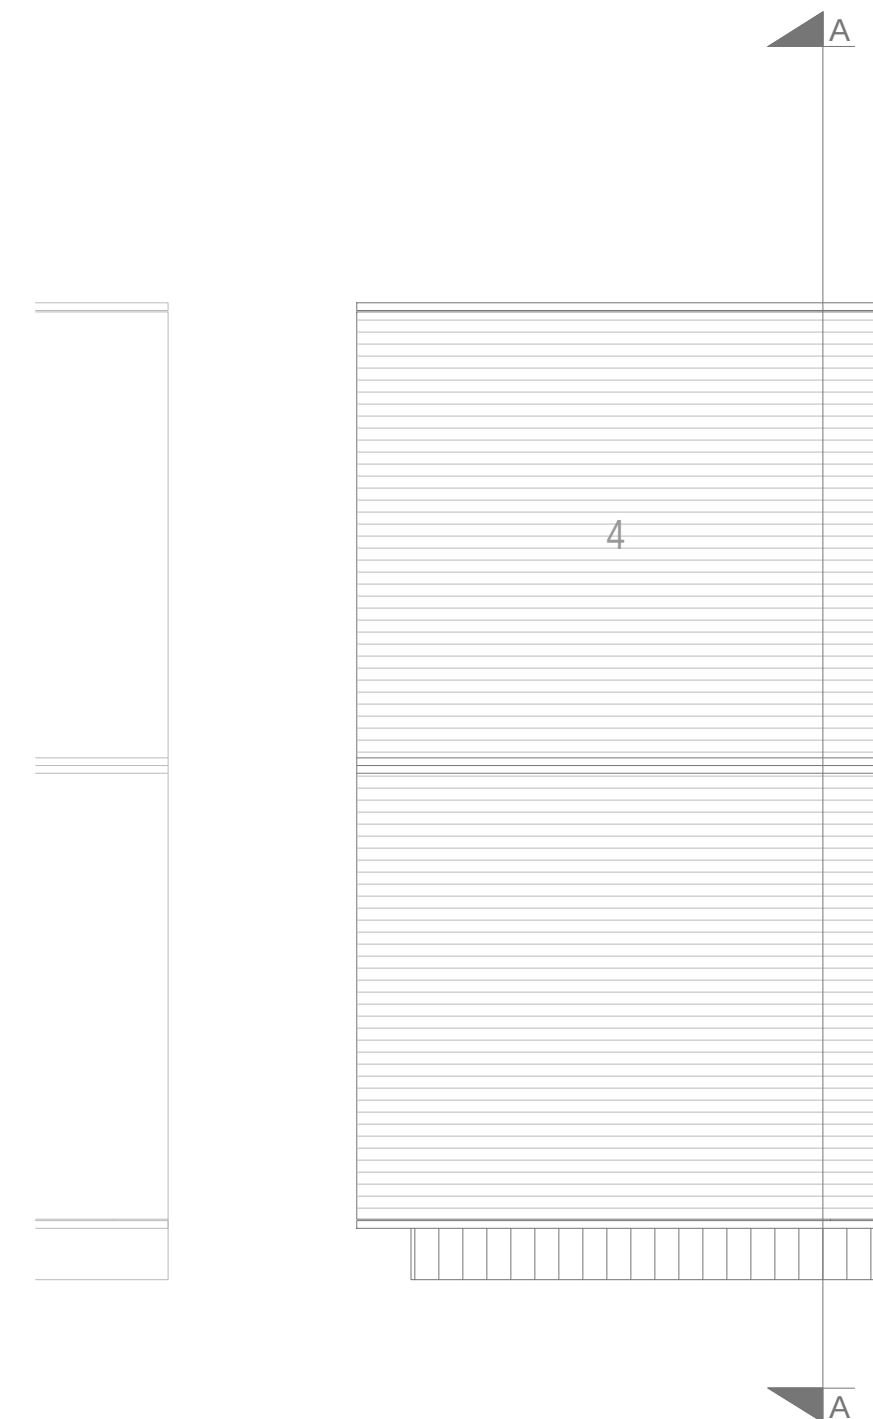

ROOF PLAN
SCALE 1:200@A3



VIEW 1

MATERIALS

- 1 SELECTED BRICK
- 2 RENDER ROUGH
- 3 RENDER SMOOTH
- 4 SLATE ROOF
- 5 TIMBER FENCE
- 6 PVC/ALUMINIUM WINDOWS
- 7 TIMBER PAINTED



LEGEND
N.T.S.

NOTES	NO.	ISSUE/STATUS	NO.	Date	Revision	Initials	NO.	Date	Revision	Initials	NO.	Date	Revision	Initials
1. Copyright Reserved.		PROGRESS												
2. Work to figured dimensions only. Do not scale drawing.		INFORMATION ONLY												
3. The contractor is responsible for checking all levels and dimension on site and shall refer all discrepancies to the Architect.		PLANNING APPLICATION												
4. Where appropriate, for details of R.C. structure, or mechanical and electrical details, see Engineers drawings.		TENDER												
5. Proprietary items shall be fixed in strict accordance with manufacturers instructions.		FIRE CERT												
6. Sizes of proprietary items shall be checked with manufacturer.		CONSTRUCTION												
7. The contractor shall be responsible for the co-ordination of structure, finishes and services.		DAC												
		COMPLIANCE												

Project : RATHMULLAN	JOB NO.
Client : TRAILFORD LTD	17/094
Drawing Title : 4 BED DETACHED HOUSE - TYPE 4.4	DRAWING NO. PP-H17-01
Date : Aug 2019 Scale as shown	A3 REVISION NO. B
Drawn by: GZ	Checked by: JOL
File:	
Niall D. Brennan Associates, 52 Pembroke Road, Ballsbridge, Dublin 4, Ireland	
TEL (353 1) 478 90 09 FAX (353 1) 478 90 10 E-MAIL info@ndba.ie WEB www.ndba.ie	