
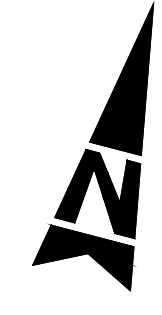


100  
0 10  
A1

DO NOT SCALE

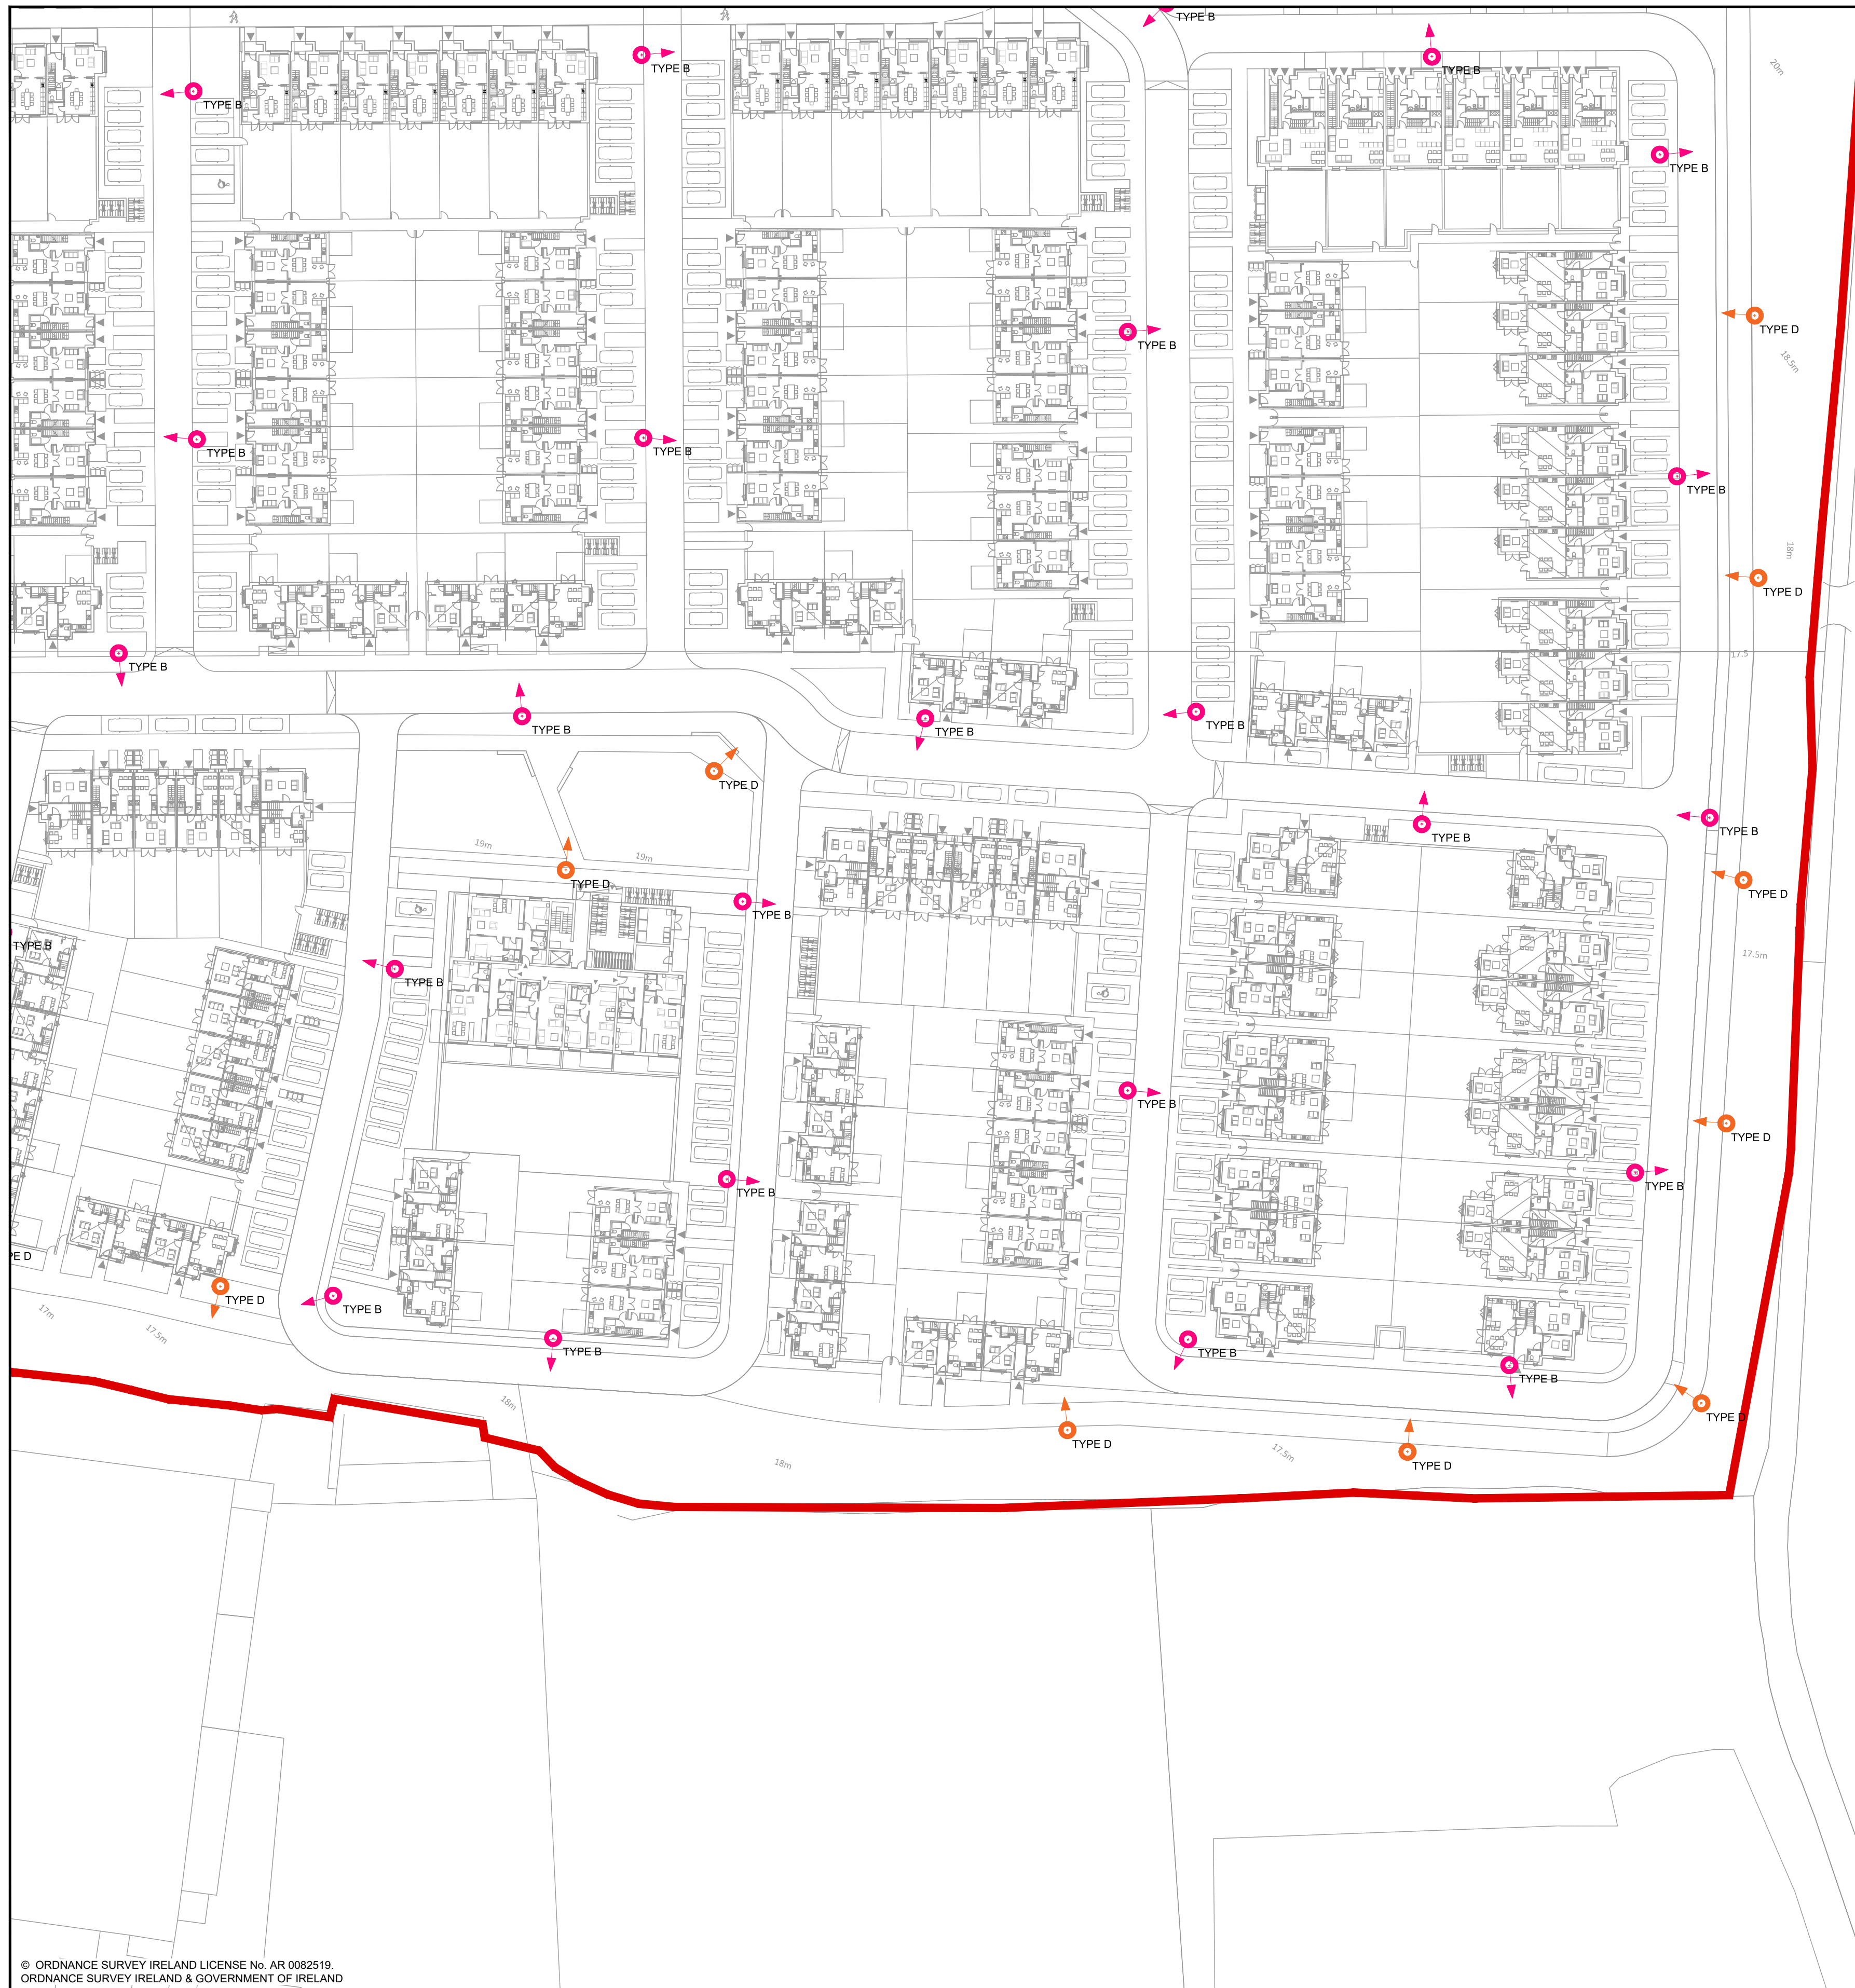

- GENERAL NOTES**
1. ALL DIMENSIONS ARE IN MILLIMETRES UNLESS NOTED OTHERWISE
  2. ONLY WRITTEN DIMENSIONS SHALL BE USED. NO DIMENSIONS SHALL BE SCALED FROM THE DRAWINGS
  3. ALL LEVELS ARE IN METRES AND ARE TO MALIN HEAD DATUM
  4. ALL COORDINATES ARE IN METRES AND ARE TO IRISH TRANSVERSE MERCATOR
  5. DRAWINGS ARE TO BE READ IN CONJUNCTION WITH THE SPECIFICATION

**LUMINAIRE SPECIFICATIONS**

**LUMINAIRE TYPE A DETAILS**

TYPE: CU PHOSCO P862-32-P1-WW-C0900-87W  
 LAMP: 730P WW  
 COLOUR TEMPERATURE: 3000K  
 LAMP FLUX: 9.53  
 MAINTENANCE FACTOR: 0.87

**LUMINAIRE TYPE B DETAILS**

TYPE: CU PHOSCO P862-32-P4-WW-C0350-37W  
 LAMP: 730P WW  
 COLOUR TEMPERATURE: 3000K  
 LAMP FLUX: 4.14  
 MAINTENANCE FACTOR: 0.87

**LUMINAIRE TYPE C DETAILS**

TYPE: CU PHOSCO P862-32-A1-WW-C0750-74W  
 LAMP: 730P WW  
 COLOUR TEMPERATURE: 3000K  
 LAMP FLUX: 8.73  
 MAINTENANCE FACTOR: 0.87

**LUMINAIRE TYPE D DETAILS**

TYPE: CU PHOSCO P863-16-R2-WW-C0300-17W  
 LAMP: 730P WW  
 COLOUR TEMPERATURE: 3000K  
 LAMP FLUX: 1.87  
 MAINTENANCE FACTOR: 0.87

**COLUMN SPECIFICATIONS**

**LUMINAIRE TYPE A**

COLUMN HEIGHT: 8.0 METRES  
 BRACKET OUTREACH: 1.0 METRES  
 TILT: 0°

**LUMINAIRE TYPE B**

COLUMN HEIGHT: 6.0 METRES  
 BRACKET OUTREACH: 0 METRES  
 TILT: 0°

**LUMINAIRE TYPE C**

COLUMN HEIGHT: 8.0 METRES  
 BRACKET OUTREACH: 1.0 METRES  
 TILT: 0°

**LUMINAIRE TYPE D**

COLUMN HEIGHT: 5.0 METRES  
 BRACKET OUTREACH: 0.5 METRES  
 TILT: 0°


**LEGEND**

- APPLICATION BOUNDARY
- MINIX PUBLIC LIGHTING MINI PILLAR (PROPOSED)
- TYPE A PUBLIC LIGHTING COLUMN (PROPOSED) - LUMINAIRE TYPE A
- TYPE B PUBLIC LIGHTING COLUMN (PROPOSED) - LUMINAIRE TYPE B
- TYPE C PUBLIC LIGHTING COLUMN (PROPOSED) - LUMINAIRE TYPE C
- TYPE D PUBLIC LIGHTING COLUMN (PROPOSED) - LUMINAIRE TYPE D

© ORDNANCE SURVEY IRELAND LICENSE No. AR 0082518  
 ORDNANCE SURVEY IRELAND & GOVERNMENT OF IRELAND

WOODBROOK GOLF CLUB

File: 5154251 MEP\_DR\_1305.dwg  
 Date: Oct 30, 2019 - 8:59am  
 Plotted by: jwsh

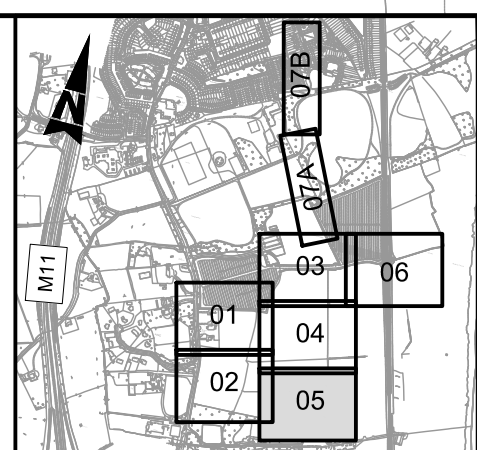

Rev	Description	By	Date	Chk'd	Auth
B	PLANNING SUBMISSION	AK	29.10.19	JW	KB
A	FINAL CLIENT APPROVAL	AK	08.10.19	NS	KB
-	FOR INFORMATION	AK	19.03.19	NS	KB

**ATKINS**  
 Member of the SNC-Lavalin Group

Alkins House, 150-155 Airside Business Park, Swords, Co. Dublin  
 Tel (+353) 01 810 8000 Fax (+353) 01 810 8001

Unit 2B, 2200 Cork Airport Business Park, Cork  
 Tel (+353) 021 429 0300 Fax (+353) 021 429 0360

2nd Floor Technology House Parkmore Technology Park, Galway  
 Tel (+353) 091 786 0550 Fax (+353) 091 779 830

Client: **AEVAL**

Project: **WOODBROOK PHASE 1**

Purpose: **PLANNING**

Title: **PROPOSED PUBLIC LIGHTING LAYOUT SHEET 5 of 5**

Original Scale: 1:500 at A1 1:1000 at A3	Design/Drawn: AK	Checked: NS	Authorised: KB
Date: 19.03.19	Date: 19.03.19	Date: 19.03.19	Date: 19.03.19
Status: P	Drawing Number: 5154251 / MEP / DR / 1305	Rev: B	