




1 Block D - Level 00
1:200




2 Block D - Level 01
1:200

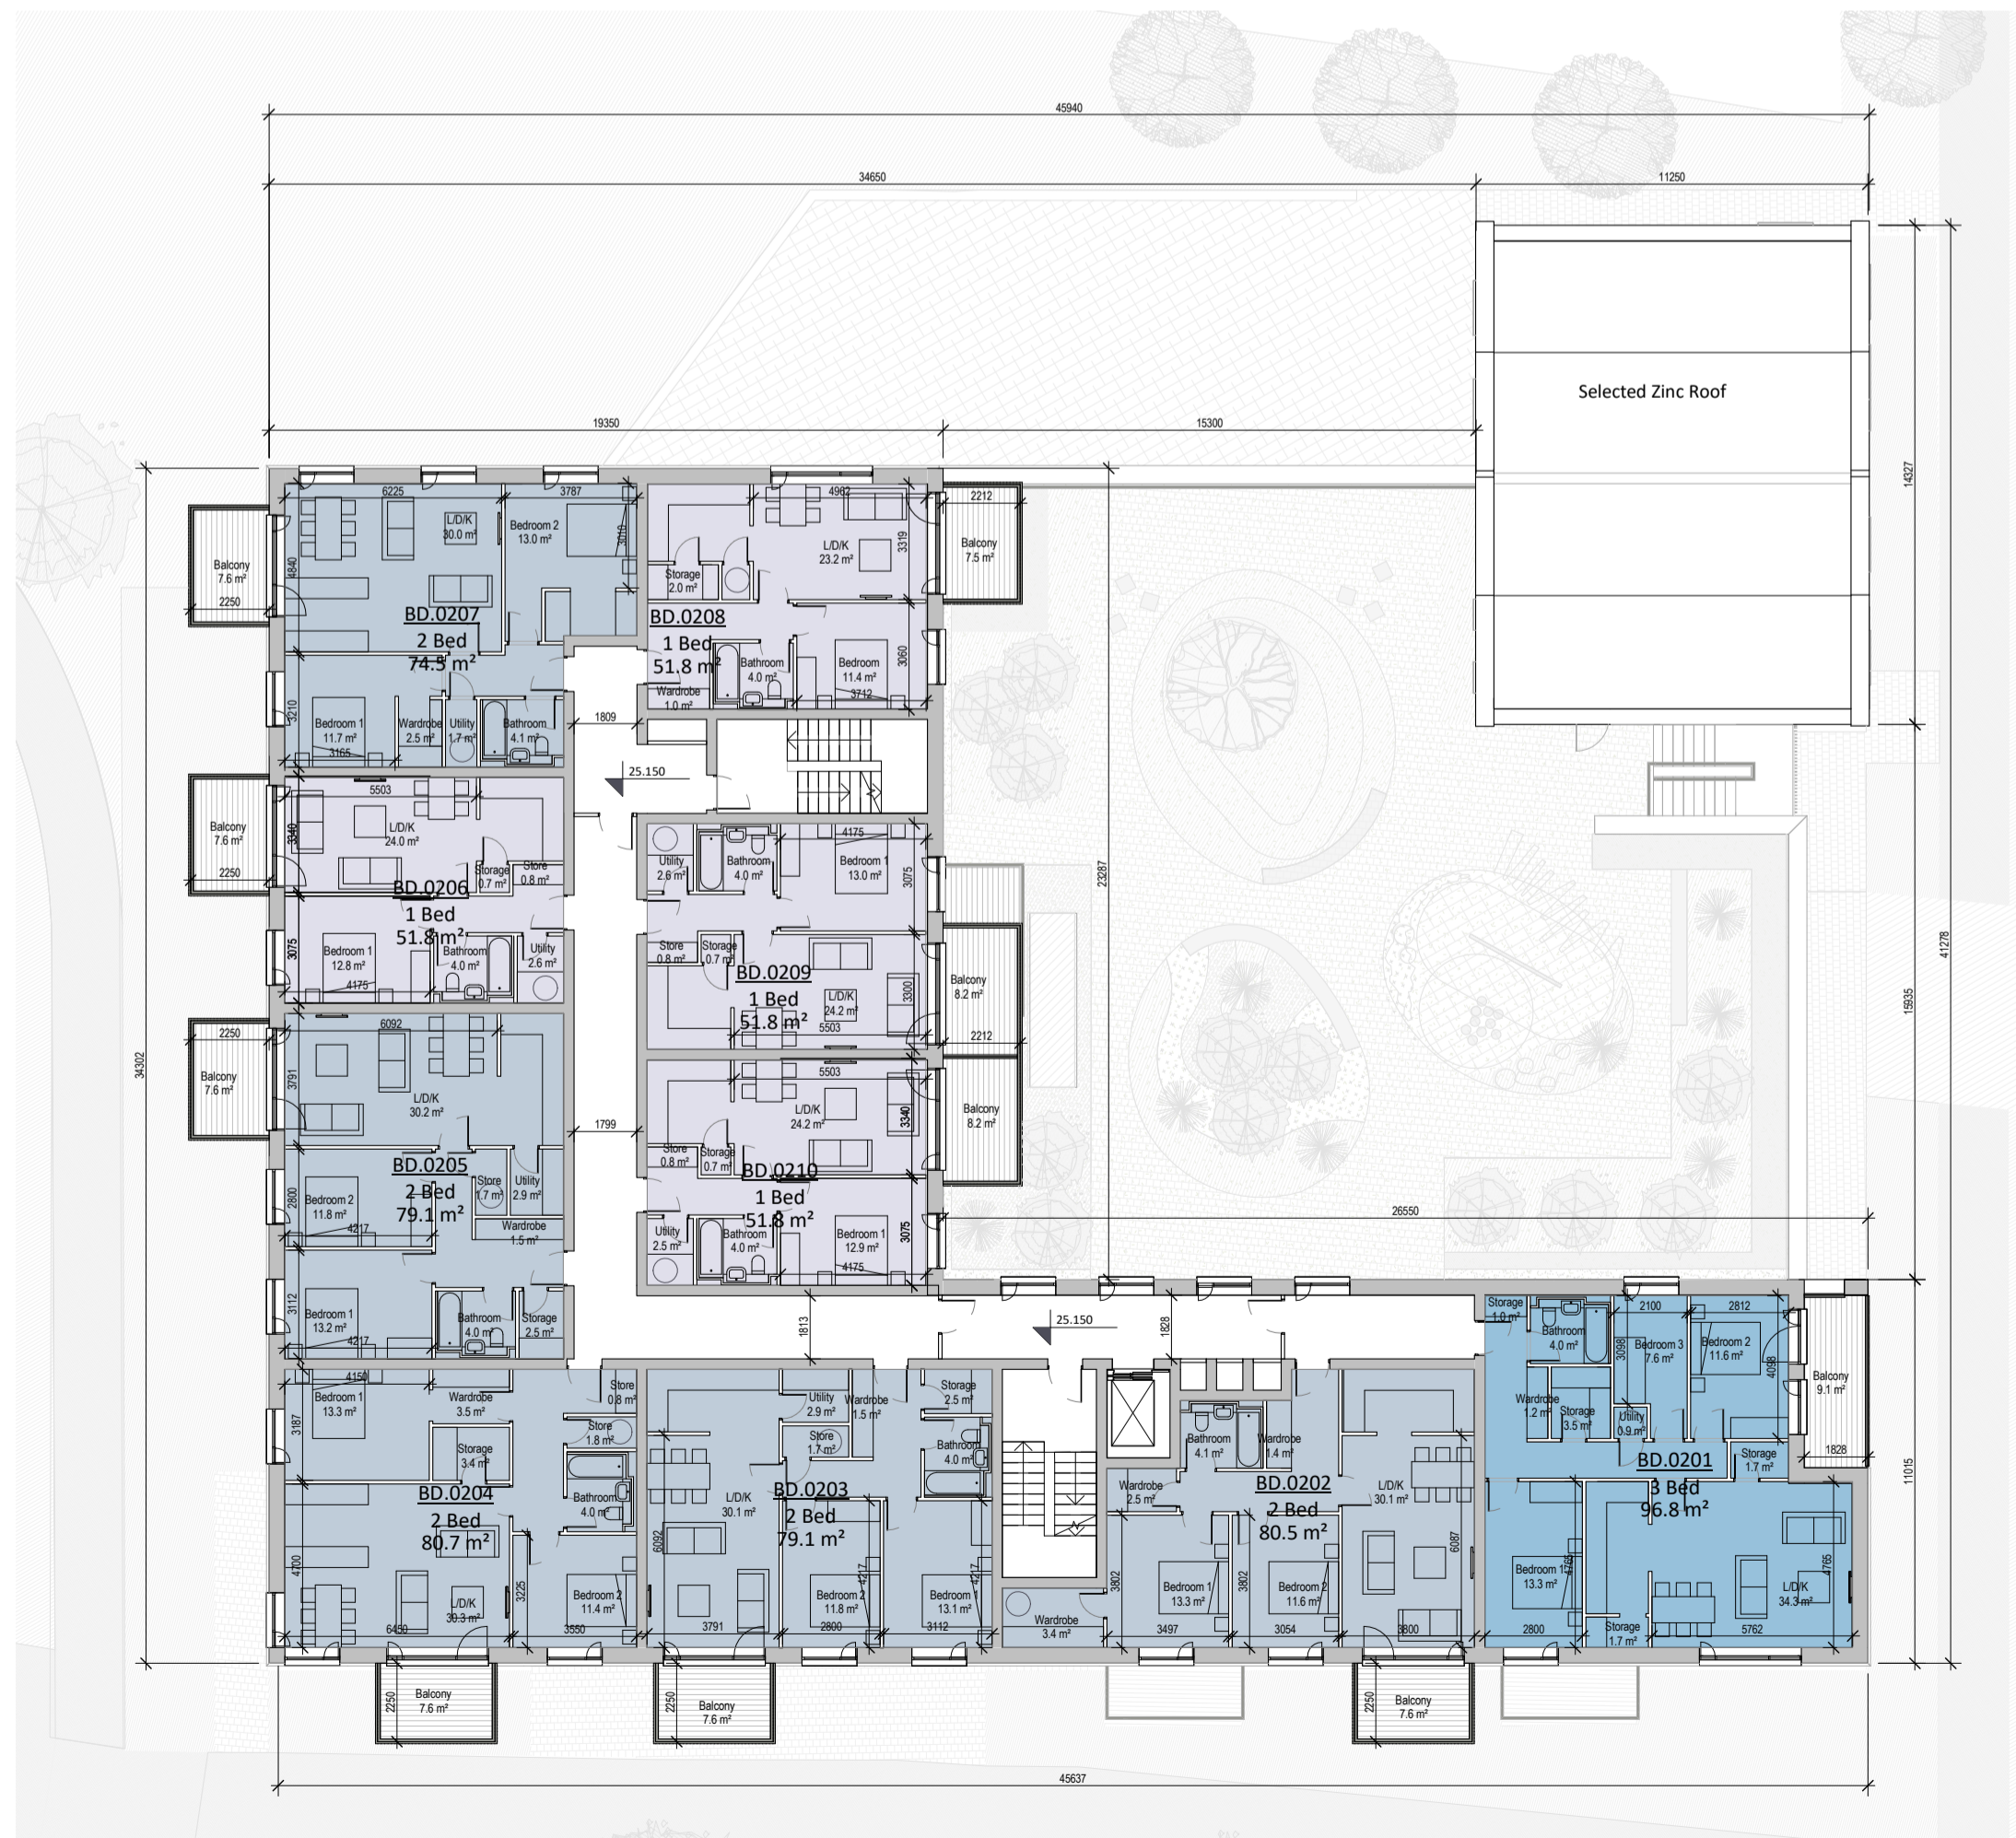

3 Block D - Level 02
1:200



4 Block D - Level 03
1:200

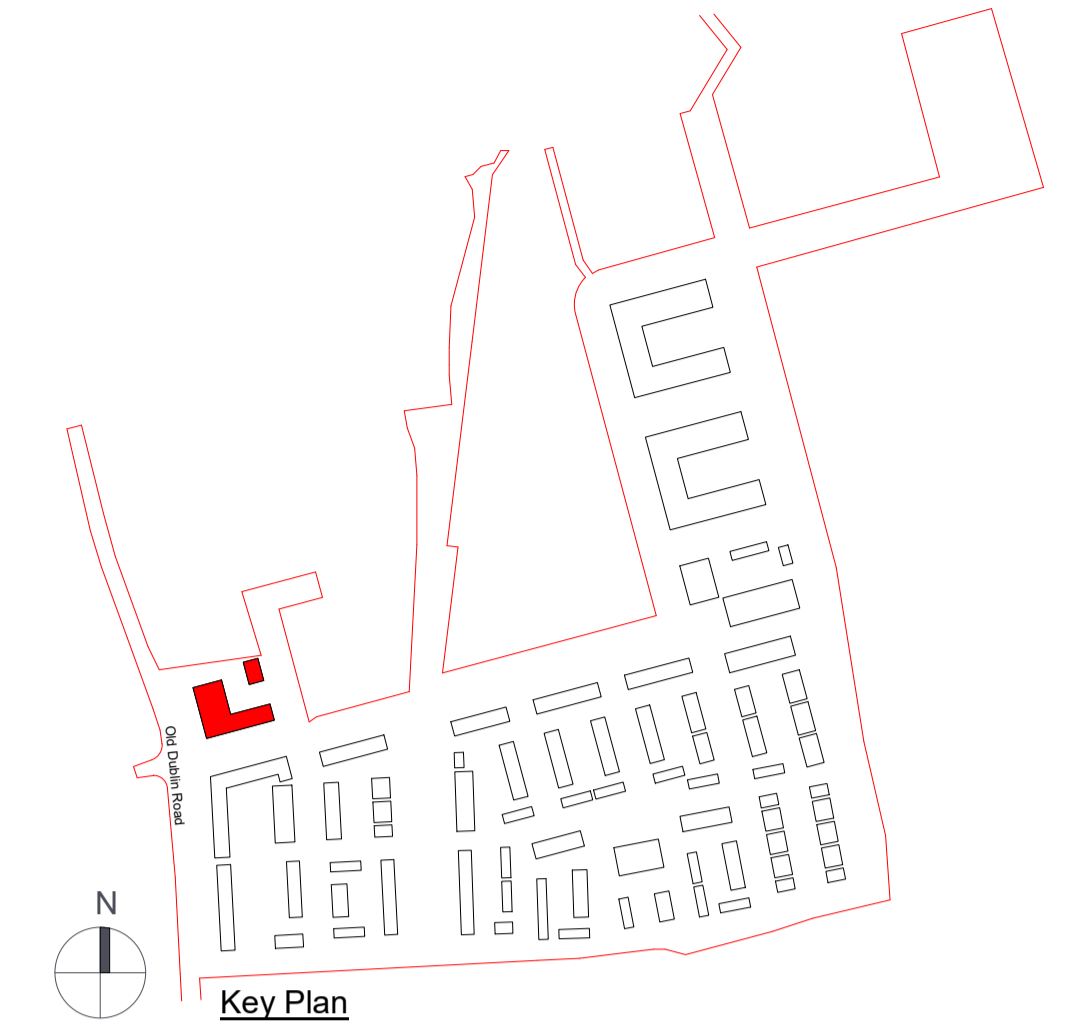

Key Plan

- Legend:**
- 1 Bed
 - 2 Bed
 - 3 Bed
 - Bicycle Store
 - Bin Stores
 - Creche
 - Electrical Plant
 - Mechanical Plant

All levels (in meters) are related to Malin head datum.
All dimensions in millimeters.
Figured dimensions only are to be taken from this drawing.

Revision Description	Date	Rev. No.	Issued by
Issued for Planning	09.10.2019	1	TT

Figured dimensions only to be used. This drawing is copyright of O'Mahony Pike Architects Ltd. All information is shared as per approved use in accordance with BS1192(2007) + A2(2016), Table 5; Standard Codes for Suitability of Models and Documents. If the 'Status' field is empty, this information has been shared at S0 - WIP.

omahony pike Project No.: 1618 Scale @ A1: 1:200
 architecture | urban design | Dublin | Cork | Drawn By: TT | Current Rev.: 1 | Status: SO
 tel: +353 1 202 7400 | The Chapel | 26 South Mall |
 fax: +353 1 283 0822 | Mount St. Anne's | Cork City |
 www.omahonypike.com | Milltown, Dublin 6 | Co. Cork |
 | D06 XN52 Ireland | T12 R2RV Ireland | Purpose: Planning

Project: Woodbrook Phase 1
 Location: Woodbrook
 Client: Aeval