

REF: 'A' LUMINAIRE



REFER TO LUMINAIRE SCHEDULE

REF: 'B' LUMINAIRE



REFER TO LUMINAIRE SCHEDULE

REF: 'C' LUMINAIRE



REFER TO LUMINAIRE SCHEDULE

REF: 'D' LUMINAIRE




REFER TO LUMINAIRE SCHEDULE

LEGEND OF SYMBOLS:

- A LUMINAIRE A XSPME - A - TYPE 275 - VM 26 4K LAMP 3 MD-SA1400 26 4K MF 0.99
- B LUMINAIRE B URBAN MODERN E - TYPE 3ME - 9 LAMP 5 MD-SA1000 9 4K MF 0.99 45W
- C LUMINAIRE C CREE XSPW SERIES, 2ME OPTIC LAMP 4 LED MD-A 4K MF 0.99
- D LUMINAIRE D URBAN MODERN E - TYPE 3ME -Y3 LAMP 5 MD-SA1400 63W 4K MF 0.99
- EX EXISTING 10M PUBLI LIGHTING COLUMNS

DRAWINGS NOTES:

1. LIGHTING TO BE SUPPLIED VIA A SOLAR TIME CLOCK WITHIN EACH PUBLIC LIGHTING MINI PILLAR.
2. A MAXIMUM OF 6No. LUMINAIRES PER CIRCUIT & 4No. CIRCUITS PER PUBLIC LIGHTING MINI PILLAR.
3. ALL COLUMNS TO BE 6 METRES HIGH WITH A 1 METRE OUTREACH BRACKET & SETBACK 1 METRE FROM KERB.
4. ALL COLUMNS TO BE HINGED & TO BE AT LEAST 1 METRE CLEAR OF ALL OVERHEAD HIGH VOLTAGE POWER LINES.
5. FOR SCHEDULES OF EQUIPMENT SEE SPECIFICATION.
6. THE COMPLETE INSTALLATION TO BE CO-ORDINATED WITH ALL OTHER SERVICES.

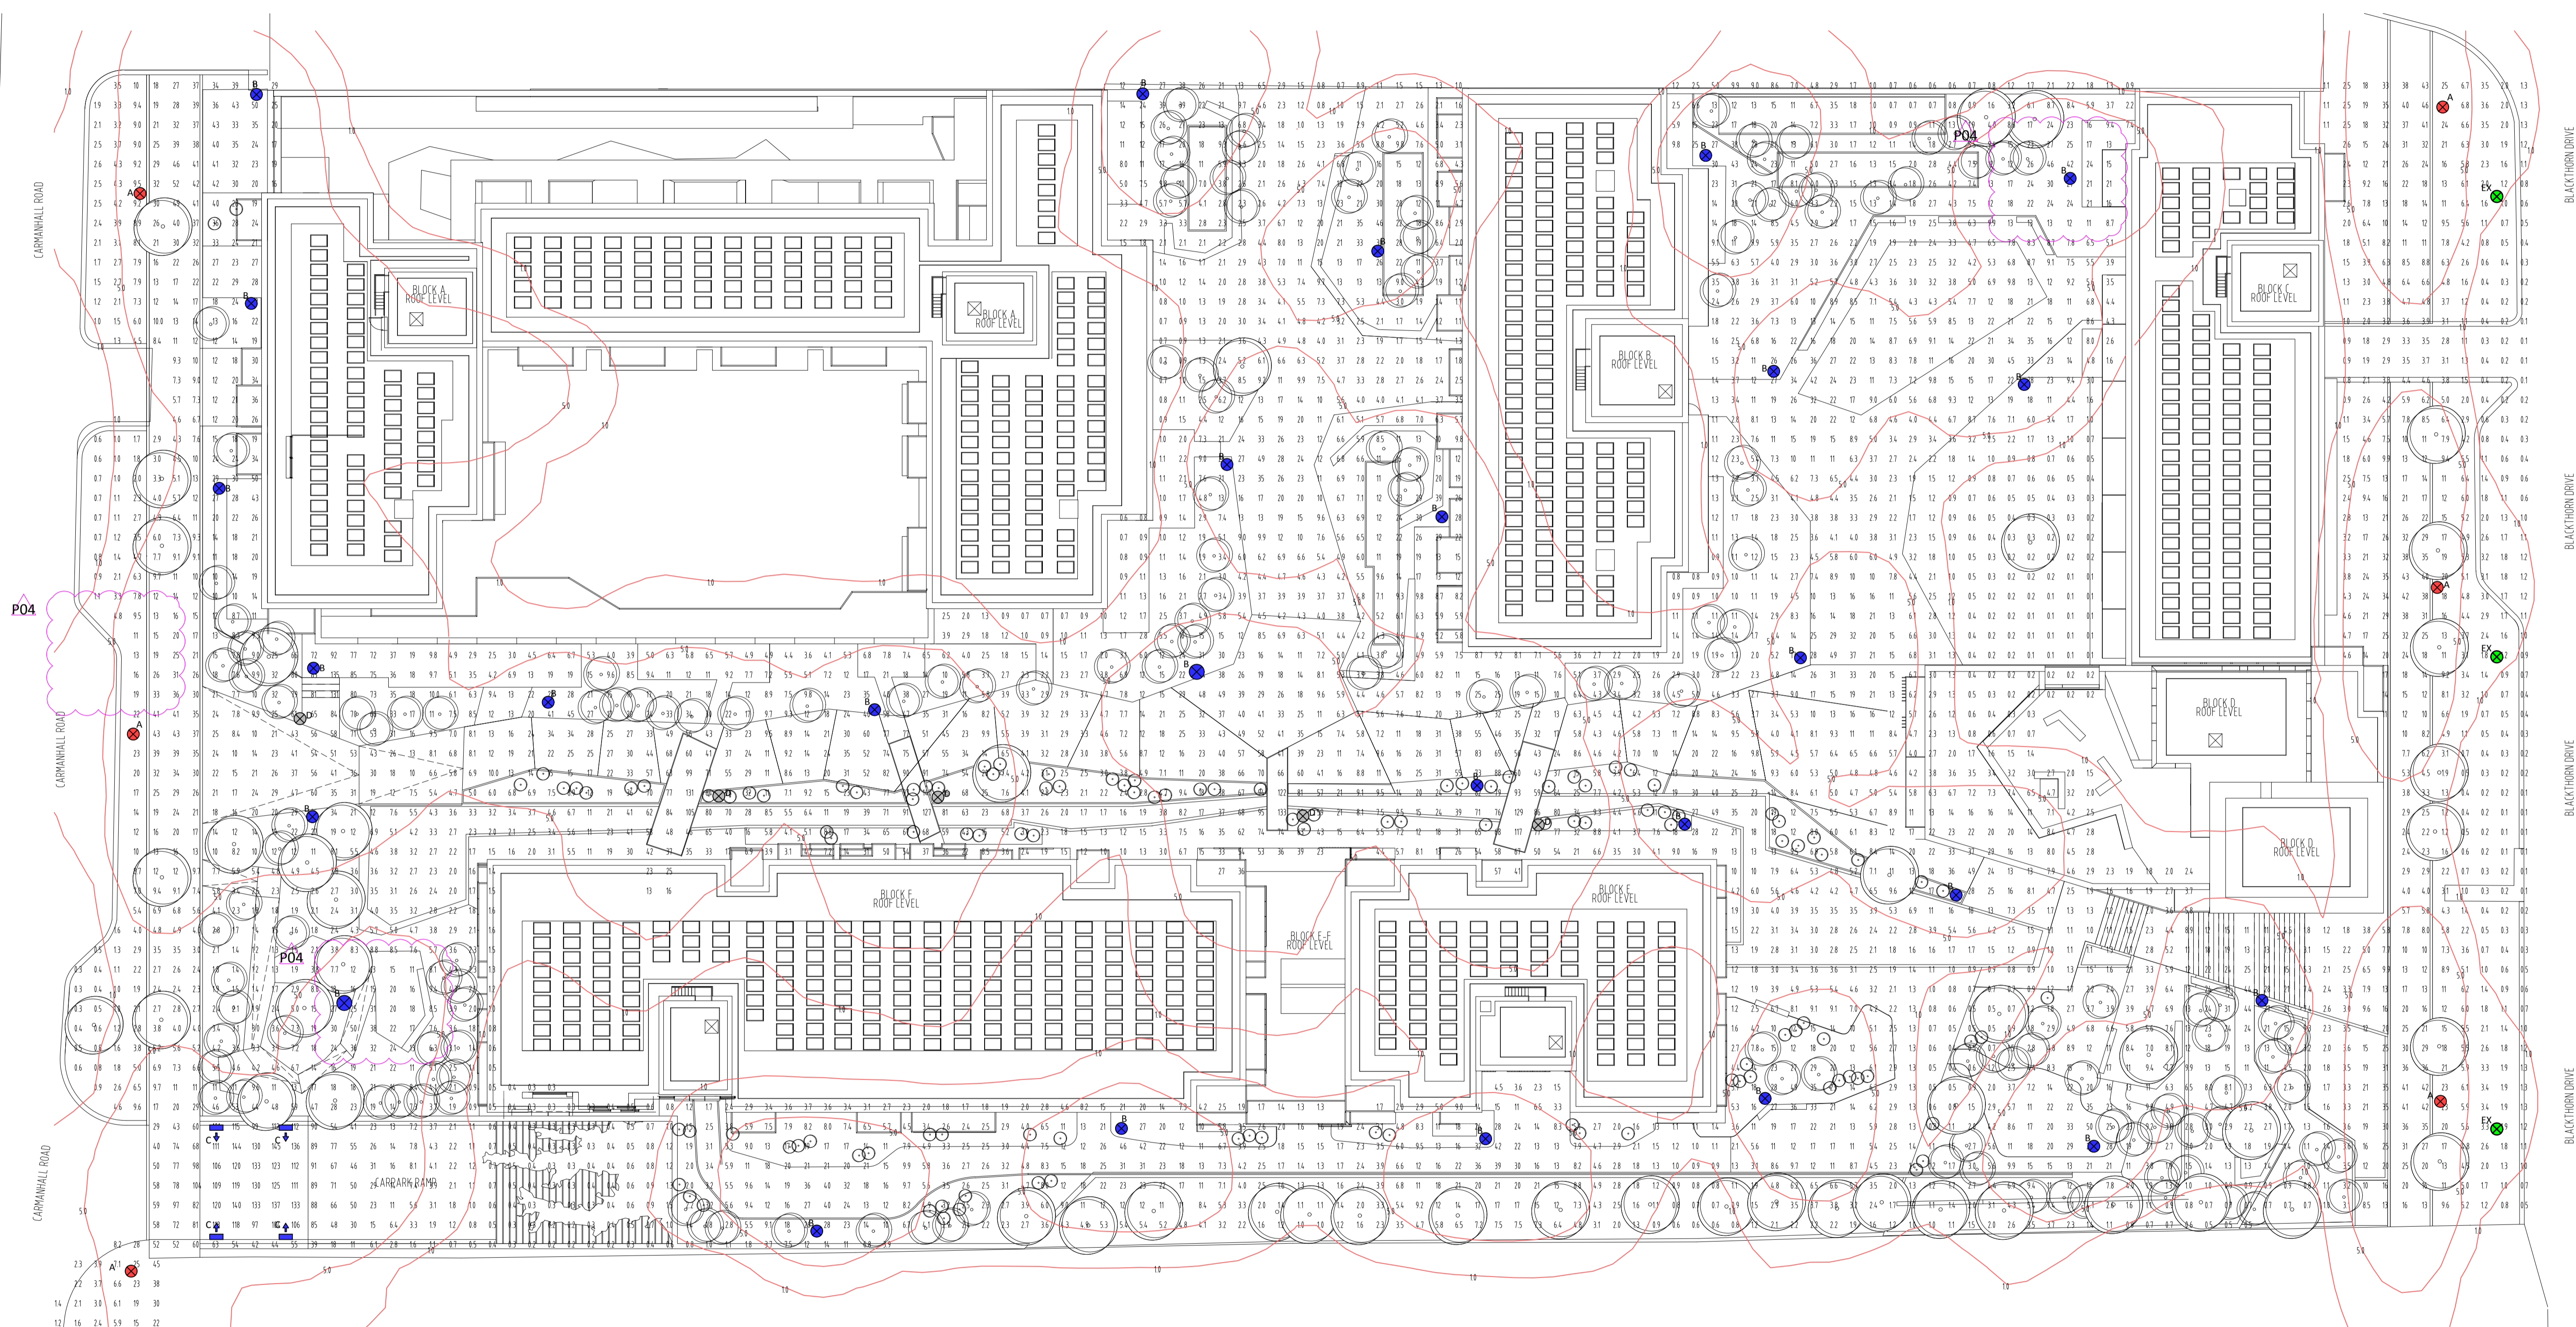

- FOR SETTING OUT REFER TO ARCHITECT'S DRAWINGS.
- THIS DRAWING TO BE READ IN CONJUNCTION WITH ALL OTHER ARCHITECTURAL AND ENGINEERING DRAWINGS AND ALL OTHER RELEVANT DRAWINGS AND SPECIFICATIONS.
- DO NOT SCALE THIS DRAWING. USE FIGURED DIMENSIONS ONLY.
- NO PART OF THIS DOCUMENT MAY BE REPRODUCED OR TRANSMITTED IN ANY FORM OR STORED IN ANY RETRIEVAL SYSTEM OF ANY NATURE WITHOUT THE WRITTEN PERMISSION OF O'CONNOR SUTTON CRONIN AS COPYRIGHT HOLDER EXCEPT AS AGREED FOR USE ON THE PROJECT FOR WHICH THE DOCUMENT WAS ORIGINALLY ISSUED.

Rev No.	Date	Revision Note	Drn by	Chkd by
P01	05.07.19	ISSUED FOR PLANNING.	B.M.	M.F.
P02	10.10.19	RE-ISSUED FOR PLANNING.	S.R.	M.F.
P03	08.11.19	EXISTING PUBLIC LIGHTING ADDED	J.S.	M.F.
P04	12.11.19	REVISIONS AS CLOUDED.	N.O.C.	M.F.

Rev No.	Date	Revision Note	Drn by	Chkd by



Head Office,
9 Prussia Street,
Dublin 7,
D07 KT57

TEL +353 (0)1 8682000

e: contactus@ocsc.ie
w: www.ocsc.ie

Dublin | London | Belfast | Galway | Cork



OCSC
O'CONNOR | SUTTON | CRONIN
Multidisciplinary
Consulting Engineers

Client: SANDYFORD GP LIMITED
Project: SANDYFORD CENTRAL, CARMANHALL ROAD, SANDYFORD BUSINESS DISTRICT, DUBLIN 18
Title: ELECTRICAL PROPOSED SITE LIGHTING LAYOUT

Code | Originator | Zone | Level | Type | Role | Number | Status | Revision
R478 | OCSC | XX | XX | DR | E | 0001 | S8 | P04
Date: 10.10.19 Scale: 1:250 @ A1 Drn by: S.R. Chkd by: M.F. Aprvd by: B.R.