



KEYPLAN

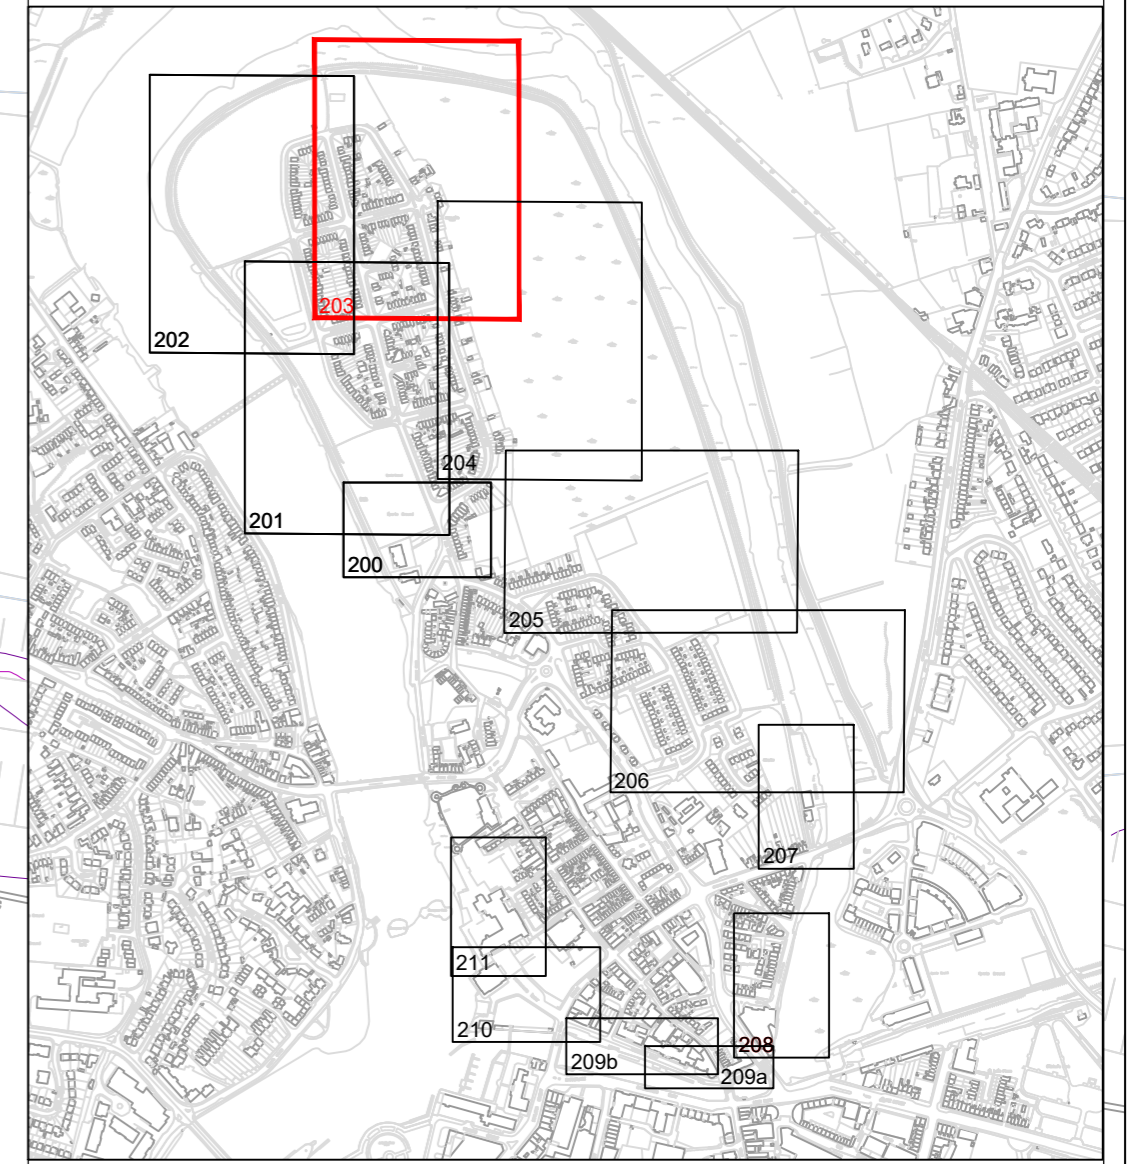

LEGEND

- EXISTING STORM MANHOLE
- EXISTING FOUL MANHOLE
- PROPOSED STORM MANHOLE
- PROPOSED FOUL MANHOLE
- IC
- EXISTING STORM SEWER
- EXISTING FOUL SEWER
- - - REDUNDANT SEWER
- - - EXISTING STORM SEWER TO BE REMOVED
- - - EXISTING FOUL SEWER TO BE REMOVED
- - - PROPOSED STORM SEWER
- - - PROPOSED FOUL SEWER
- - - PROPOSED FILTER DRAIN
- + + + PROPOSED ACO CHANNEL
- . - . PROPOSED FOUL RISING MAIN
- SURFACE CHANNEL/SWALE

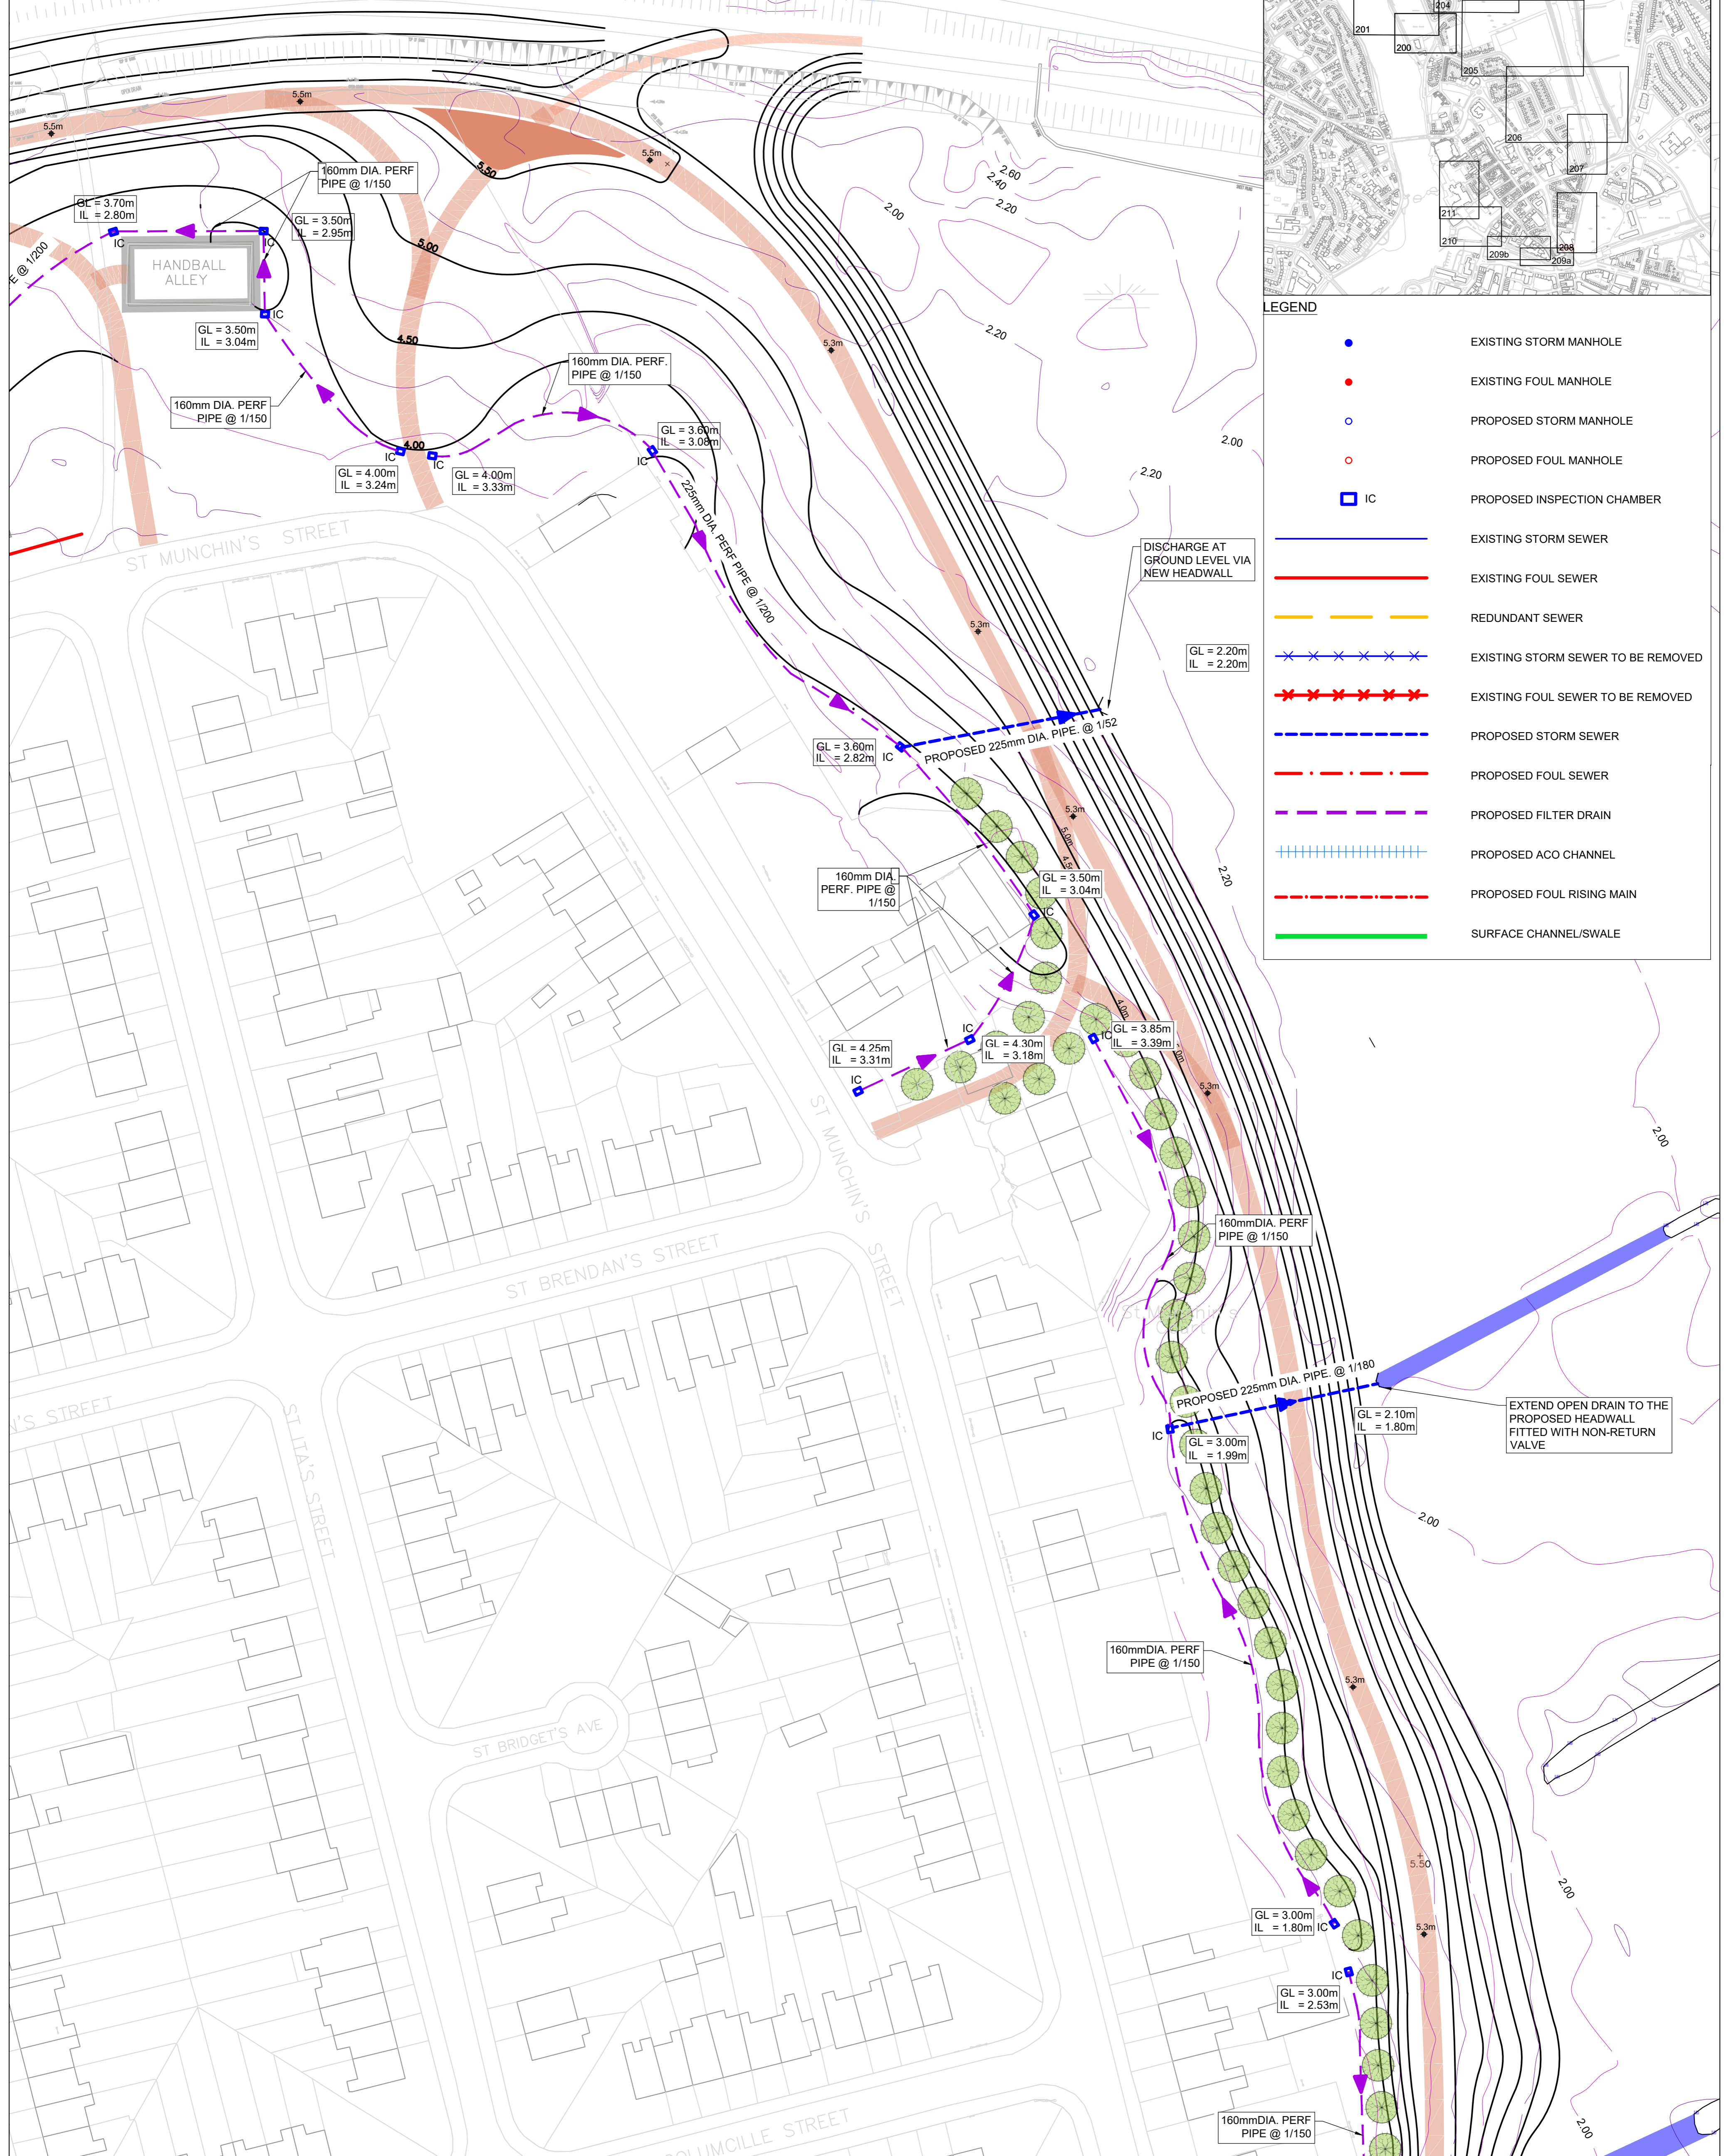

Nicholas de Jong Associates
URBAN DESIGN

Issue	Date	By	Chkd	Appd

Client

Job Title

Scale at A1 1:500

Discipline Infrastructure



Arup, 50 Ringsend Road
Dublin, D04 T6X0
Tel +353(0)1 233 4455 Fax +353(0)1 668 3169
www.arup.ie

Drawing Title

Proposed Drainage Layout
Sheet 4 of 12

Job No 265545

Drawing Status **PLANNING**

Drawing No KIFRS-C-203

Issue **PL1**