


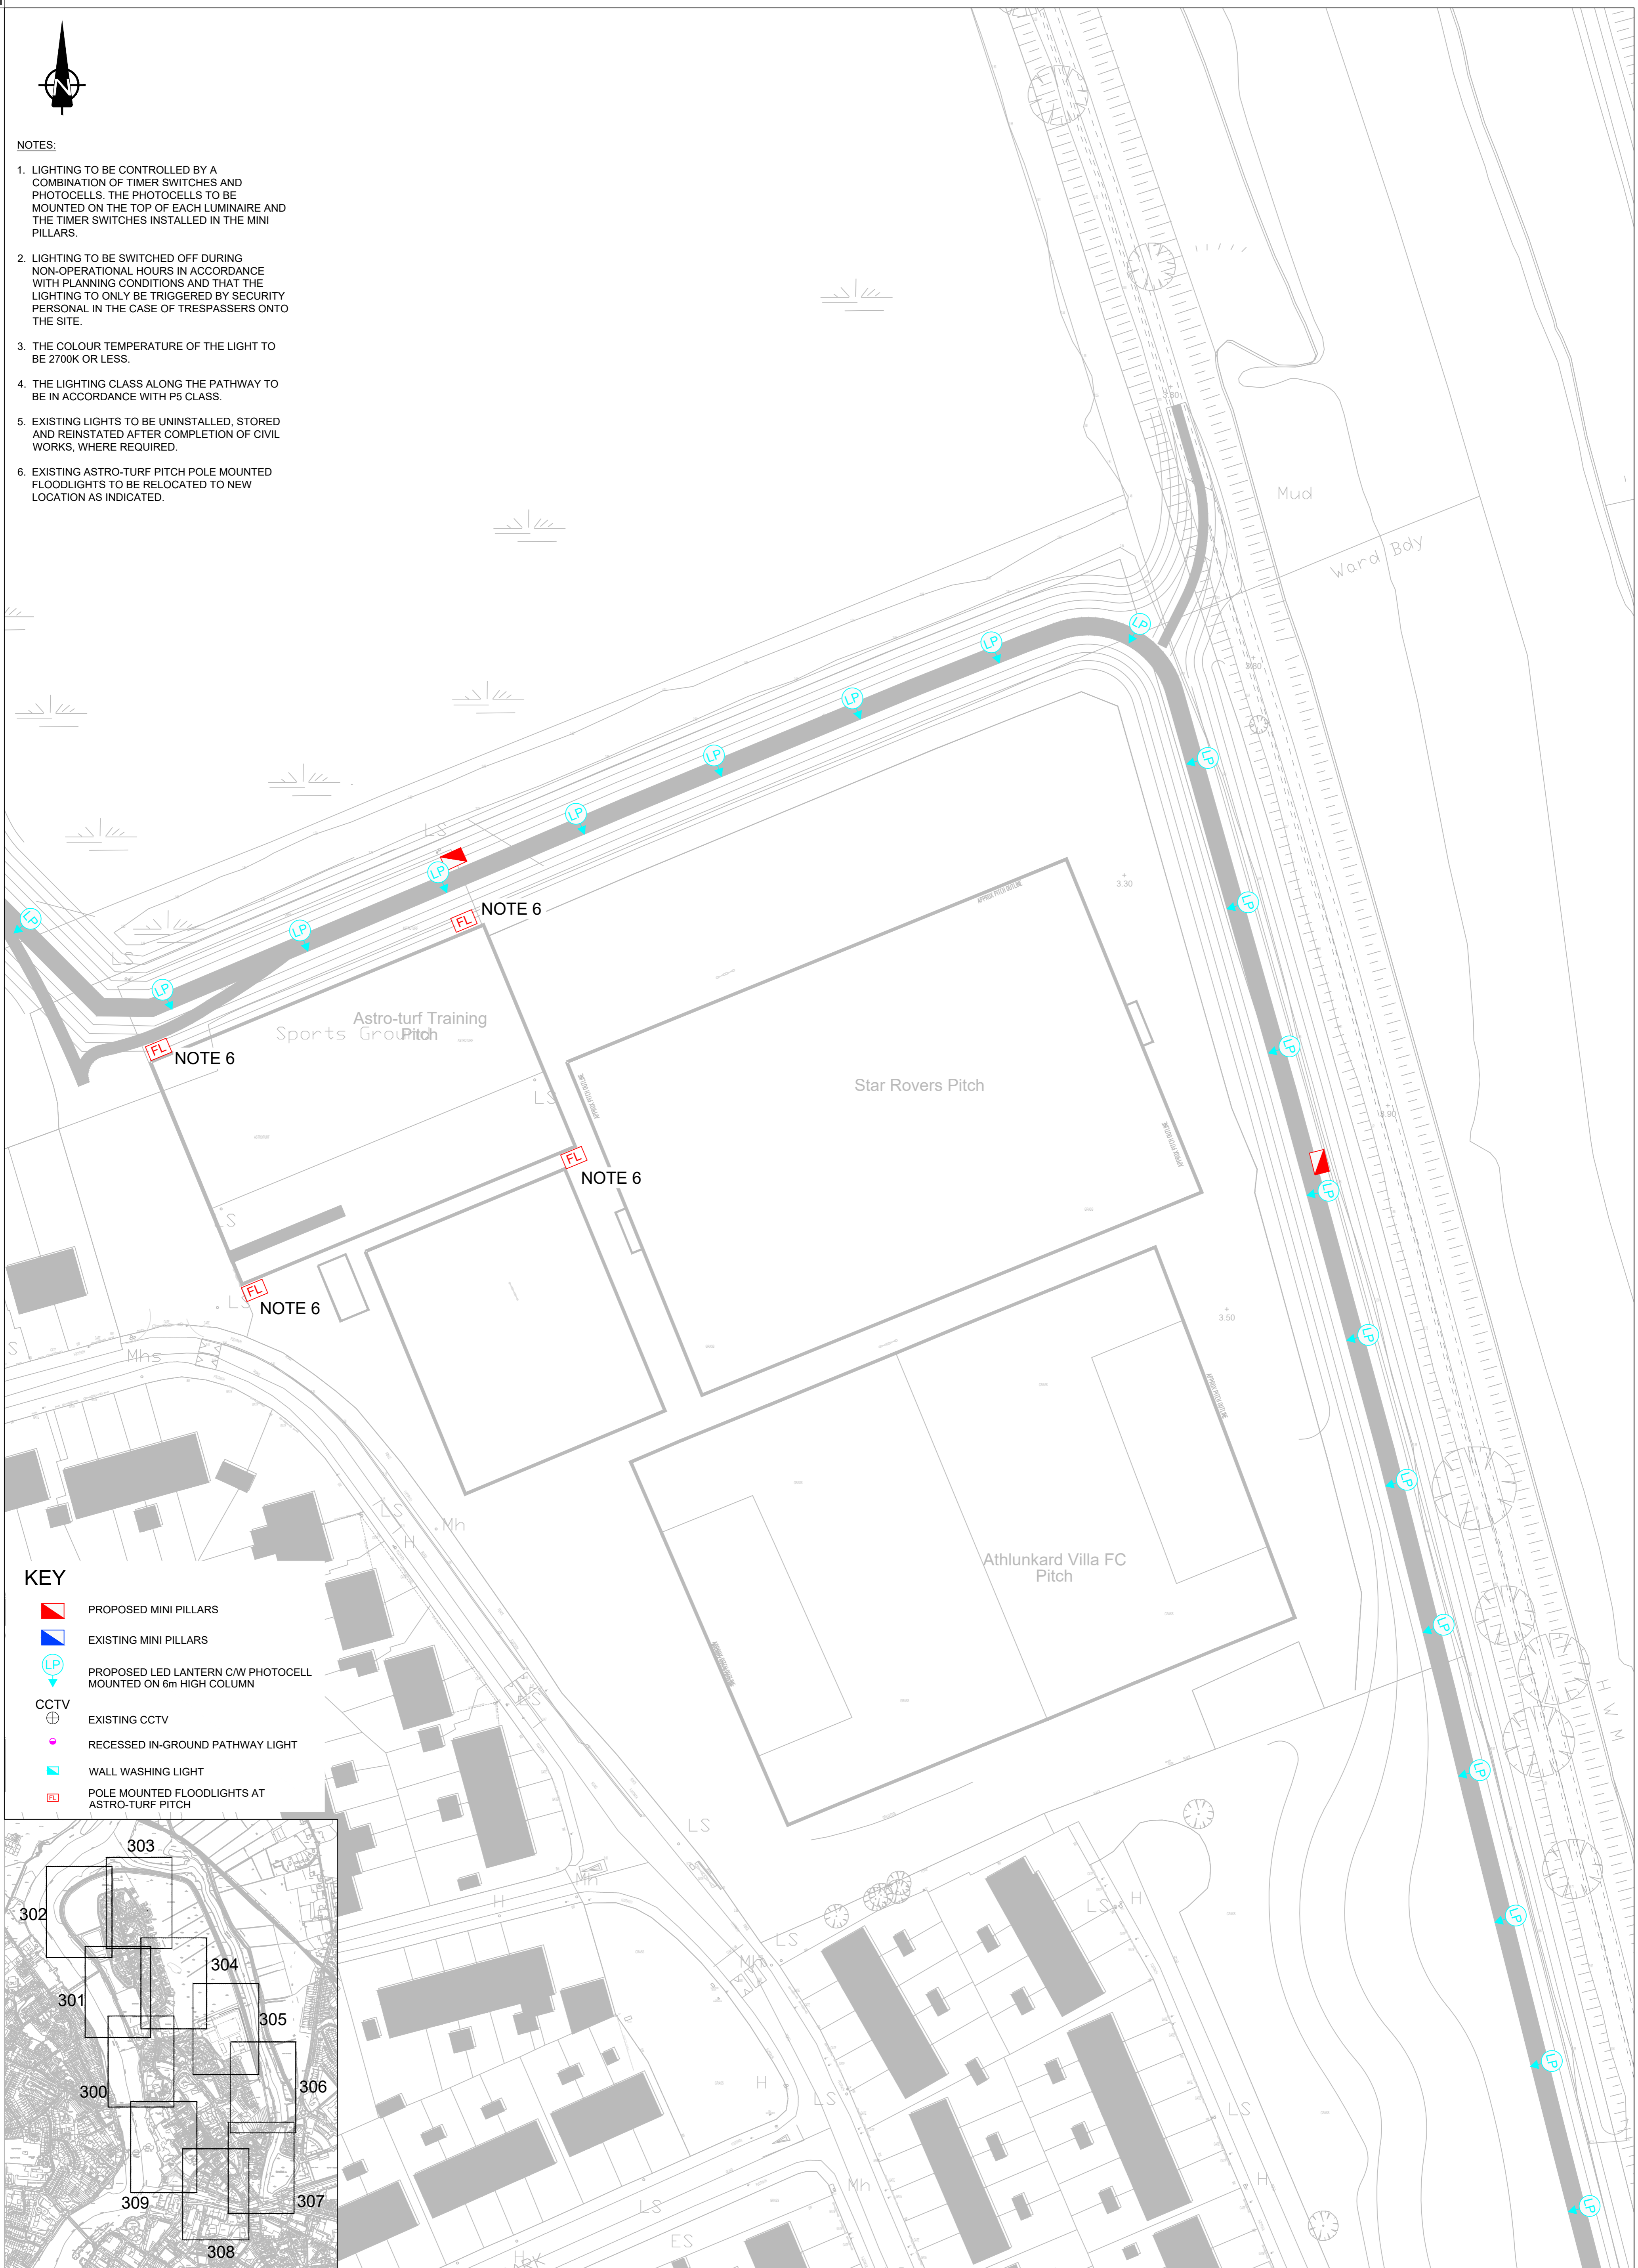


NOTES:

1. LIGHTING TO BE CONTROLLED BY A COMBINATION OF TIMER SWITCHES AND PHOTOCELLS. THE PHOTOCELLS TO BE MOUNTED ON THE TOP OF EACH LUMINAIRE AND THE TIMER SWITCHES INSTALLED IN THE MINI PILLARS.
2. LIGHTING TO BE SWITCHED OFF DURING NON-OPERATIONAL HOURS IN ACCORDANCE WITH PLANNING CONDITIONS AND THAT THE LIGHTING TO ONLY BE TRIGGERED BY SECURITY PERSONAL IN THE CASE OF TRESPASSERS ONTO THE SITE.
3. THE COLOUR TEMPERATURE OF THE LIGHT TO BE 2700K OR LESS.
4. THE LIGHTING CLASS ALONG THE PATHWAY TO BE IN ACCORDANCE WITH P5 CLASS.
5. EXISTING LIGHTS TO BE UNINSTALLED, STORED AND REINSTATED AFTER COMPLETION OF CIVIL WORKS, WHERE REQUIRED.
6. EXISTING ASTRO-TURF PITCH POLE MOUNTED FLOODLIGHTS TO BE RELOCATED TO NEW LOCATION AS INDICATED.



KEY

- PROPOSED MINI PILLARS
- EXISTING MINI PILLARS
- PROPOSED LED LANTERN C/W PHOTOCELL MOUNTED ON 6m HIGH COLUMN
- EXISTING CCTV
- RECESSED IN-GROUND PATHWAY LIGHT
- WALL WASHING LIGHT
- POLE MOUNTED FLOODLIGHTS AT ASTRO-TURF PITCH

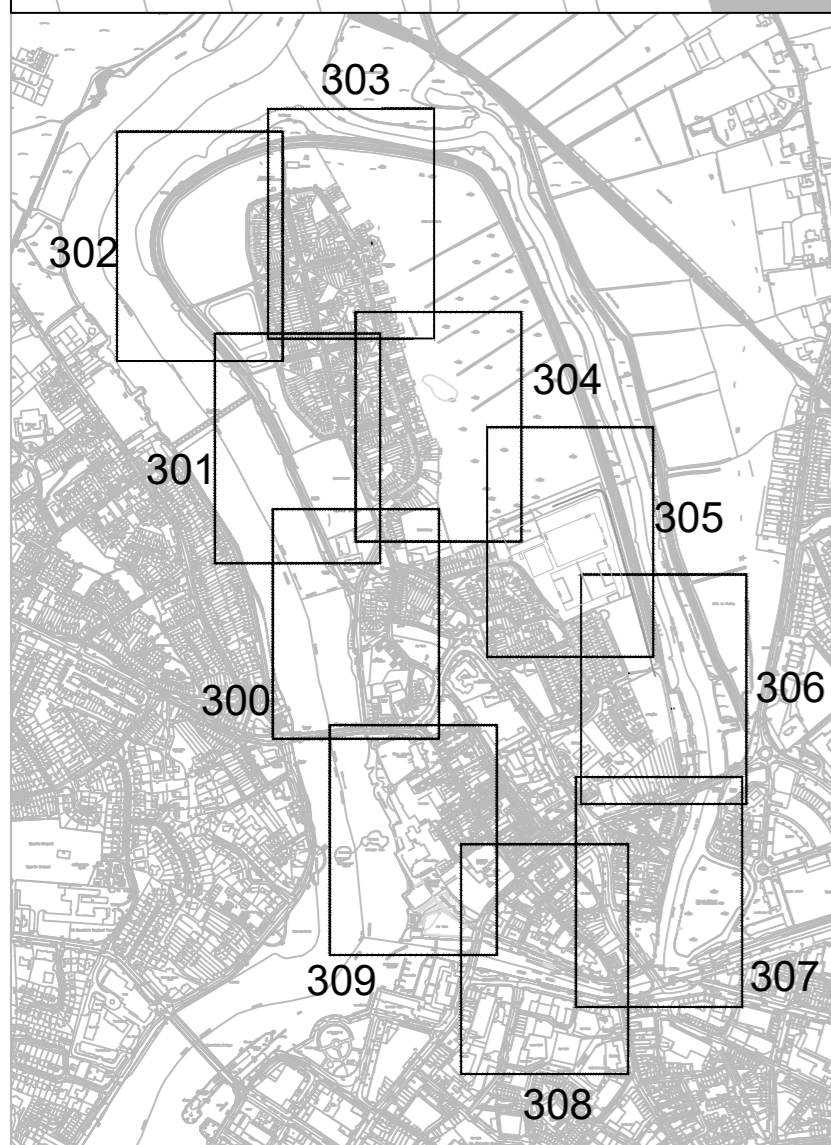

JBA consulting
 Nicholas de Jong Associates
 URBAN DESIGN

PL1	19/12/19	JT	KC	VA
Issue	Date	By	Chkd	Appd

Client
 Comhairle Cathrach & Contae Luimnigh
 Limerick City & County Council
 OPW Óifig na n-Obrechtaí Poiblí / Office of Public Works

Job Title
KING'S ISLAND
 FLOOD RELIEF SCHEME
 Scale at A1 1:500
 Discipline Infrastructure

ARUP
 Arup, 50 Ringsend Road
 Dublin, D04 T6X0
 Tel +353(0)1 233 4455 Fax +353(0)1 668 3169
 www.arup.ie

Drawing Title
 KIFRS Public Lighting Layout
 Sheet 6 of 10
 Area A5
 Job No **KIFRS** Drawing Status **Planning**
 Drawing No **KIFRS-E-305** Issue **PL1**