


**1 proposed GIS building ground floor plans -overall plan**  
scale 1 : 200

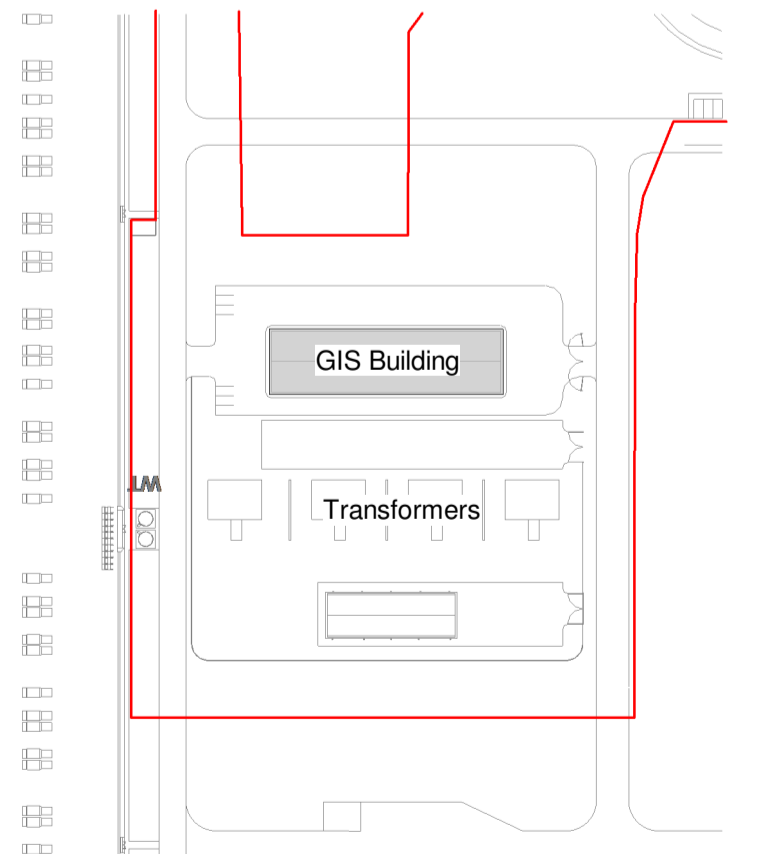

**KEYPLAN**  
N.T.S.

**NOTES:**  
Check all dimensions on site. Do not rely on scaled dimensions. This drawing must be read in conjunction with all relevant contract documents.  
This drawing is the property of Michael Collins Associates Ltd. (trading as MCA Architects). The drawing shall not be copied, reproduced or otherwise used without the consent of Michael Collins Associates Ltd.

- LEGEND:**
- 49kVA CABLE ROUTE
  - PERMITTED DEVELOPMENT UNDER PLANNING APPLICATION Reg. Ref.: FW17A/0025

Rev	Date	Description	Dm	Chkd	GO
P12	01.20	For Submission			

Architecture + Interior Design + Masterplanning + Project Management

**MCA ARCHITECTS**  
4 Harover Wharf, Riggall Road, Dublin 2, Ireland.  
+353 1 6760916  
info@mca.ie  
www.mca.ie

Client: CRUISERATH 220kV SUB STATION & TRANSMISSION LINE  
Job No: 2018.62  
Drawing: PROPOSED GIS BUILDING GROUND FLOOR PLANS - OVERALL PLAN  
Sheet: A1  
Scale: 1:200  
Stage: PLANNING  
Status: FOR SUBMISSION  
Status Code: S5  
Drawing Number: STS-MCA-PL-ZZ-DR-A-1011

REVISION:  
P12