


**1 proposed GIS building first floor plans - overall plan**  
scale 1 : 200

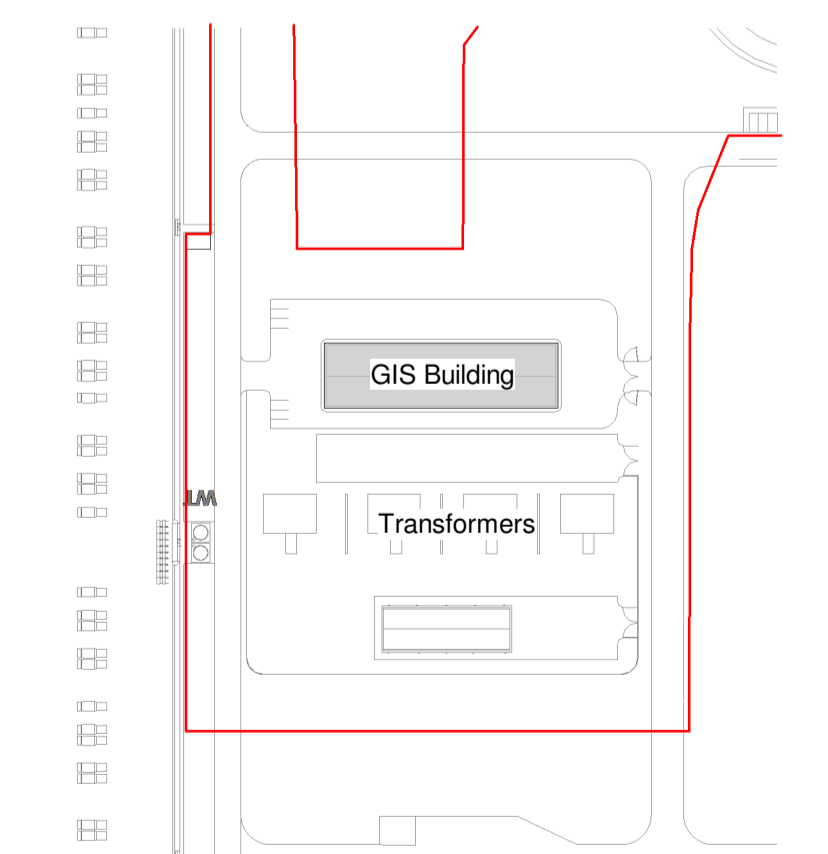

**KEYPLAN**  
N.T.S.

**NOTES:**  
Check all dimensions on site. Do not rely on scaled dimensions. This drawing must be read in conjunction with all relevant contract documents.  
This drawing is the property of Michael Collins Associates Ltd. (trading as MCA Architects). The drawing shall not be copied, reproduced or otherwise used without the consent of Michael Collins Associates Ltd.

**LEGEND:**  
[Hatched Box] PERMITTED DEVELOPMENT UNDER PLANNING APPLICATION Reg. Ref.: FW17A/0025

Rev	Date	Description	Dm	Chkd
P09	01.20	For Submission	ML	GO

Architecture + Interior Design + Masterplanning + Project Management

**MCA ARCHITECTS**

4 Harcourt Wharf, Riggall Road, Dublin 2, Ireland  
+353 1 6760916  
info@mca.ie  
www.mca.ie

Client:	CRUISERATH 220kV SUB STATION & TRANSMISSION LINE	Job No:	2018.62
Drawing:	PROPOSED GIS FIRST FLOOR PLAN - ELECTRICAL COMPOUND	Sheet:	A1
Stage:	PLANNING	Scale:	1:200
Status:	FOR SUBMISSION	Status Code:	S5
Drawing Number:	STS-MCA-PL-ZZ-DR-A-1012		

REVISION:  
P09