



Notes :


1. All drawings are to be read in conjunction with all relevant Specifications, Bills of Quantities, Architectural, Services and Engineering drawings.
2. Any discrepancies between these documents shall be brought to the attention of the Engineer.
3. All dimensions are in millimetres, unless noted otherwise.
4. All levels are in metres related to Ordnance Datum.
5. Drawings are not to be scaled.

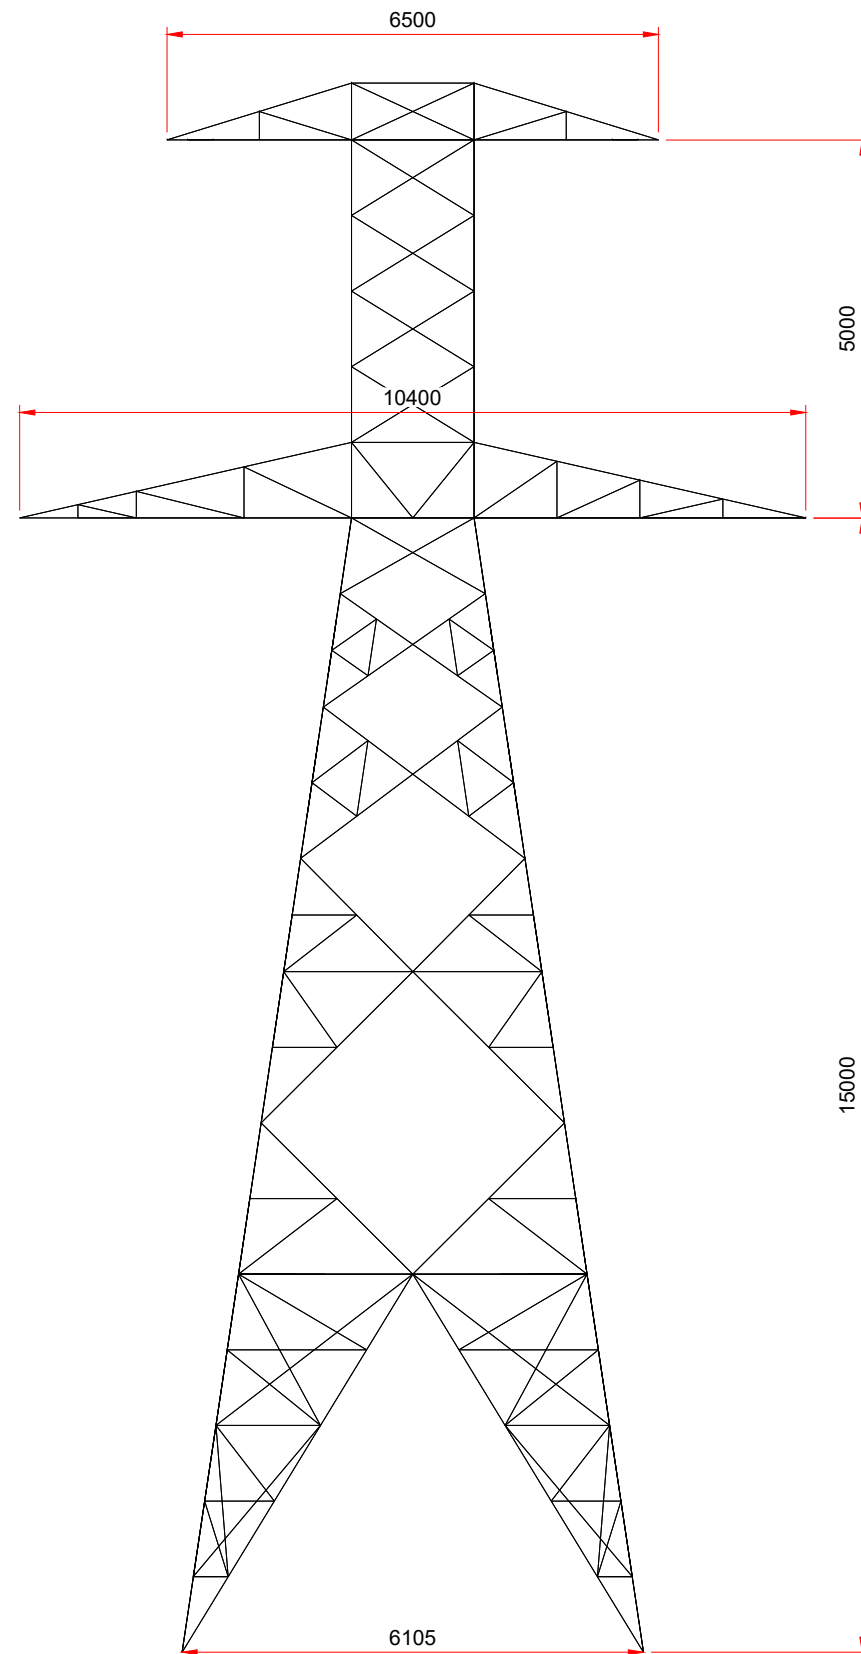

FRONT ELEVATION SCALE: 1:100

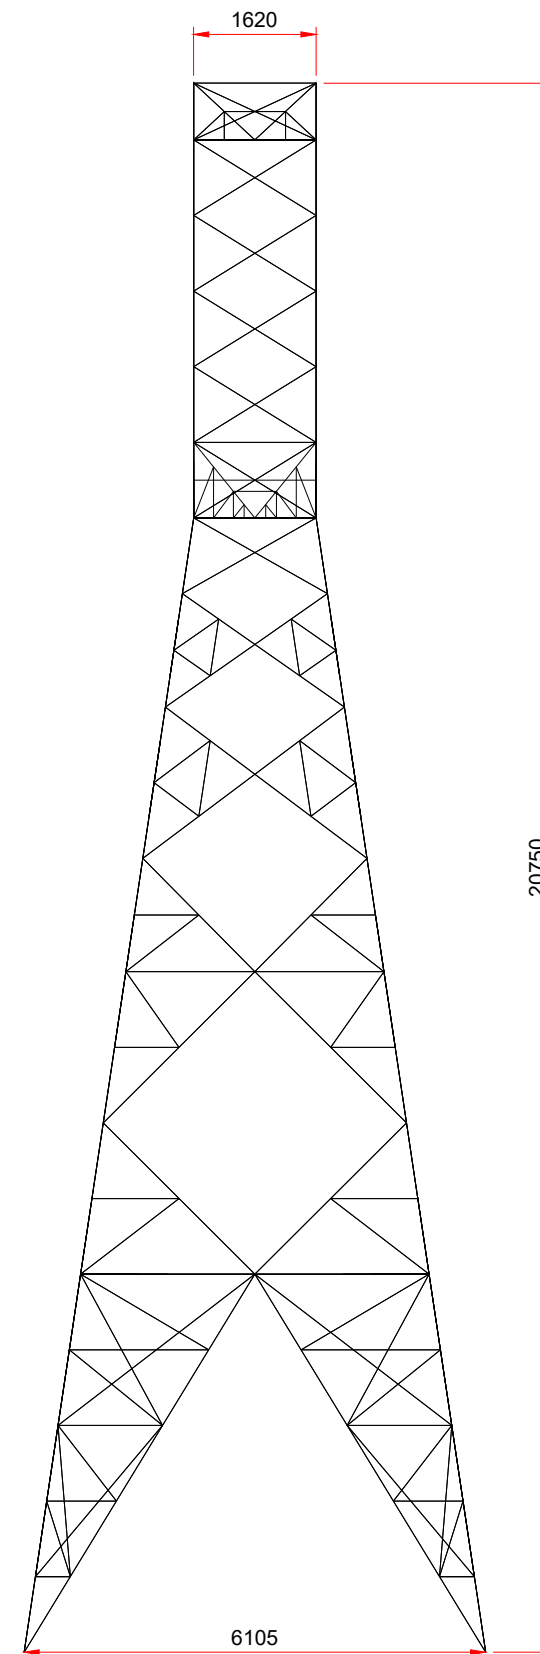

SIDE ELEVATION SCALE: 1:100

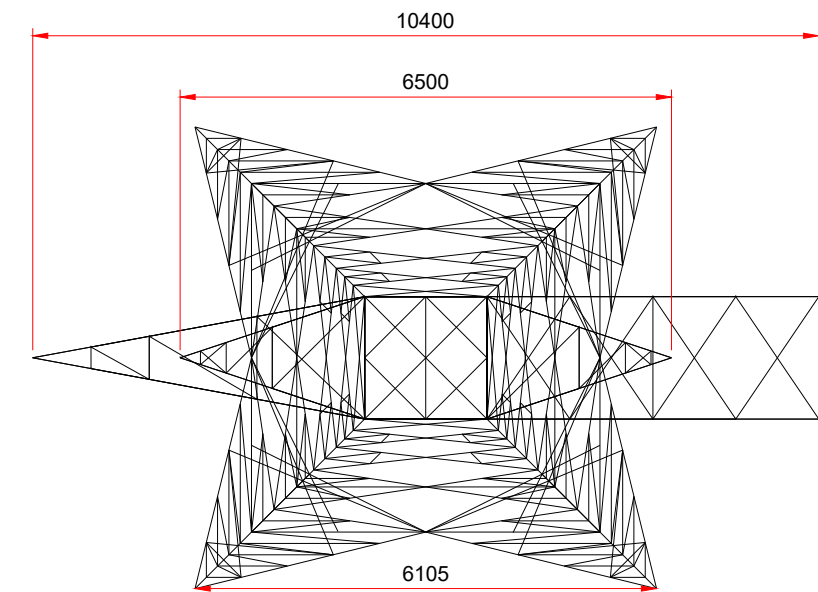

PLAN VIEW SCALE: 1:100



Malachy Walsh and Partners

Engineering and Environmental Consultants

Cork | Tralee | London | Limerick



Reen Point, Blennerville, Tralee, Co. Kerry, V92 X2TK
Tel : +353 (0)66 7123404
E-mail : tralee@mwp.ie



REV	DATE	DESCRIPTION	BY	APP
A	23.01.2020	ISSUED FOR PLANNING	AS	JOL

CLIENT: 

PROJECT:	HARRISTOWN 110kV SUBSTATION
TITLE:	110kV OVERHEAD LINE TOWER

DRAWN: AS	CHECKED: DT	APPROVED: JOL
DATE: 23.04.2019	SCALE @ A3: 1:100	
PROJECT NUMBER: 20205	DRAWING STATUS:	
DRAWING NUMBER: 20205-MWP-SS-00-DR-C-5037	REV: A	