

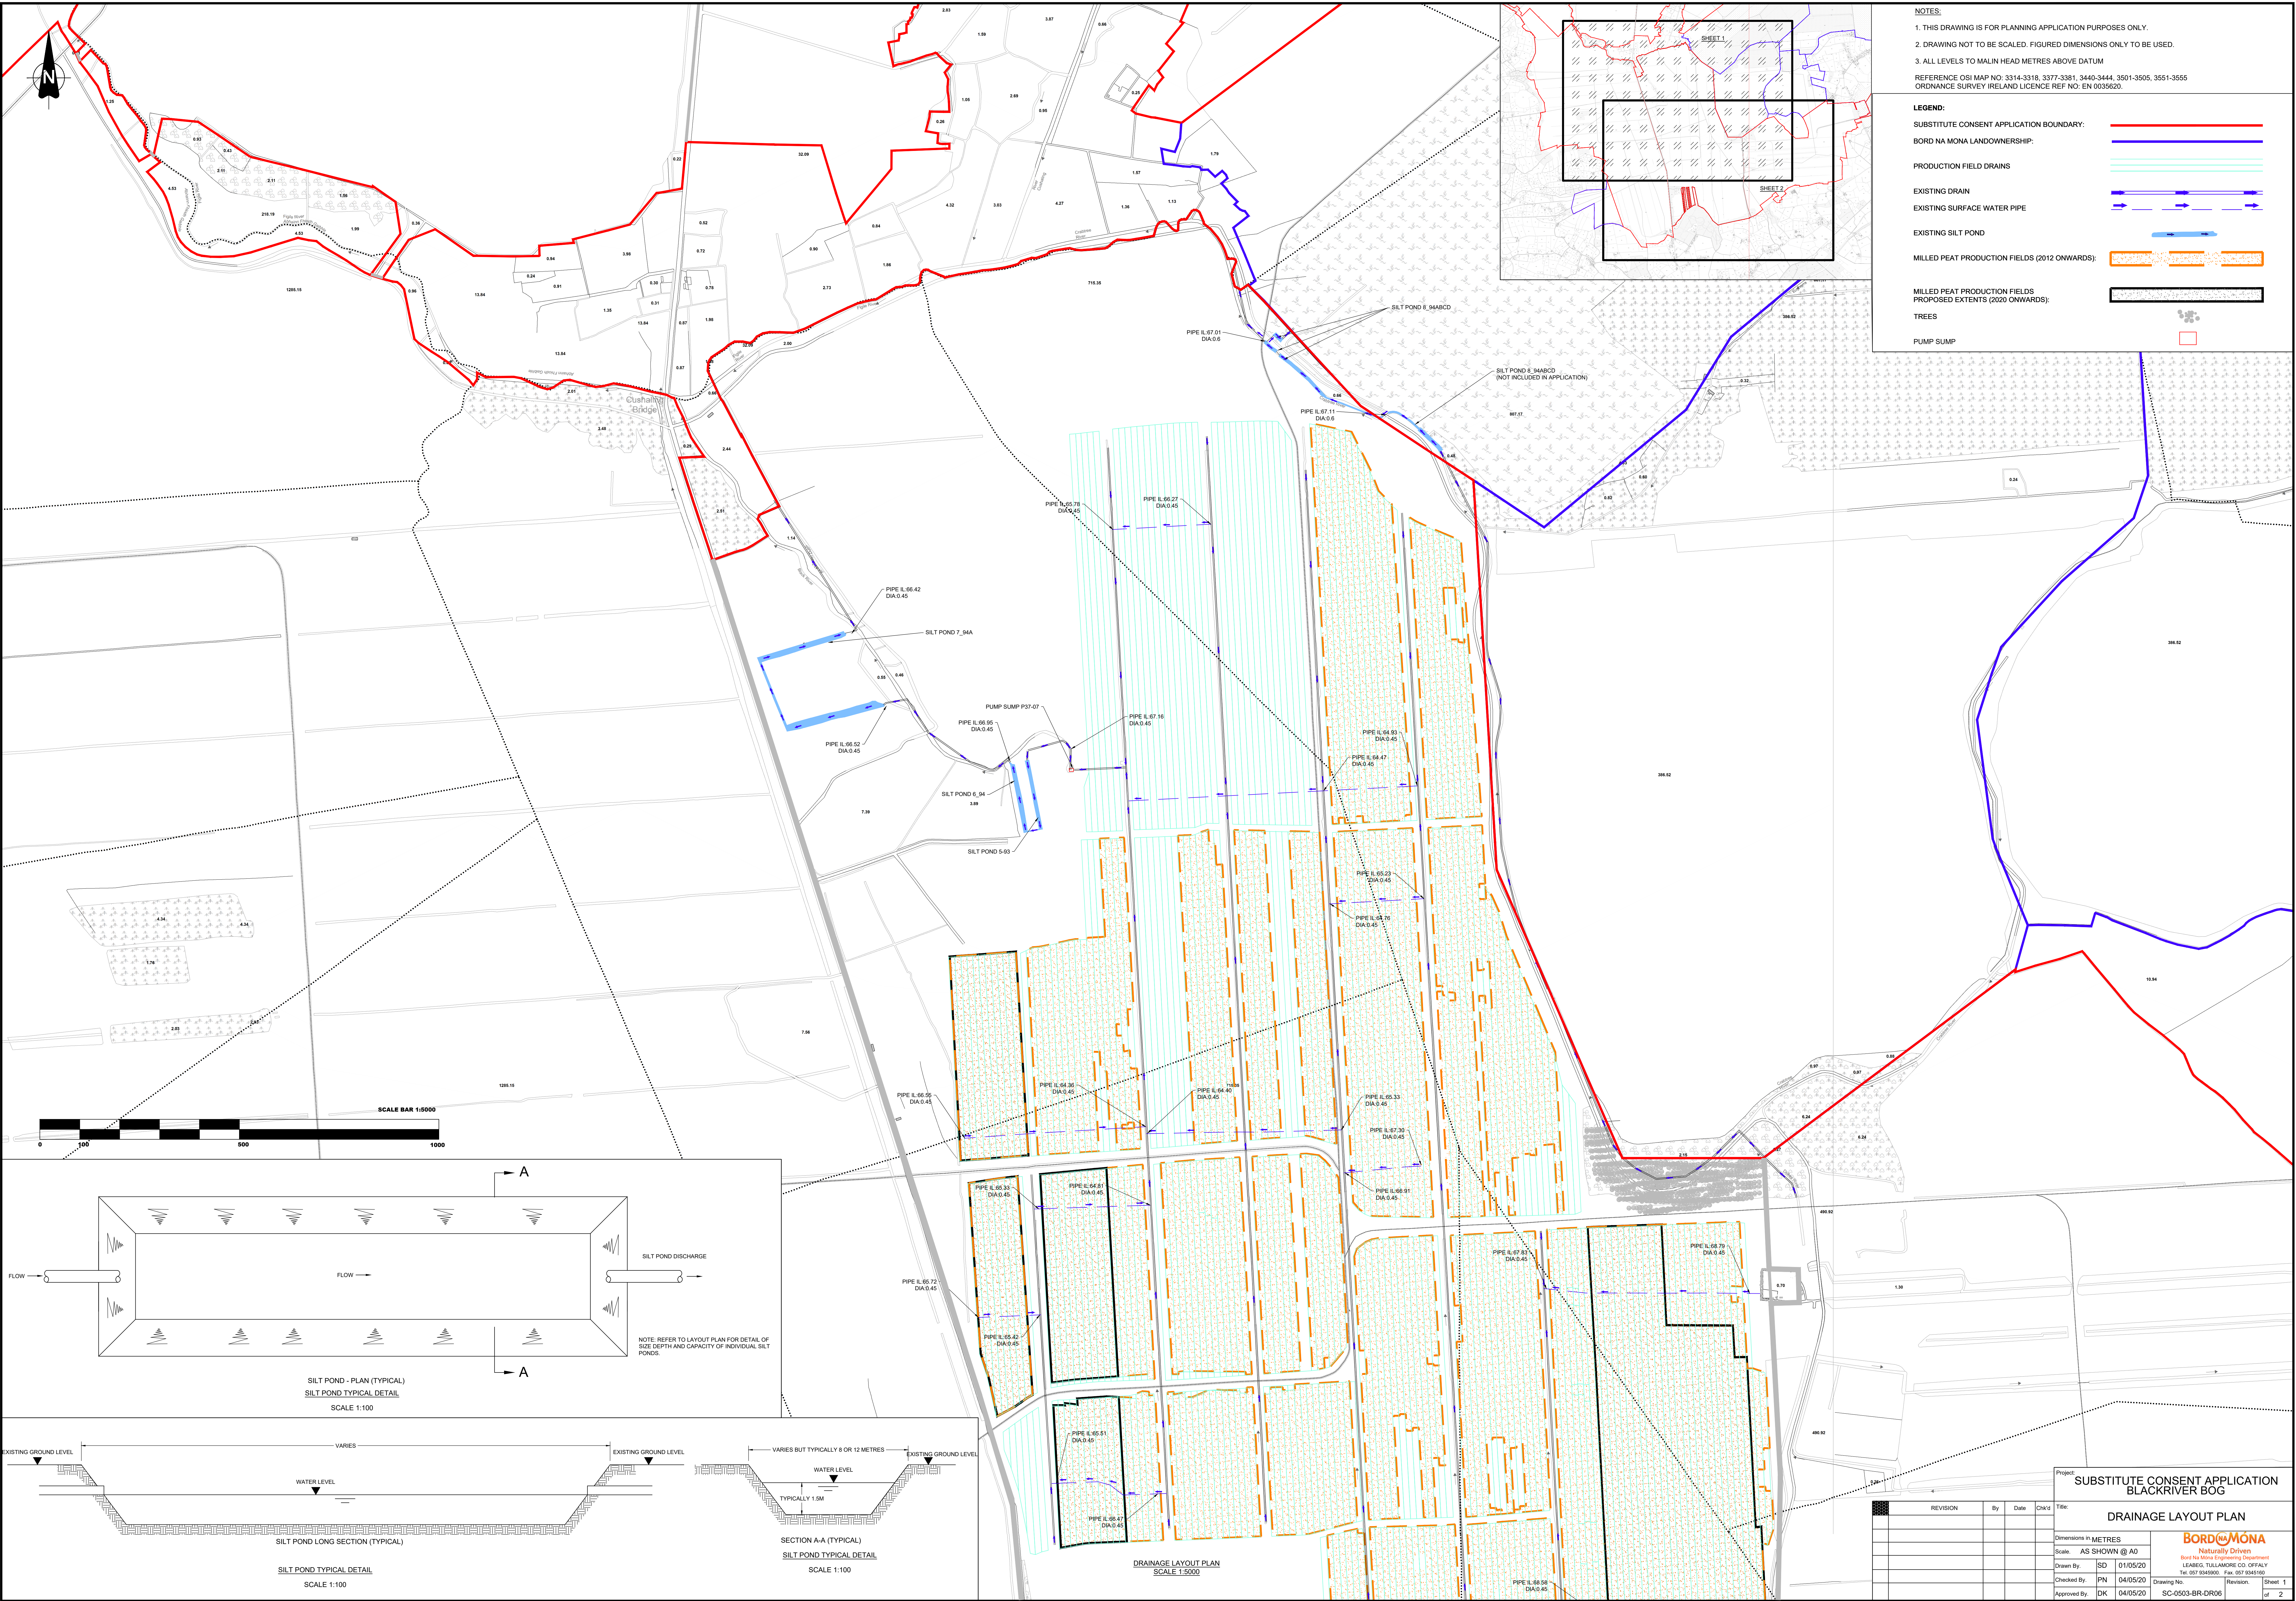
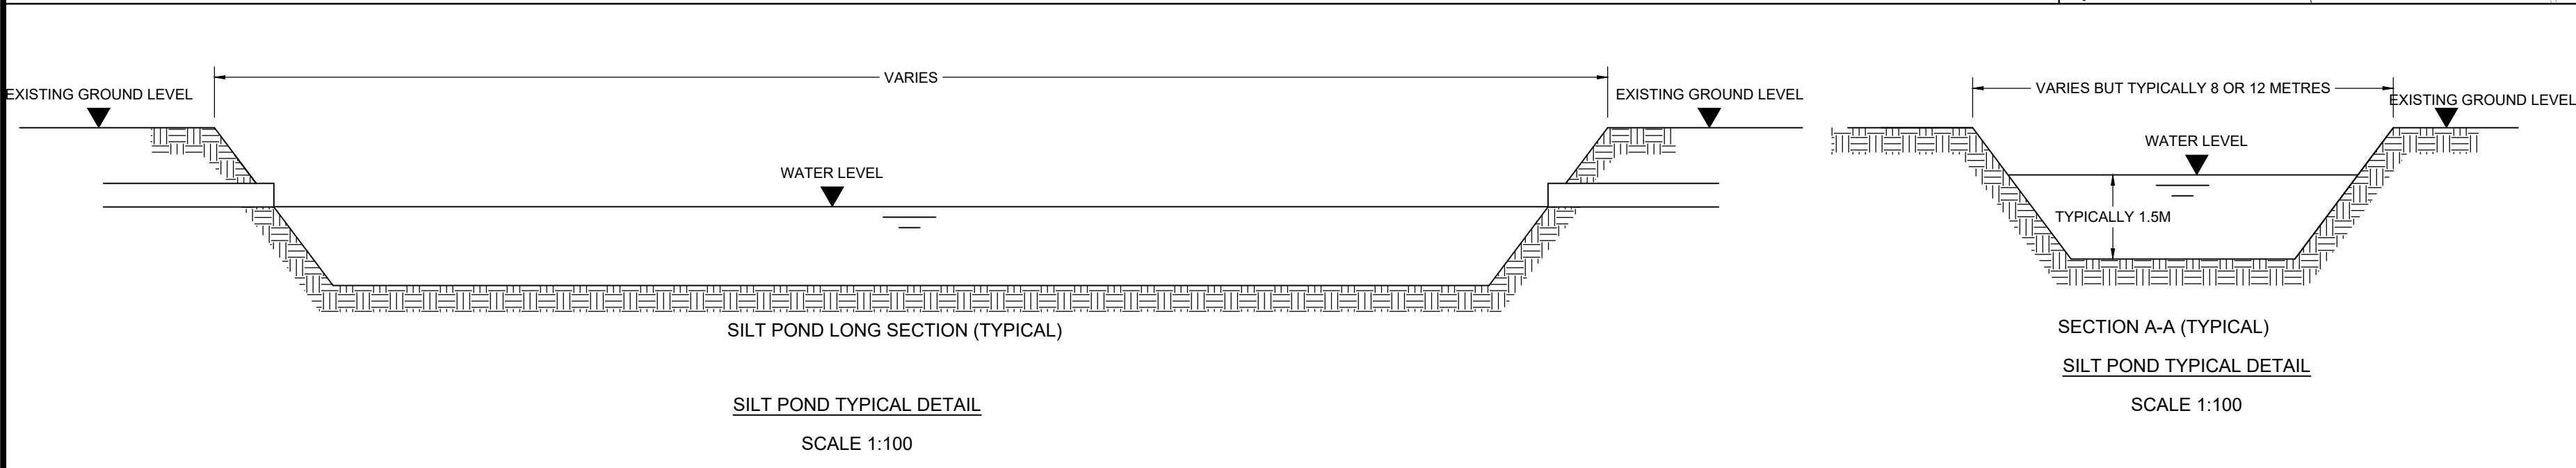
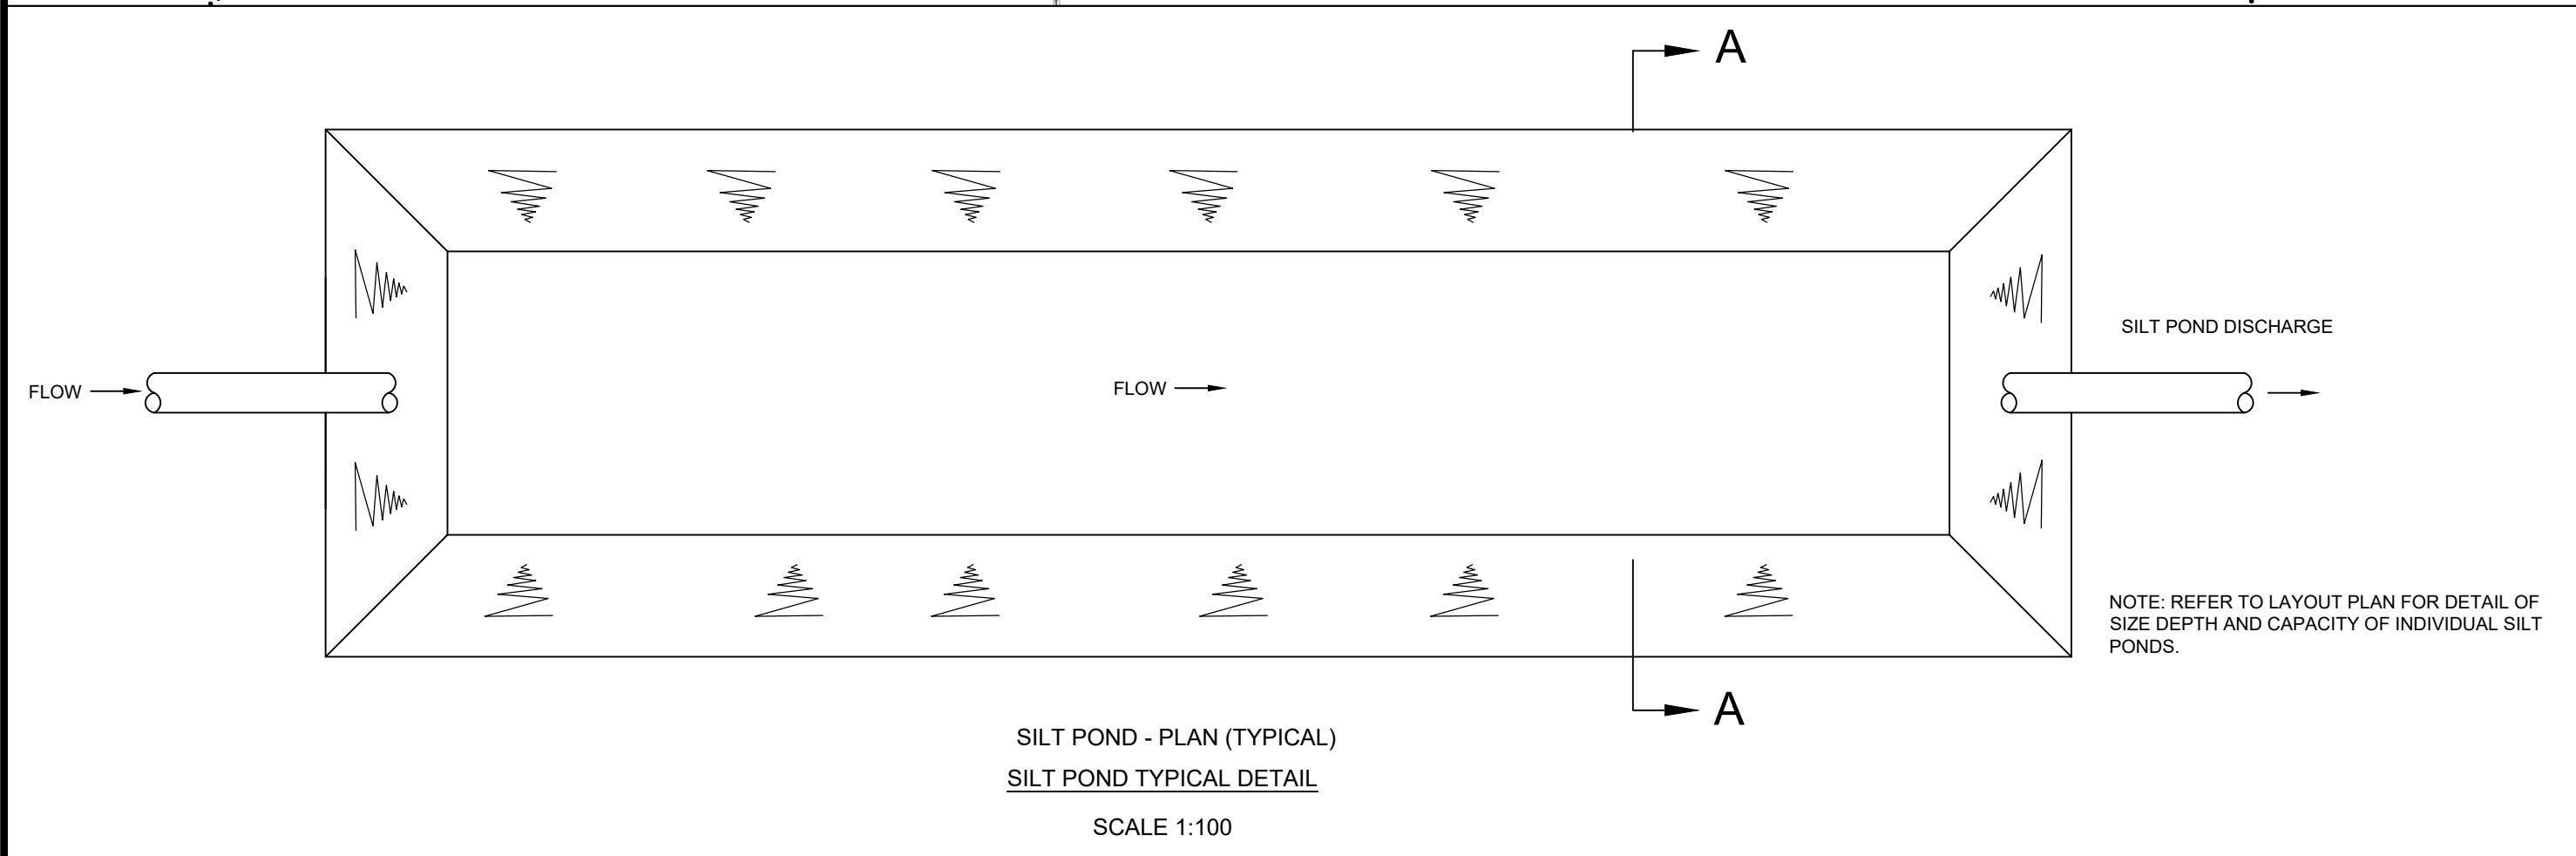


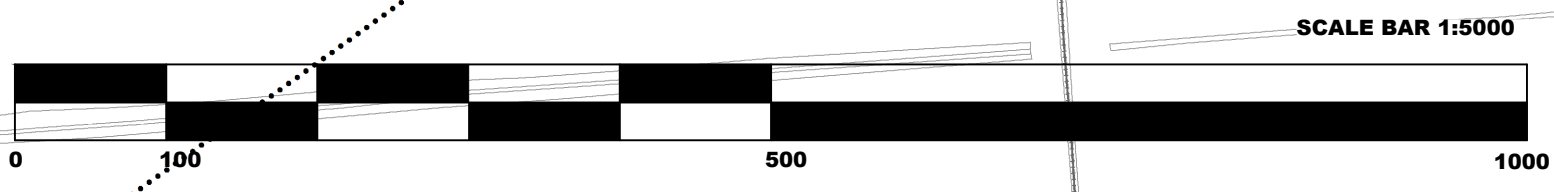

- NOTES:
1. THIS DRAWING IS FOR PLANNING APPLICATION PURPOSES ONLY.
 2. DRAWING NOT TO BE SCALED. FIGURED DIMENSIONS ONLY TO BE USED.
 3. ALL LEVELS TO MALIN HEAD METRES ABOVE DATUM
- REFERENCE OSI MAP NO: 3314-3318, 3377-3381, 3440-3444, 3501-3505, 3551-3555
ORDNANCE SURVEY IRELAND LICENCE REF NO: EN 0035620.

- LEGEND:
- SUBSTITUTE CONSENT APPLICATION BOUNDARY:
- BORD NA MONA LANDOWNERSHIP:
- PRODUCTION FIELD DRAINS:
- EXISTING DRAIN:
- EXISTING SURFACE WATER PIPE:
- EXISTING SILT POND:
- MILLED PEAT PRODUCTION FIELDS (2012 ONWARDS):
- MILLED PEAT PRODUCTION FIELDS PROPOSED EXTENTS (2020 ONWARDS):
- TREES:
- PUMP SUMP:

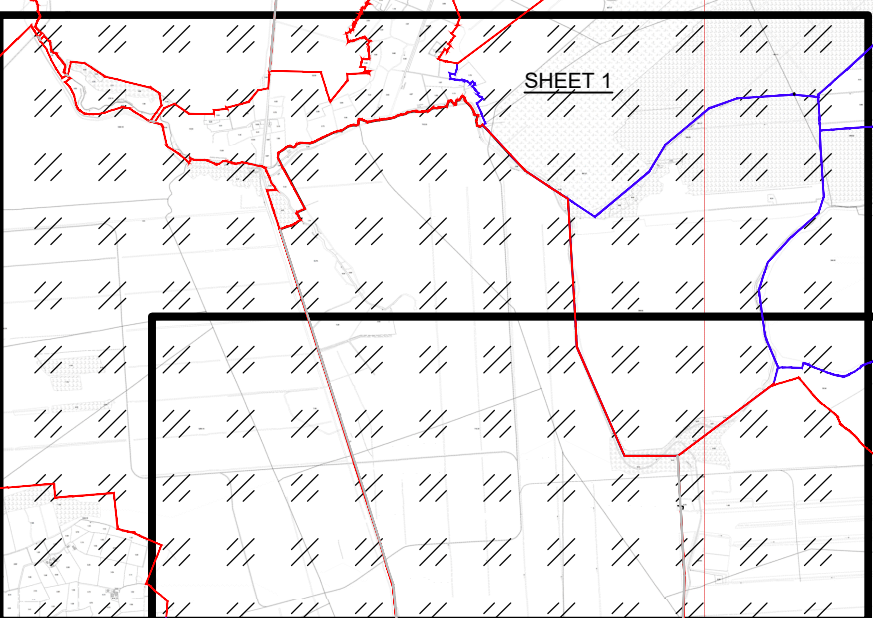

DRAINAGE LAYOUT PLAN

Project: SUBSTITUTE CONSENT APPLICATION BLACKRIVER BOG				
Revision: 1				
Title: DRAINAGE LAYOUT PLAN				
Dimensions in METRES				
Scale: AS SHOWN @ A0				
Drawn By: SD 01/05/20				
Checked By: PN 04/05/20				
Approved By: DK 04/05/20				
Drawing No: SC-0503-BR-DR06				
Revision: Sheet 1 of 2				